


- 1 FIRE HOSE CABINET.
 2 FIRE HOSE CABINET (INSTALL ON UNISTRUT).
 3 4" STANDPIPE DOWN.
 4 4" STANDPIPE UP AND DOWN.
 5 2" DRAIN LINE UP AND DOWN.
 6 FLOW SWITCH.
 7 SUPERVISED VALVE.
 8 CAP FOR FUTURE CONNECTION.
 9 4" STANDPIPE UP TO 6TH FLOOR.
 10 TRANSPORTATION HAS 5TH LEVEL BETWEEN 4TH AND 6TH LEVELS. EXTEND 4" COMBINATION SPRINKLER RISER AND 2" DRAIN LINE AT STAIRWELLS A & B THRU 5TH LEVEL. PROVIDE TWO INCH VALVED CONNECTION WITH FLOW SWITCH AT STAIR A ONLY. NO FIRE HOSE CONNECTIONS ARE REQUIRED AT 5TH LEVEL.
 11 4" FIRE PROTECTION LINE. SEE SUPPLEMENTAL DRAWING P-24.

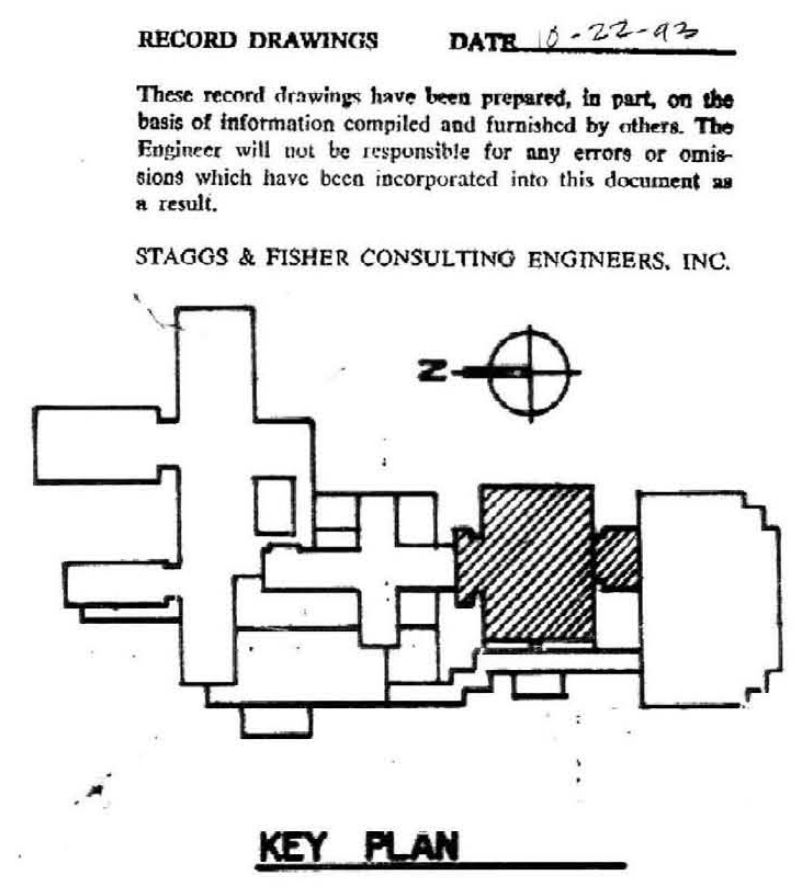

Fourth Floor Plan
 100: 1/8" = 1'-0"

SUPPLEMENTAL DRAWING

ALBERT B. CHANDLER MEDICAL CENTER UNIVERSITY OF KENTUCKY HOSPITAL EXPANSION & RENOVATION
 SUPPLEMENTAL DRAWING
 HOSPITAL EXPANSION & RENOVATION
 A. B. CHANDLER MEDICAL CENTER
 PROJECT NO. 304.1
 BID PACKAGE #2

University of Kentucky
 Design & Construction
 Approval
 Director
 Date: 9/10/83
 Drawn by: DWL
 Check by: DAC
 Revisions:

STAGGS & FISHER
CONSULTING ENGINEERS
 327 S. BARLAND AVE., COVINGTON, KY 40303
 PHONE (606) 588-1188

OMN/CMW Joint Venture Architects
 In Association with Hellmuth, Obata, & Kassabaum
 2385 Harrodsburg Road, Lexington, KY 40504 Ph: 502-253-3045
 326 S. Broadway, Lexington, KY 40506 Ph: 502-254-6203
 Chirman-Miller-Woodford

