

UNIVERSITY OF KENTUCKY
Physical Plant Division


**KEENELAND HALL STEAM / CONDENSATE REPLACEMENT
 KEENELAND TO NEW PIT AT NE CORNER BLAZER HALL**
BUILDING NUMBER: 57A

KEENELAND HALL, 5TH AM & CONDENSATE REPLACEMENT PROJECT 65834 /

<small>DESIGNED BY:</small>	<small>REVISIONS:</small>
<small>DRAWN BY:</small> B. ANGLIN	<small>DATE:</small>
<small>CHECKED BY:</small>	<small>APPROVED BY:</small>
<small>PROJECT NO.:</small> 558347	<small>DATE:</small> 05-26-06
<small>DRAWING NUMBER:</small>	

2 of 3

30775



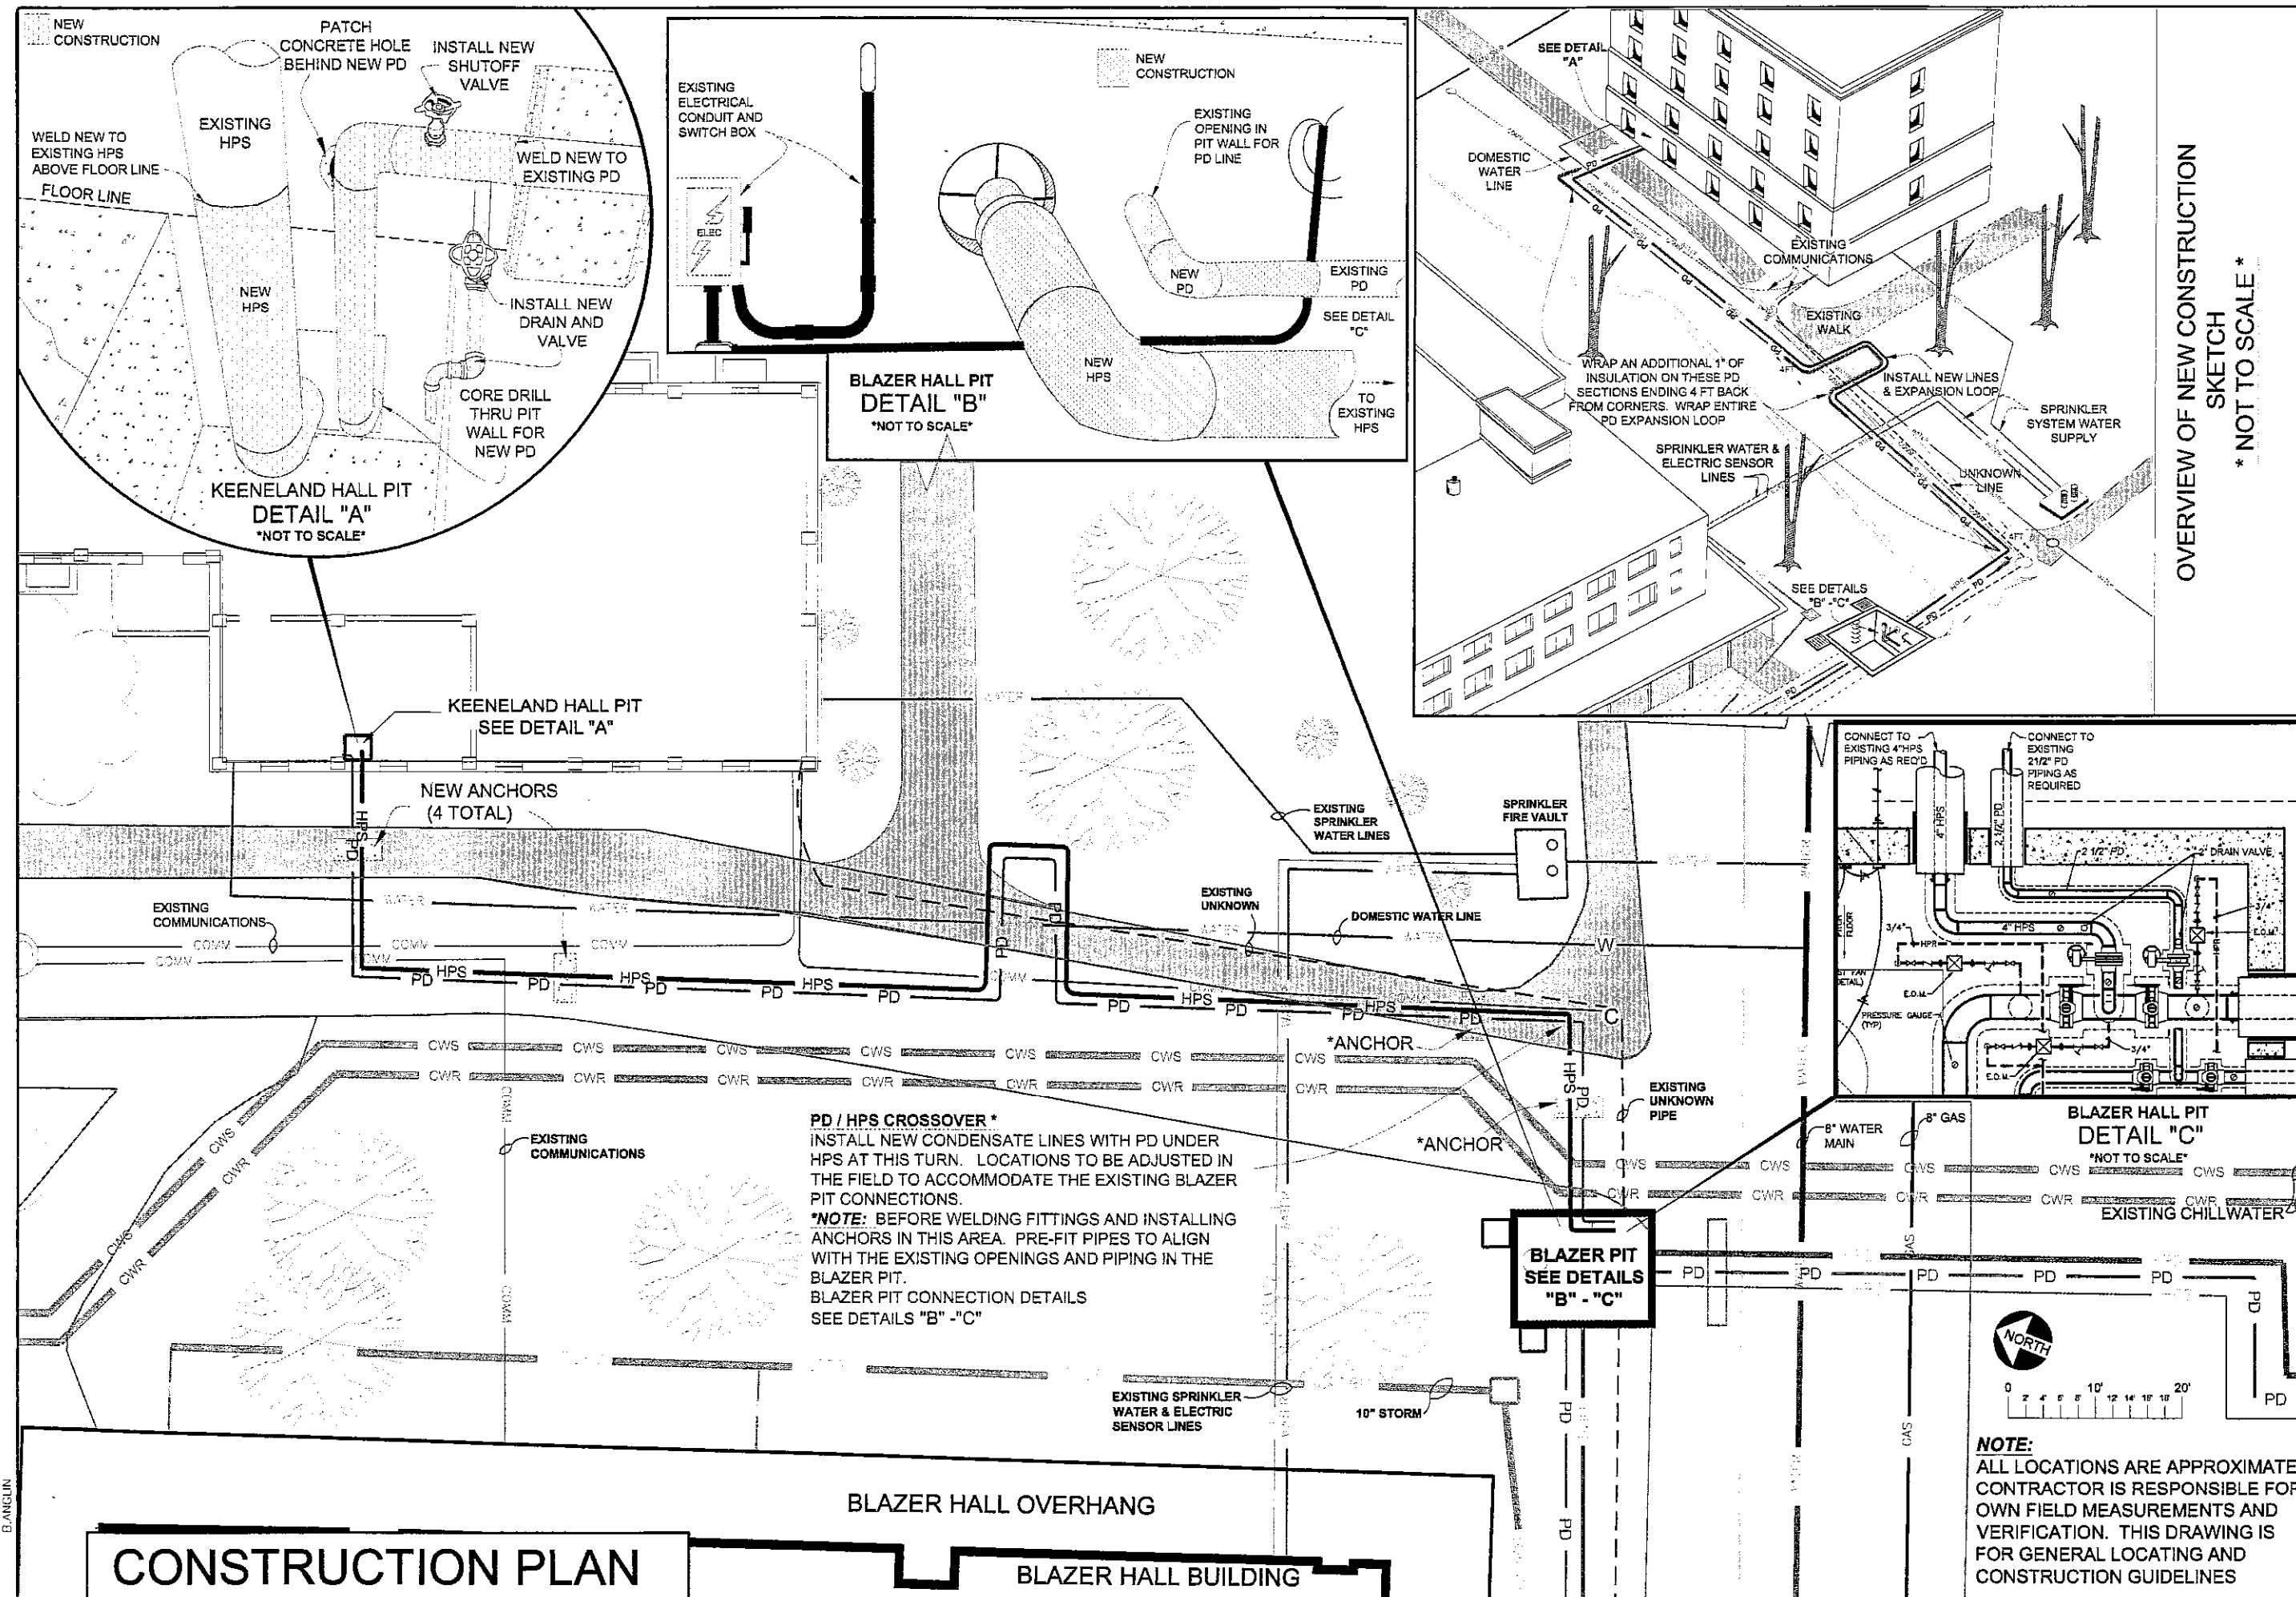


B. ANGLIN


CONSTRUCTION PLAN

BLAZER HALL OVERHANG

BLAZER HALL BUILDING

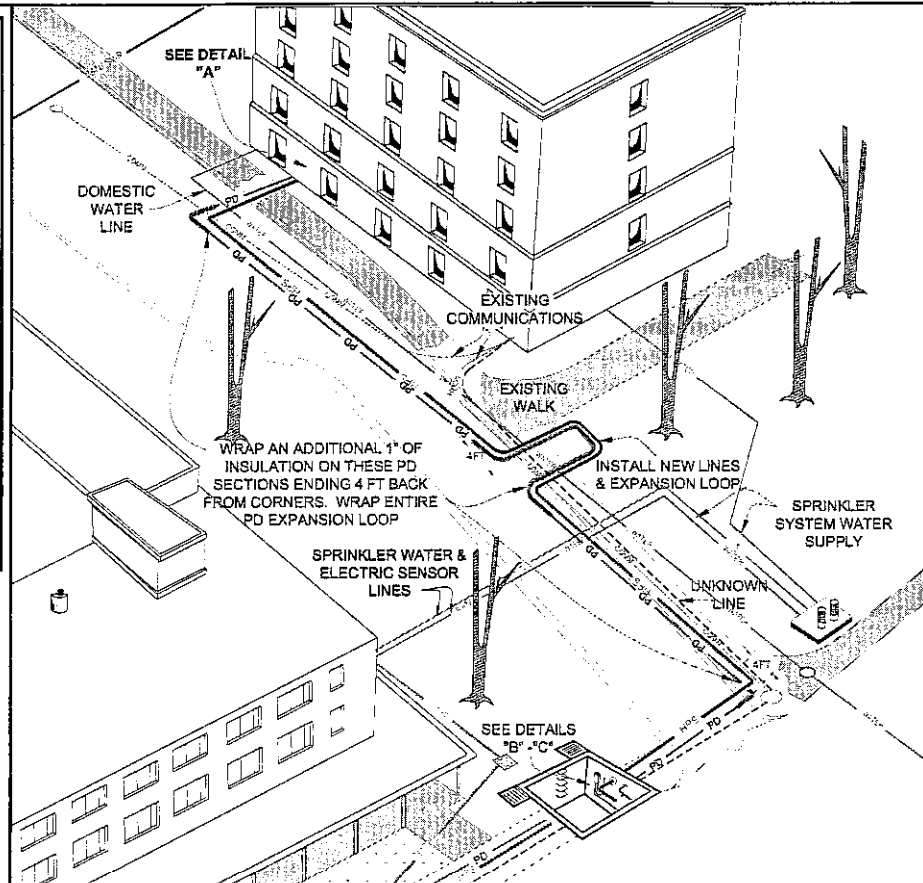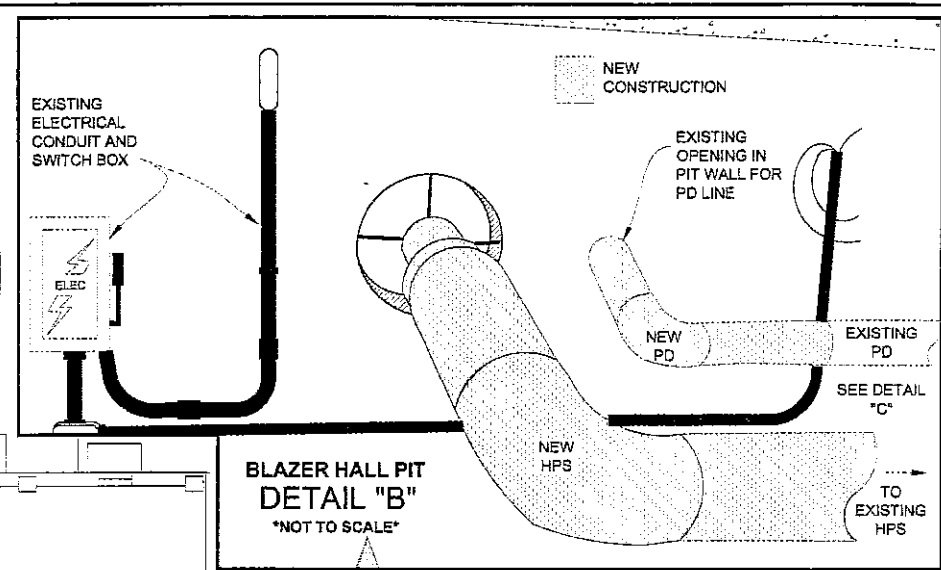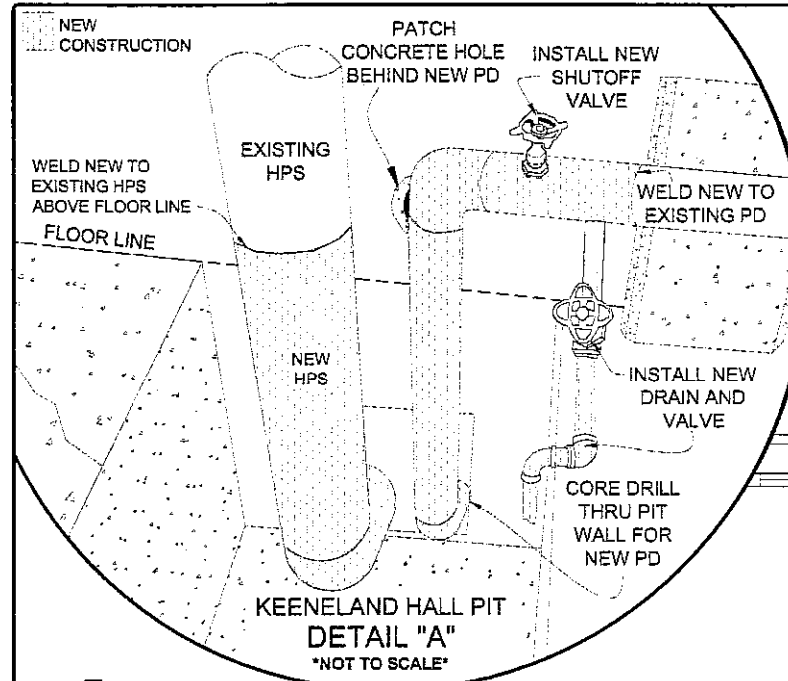


OVERVIEW OF NEW CONSTRUCTION
SKETCH
* NOT TO SCALE *

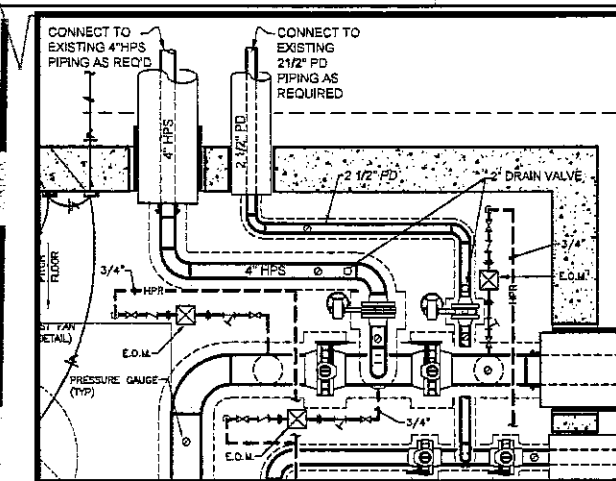

PD / HPS CROSSOVER *
INSTALL NEW CONDENSATE LINES WITH PD UNDER HPS AT THIS TURN. LOCATIONS TO BE ADJUSTED IN THE FIELD TO ACCOMMODATE THE EXISTING BLAZER PIT CONNECTIONS.
***NOTE:** BEFORE WELDING FITTINGS AND INSTALLING ANCHORS IN THIS AREA. PRE-FIT PIPES TO ALIGN WITH THE EXISTING OPENINGS AND PIPING IN THE BLAZER PIT.
BLAZER PIT CONNECTION DETAILS SEE DETAILS "B" - "C"

DESIGNED BY:	DATE:
DRAWN BY:	
CHECKED BY:	
APPROVED BY:	
PROJECT NO:	
DATE:	
DRAWING NUMBER:	

30776

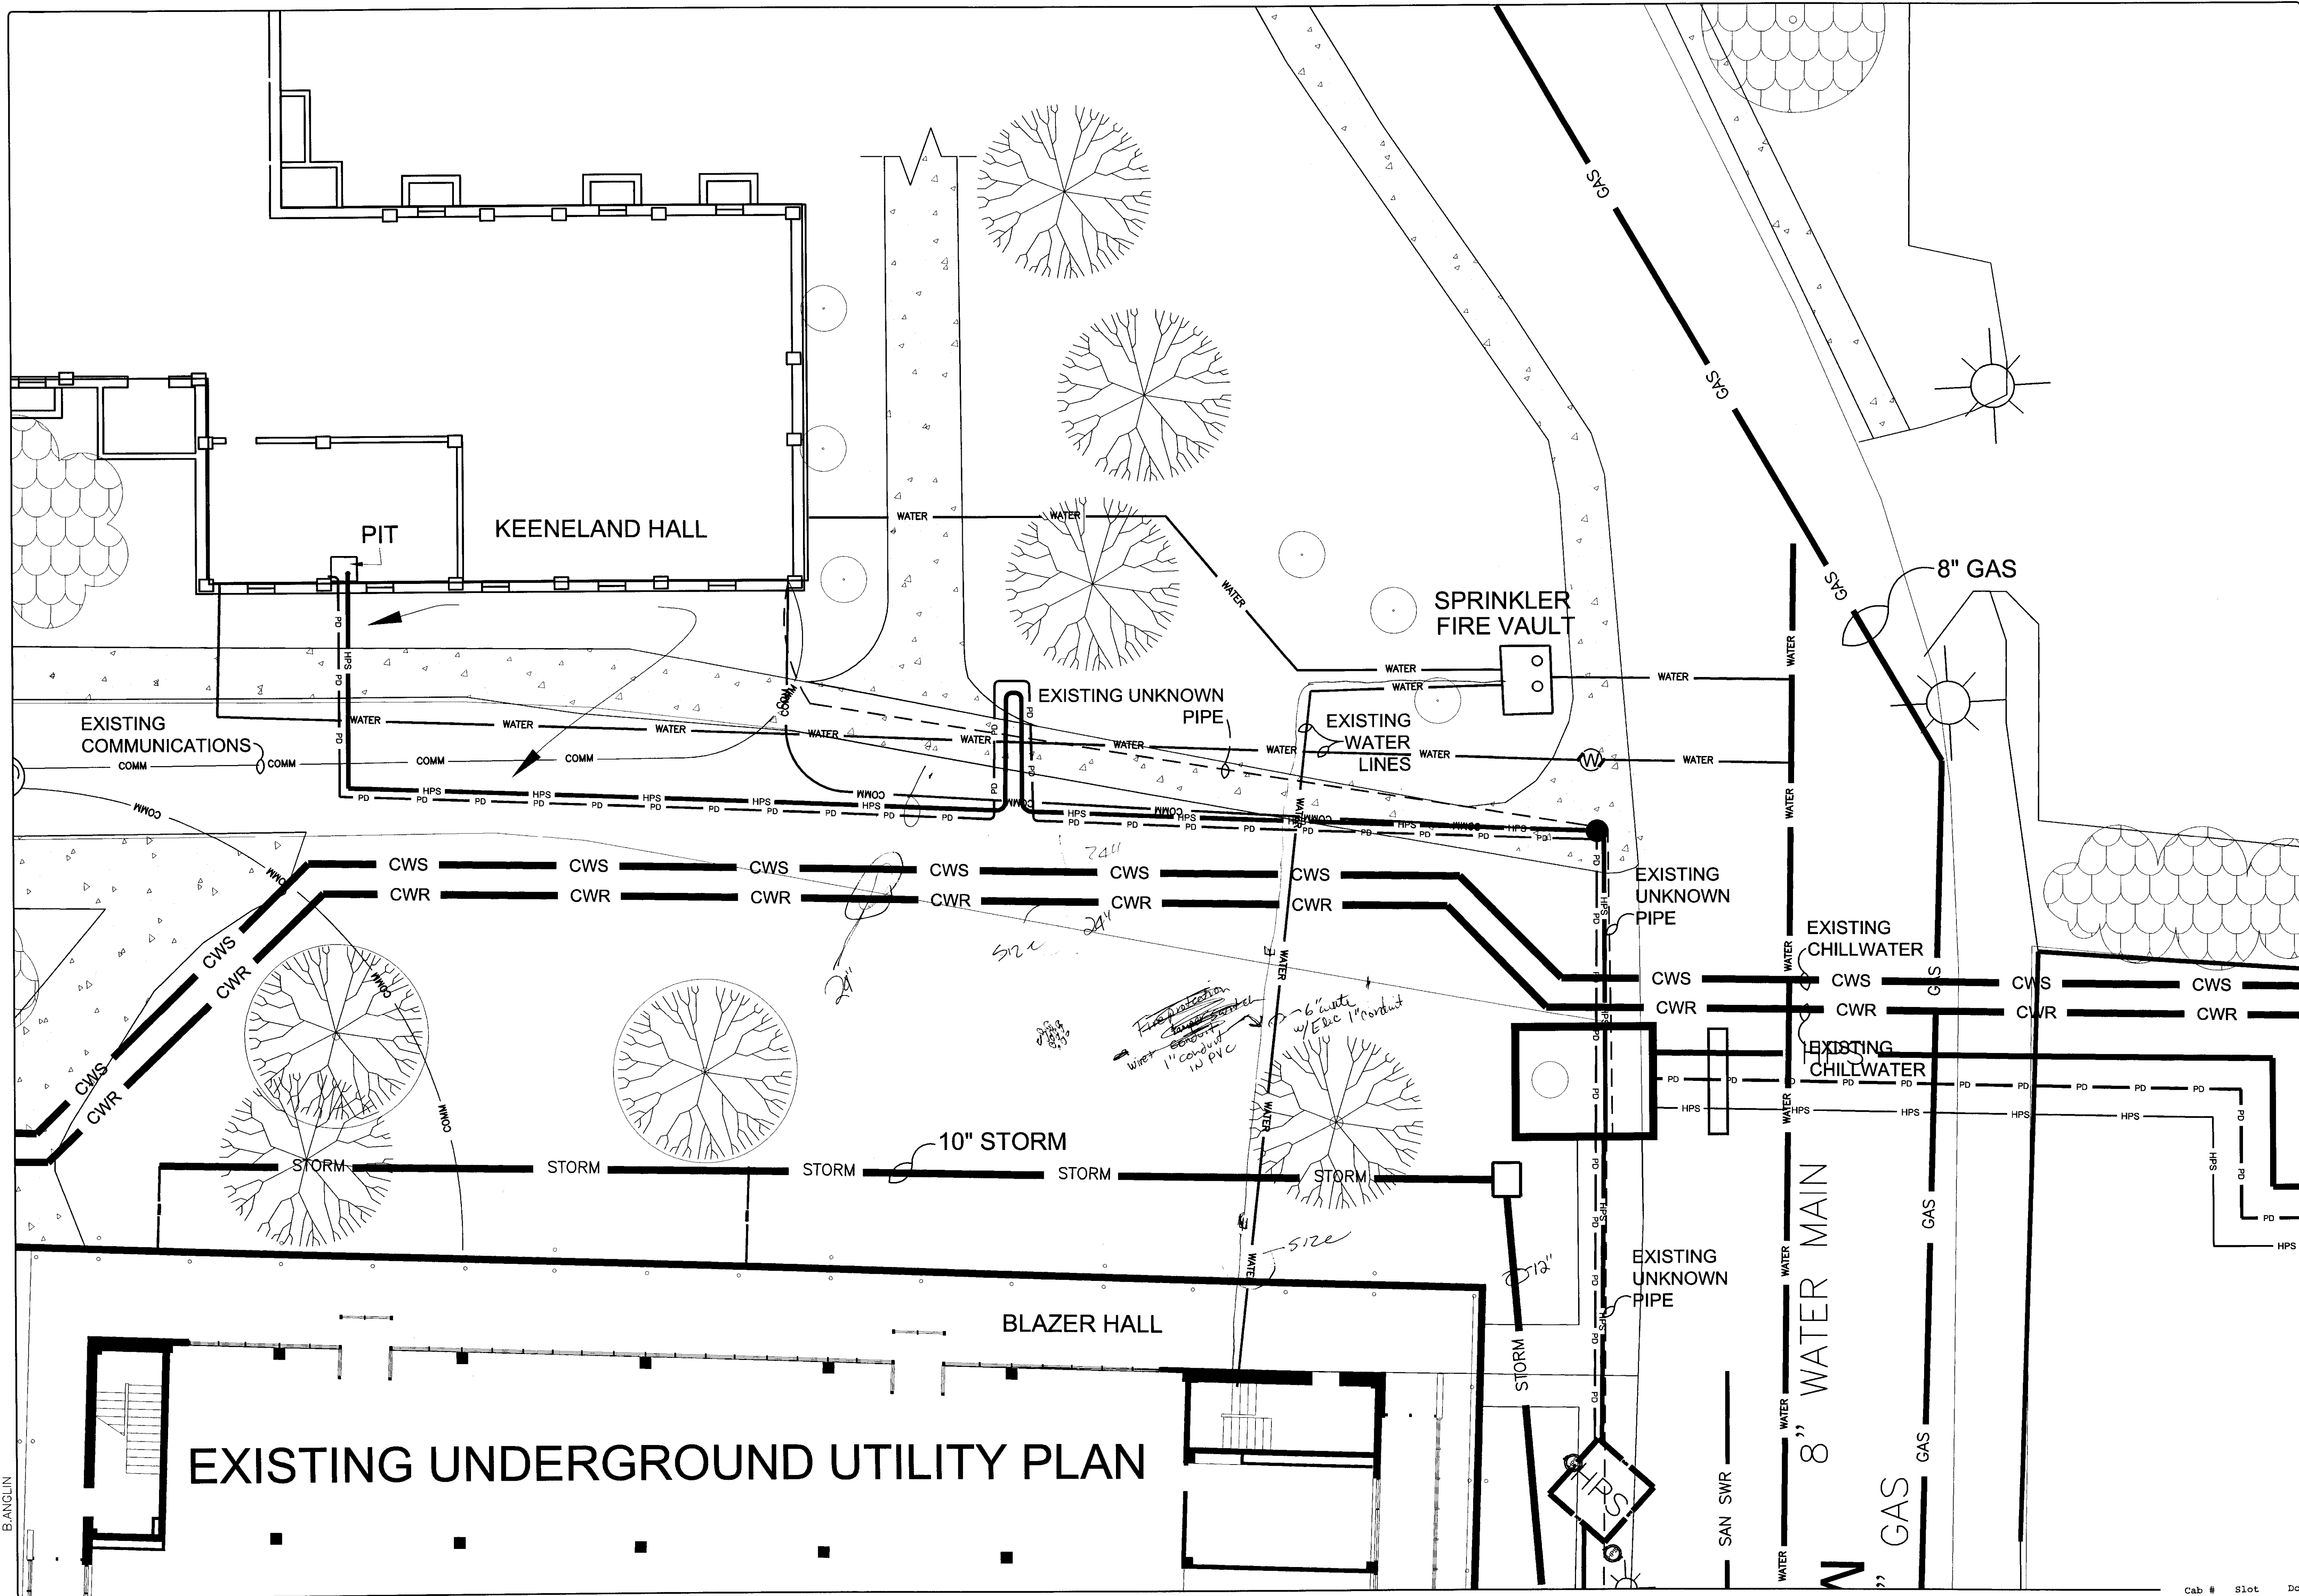



EXISTING UNDERGROUND UTILITY PLAN

**KEENELAND HALL STEAM / CONDENSATE REPLACEMENT
KEENELAND TO NEW PIT AT NE CORNER BLAZER HALL**

REVISIONS

BY:	DATE:

DESIGNED BY:
DRAWN BY: B. ANGLIN
CHECKED BY:
APPROVED BY:
PROJECT NO.: 658347
DATE: 05-02-06
DRAWING NUMBER:

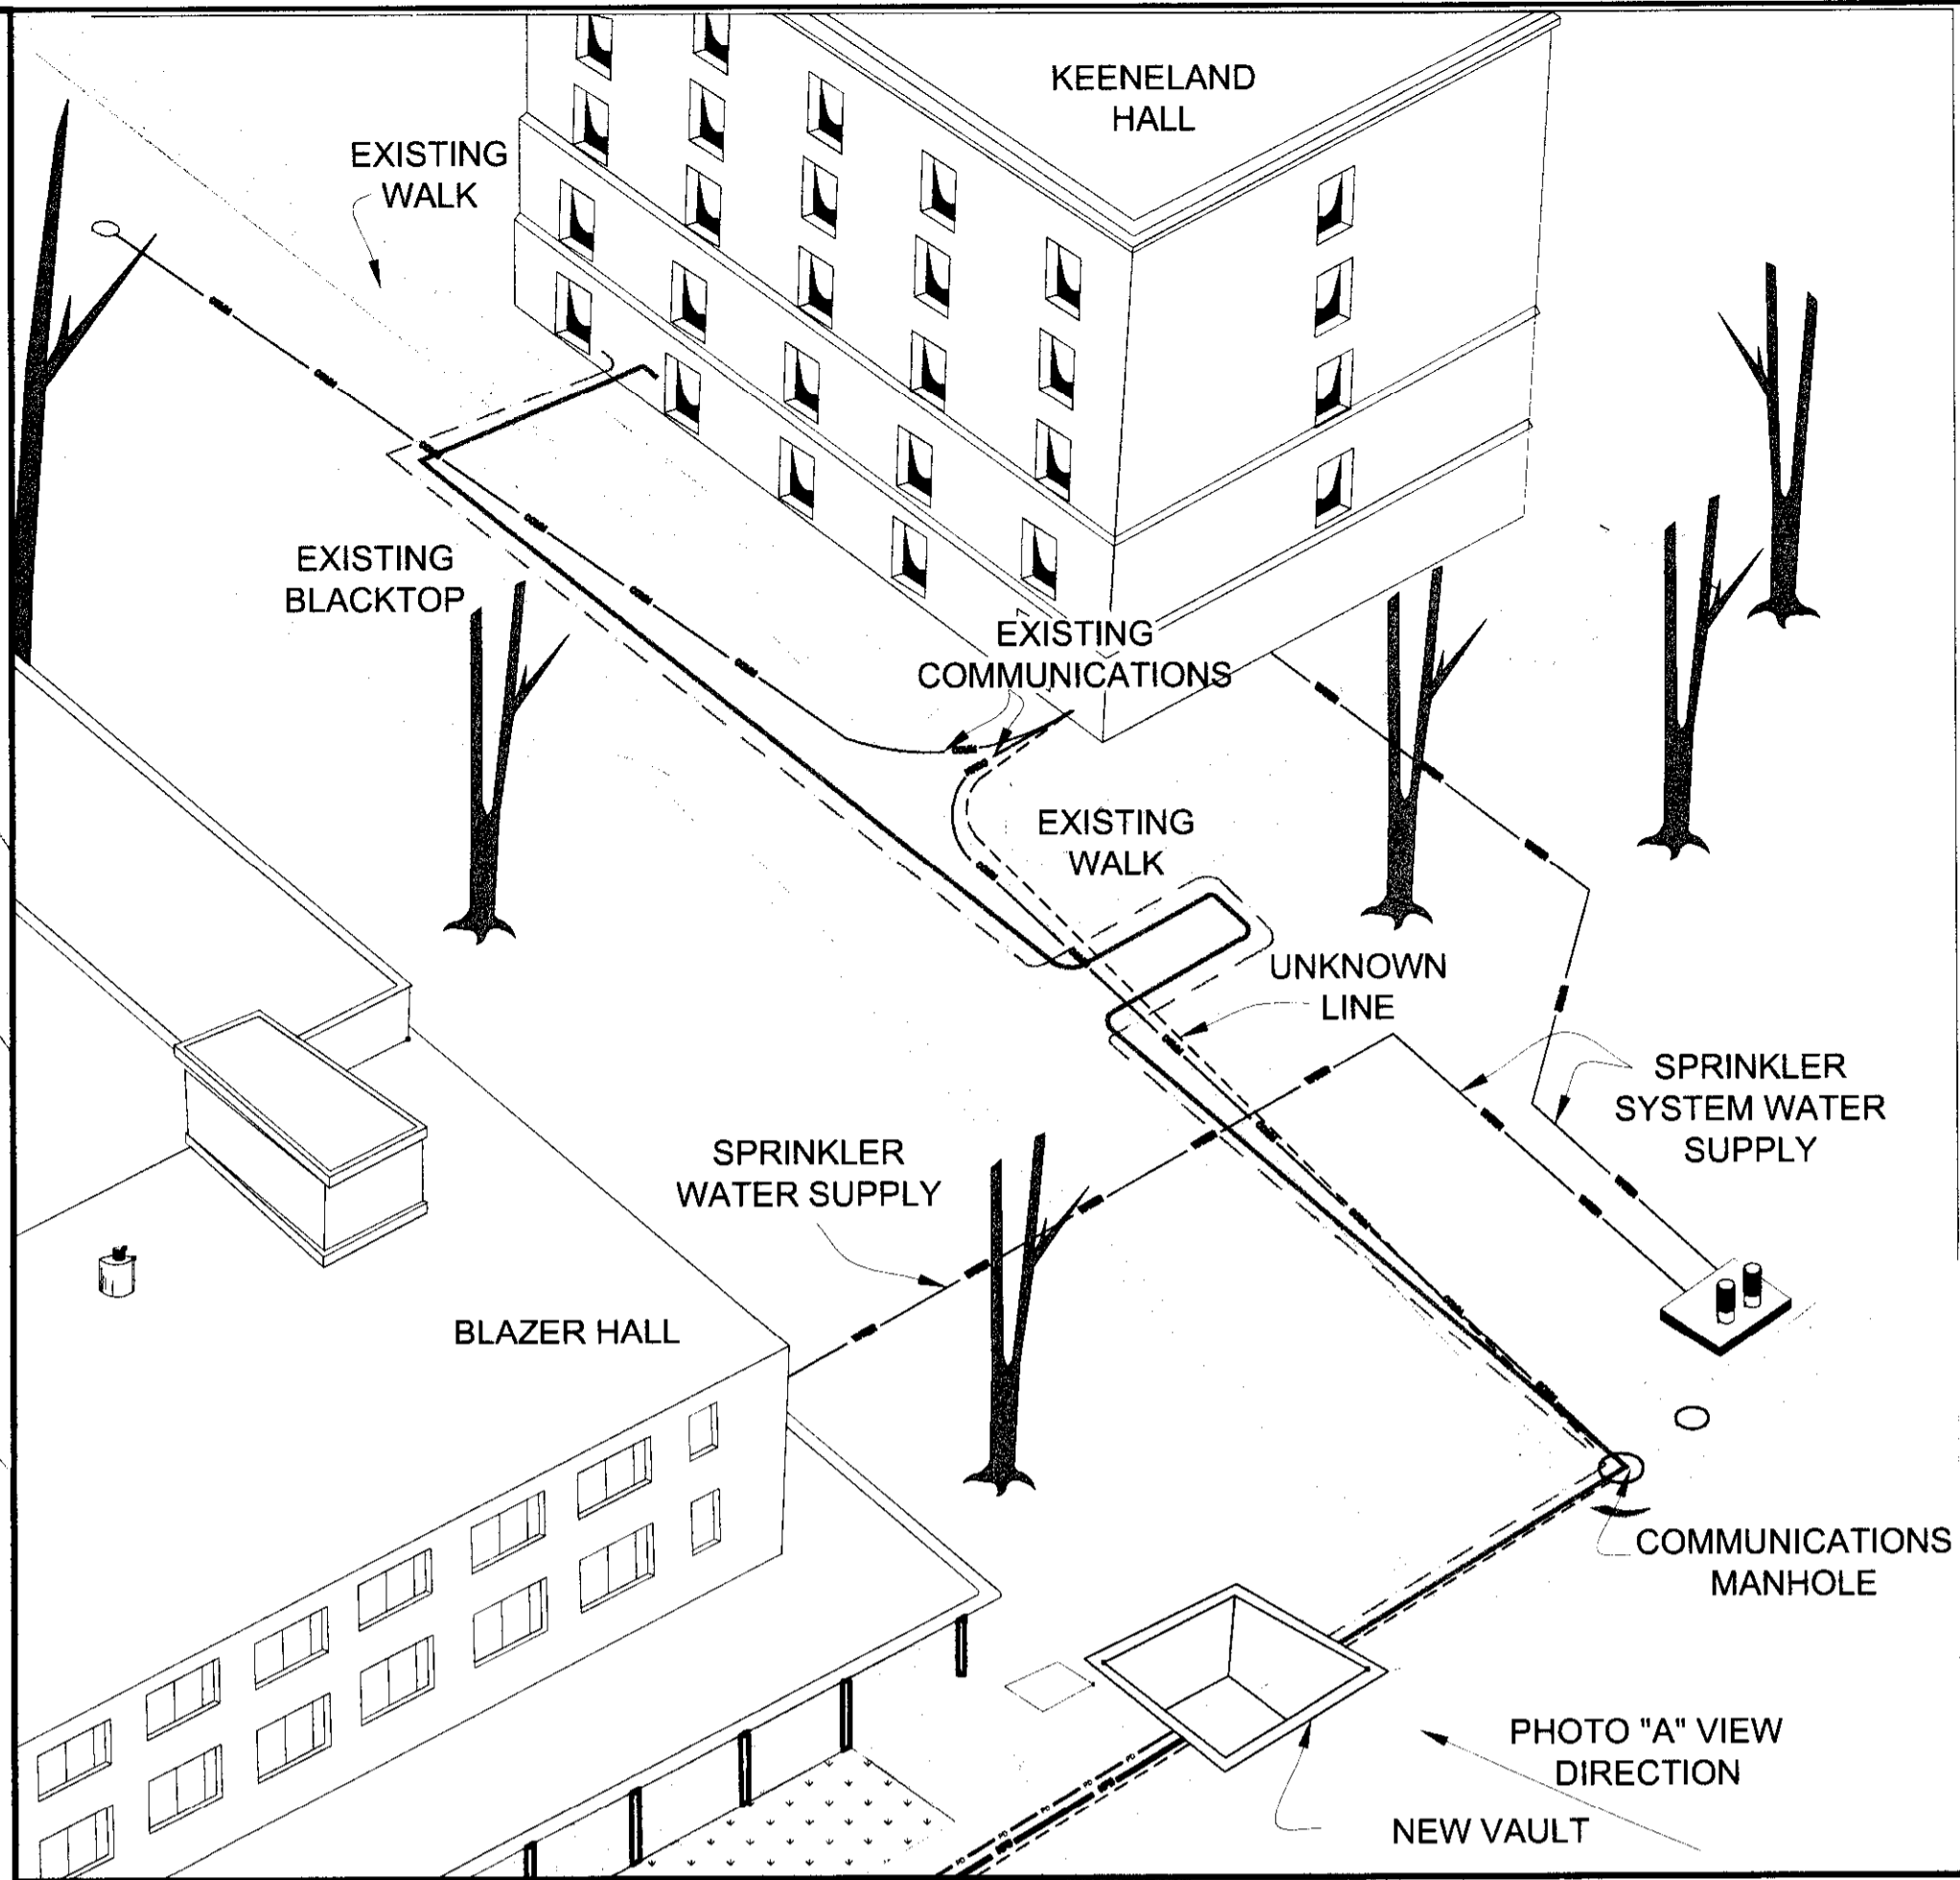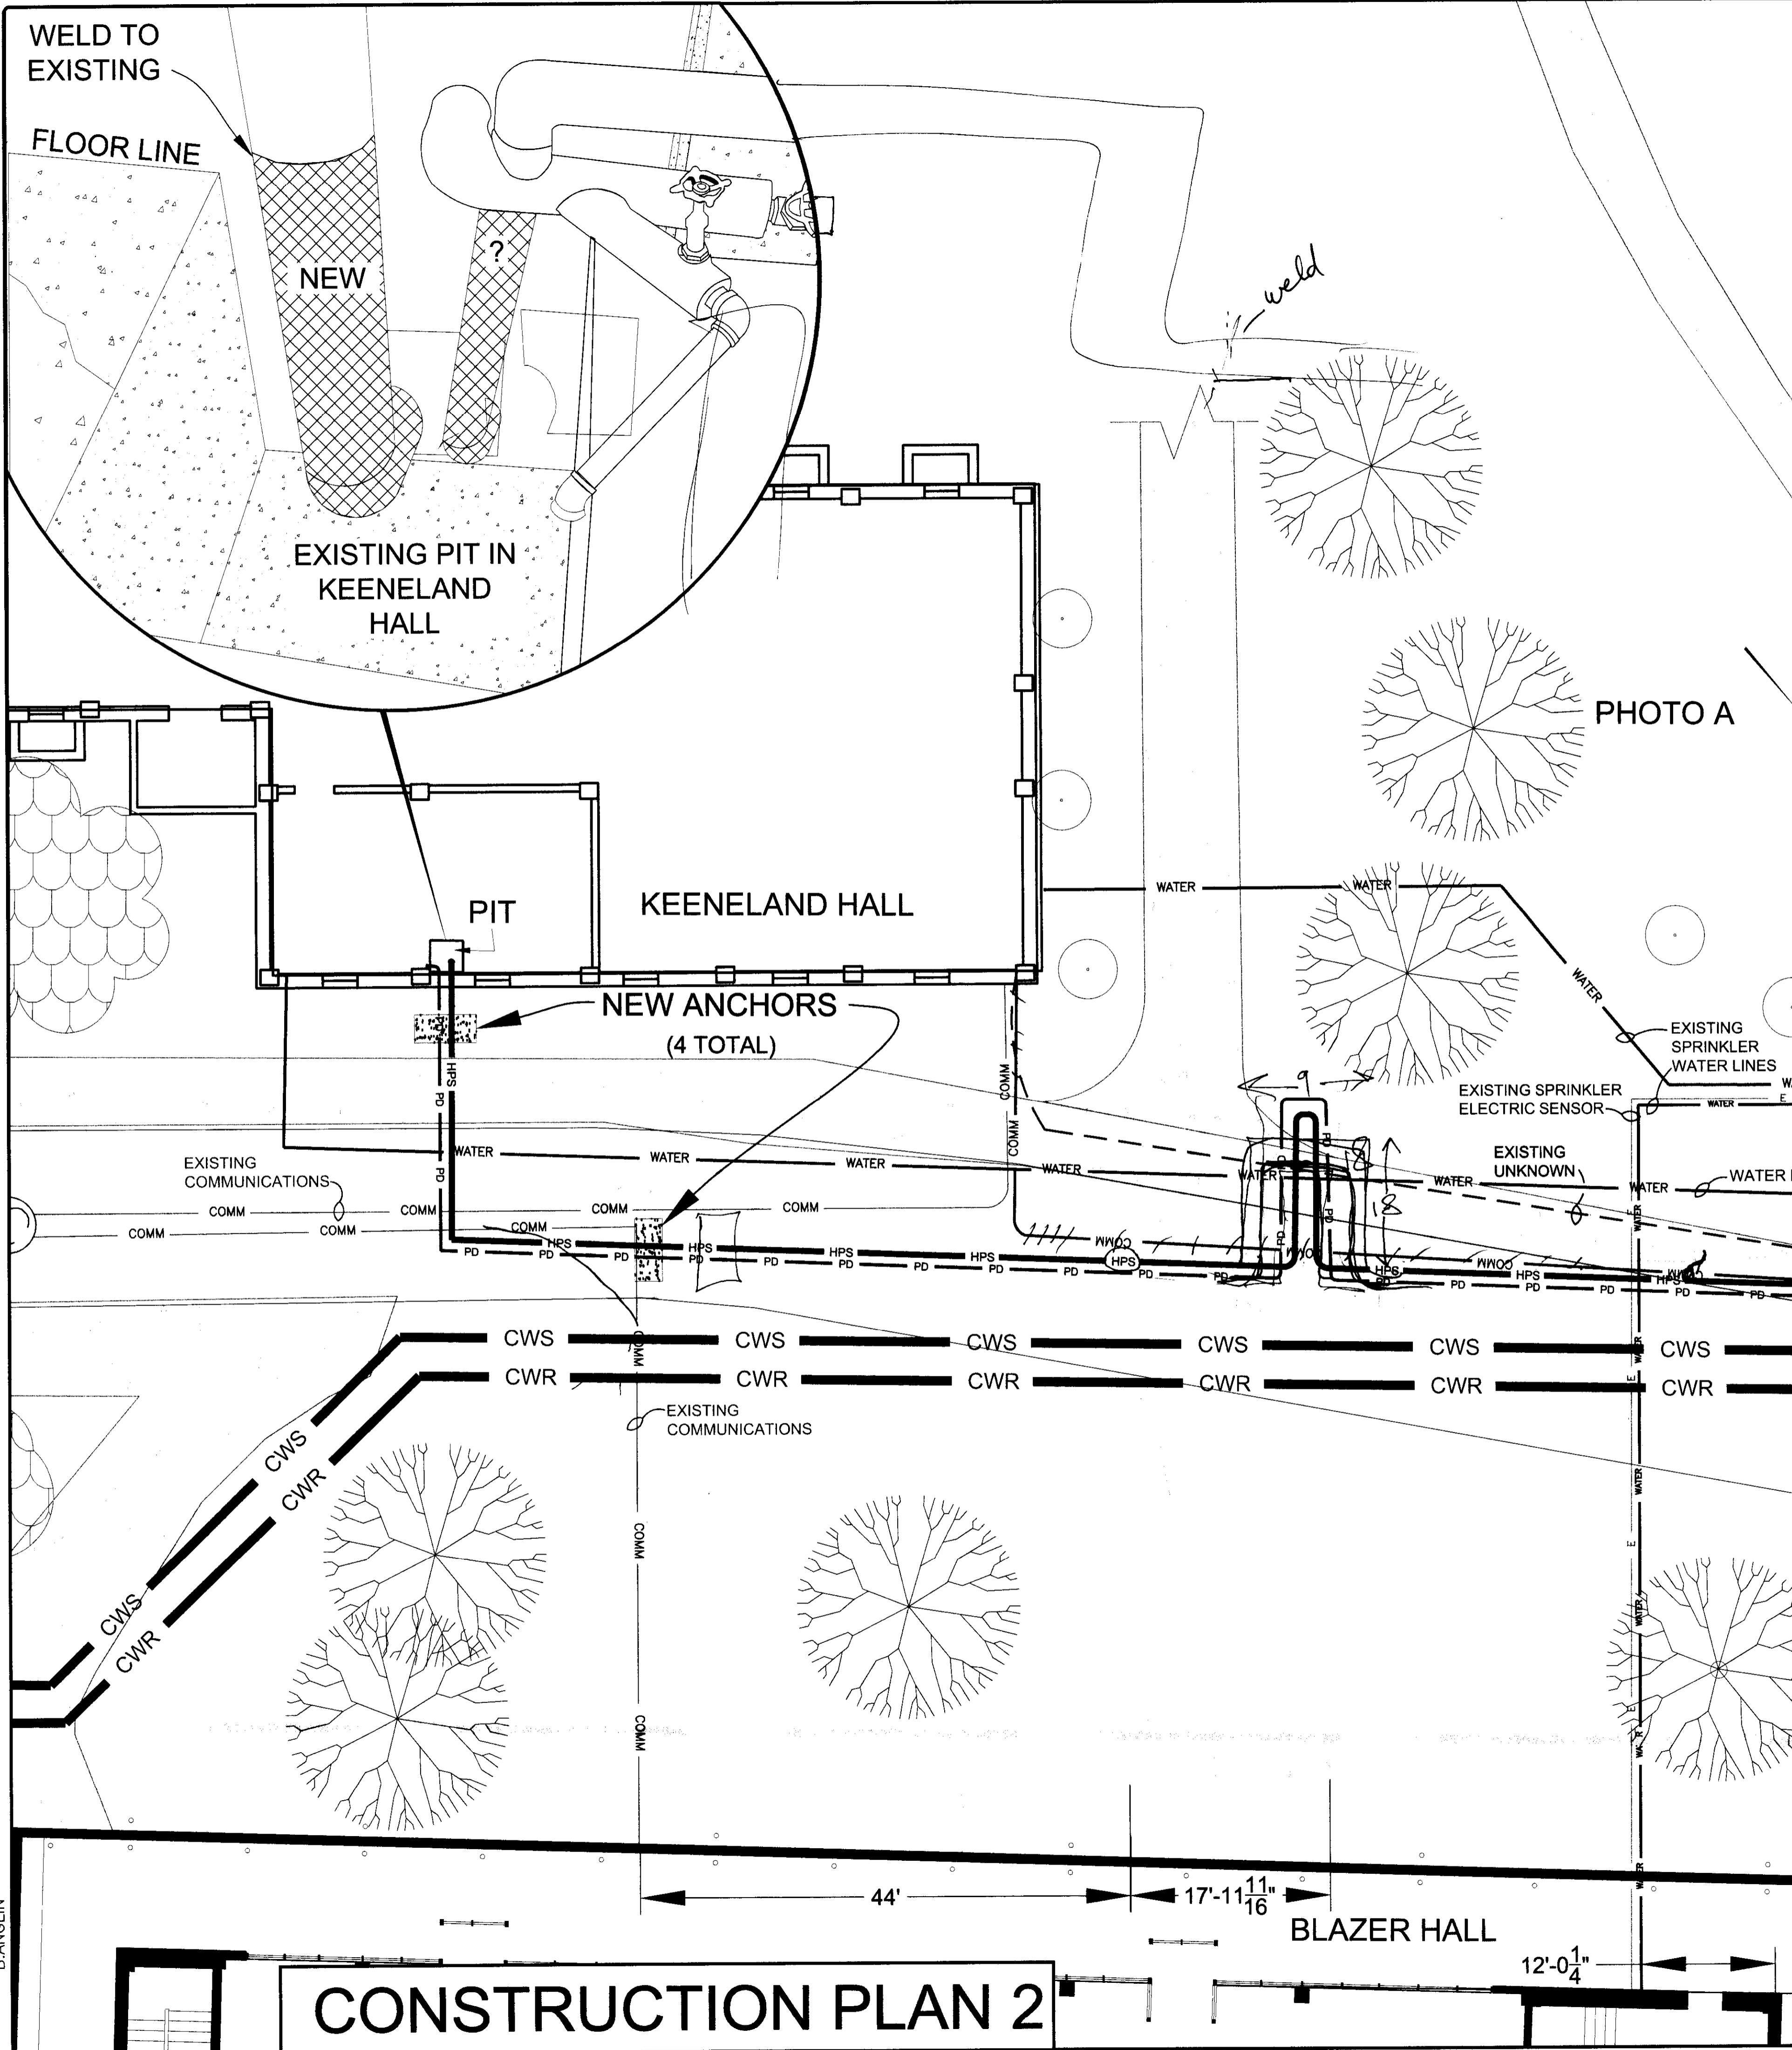

CONSTRUCTION PLAN 2

UNIVERSITY OF KENTUCKY
Physical Plant Division

UK

**KEENELAND HALL STEAM / CONDENSATE REPLACEMENT
KEENELAND TO NEW PIT AT NE CORNER BLAZER HALL**
BUILDING NUMBER: N/A

KEENELAND HALL STEAM & CONDENSATE REPLACEMENT PROJECT 658347

REVISIONS	DATE

DESIGNED BY:
DRAWN BY: B. ANGLIN
CHECKED BY:
APPROVED BY:


PROJECT NO.: 658347
DATE: 05-02-06

DRAWING NUMBER:
3 of 3

Cab # 810t Document # 195 D-4 34155

12/13/2007

B-ANGLIN

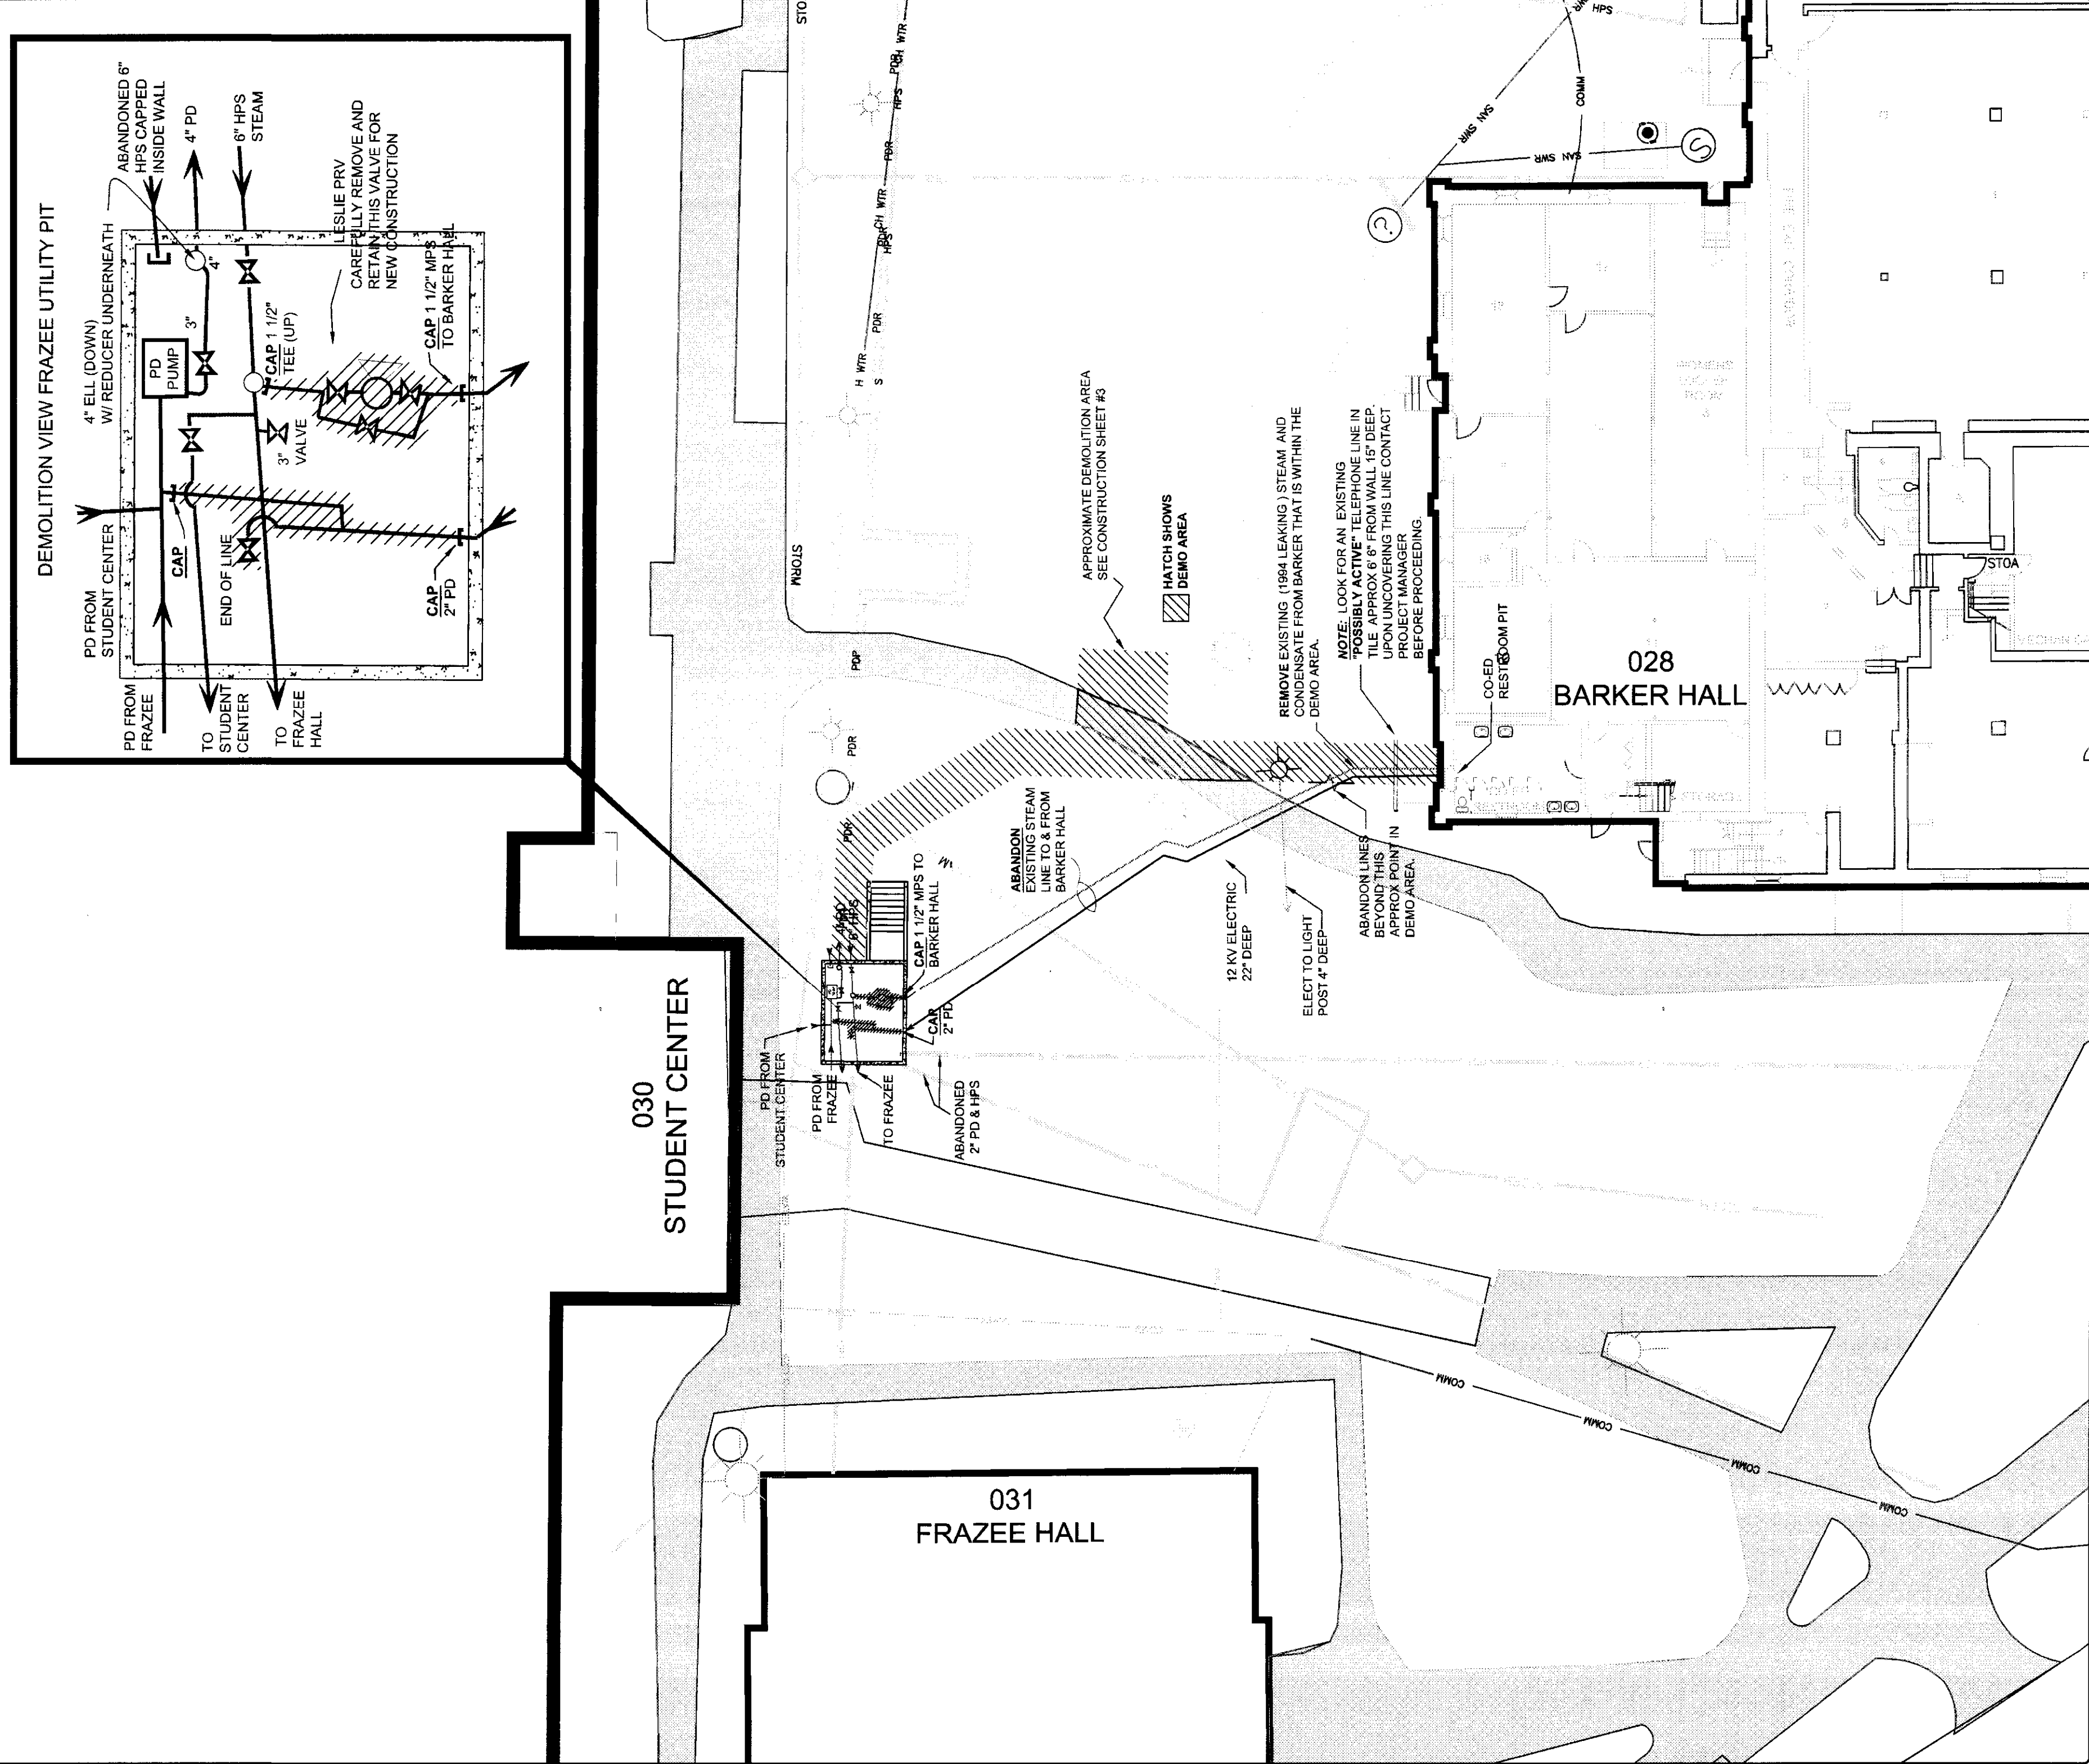

DEMOLITION SITE
BARKER- FRAZEE STEAM PIT CONNECTION

BUILDING NUMBER: 028
 PROJECT CONSTRUCTION DRAWING

REVISIONS	
BY:	DATE




DESIGNED BY: GG
 DRAWN BY: SA
 CHECKED BY:
 APPROVED BY:
 PROJECT NO.: 658347
 DATE: 05-14-07

DRAWING NUMBER:
2 of 4




B. ANGLIN

12/19/2007

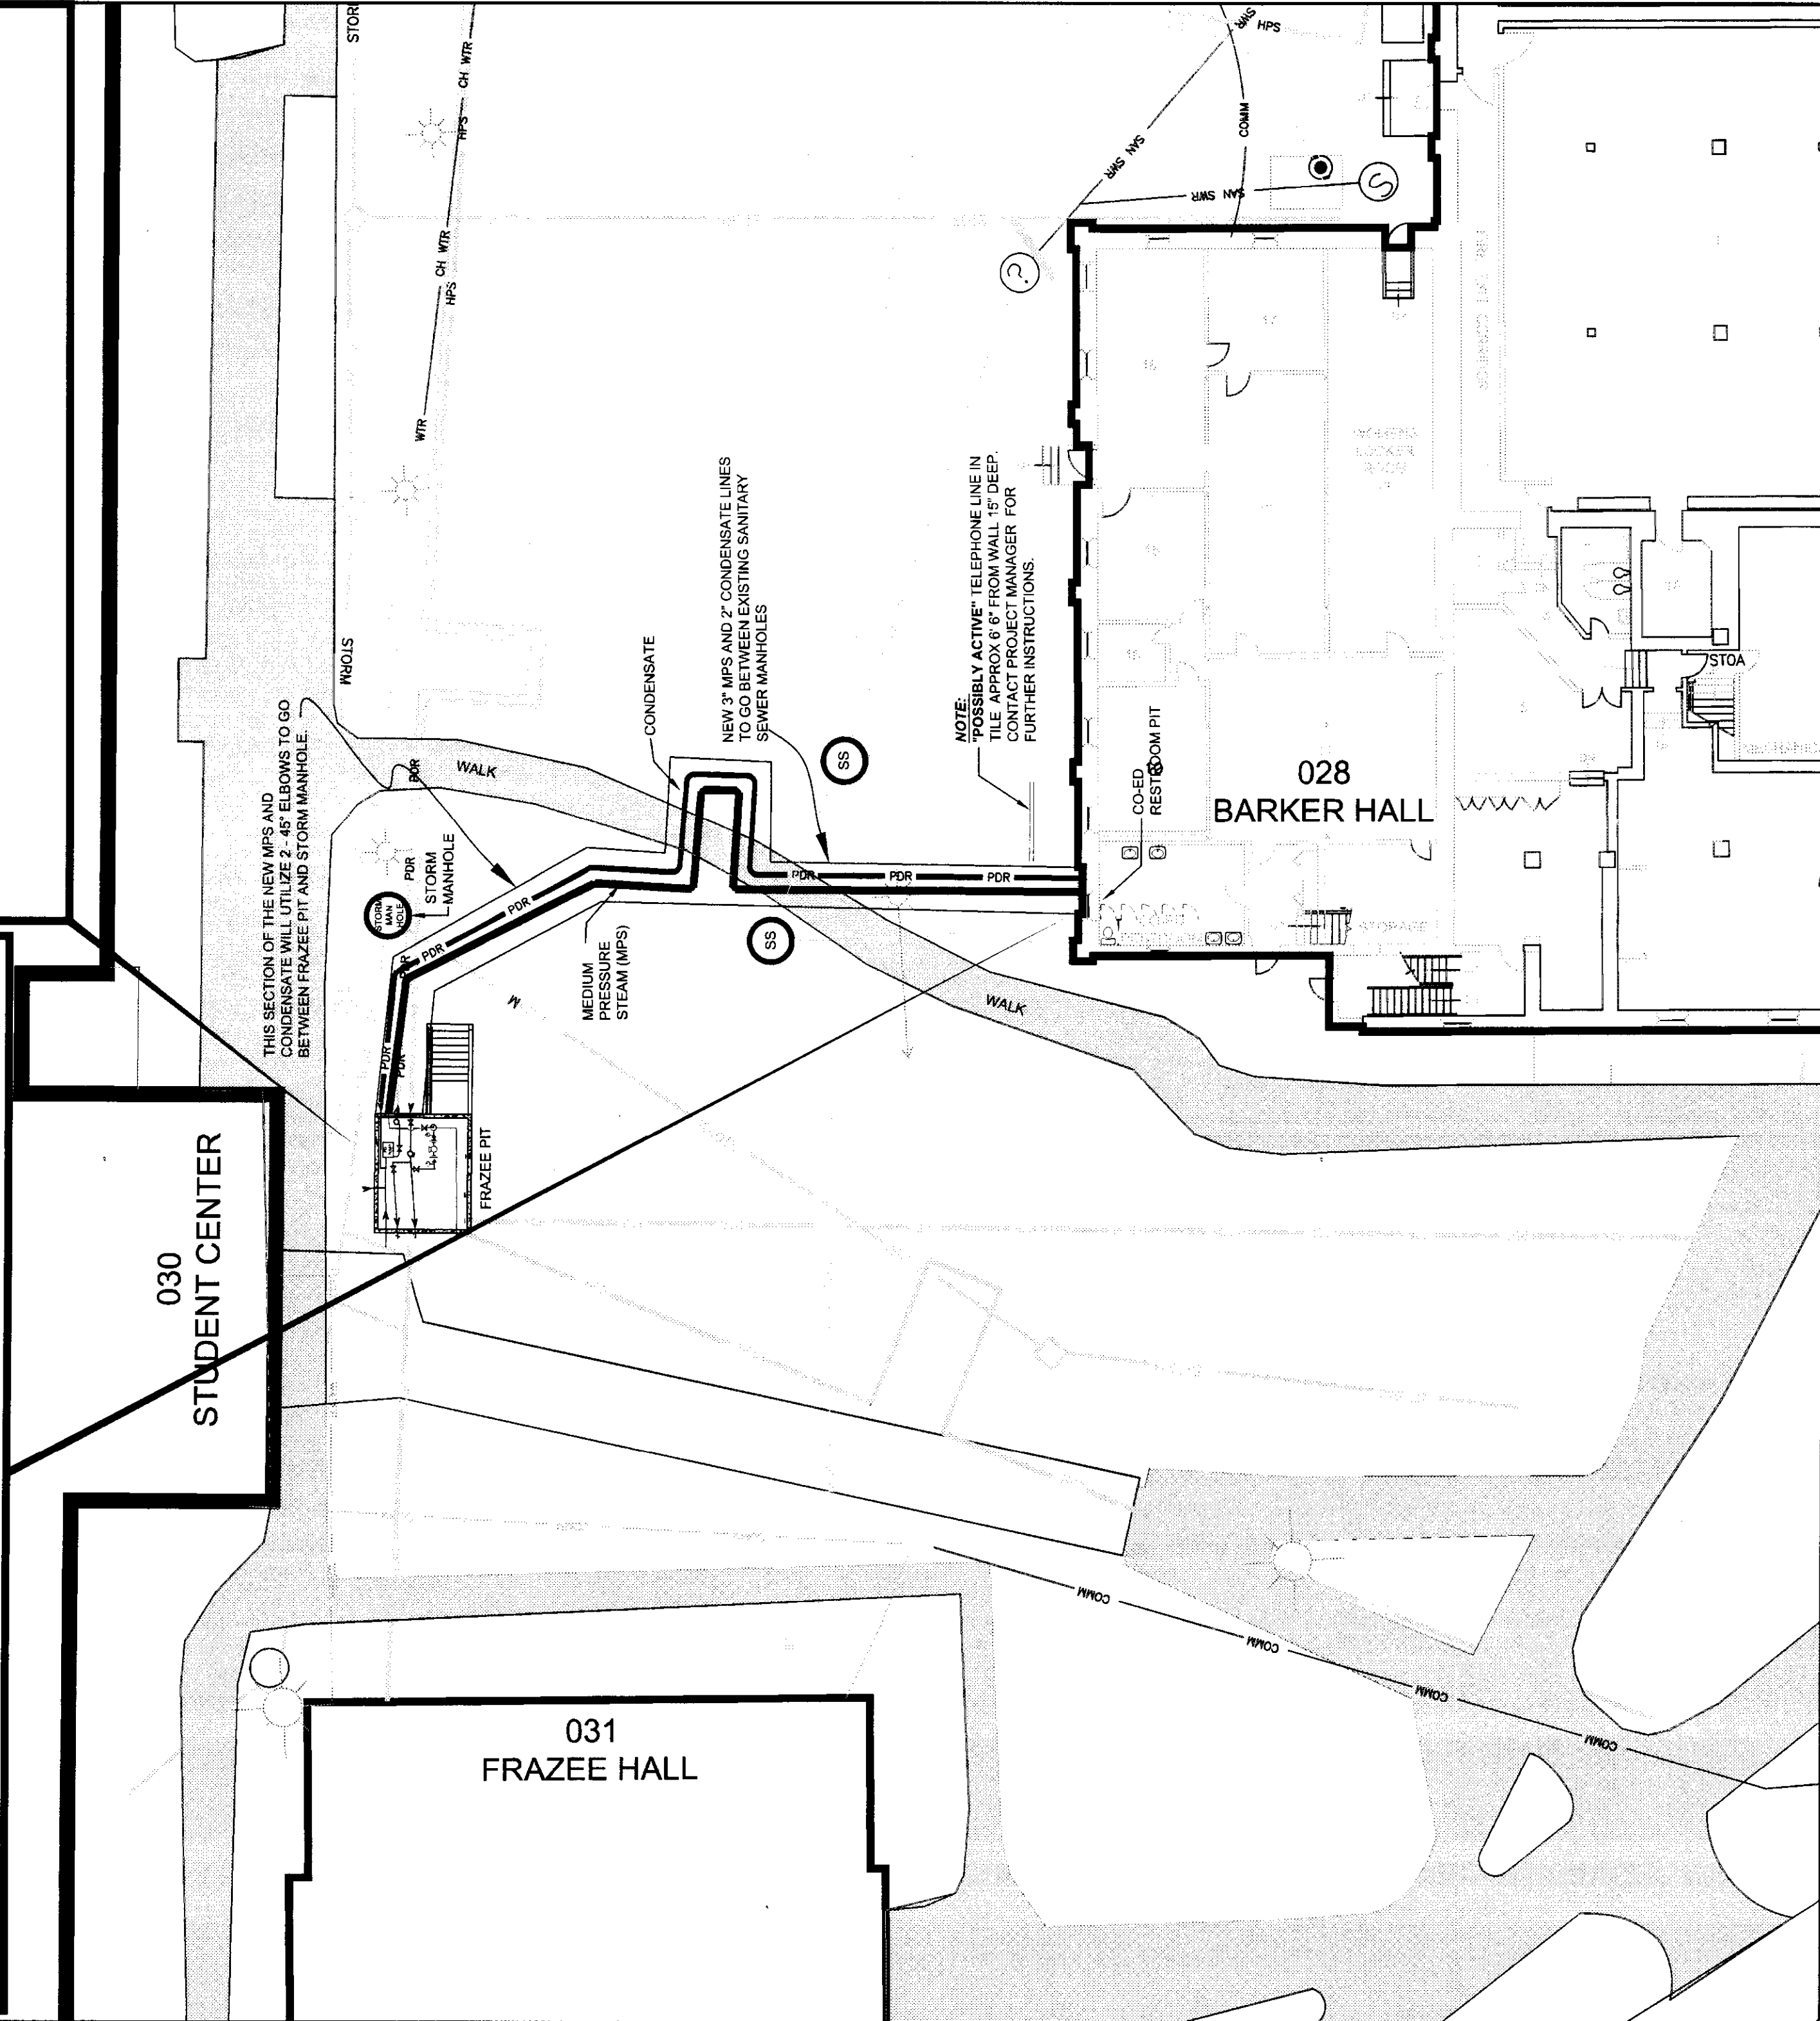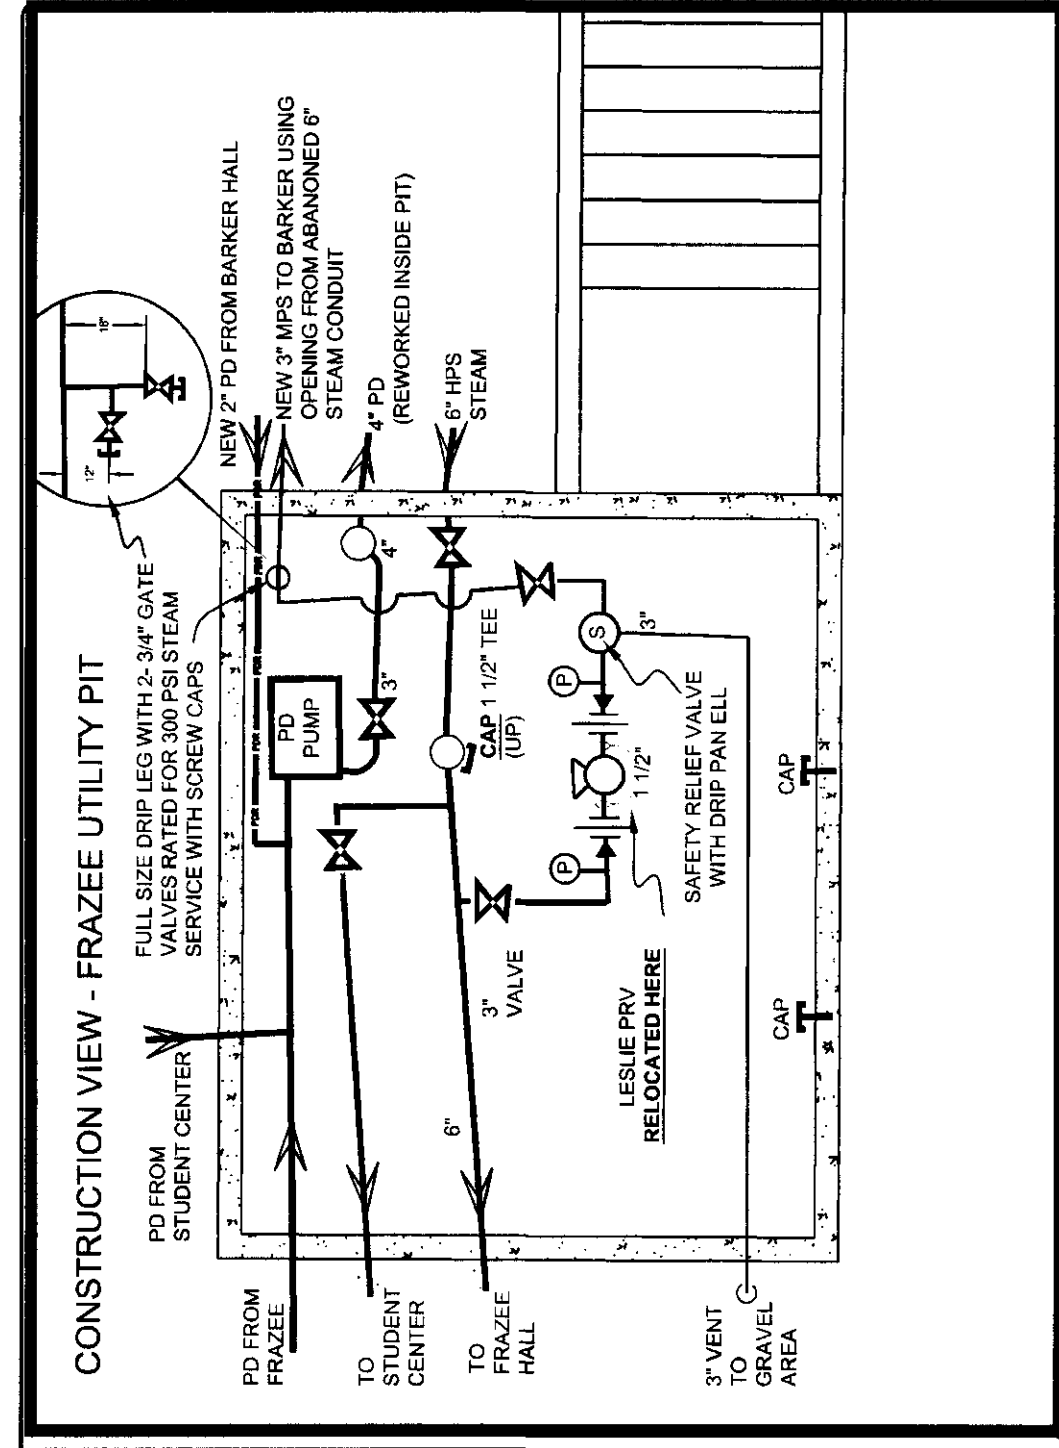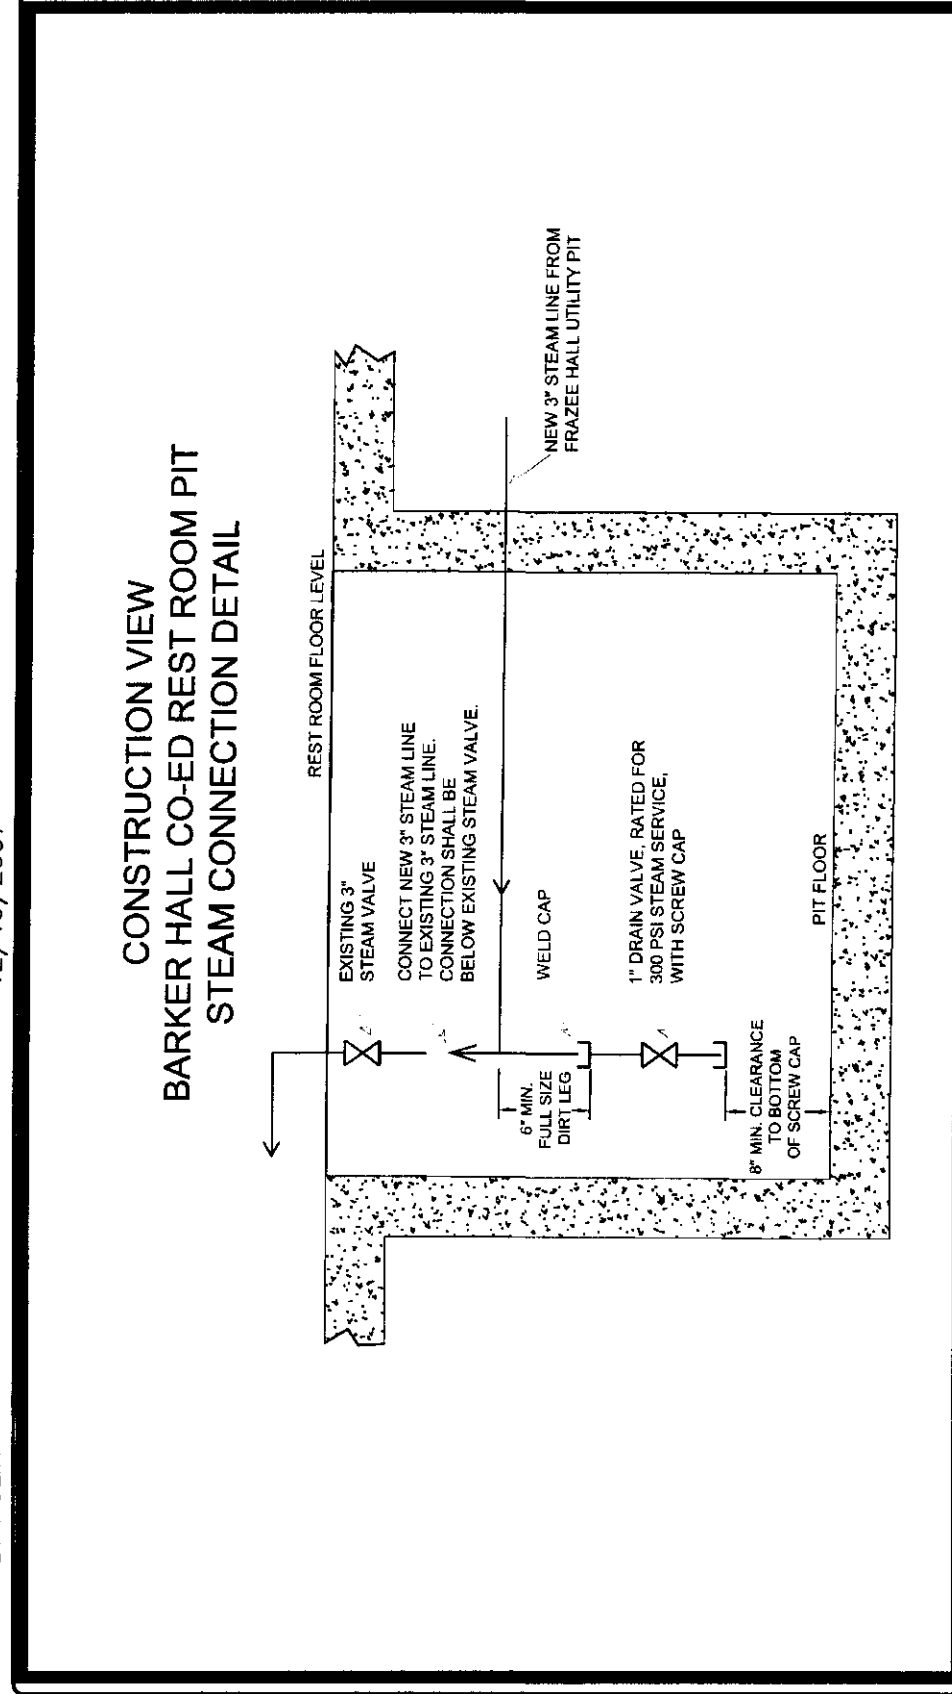


DESIGNED BY:	DATE
GG	
DRAWN BY:	
BSA	
CHECKED BY:	
APPROVED BY:	
PROJECT NO.:	658347
DATE:	05-14-07


CONSTRUCTION SITE
BARKER- FRAZEE STEAM PIT CONNECTION
 BUILDING NUMBER: 028
 PROJECT CONSTRUCTION DRAWING

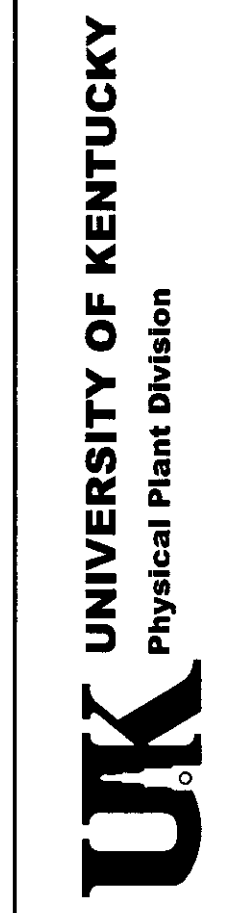

CONSTRUCTION VIEW - FRAZEE UTILITY PIT

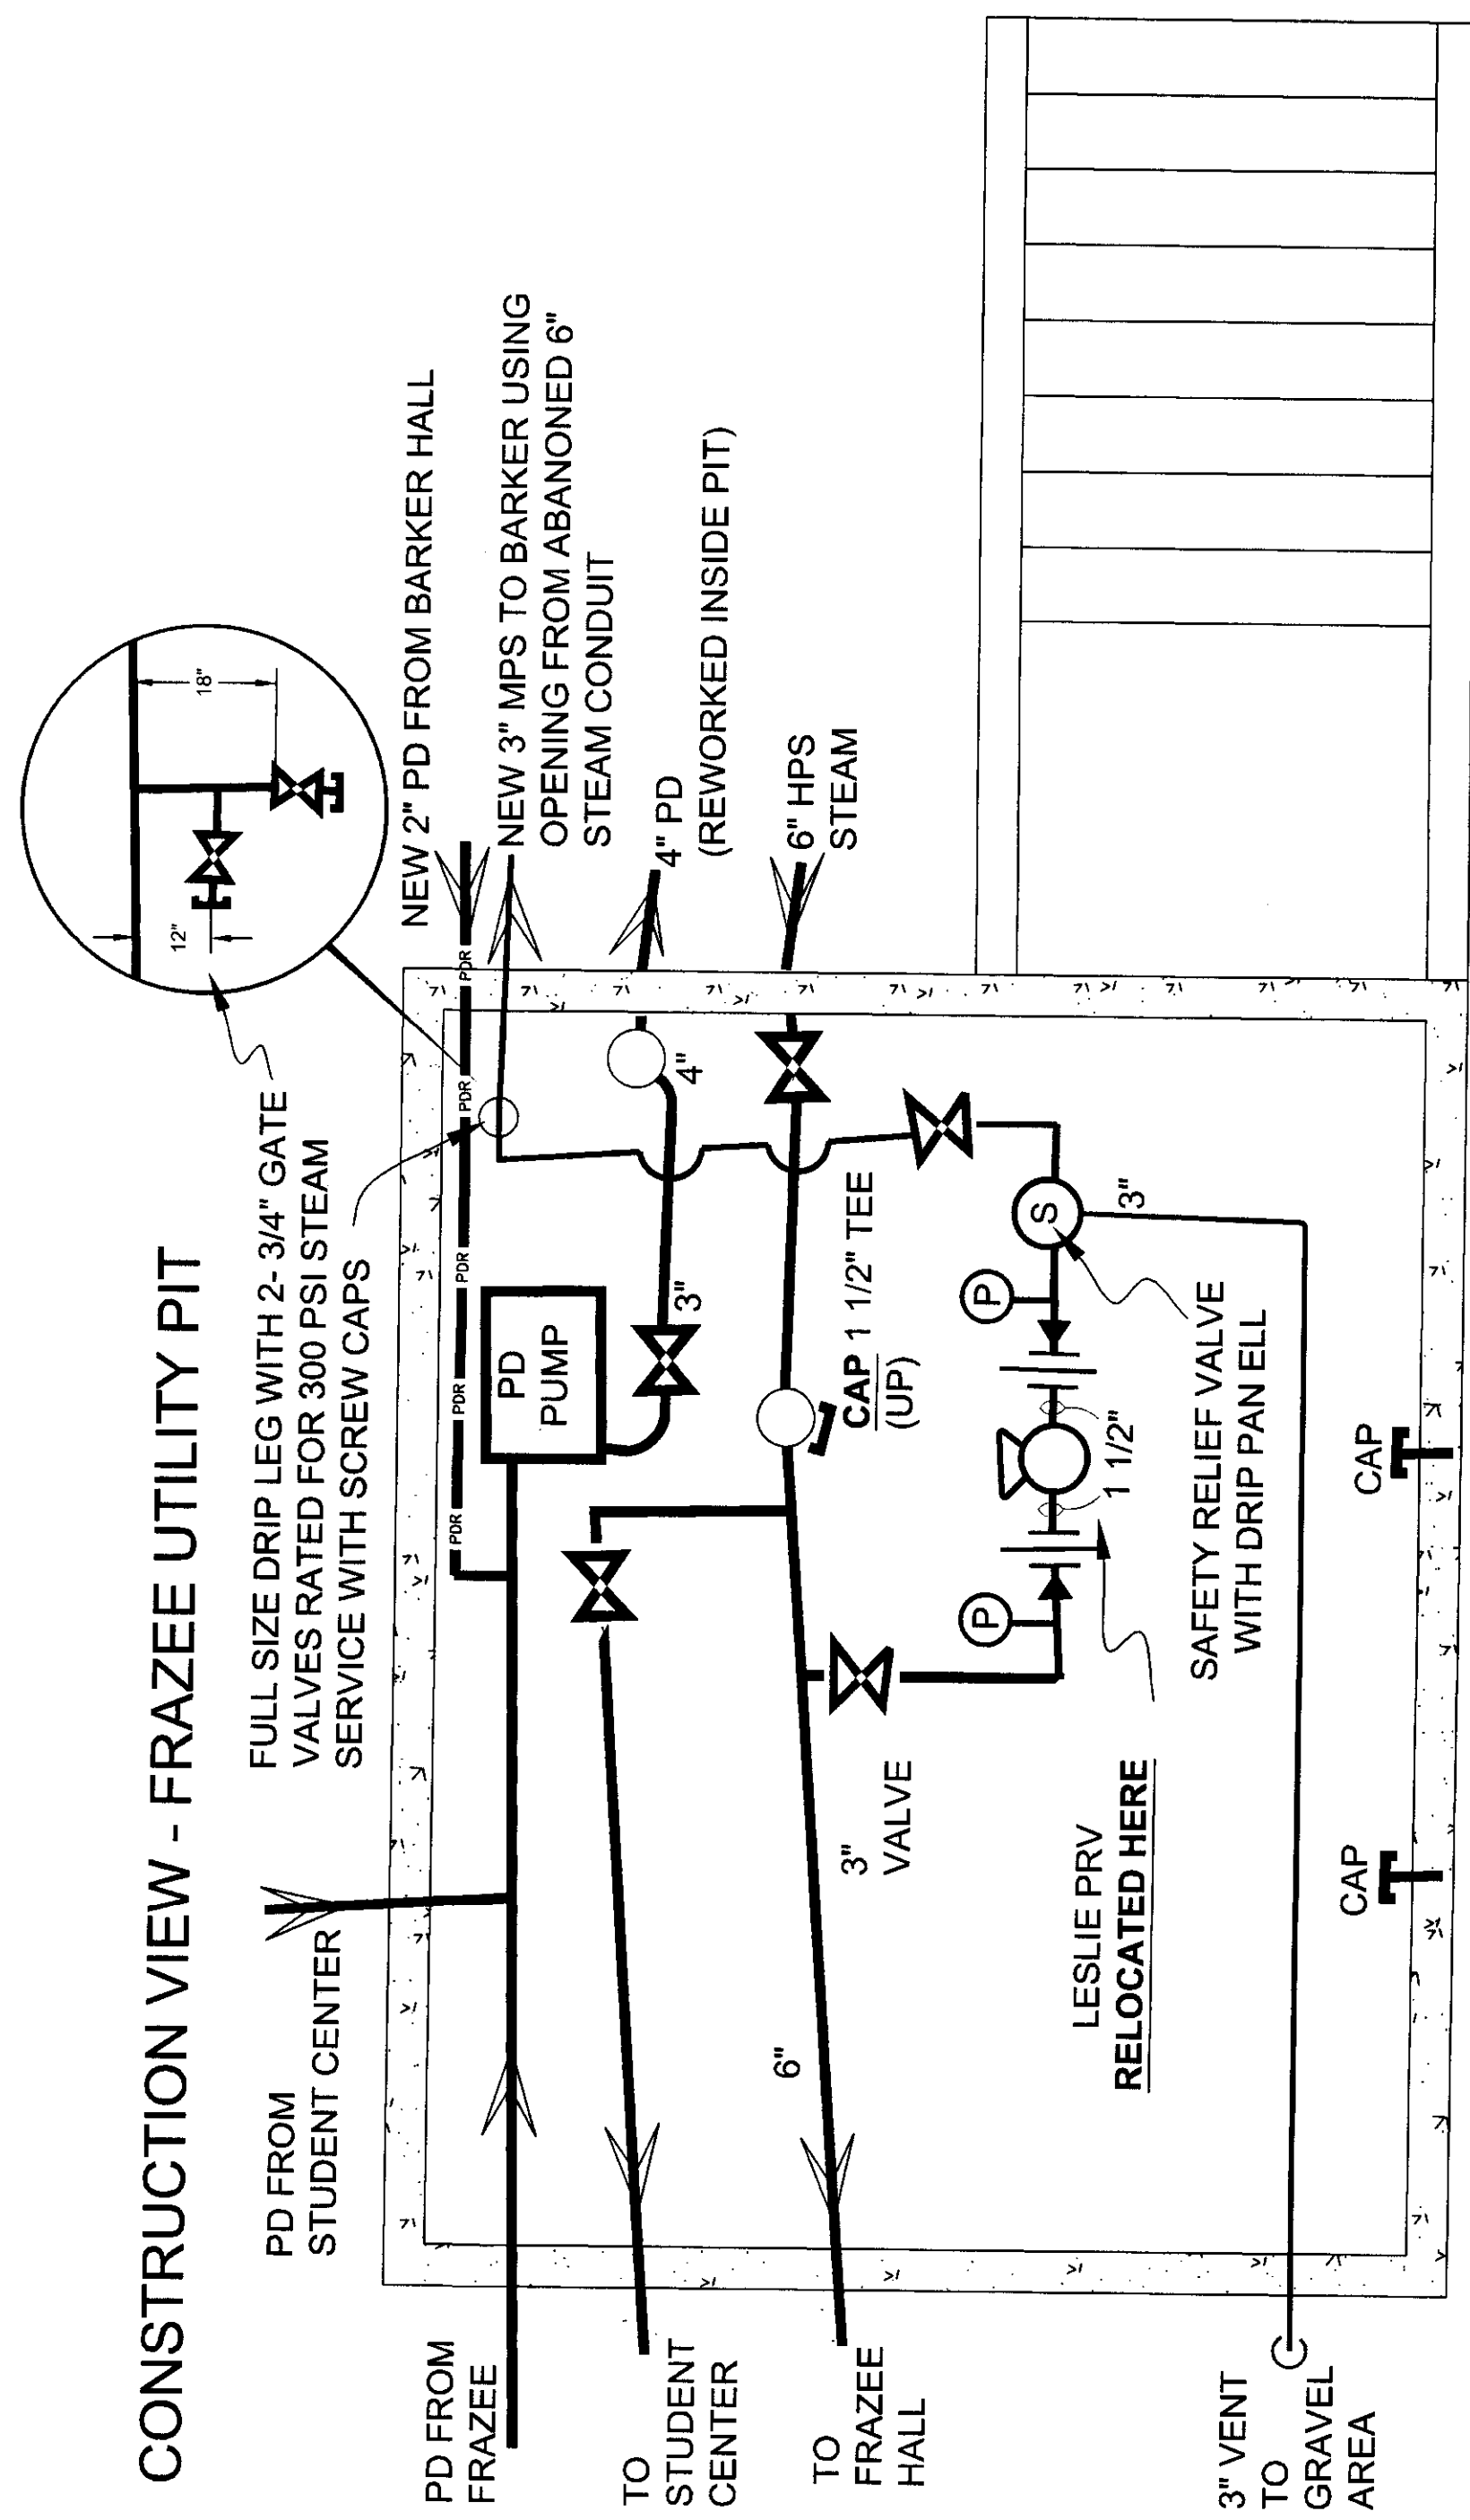

CONSTRUCTION VIEW BARKER HALL CO-EED REST ROOM PIT STEAM CONNECTION DETAIL

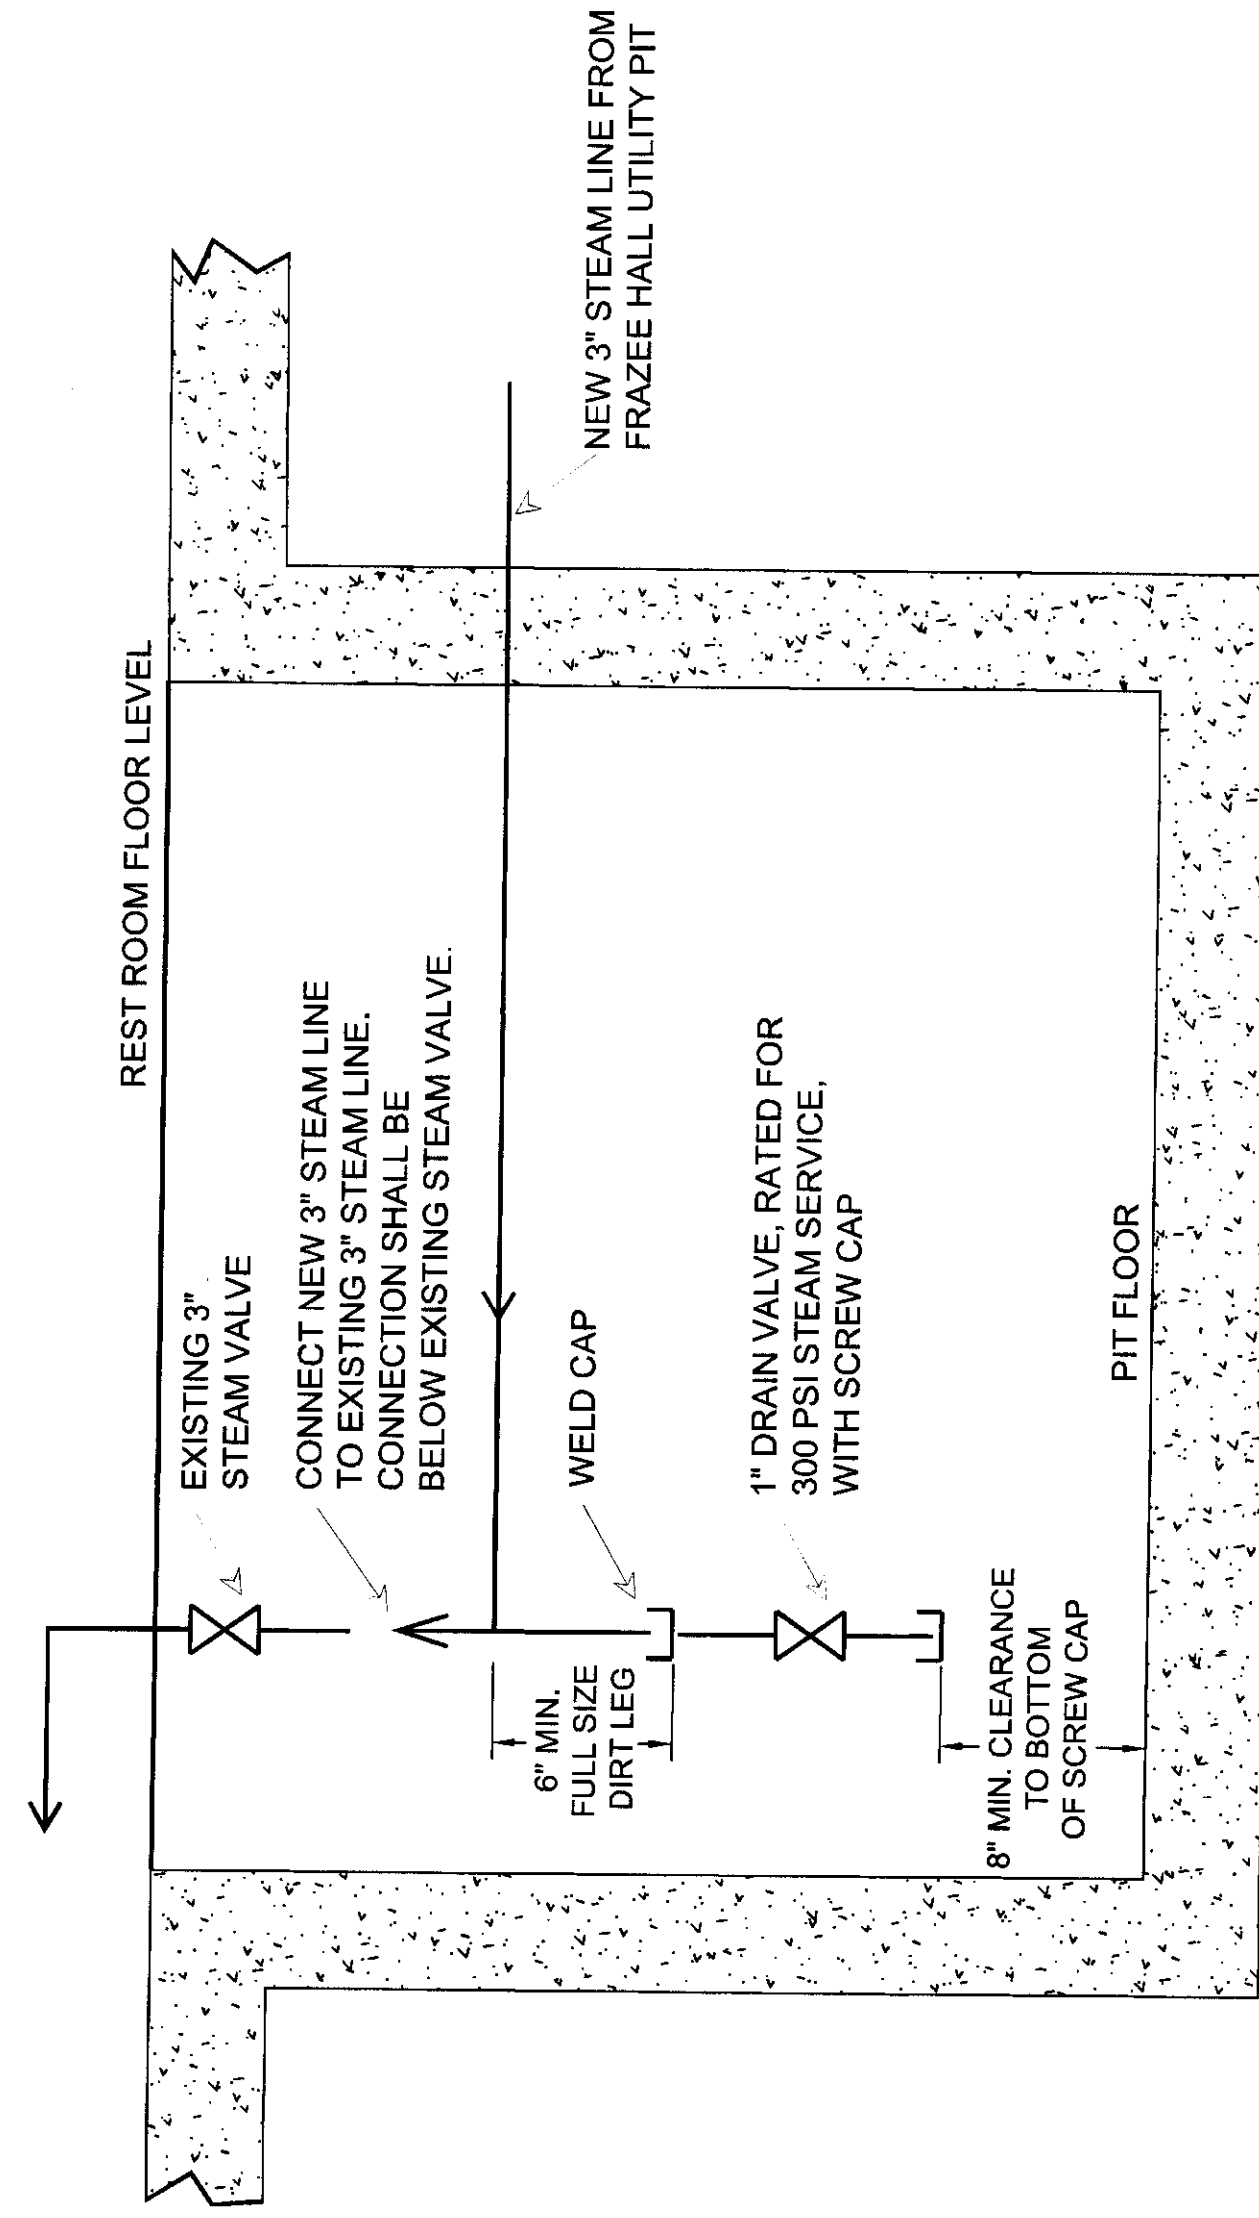

REVISIONS	BY:	DATE

DESIGNED BY: BSA
 DRAWN BY: BSA
 CHECKED BY:
 APPROVED BY:
 PROJECT NO.: 658347
 DATE: 08/10/07
 DRAWING NUMBER: 4 of 4
 Cab # Slot Document #

CONSTRUCTION SITE PIT DETAILS
BARKER- FRAZEE STEAM PIT CONNECTION
 BUILDING NUMBER: 028
 PROJECT CONSTRUCTION PIT & BARKER DETAILS