


FIRST FLOOR PLAN
SCALE 1/4" = 1'-0"

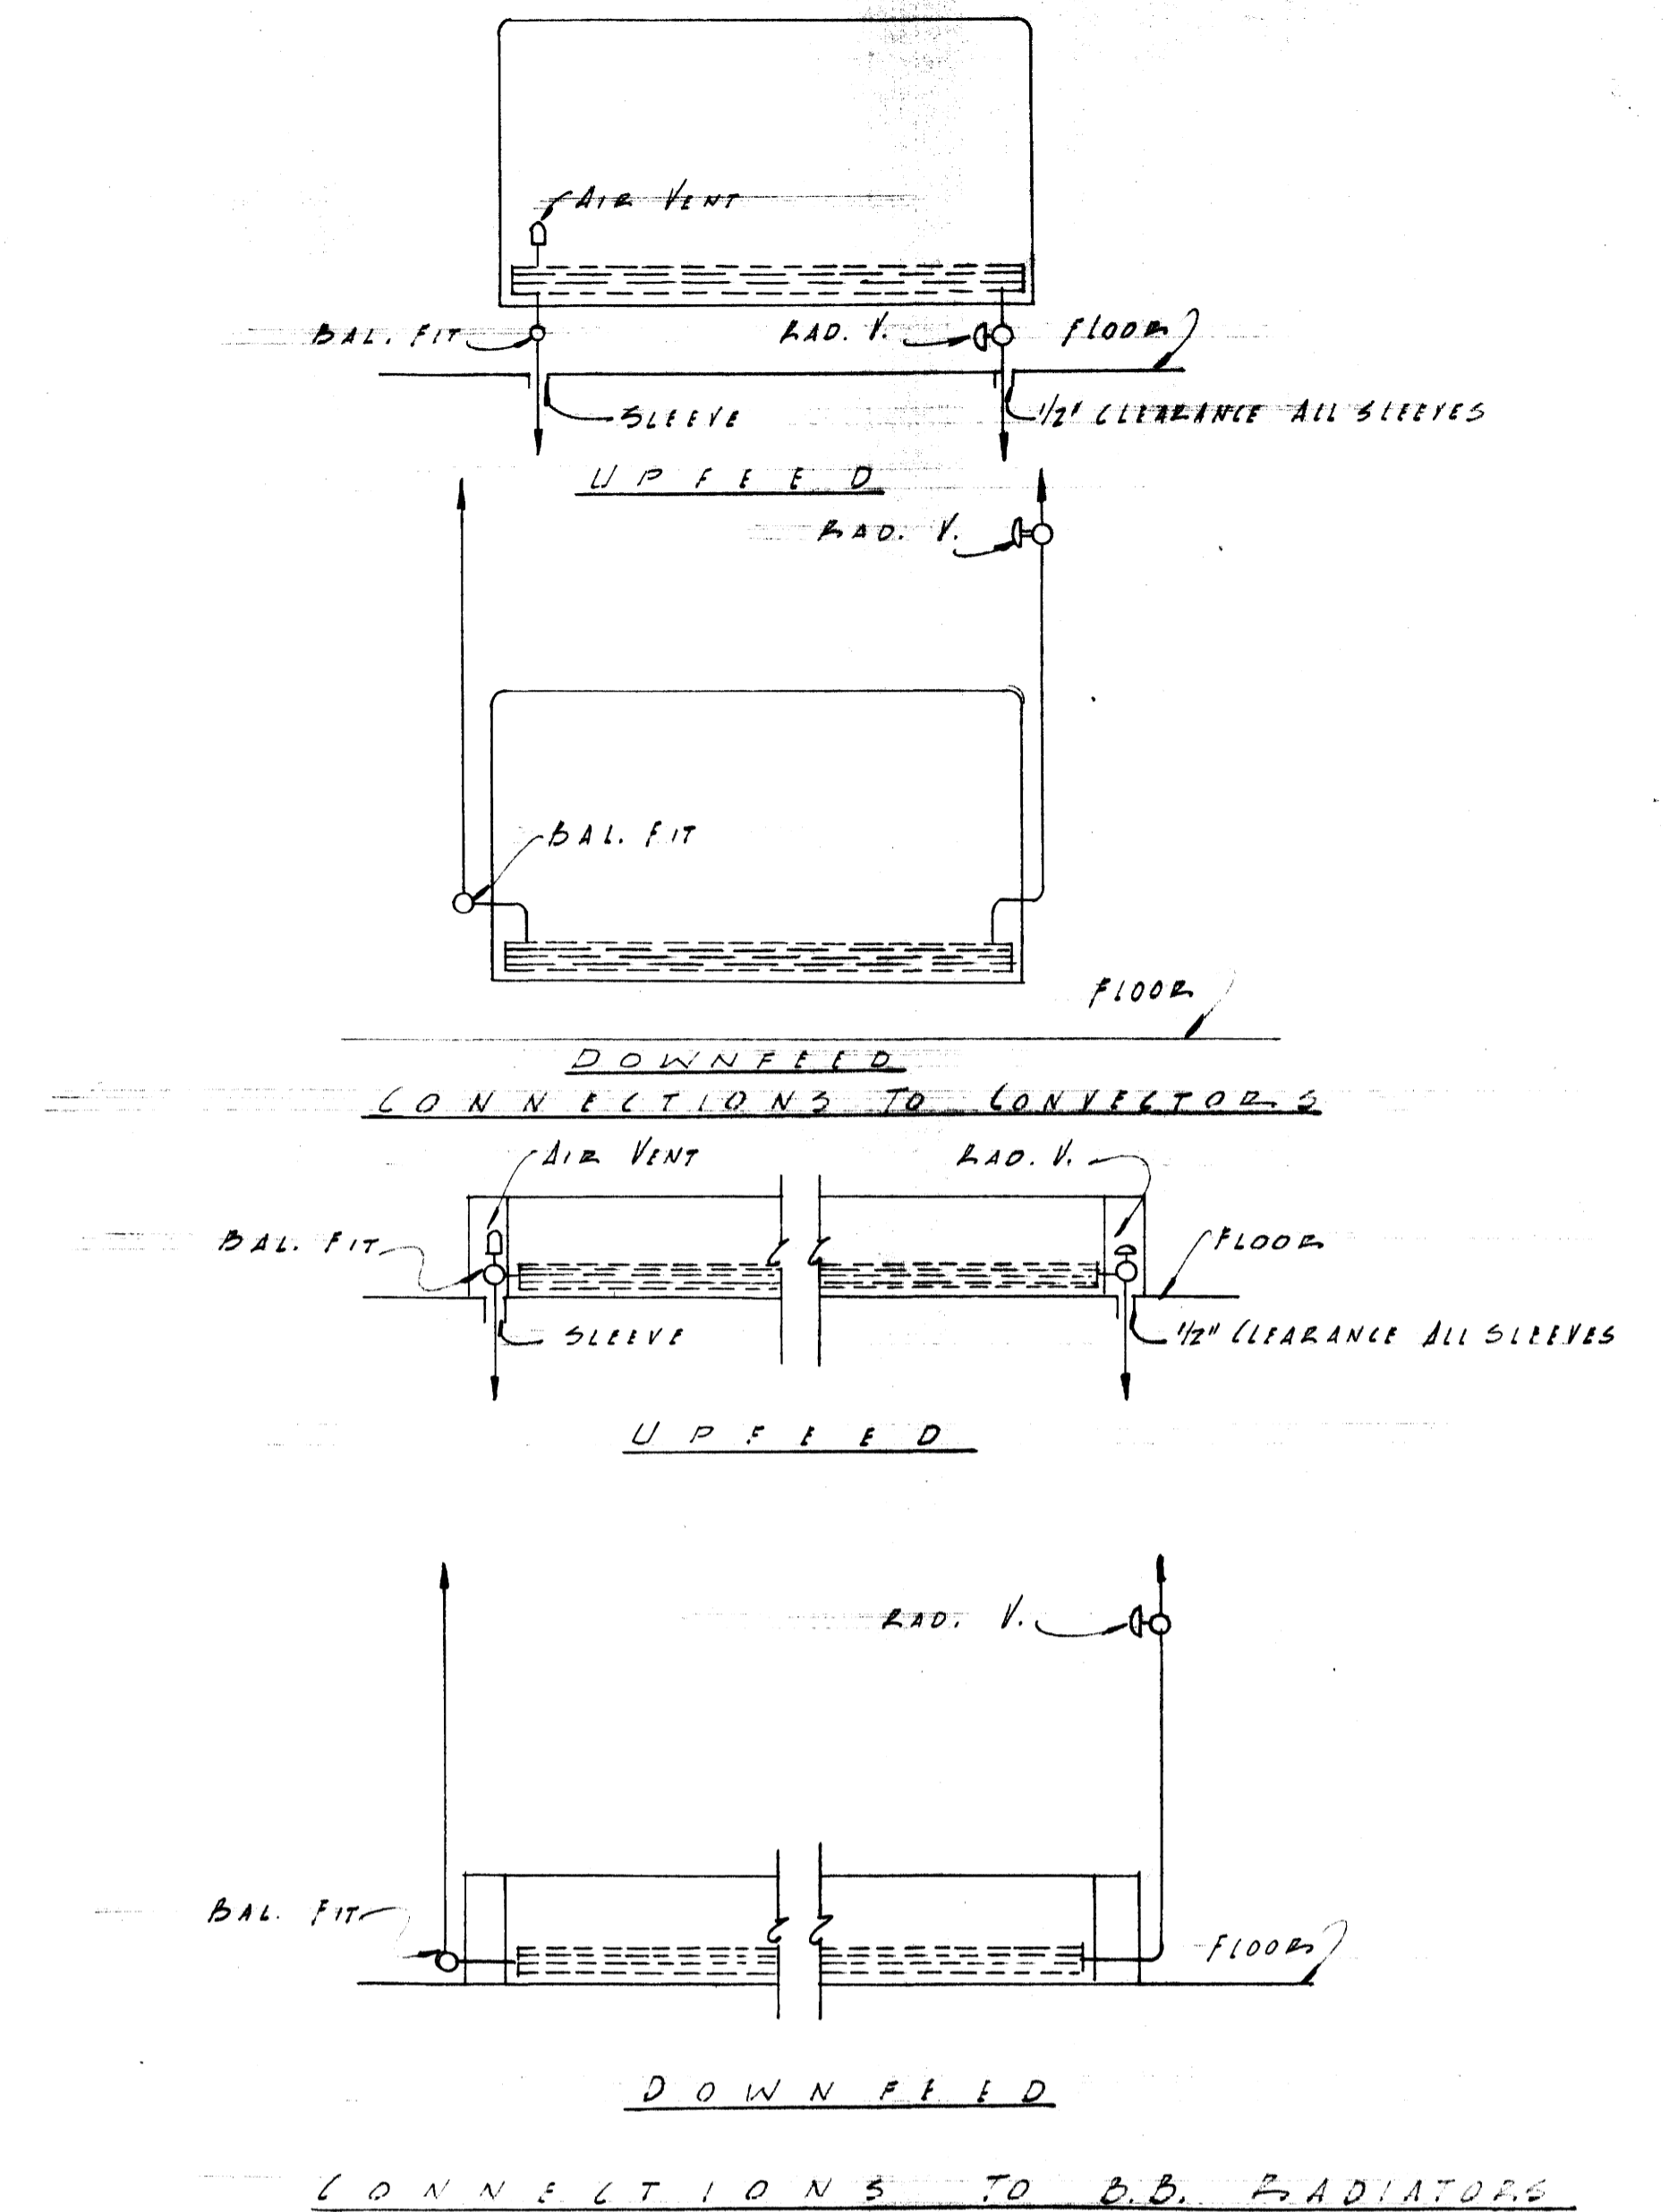

RUNOUTS AND RADIATOR CONNECTIONS		
UP FEED		
0 TO 10	M.B.H.	1/2"
11 TO 22	M.B.H.	3/4"
DOWN FEED		
RUNOUTS AND DROP RAISES:		
0 TO 10	M.B.H.	3/4"
11 TO 22	M.B.H.	1"
RADIATOR CONNECTIONS		
0 TO 10	M.B.H.	1/2"
11 TO 22	M.B.H.	3/4"

HEATING - BUILDING TYPE No. 2

SORORITY HOUSES FOR UNIVERSITY OF KENTUCKY

COMMONWEALTH OF KENTUCKY
DEPARTMENT OF FINANCE
FRANKFORT, KENTUCKY

JOHN T. GILLIG, ARCHITECT
ROBERT E. RADER, JR., DESIGNER, ASSOCIATED
180 WALNUT STREET LEXINGTON, KENTUCKY


APPROVALS
DATE 9-12-56
DRAWN BY EH EC
CHECKED BY TLF MC
DATE 9-12-56

DATE SEP 1 1956
DRAWN BY EH EC
CHECKED BY TLF MC

REVISIONS

SHEET NO.

M
14

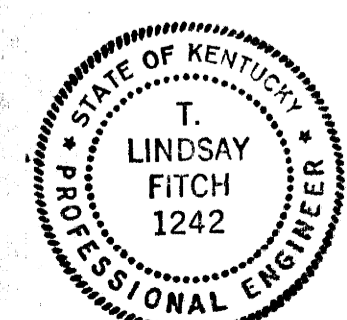

U-630