



1ST FLOOR LIGHTING PLAN-BLDG-0504
SCALE: 1/8" = 1'-0"


- SHEET NOTES:
- ① UP TO LIGHTS ON SECOND FLOOR, SEE PLAN THIS SHEET.
 - ② DOWN TO LIGHT SWITCH ON FIRST FLOOR, SEE PLAN THIS SHEET.
 - ③ FIXTURES IN THIS ROOM TO CLEAR PIPING, DUCTWORK EQUIP. ETC.
 - ④ ROUTE EXTERIOR LIGHTING CIRCUIT THROUGH A PHOTOCELL CONTROLLED LIGHTING CONTACTOR. (SEE EXTERIOR LIGHTING CONTROL DIAGRAM THIS SHEET.)

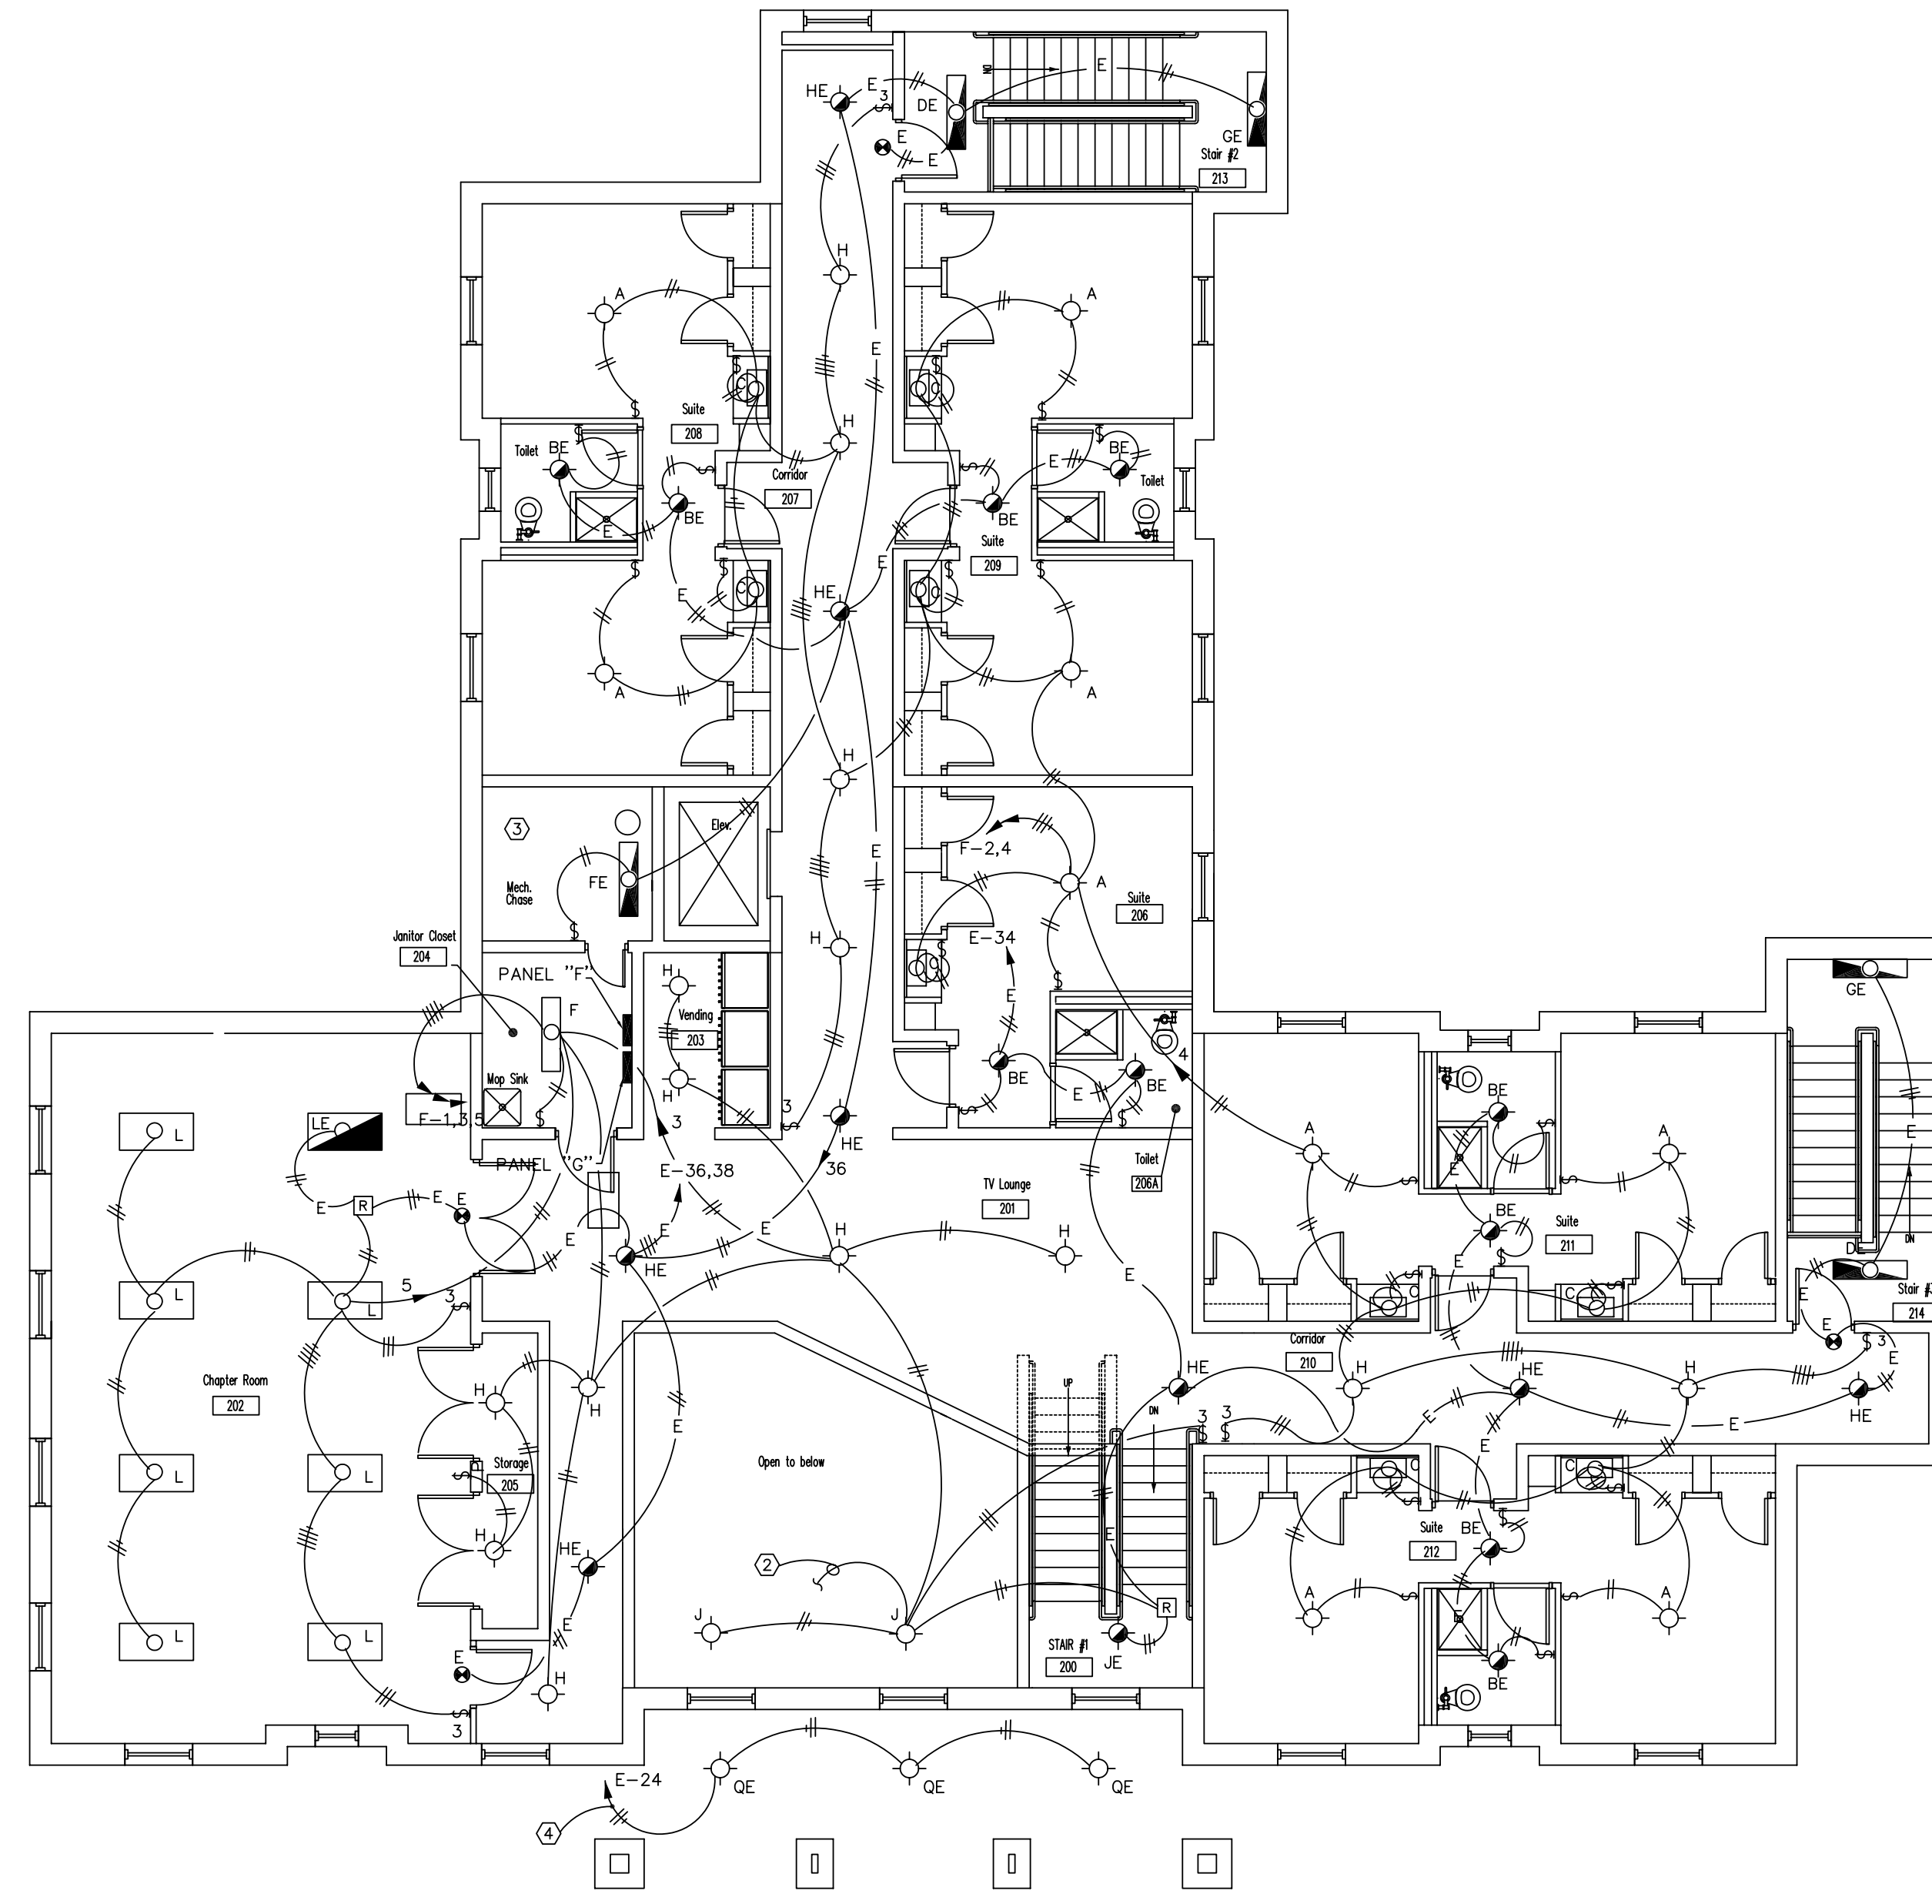


2ND FLOOR LIGHTING PLAN-BLDG-0504
SCALE: 1/8" = 1'-0"

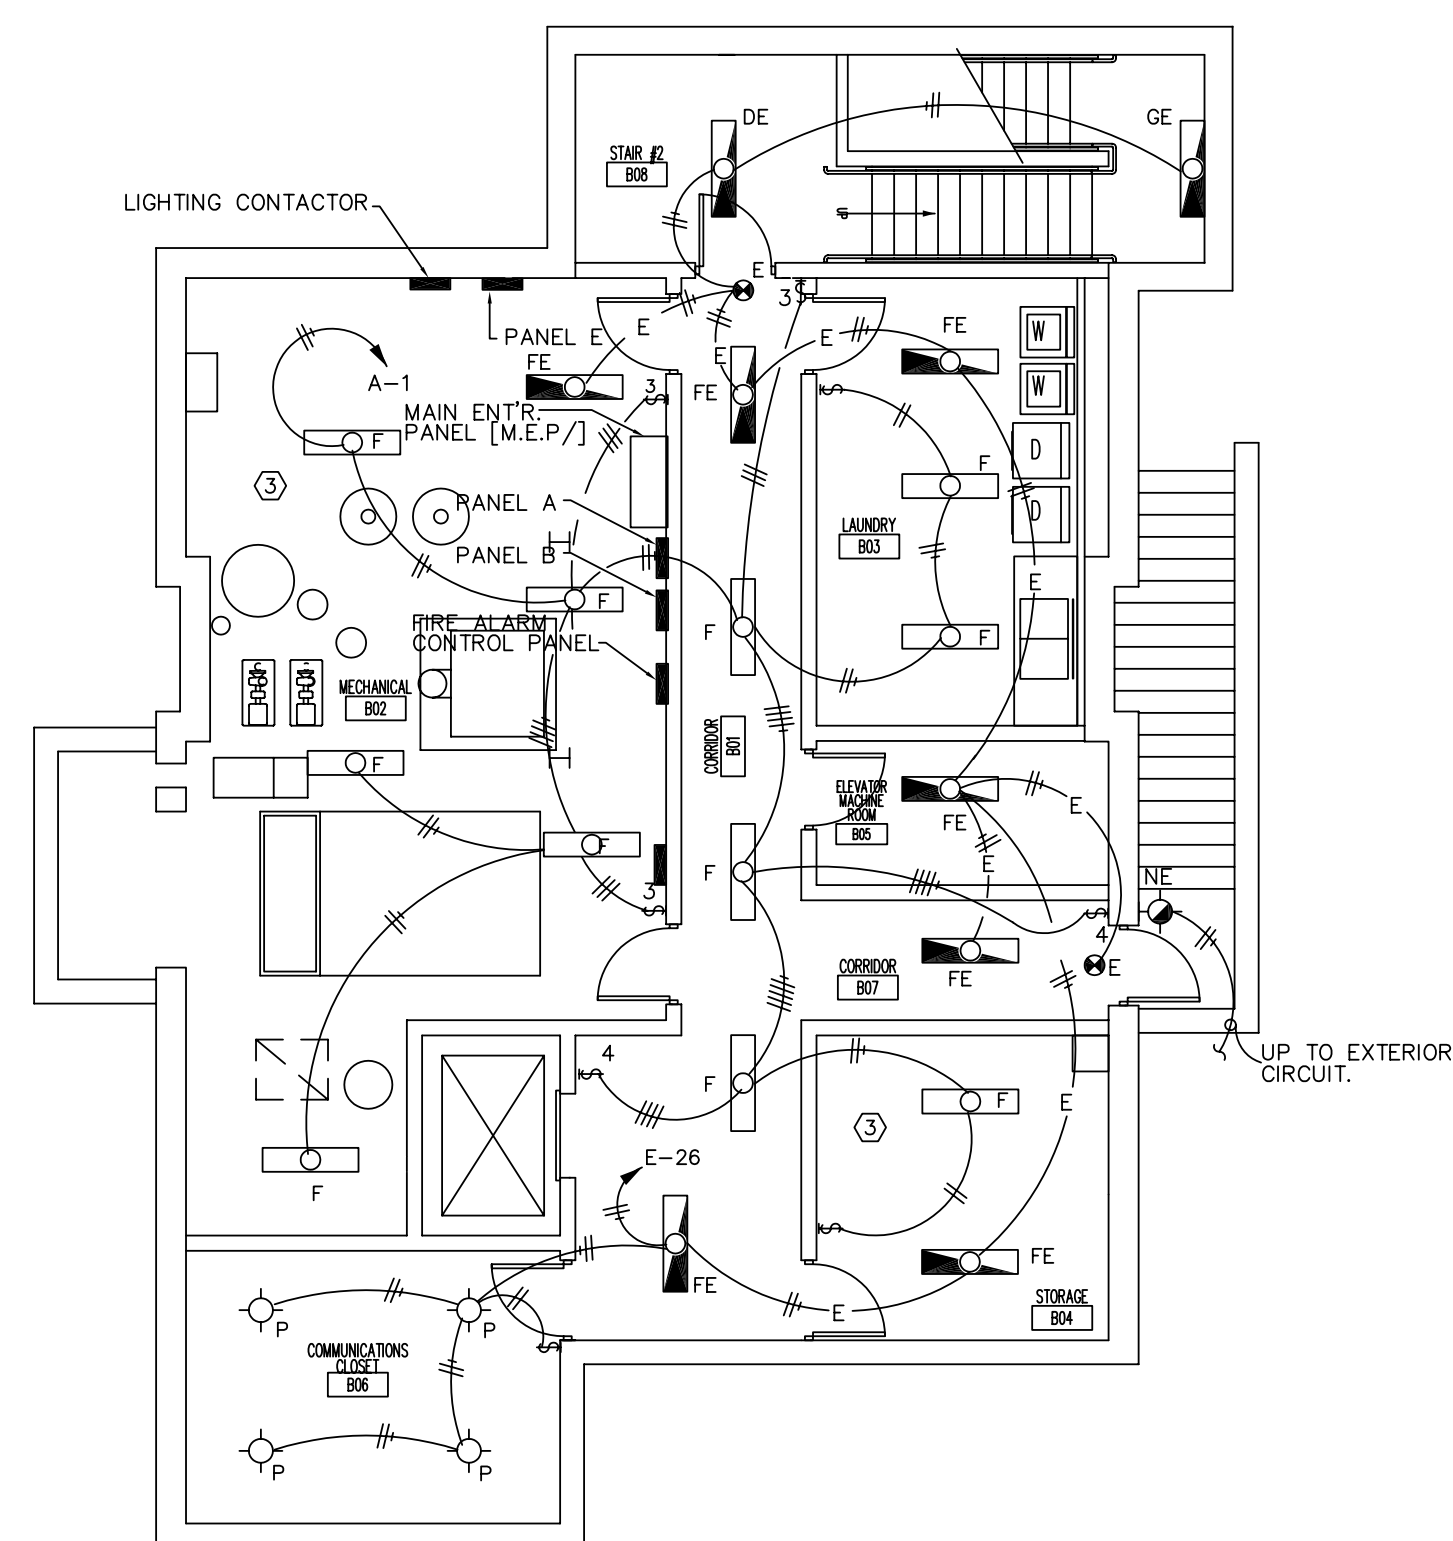

BASEMENT LIGHTING PLAN-BLDG-0504
SCALE: 1/8" = 1'-0"

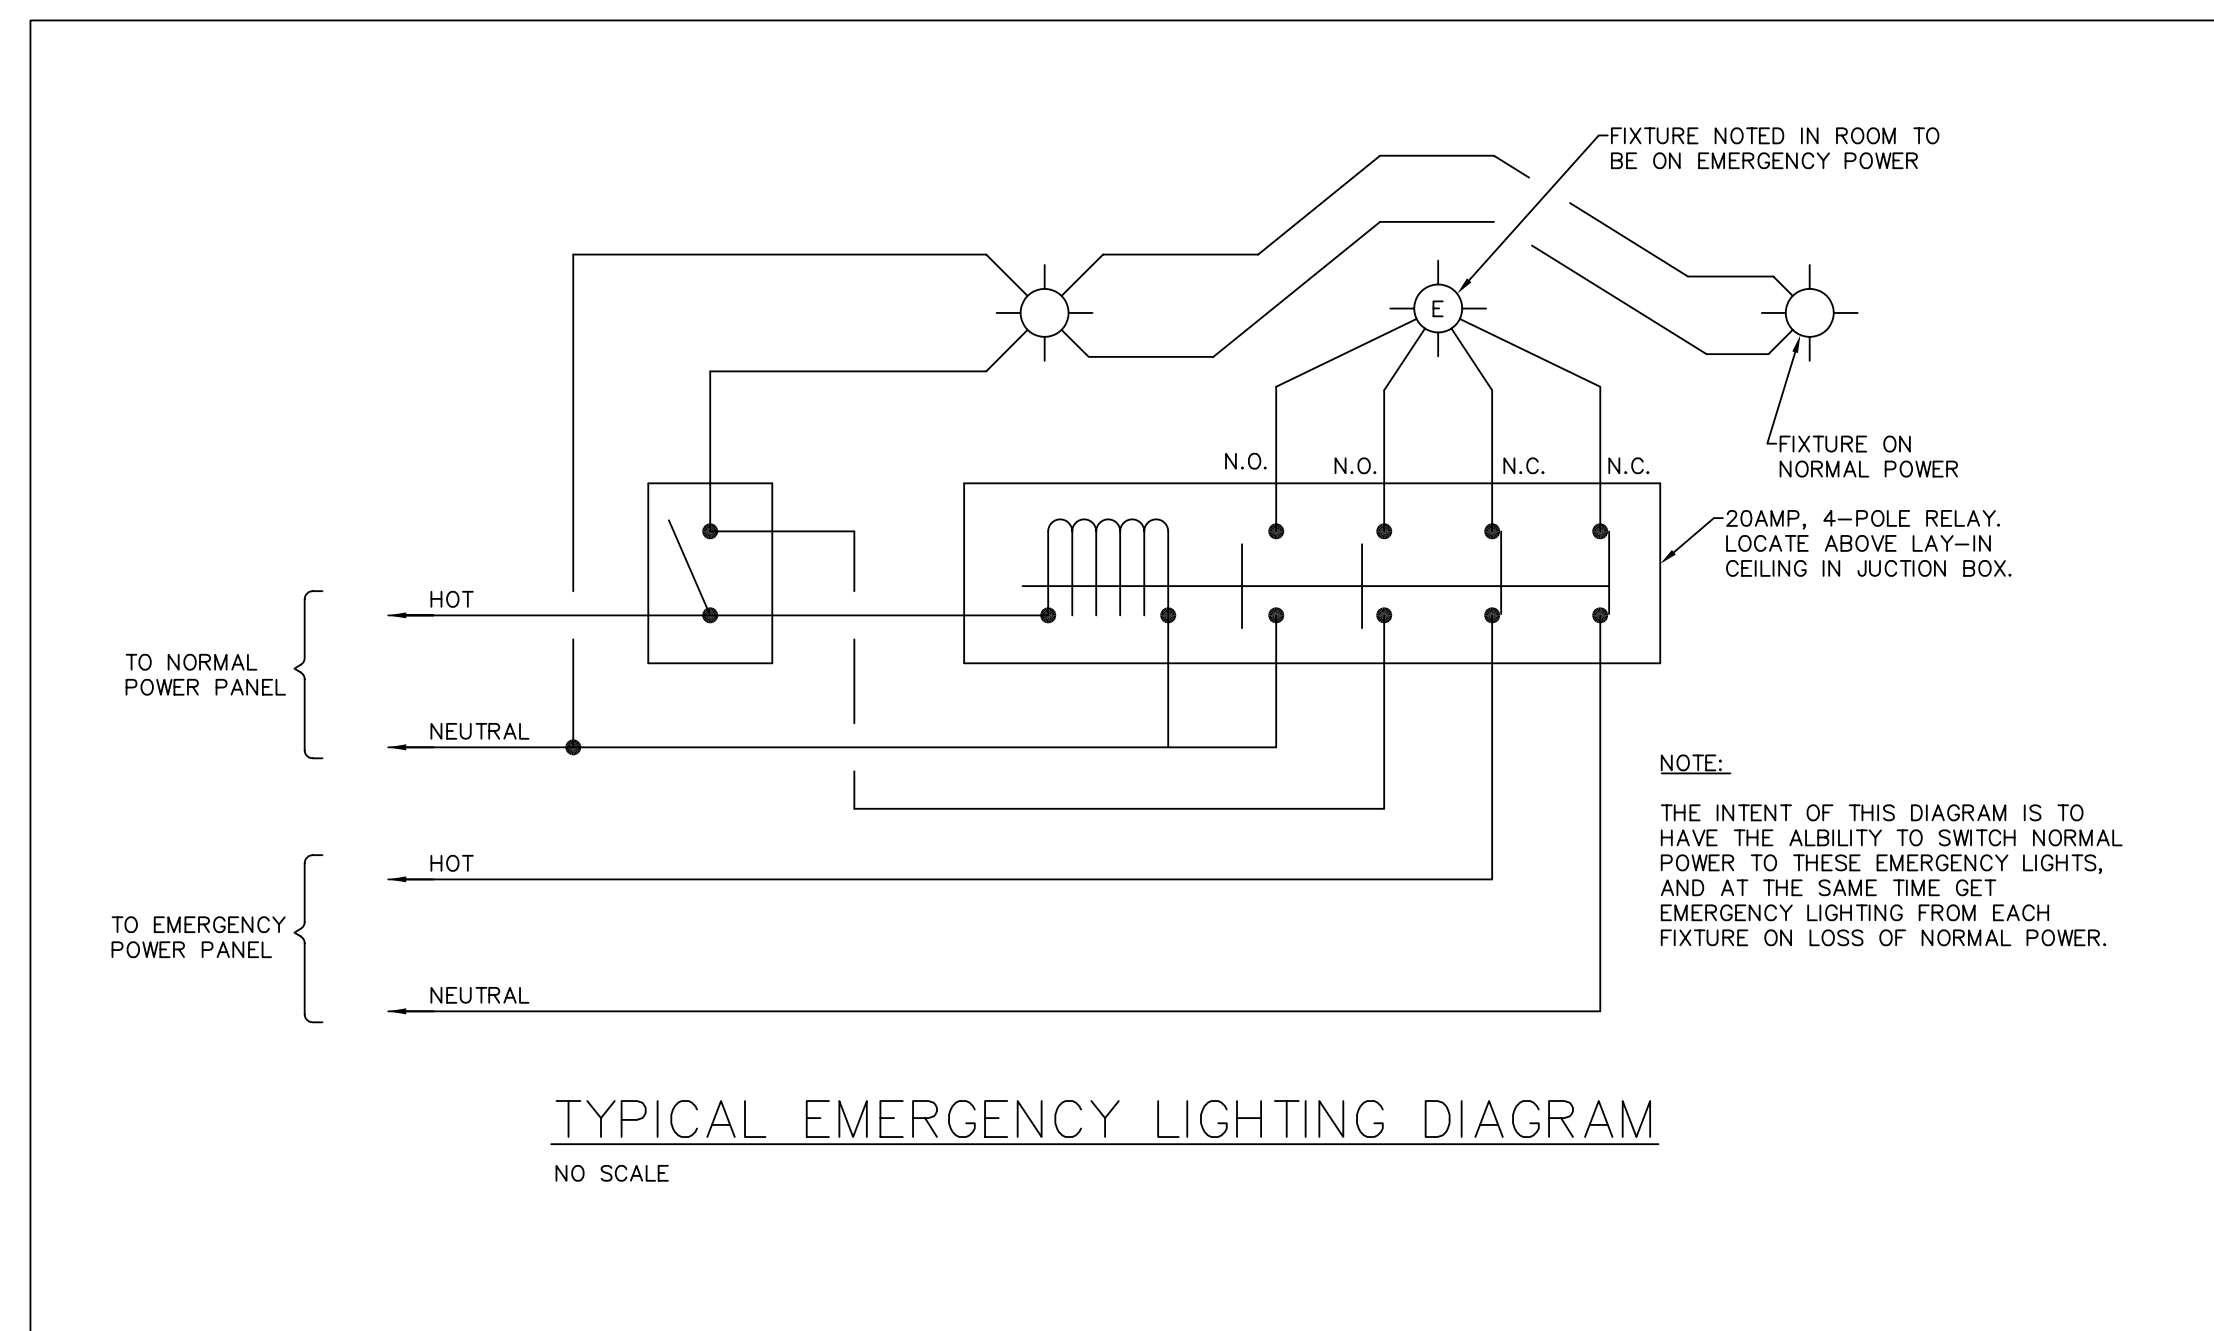

BASEMENT, FIRST AND SECOND FLOOR PLANS - BLDG. 0504 - LIGHTING
SCALE: 1/8" = 1'-0"

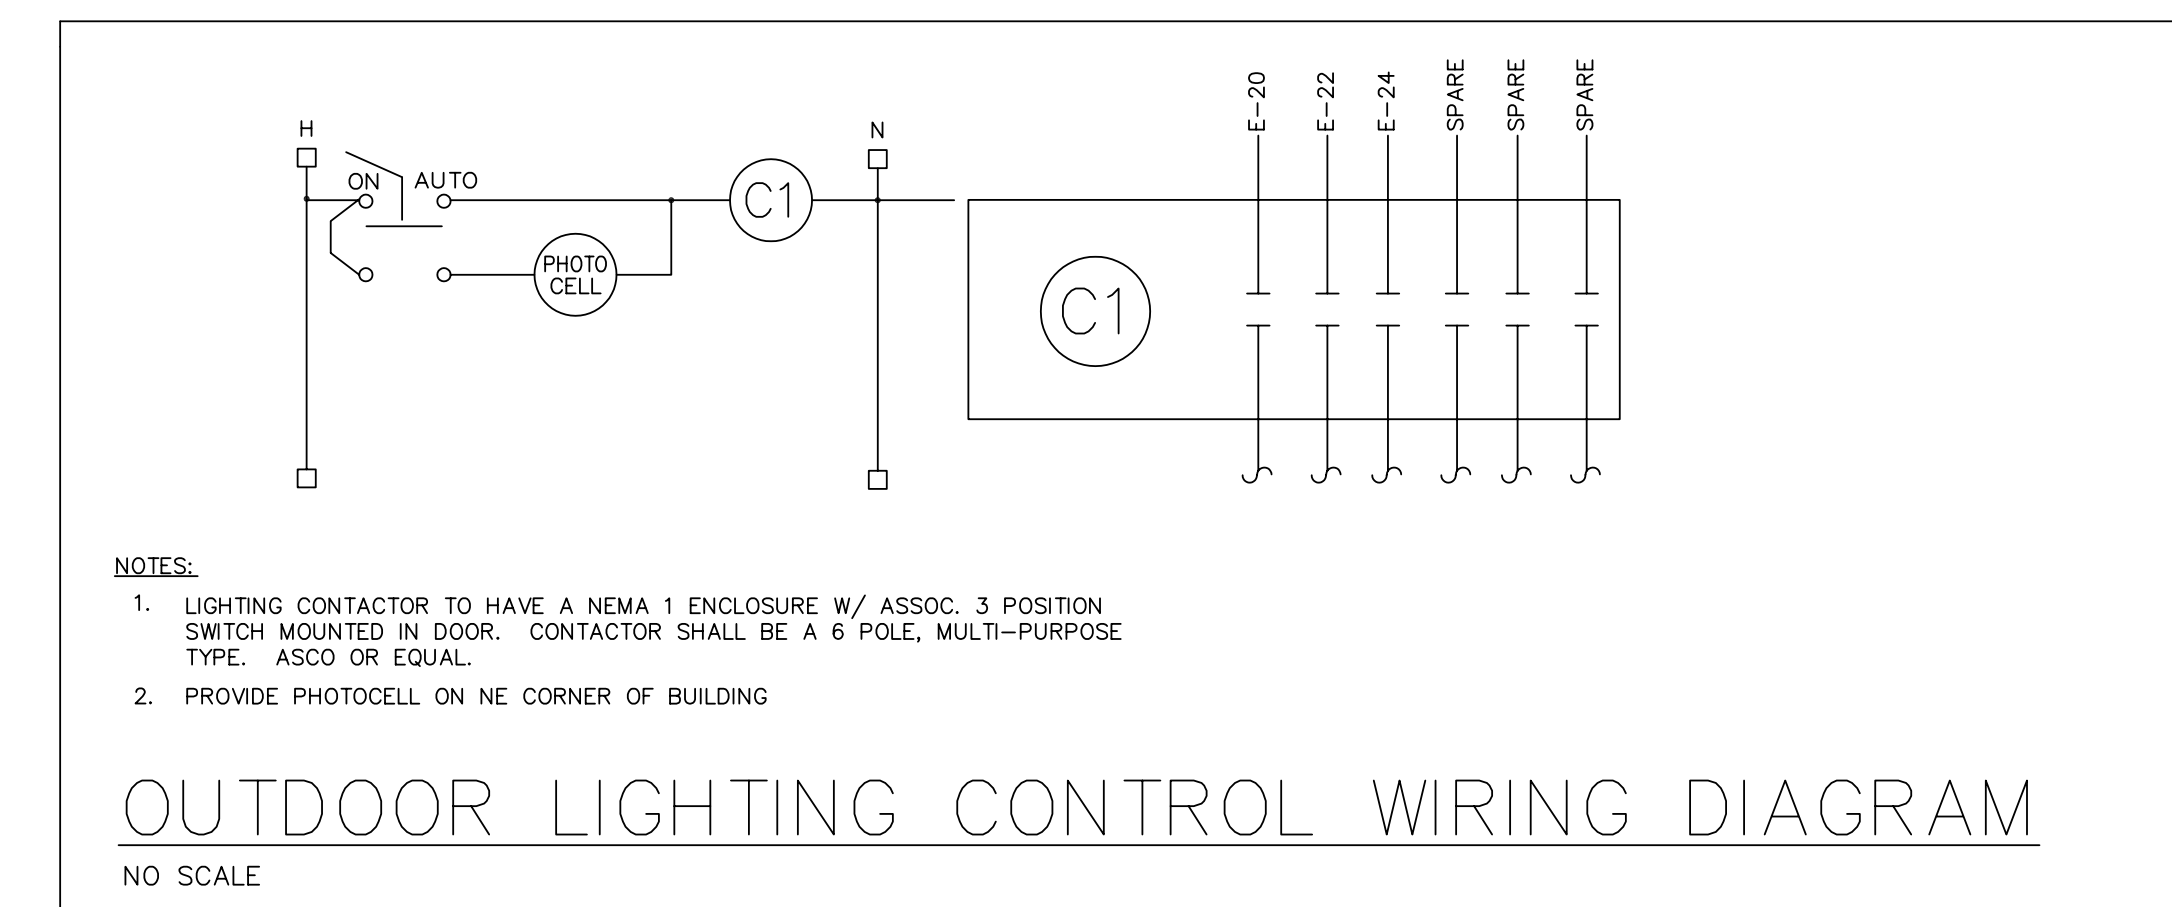

OUTDOOR LIGHTING CONTROL WIRING DIAGRAM
NO SCALE

REVISED SET
THIS DRAWING HAS BEEN REVISED TO REFLECT REVISIONS MADE BY THE ENGINEER DURING CONSTRUCTION.
ADAMS-FRAZIER-ANDERSON INC.
CONSULTING ENGINEERS
BY: _____
DATE: _____