
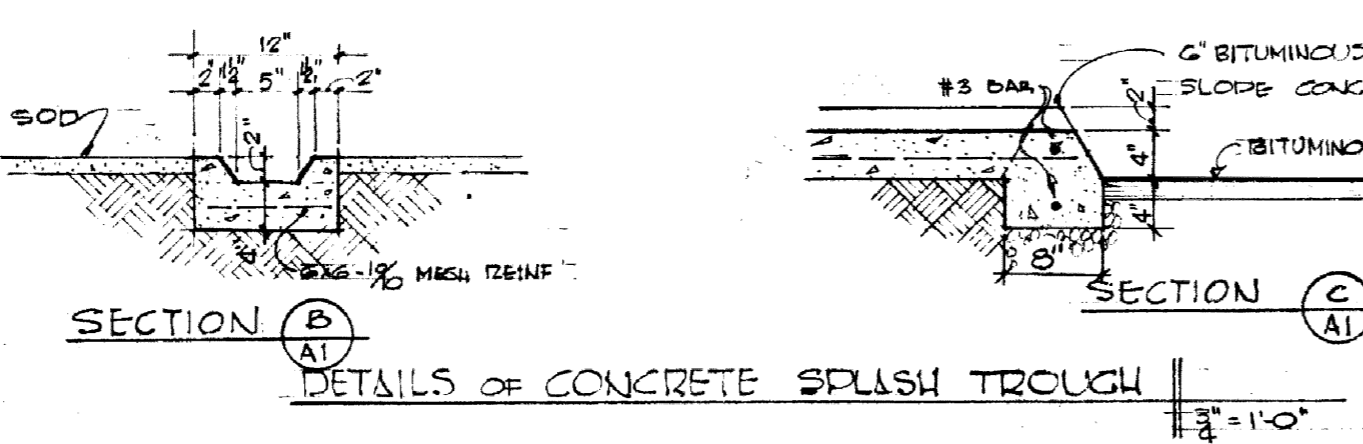



MATERIALS INDICATION		LIST OF DRAWINGS	
[Symbol]	CONCRETE IN SECTION	00. SH. NO.	SHEET TITLE
[Symbol]	CONCRETE BLOCK	A1	PLOT PLAN - SYMBOLS
[Symbol]	DRYWALL PART. IN PLAN	A2	BASEMENT PLAN - DETAILS
[Symbol]	BRICK	A3	FIRST FLOOR PLAN - DETAILS
[Symbol]	CERAMIC TILE	A4	SECOND FLOOR PLAN - DETAILS
[Symbol]	FIRE BRICK	A5	FRONT ELEVATION - DETAILS
[Symbol]	MARBLE	A6	END ELEVATIONS - DETAILS
[Symbol]	PLASTER OR GYPSUM B.D.	A7	REAR ELEVATION - FIREPLACE
[Symbol]	WOOD	A8	OMITTED
[Symbol]	PLYWOOD	A9	SECTION - PORTICO DETAILS
[Symbol]	METAL (LARGE SECTION)	A10	ROOM FINISH, DOOR & FRAME SCHED.
[Symbol]	METAL (SMALL SECTION)	A11	WINDOW DETAILS - STAIR SECTION
[Symbol]	ACOUSTICAL MATERIAL		
[Symbol]	RIGID INSULATION		
[Symbol]	EARTH IN SECTION		
SYMBOLS			
[Symbol]	SECTION (DETAIL) MARK		
[Symbol]	SHEET SECTION DETAILED ON		
[Symbol]	DETAIL REFERENCE		
[Symbol]	CROSS SECTION		
[Symbol]	ROOM NUMBER		
[Symbol]	DOOR NUMBER		
[Symbol]	WINDOW TYPE & STYLE		
[Symbol]	WINDOW INDICATION		
[Symbol]	HEAD JAMB & SILL COND.		

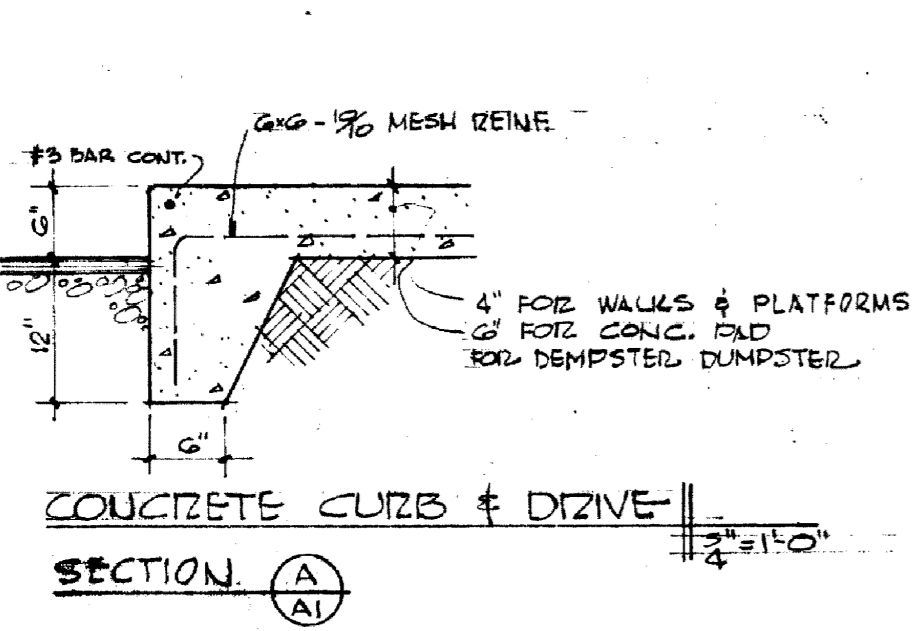

ROOF & PLOT PLAN
NOTE: SODDING N.I.C.






LEGEND

77.25	EXISTING GRADE
74.00	FINISH GRADE
W	WATER
G	GAS
S	SANITARY SEWER
SS	STORM SEWER
BT	ELECTRIC & TELEPHONE
N.I.C.	NOT IN THIS CONTRACT
I.T.C.	INCLUDED IN THIS CONTRACT


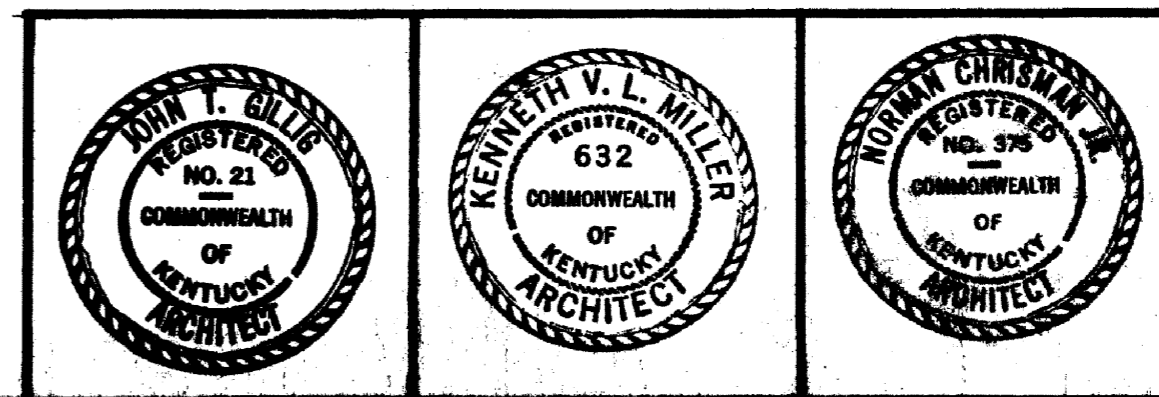


APPROVED FOR GILLIG-CHRISMAN & MILLER
Norman Chisman, Jr. 1-8-63
PLOT PLAN - SYMBOLS
DELTA GAMMA SORORITY HOUSE
 UNIVERSITY OF KENTUCKY
 LEXINGTON, KENTUCKY
 DRAWN BY NG CH ARCHITECTURAL DATE 1-8-63
 TRACED BY PP GILLIG • CHRISMAN & MILLER SCALE AS SHOWN
 CHECKED BY NC ARCHITECTS ASSOCIATED SPEC. NO.
 180 WALNUT STREET LEXINGTON, KENTUCKY
 REVISIONS COMMONWEALTH OF KENTUCKY DRAWING NO. A1
 DEPARTMENT OF FINANCE
 ENGINEERING STAFF
 FRANKFORT, KENTUCKY
 APPROVED BY *Frank Chisman* DATE 1-25-63
 APPROVED BY *Norman Chisman* DATE



U-1884

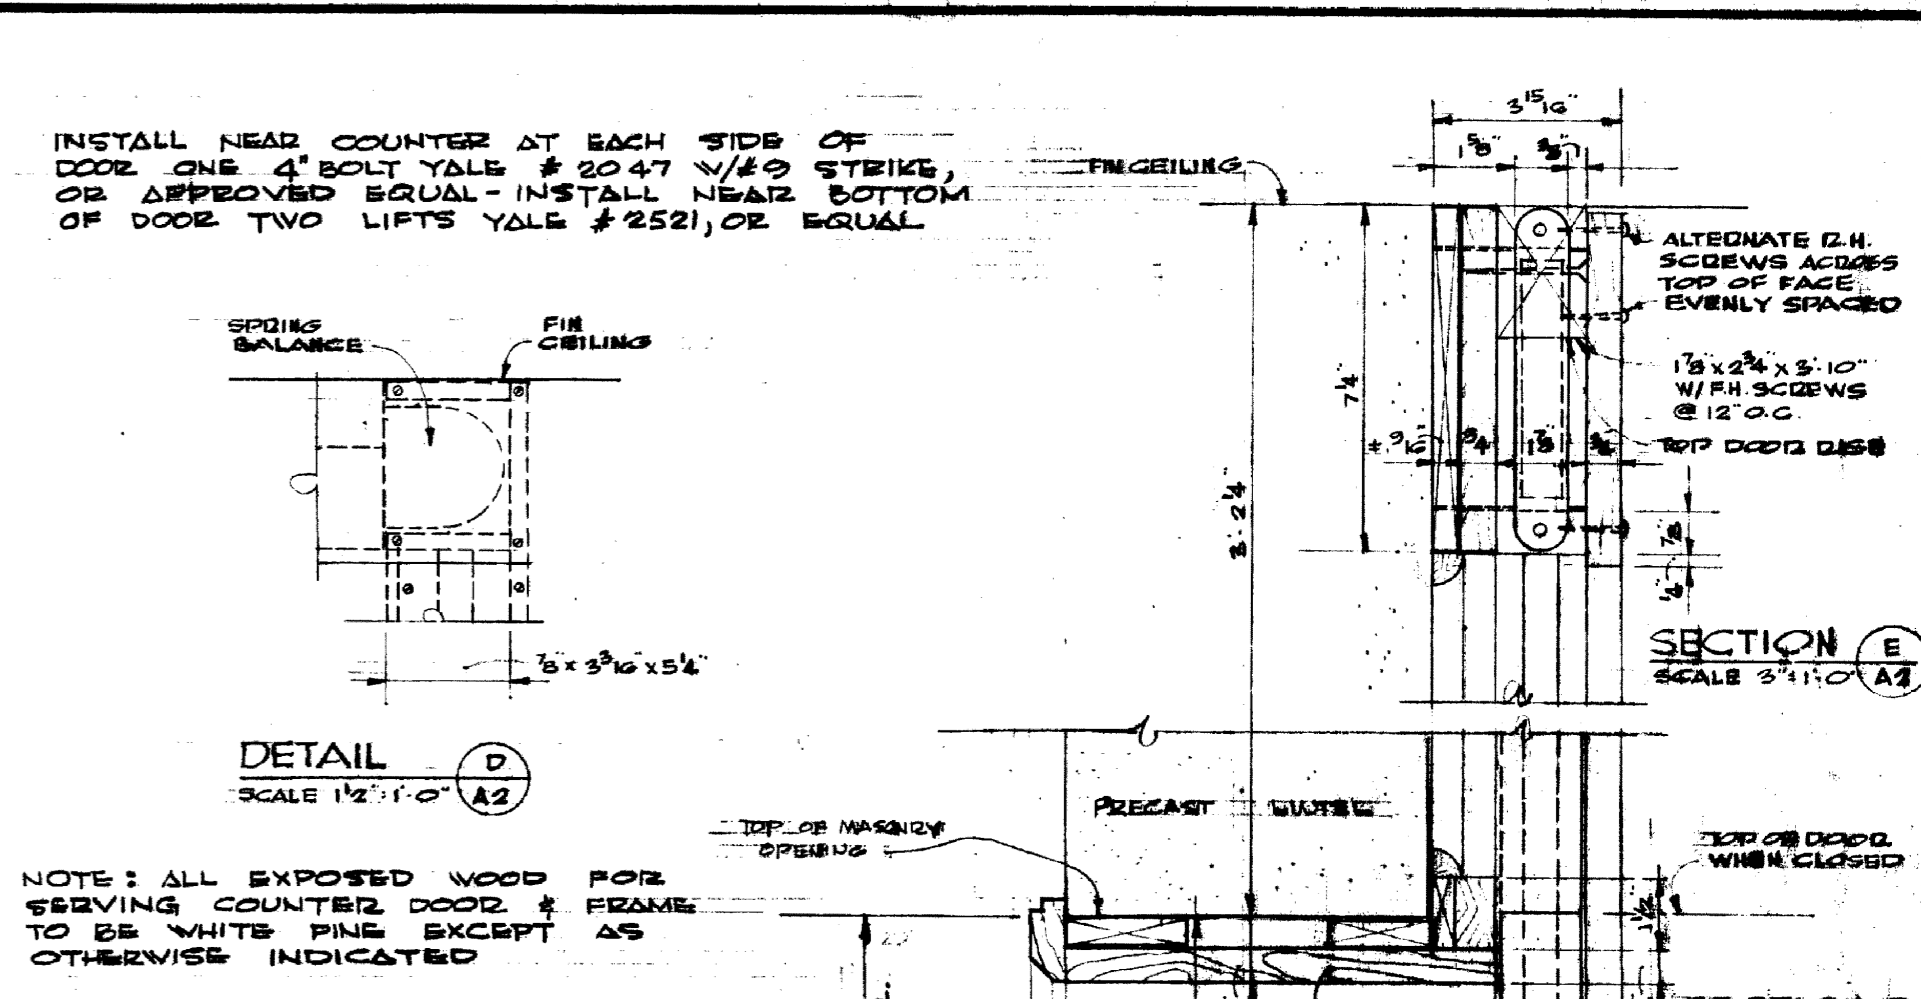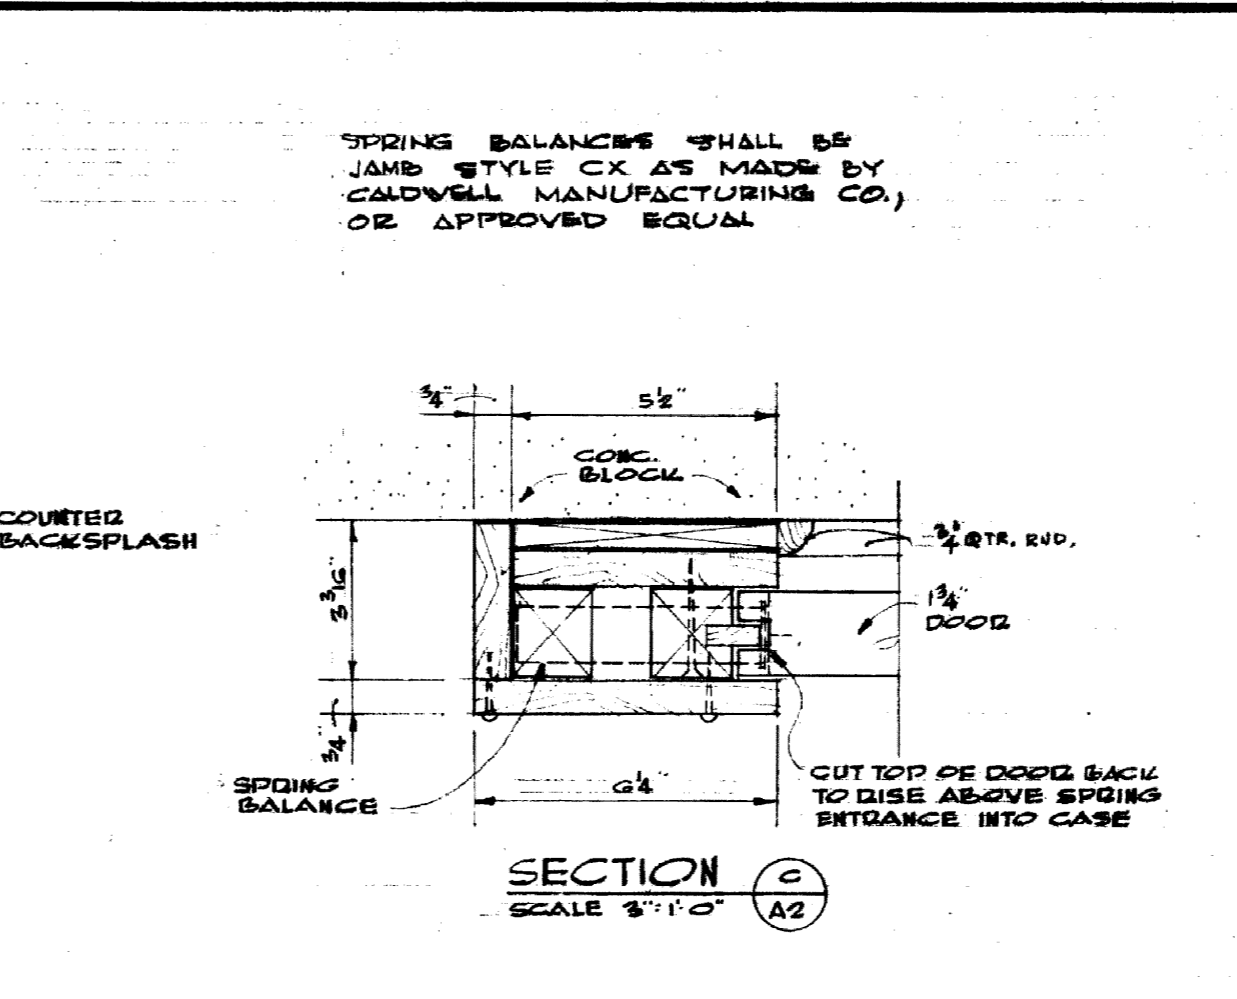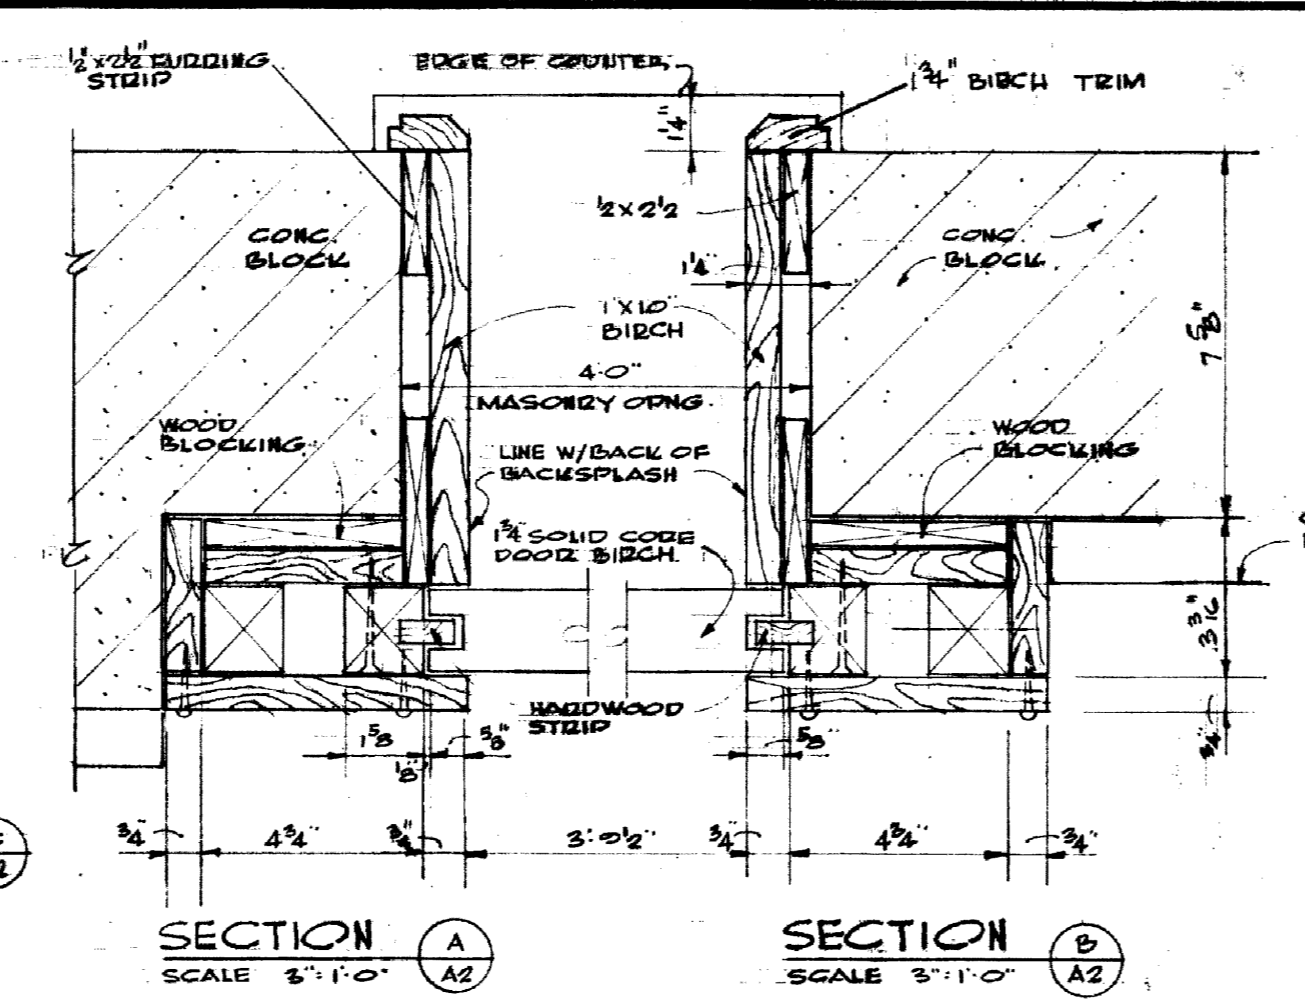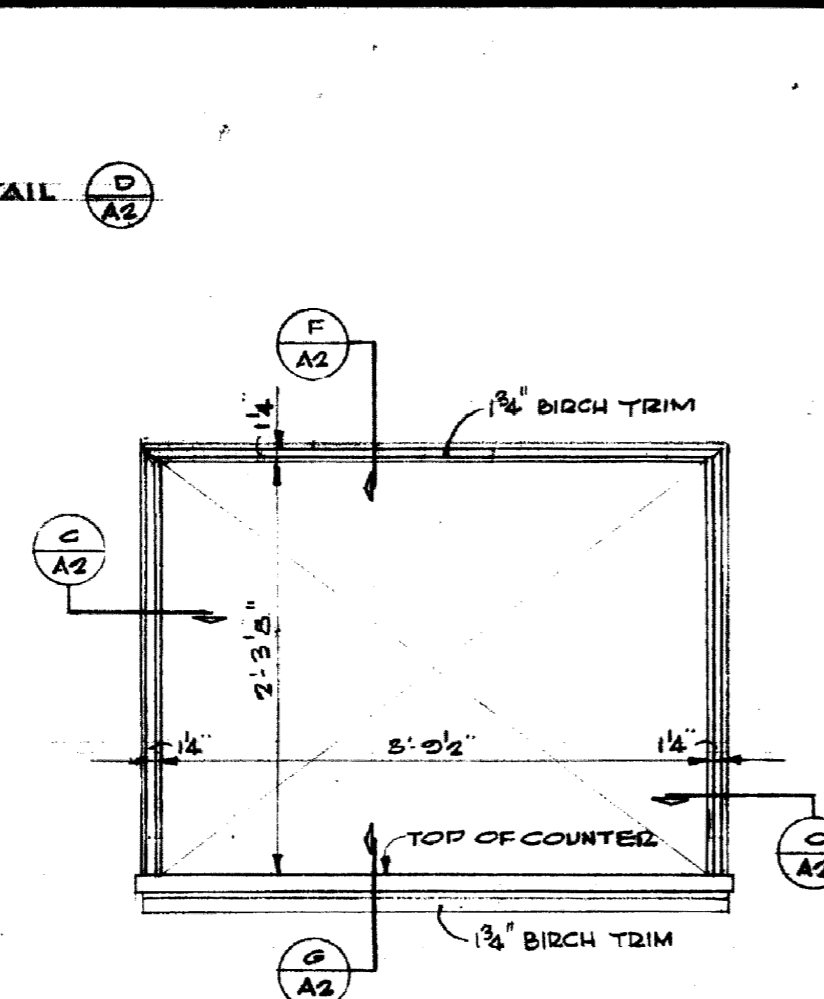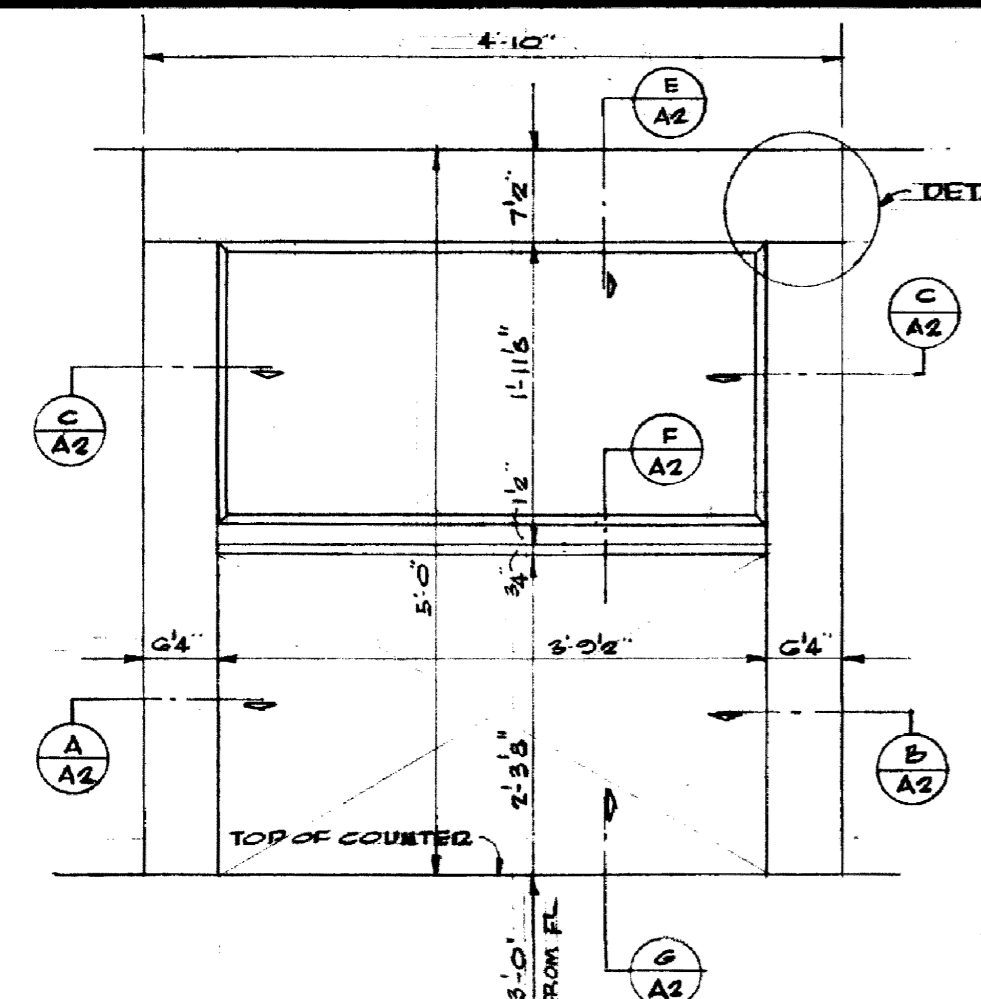

DETAILS KITCHEN SERVING COUNTER DOOR

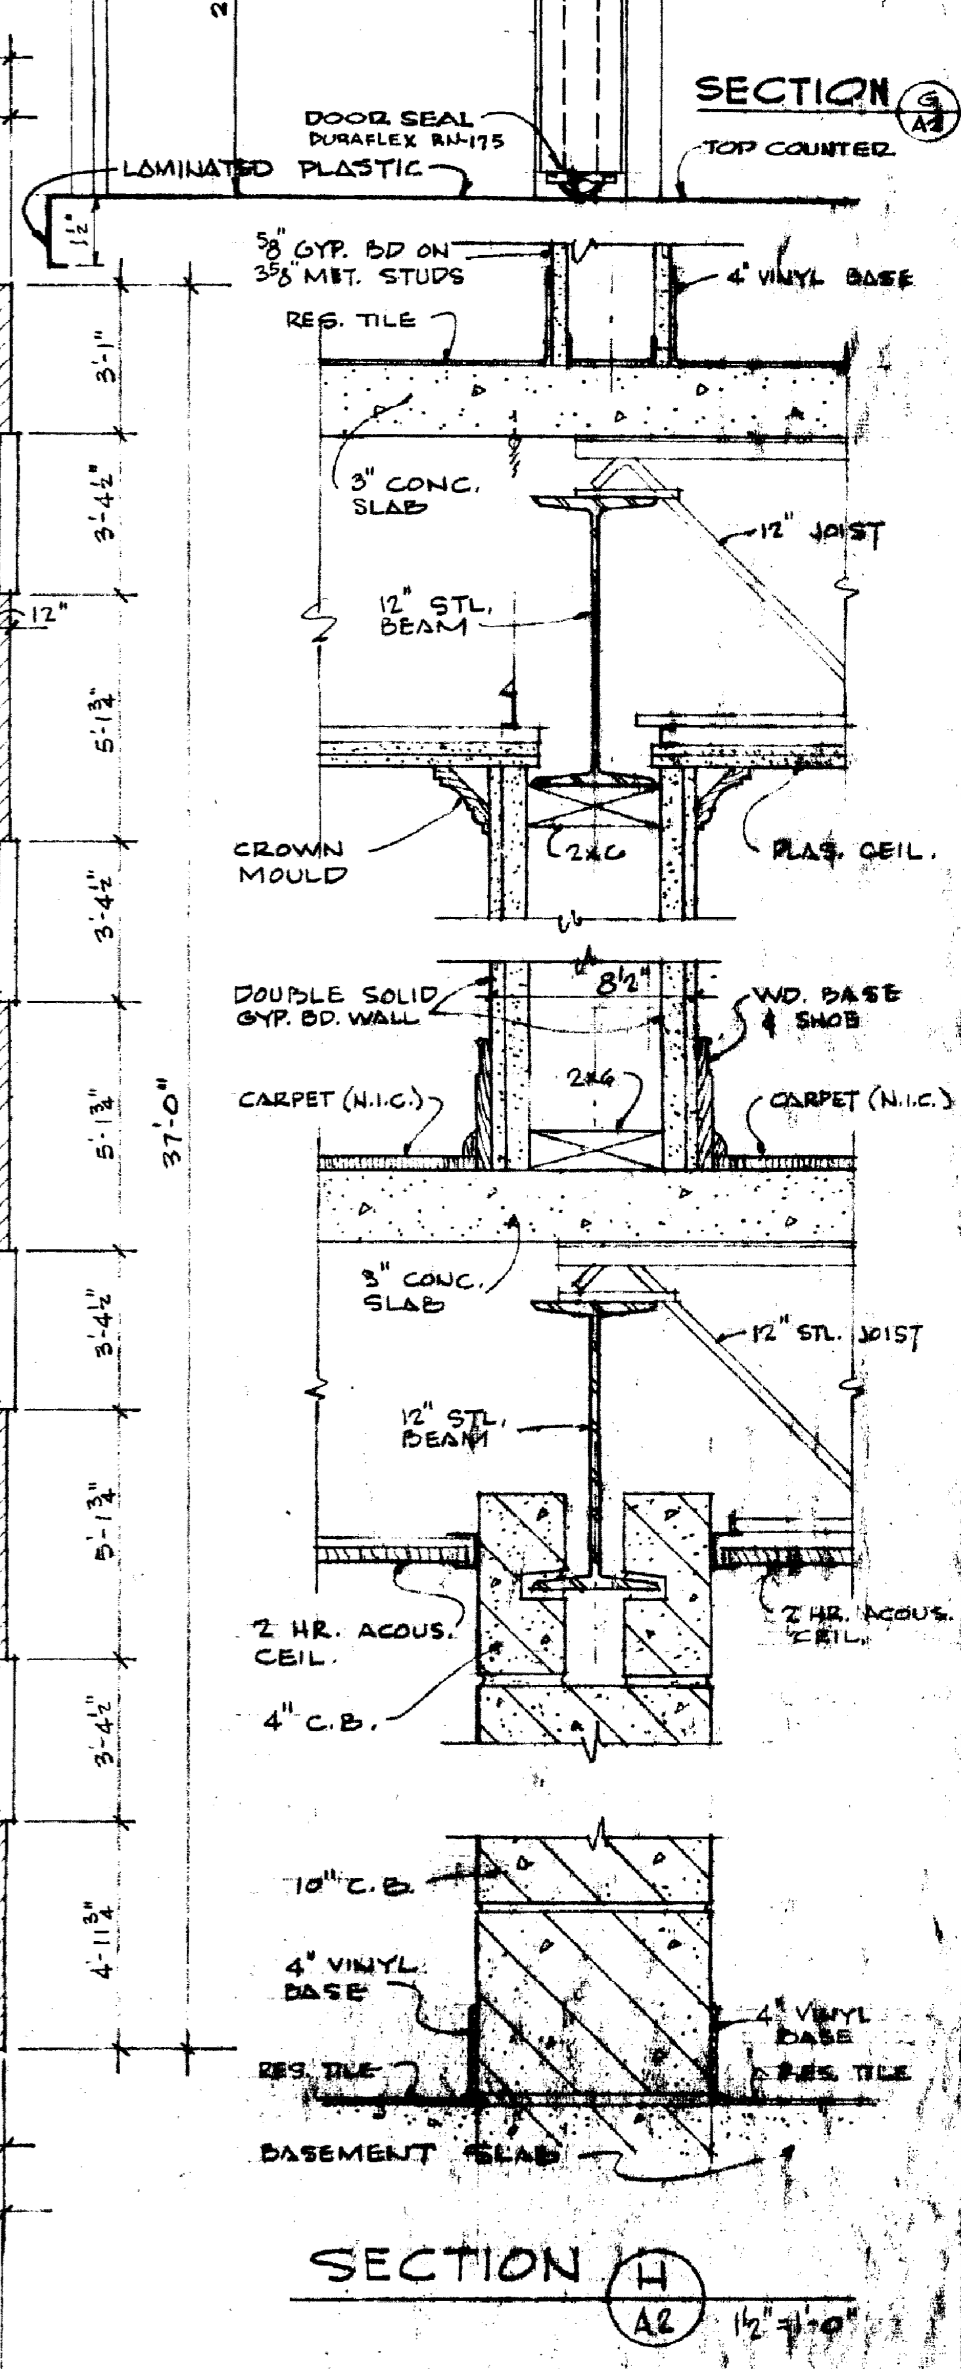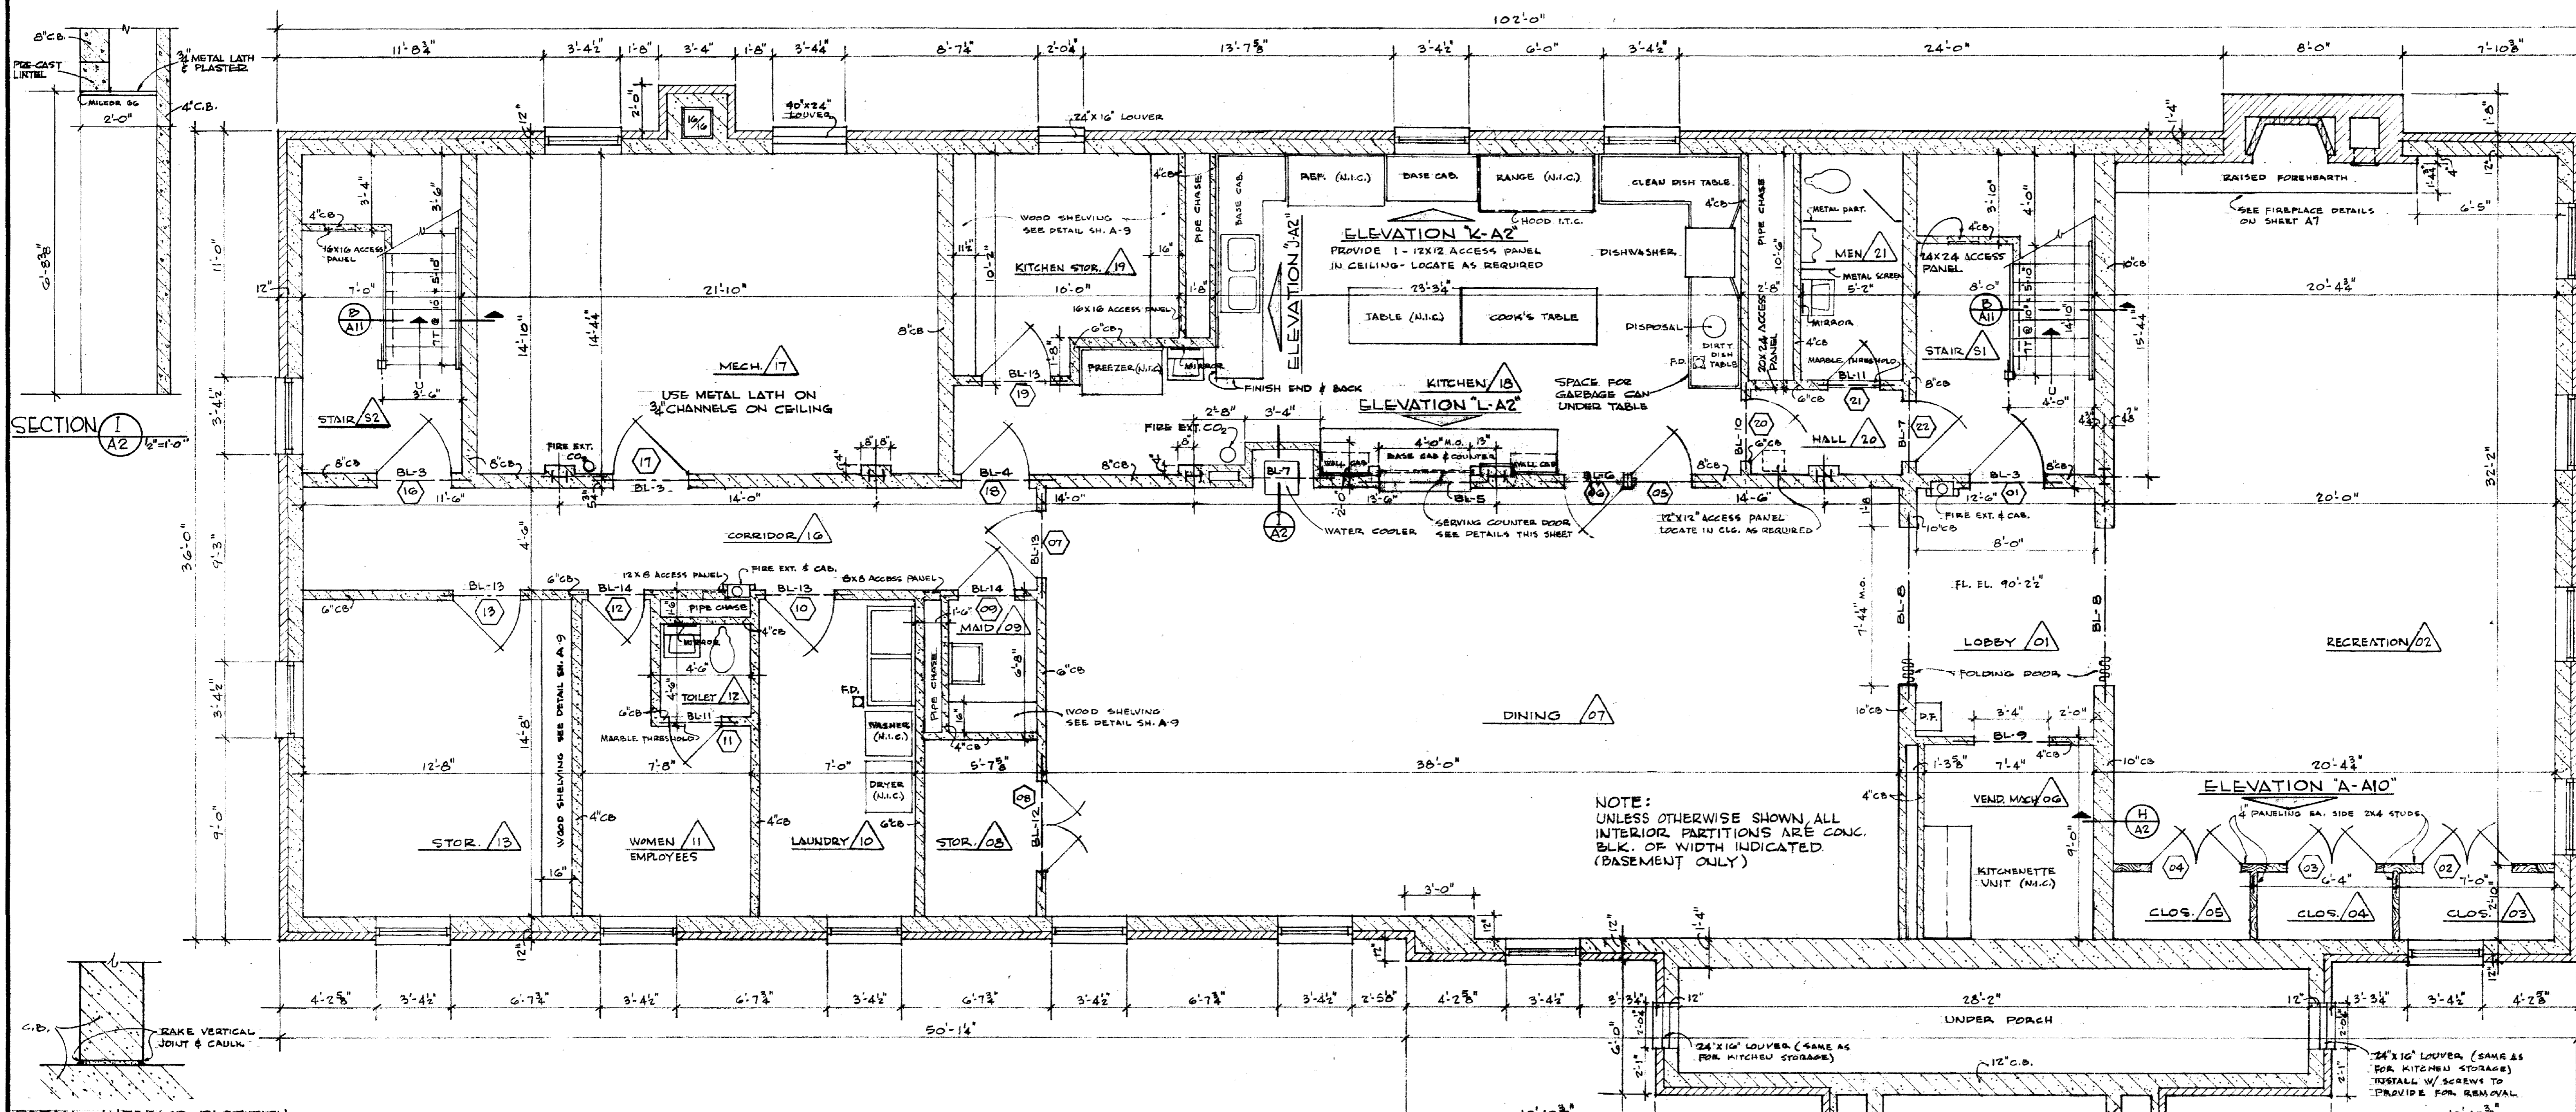


DETAIL - INTERIOR PARTITION BUTTING EXTERIOR WALLS




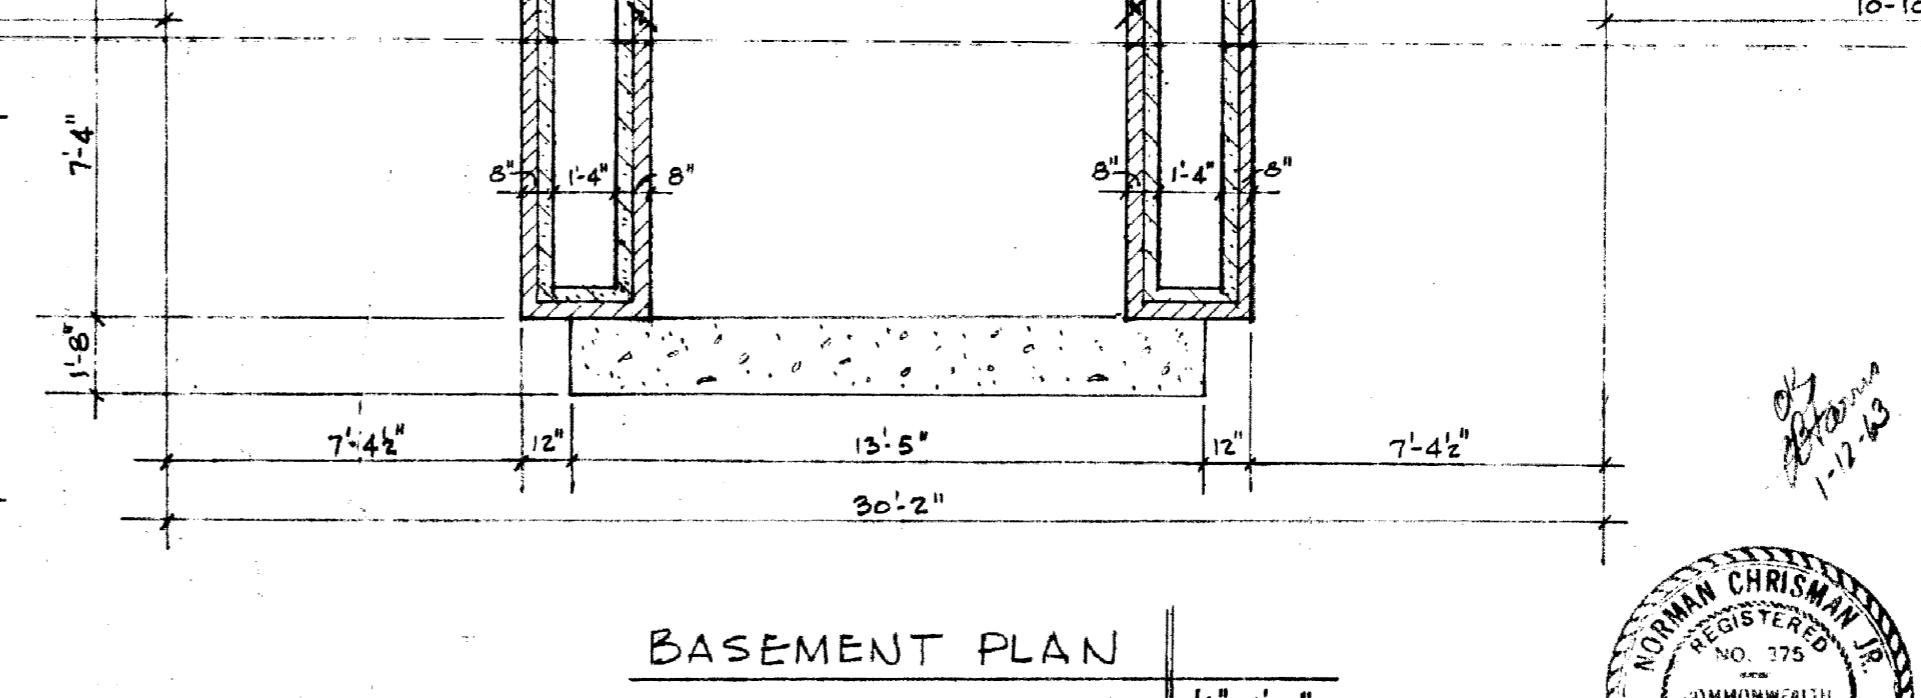
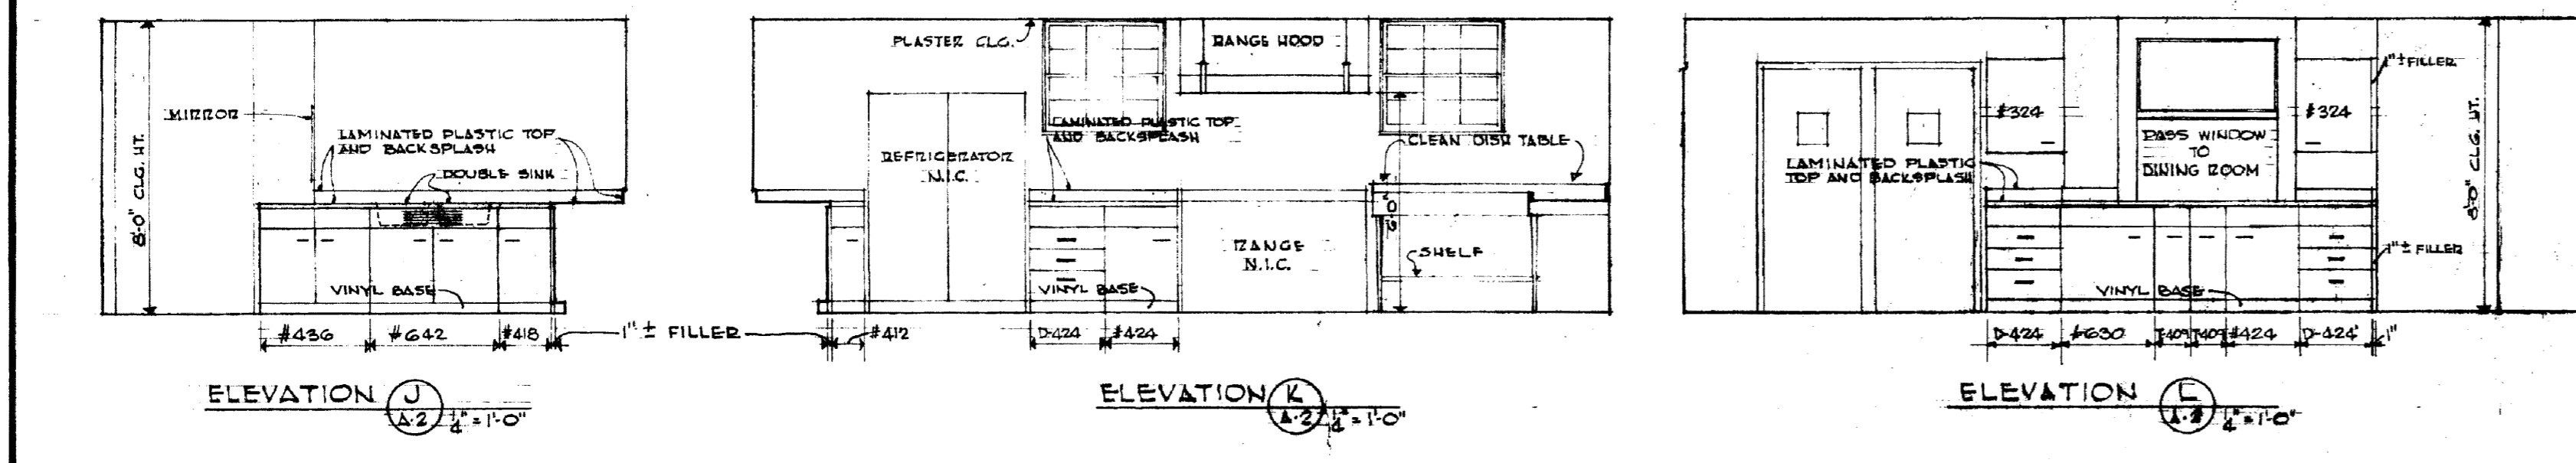


BASEMENT PLAN - DETAILS			
DELTA GAMMA SORORITY HOUSE UNIVERSITY OF KENTUCKY LEXINGTON, KENTUCKY			
DRAWN BY NC CH	ARCHITECTURAL	DATE 1-8-93	DRAWING NO. A2
TRACED BY PP	GILLIG • CHRISMAN & MILLER	SCALE AS SHOWN	
CHECKED BY NC	ARCHITECTS ASSOCIATED 180 WALNUT STREET LEXINGTON, KENTUCKY	SPEC. NO.	
REVISIONS	COMMONWEALTH OF KENTUCKY DEPARTMENT OF FINANCE ENGINEERING STAFF FRANKFORT, KENTUCKY	DATE 1-25-93	
APPROVED BY: <i>Mark D. Gillig</i>		DATE	
APPROVED BY: <i>David H. P.</i>		DATE	



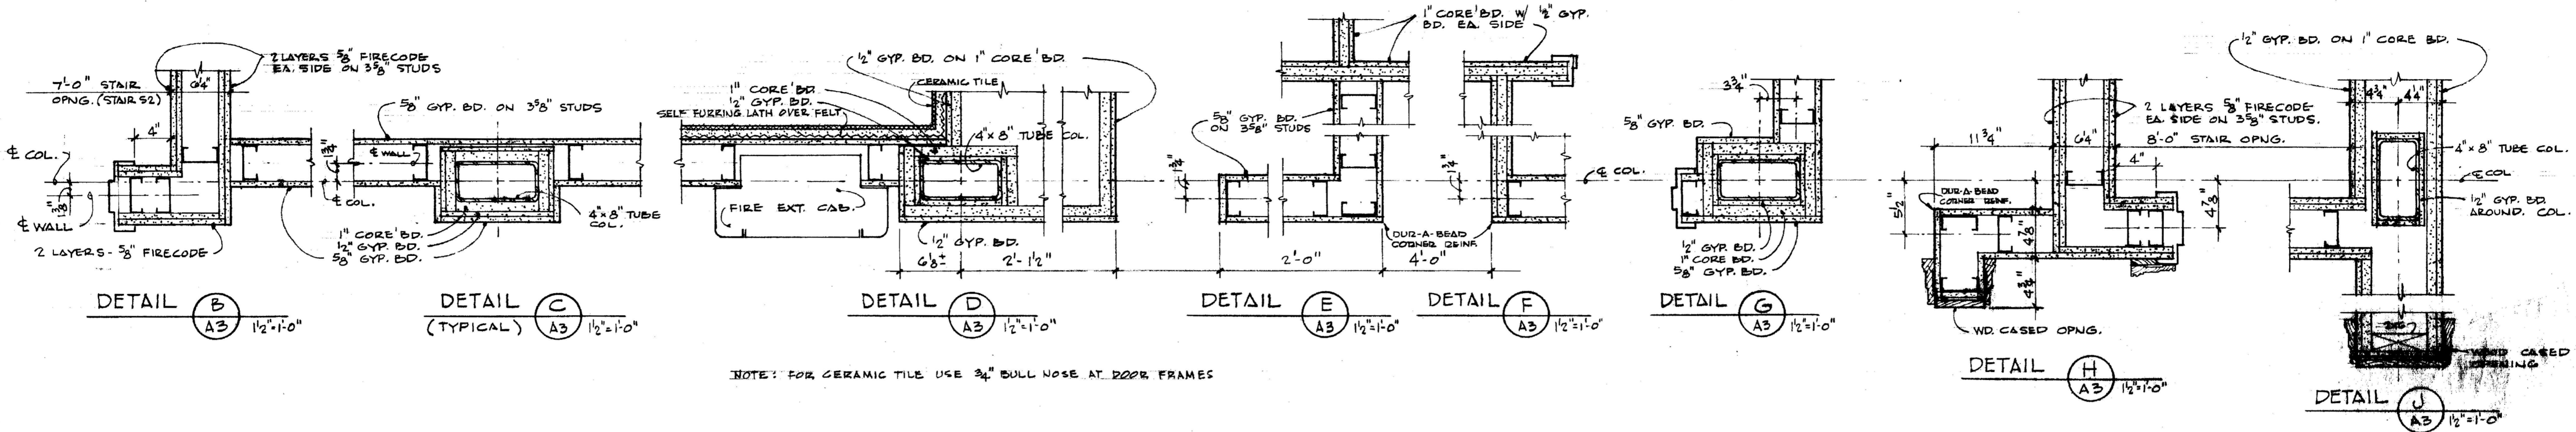

NOTE: FOR CERAMIC TILE USE 3/4\"/>

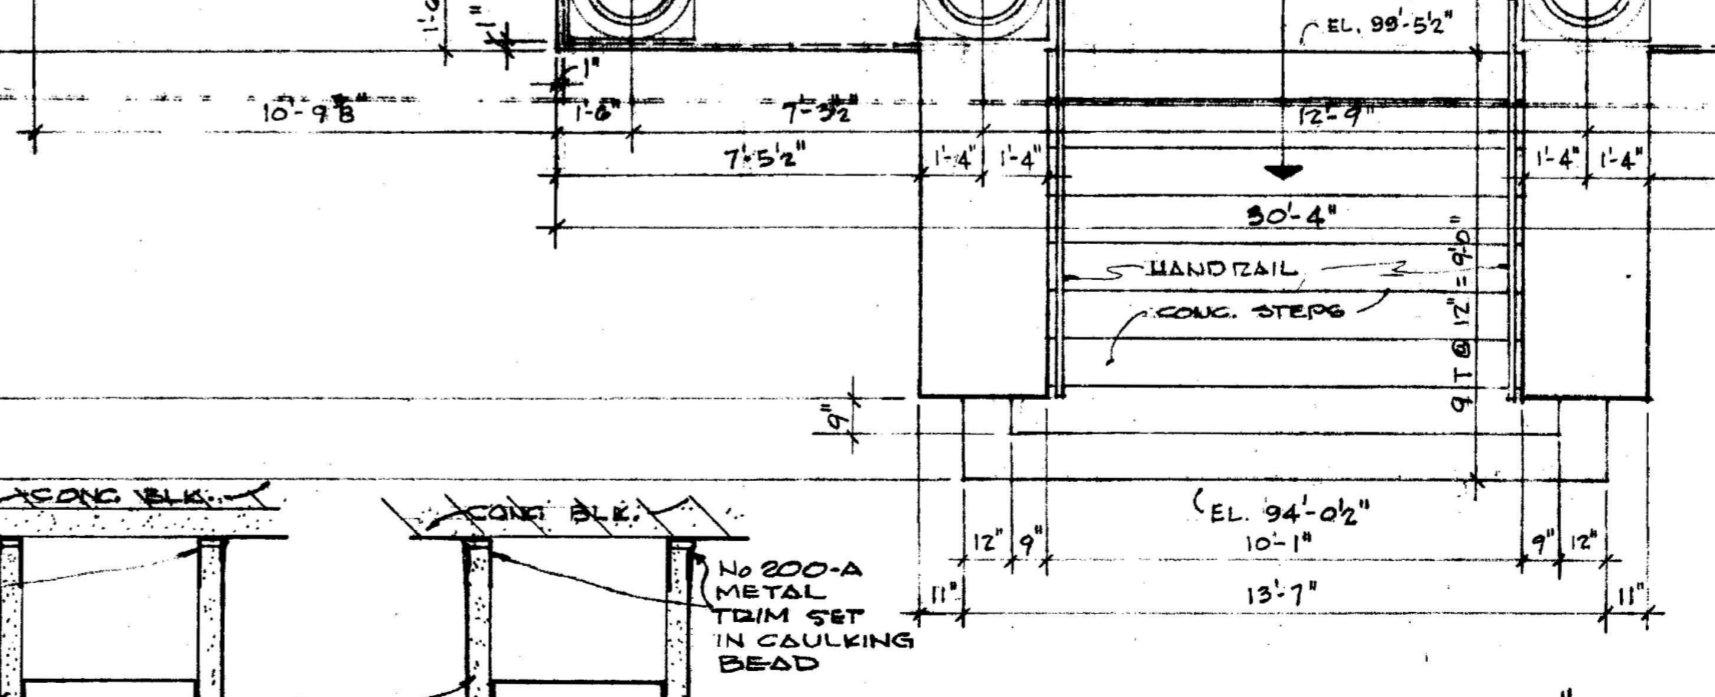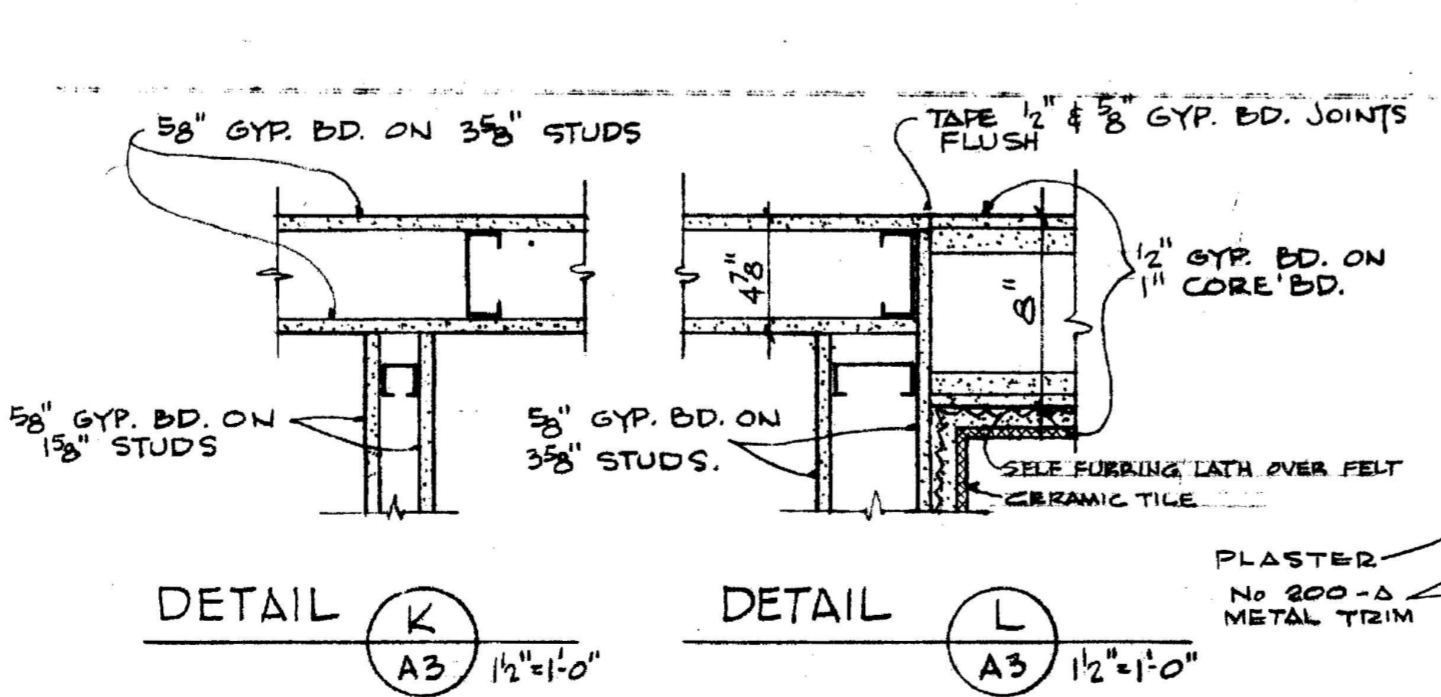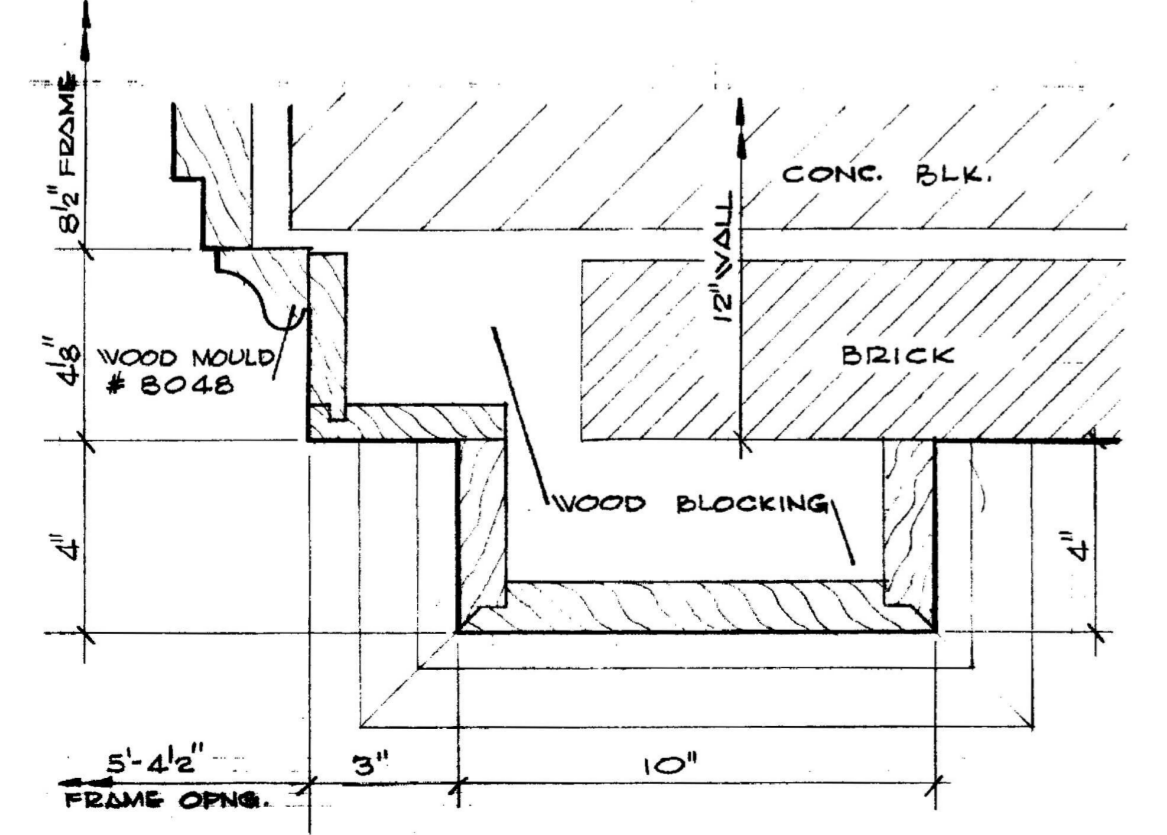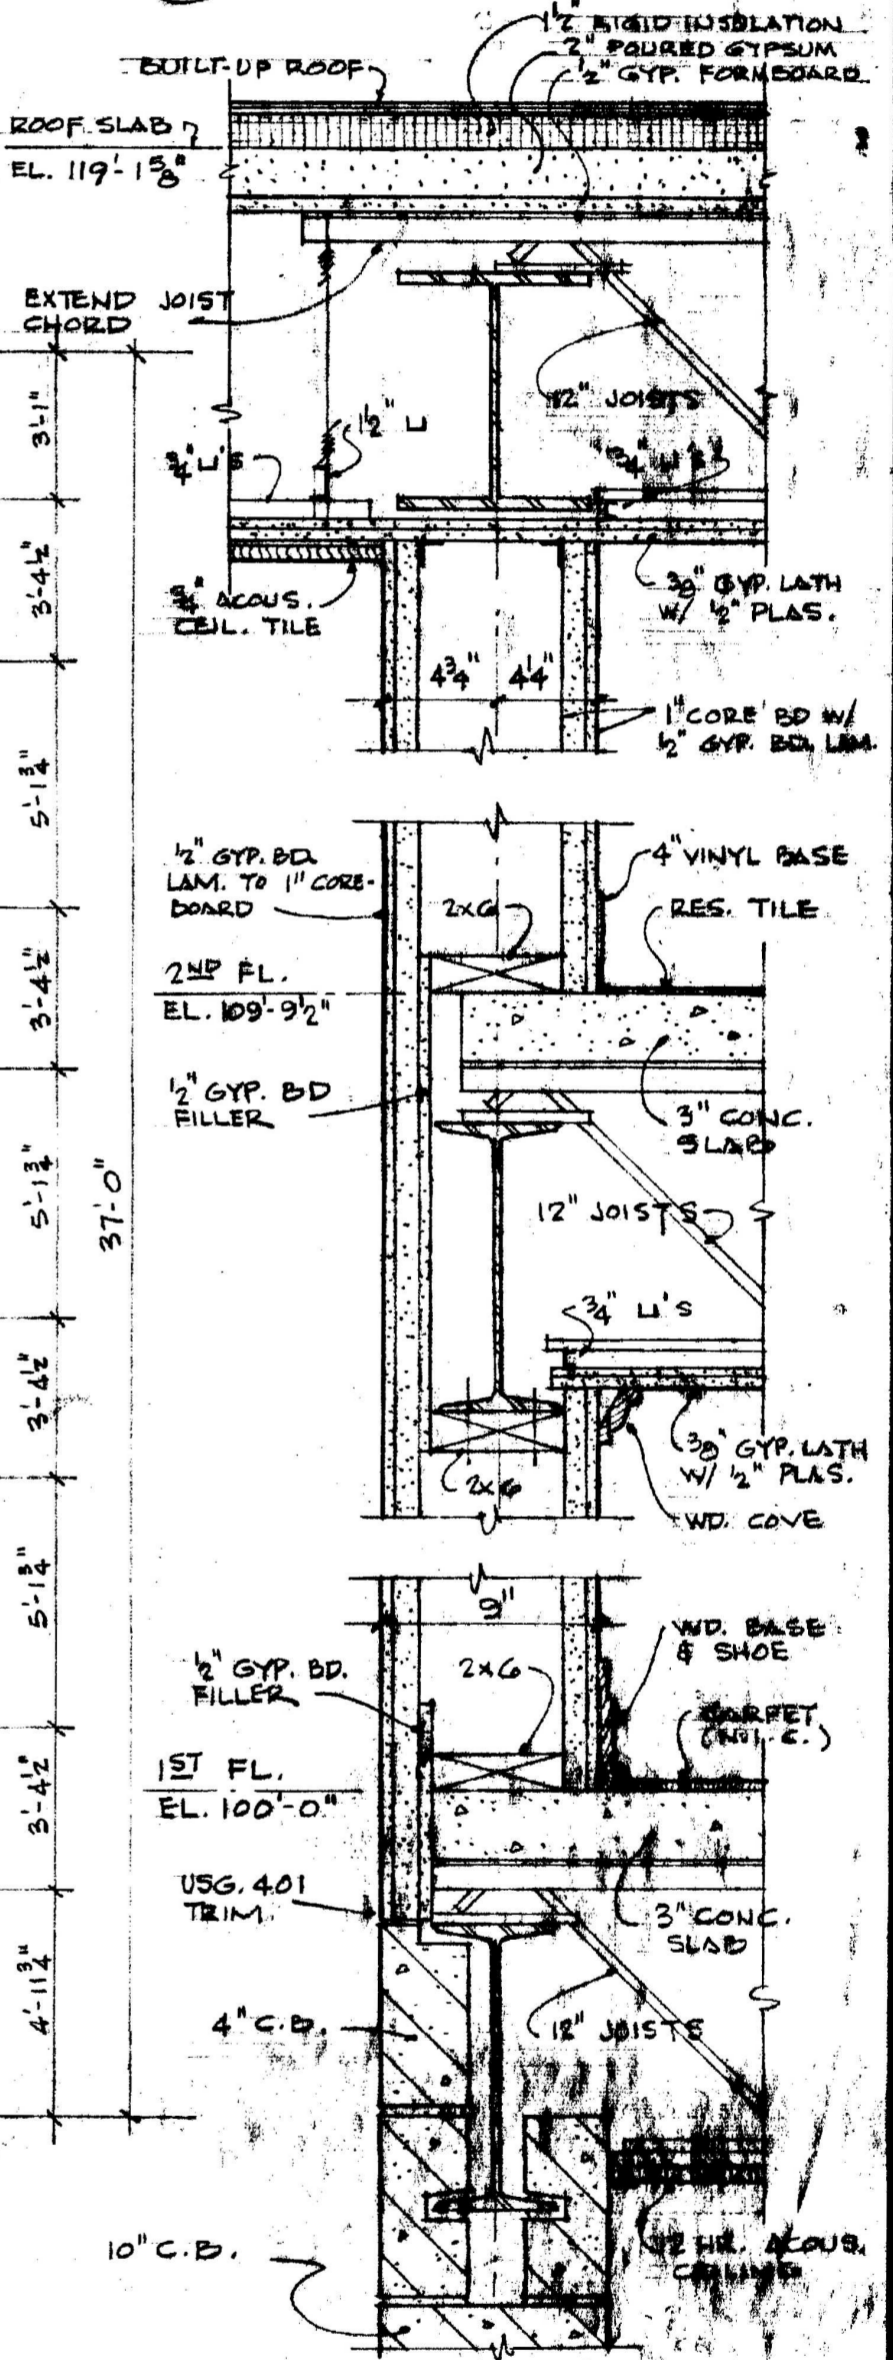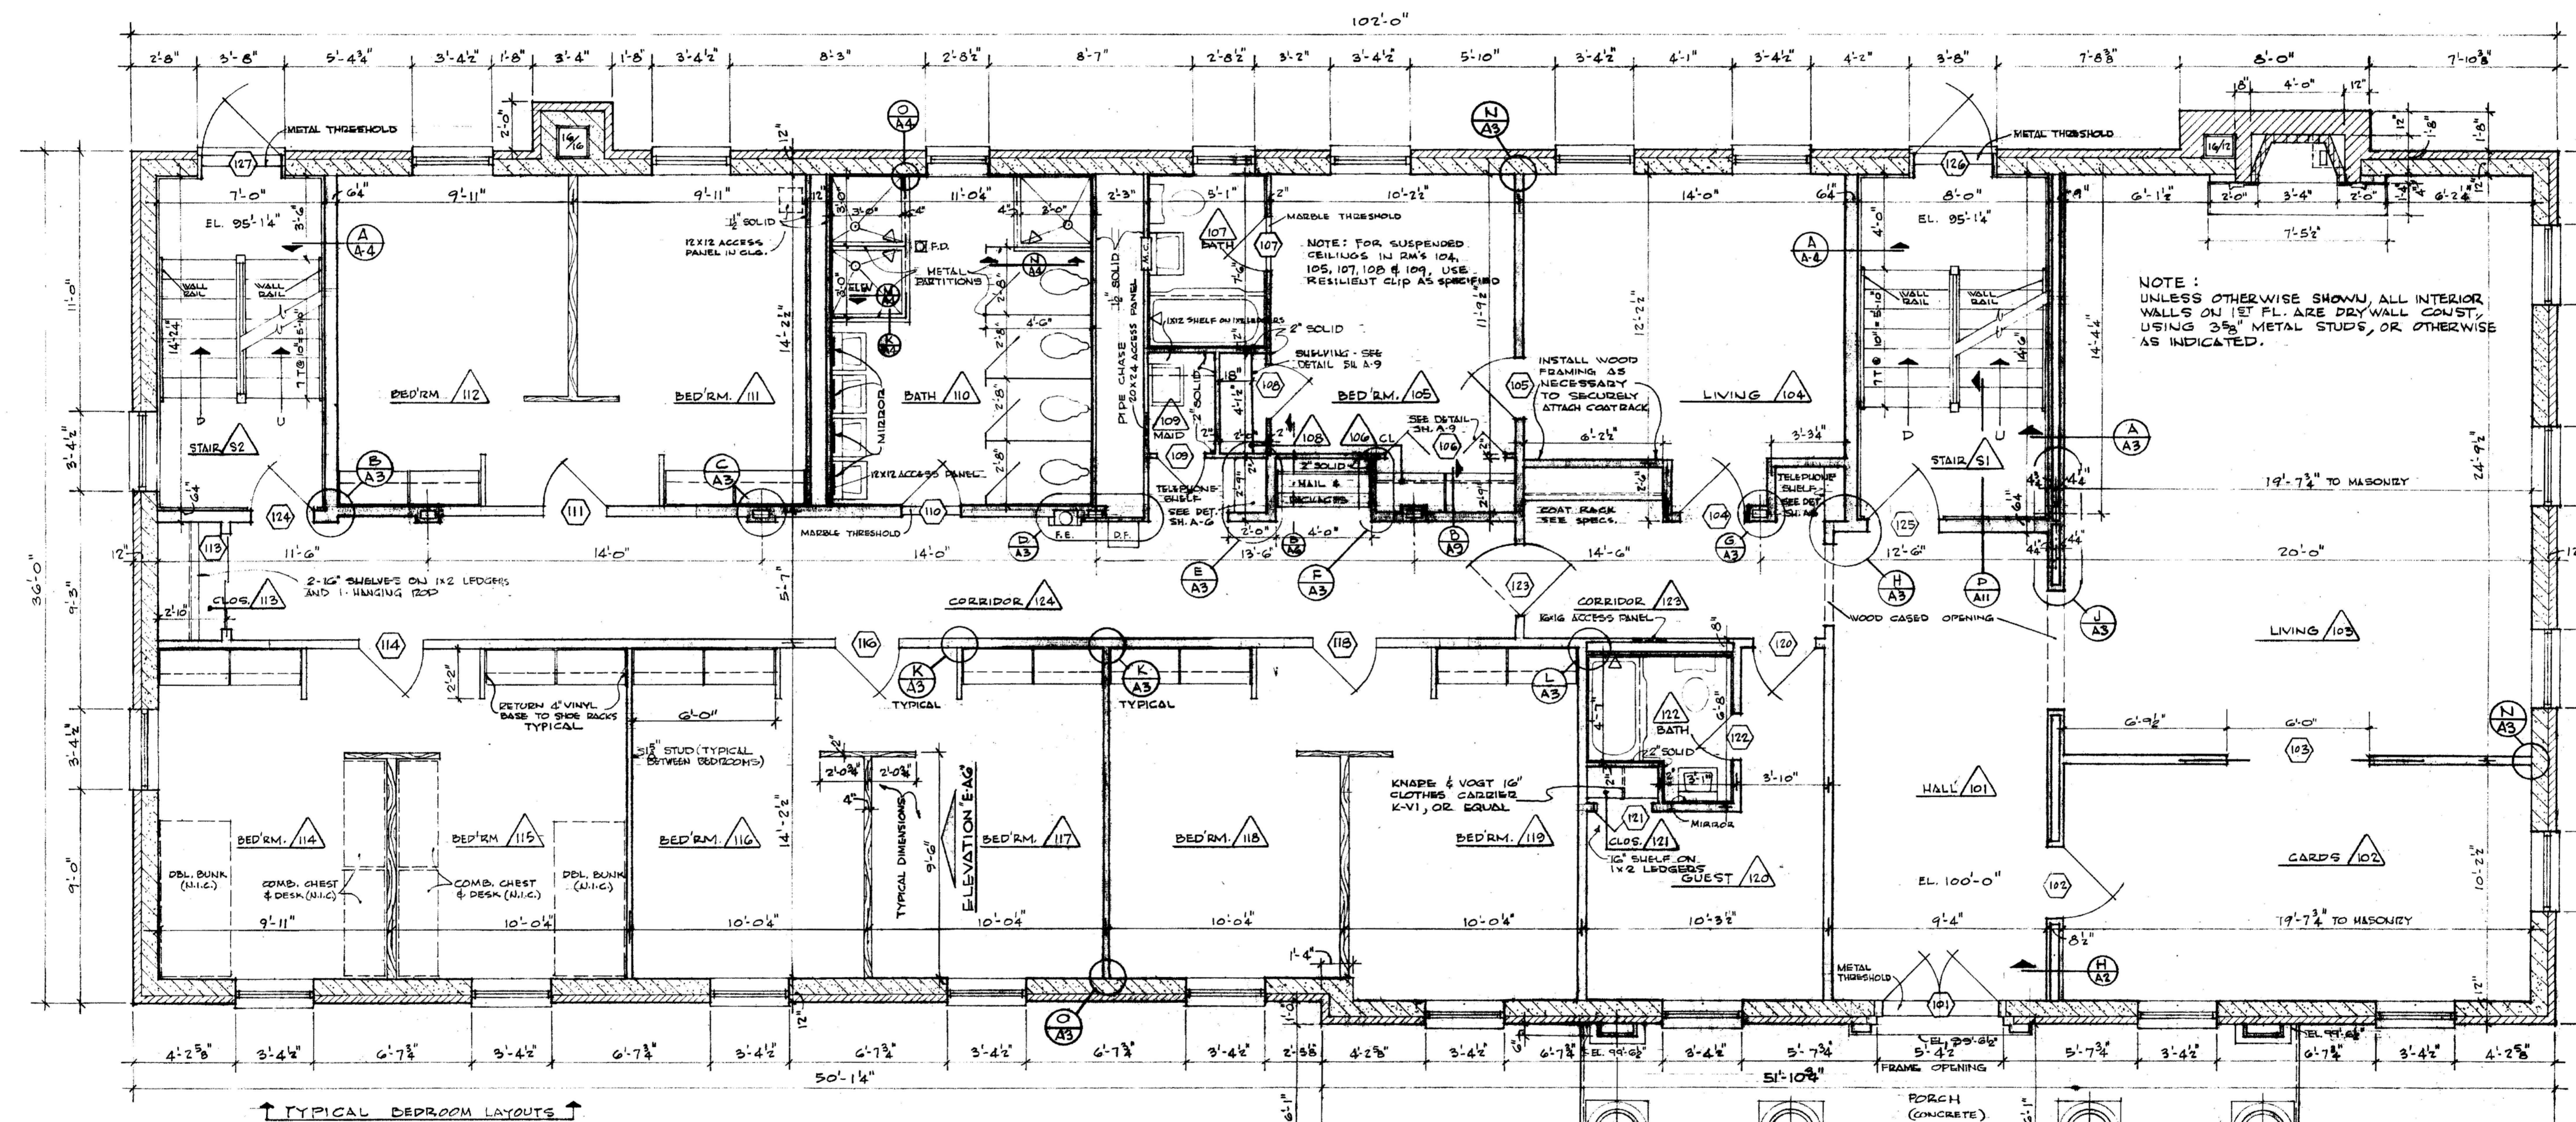

SECTION M M 101 ENTRANCE JAMB 3\"/>

DETAIL K A3 1 1/2\"/>

DETAIL L A3 1 1/2\"/>


DETAIL N A3 3\"/>

DETAIL O A3 3\"/>


FIRST FLOOR PLAN

DELTA GAMMA SORORITY HOUSE UNIVERSITY OF KENTUCKY LEXINGTON KENTUCKY		
DRAWN BY NE KM	ARCHITECTURAL	DATE 7-8-65
CHECKED BY MC	GILLIG • CHRISMAN & MILLER ARCHITECTS ASSOCIATED 180 WALNUT STREET LEXINGTON, KENTUCKY	SCALE AS SHOWN SPEC. NO.
REVISIONS	COMMONWEALTH OF KENTUCKY DEPARTMENT OF FINANCE ENGINEERING STAFF FRANKFORT KENTUCKY	DRAWING NO. A3
APPROVED BY <i>David J. [Signature]</i> AGENCY HEAD		DATE
APPROVED BY <i>David J. [Signature]</i> DATE		


V-1986

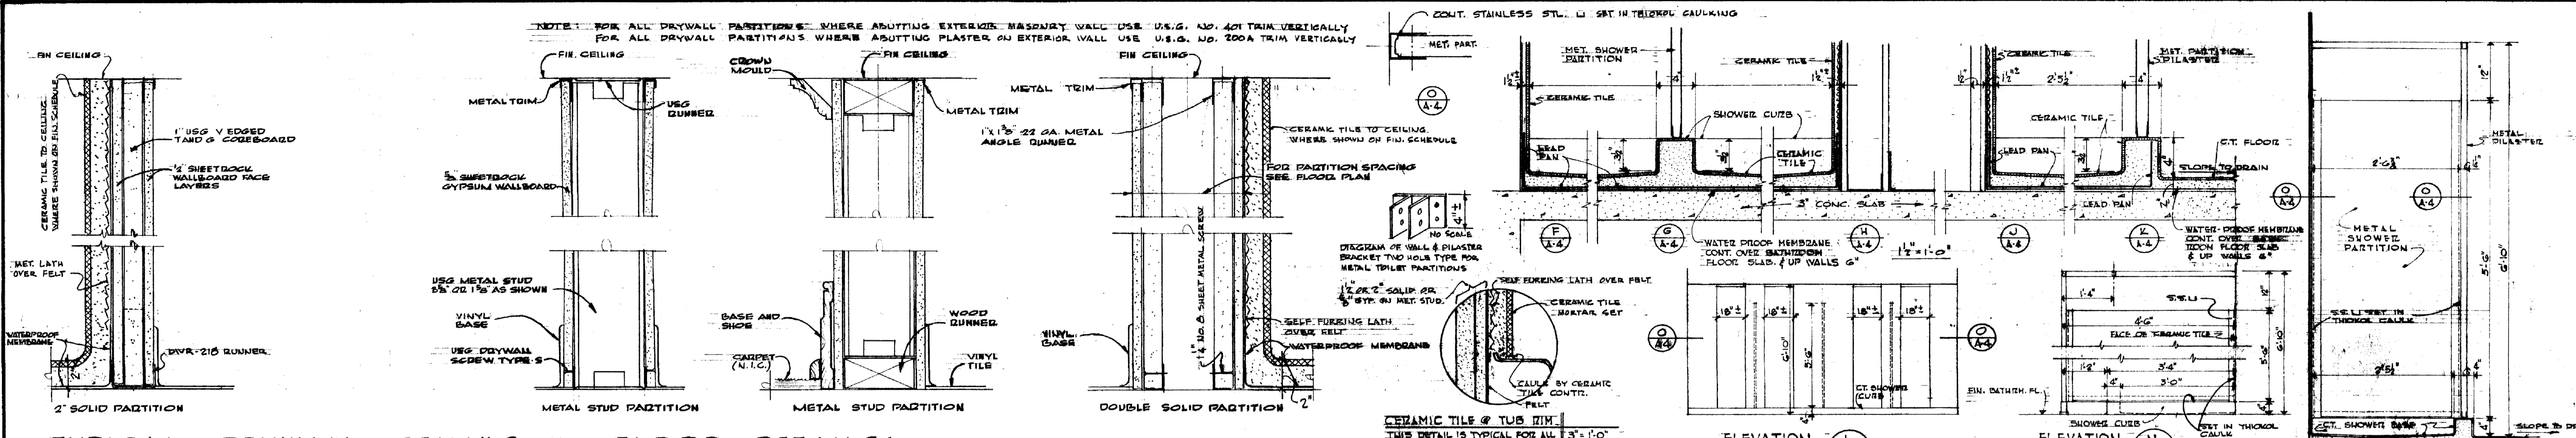


TYPICAL DRYWALL CEILING AND FLOOR DETAILS
 USE NO. 200-A METAL TRIM AT CEILING WHERE CEILING IS SCHEDULED TO BE PAINTED - OTHERWISE USE NO. 401 METAL TRIM AT CEILING.

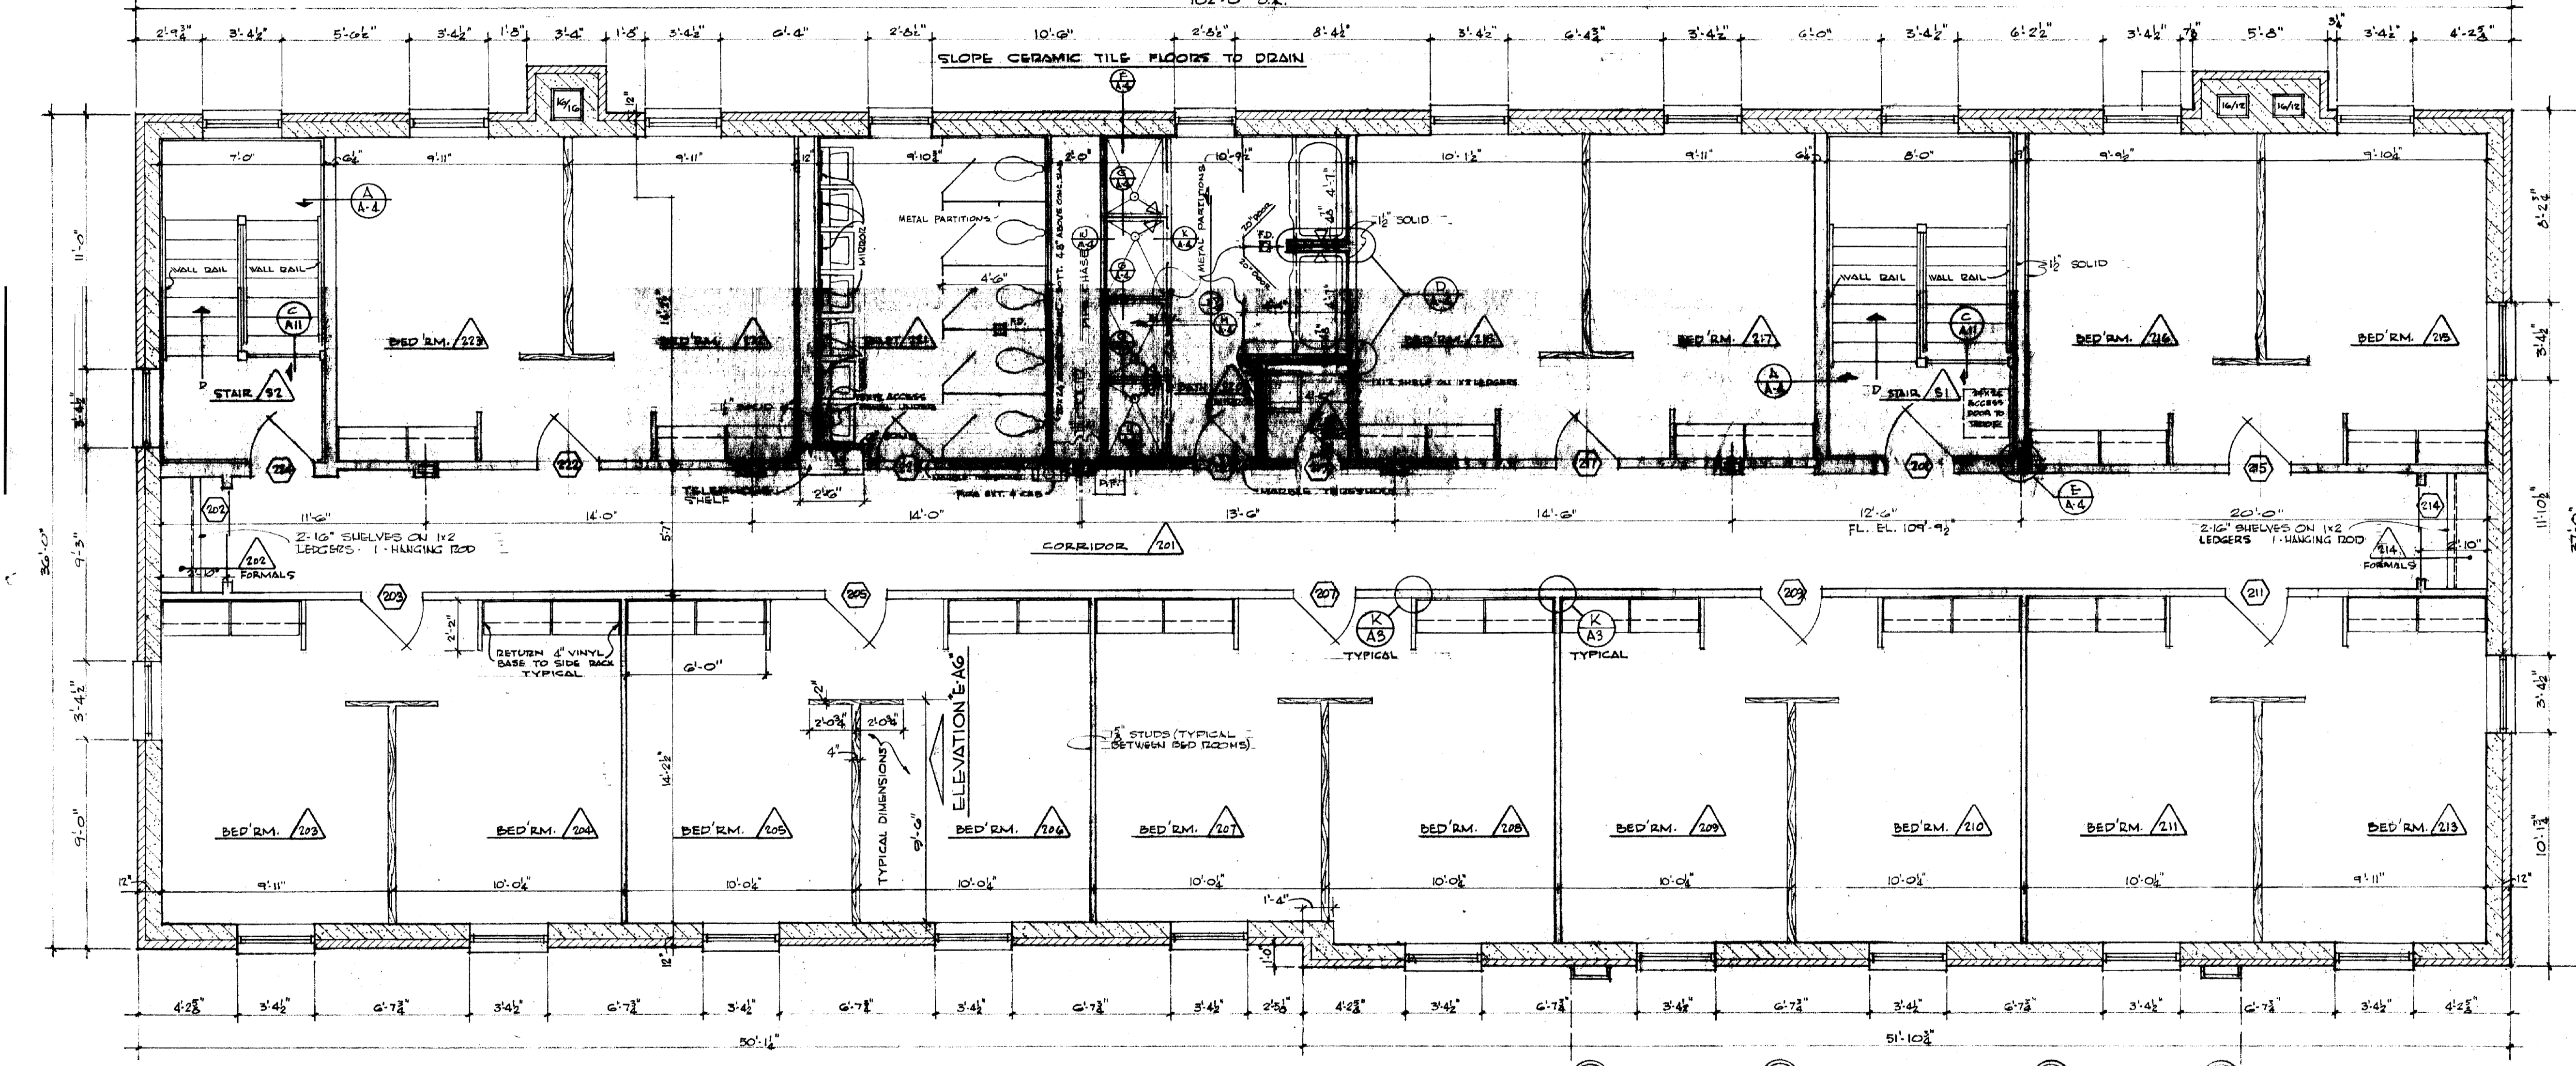


SECOND FLOOR PLAN
 SCALE: 1/8" = 1'-0"

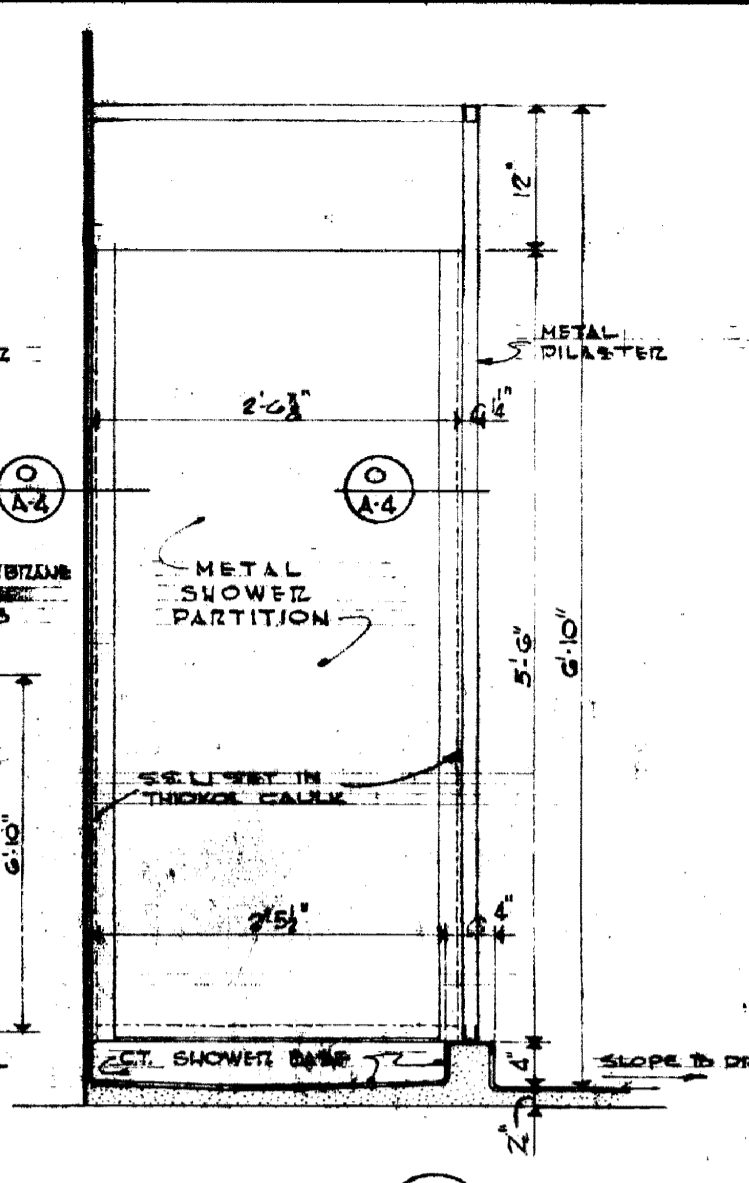


ELEVATION M
 SCALE: 1/8" = 1'-0"

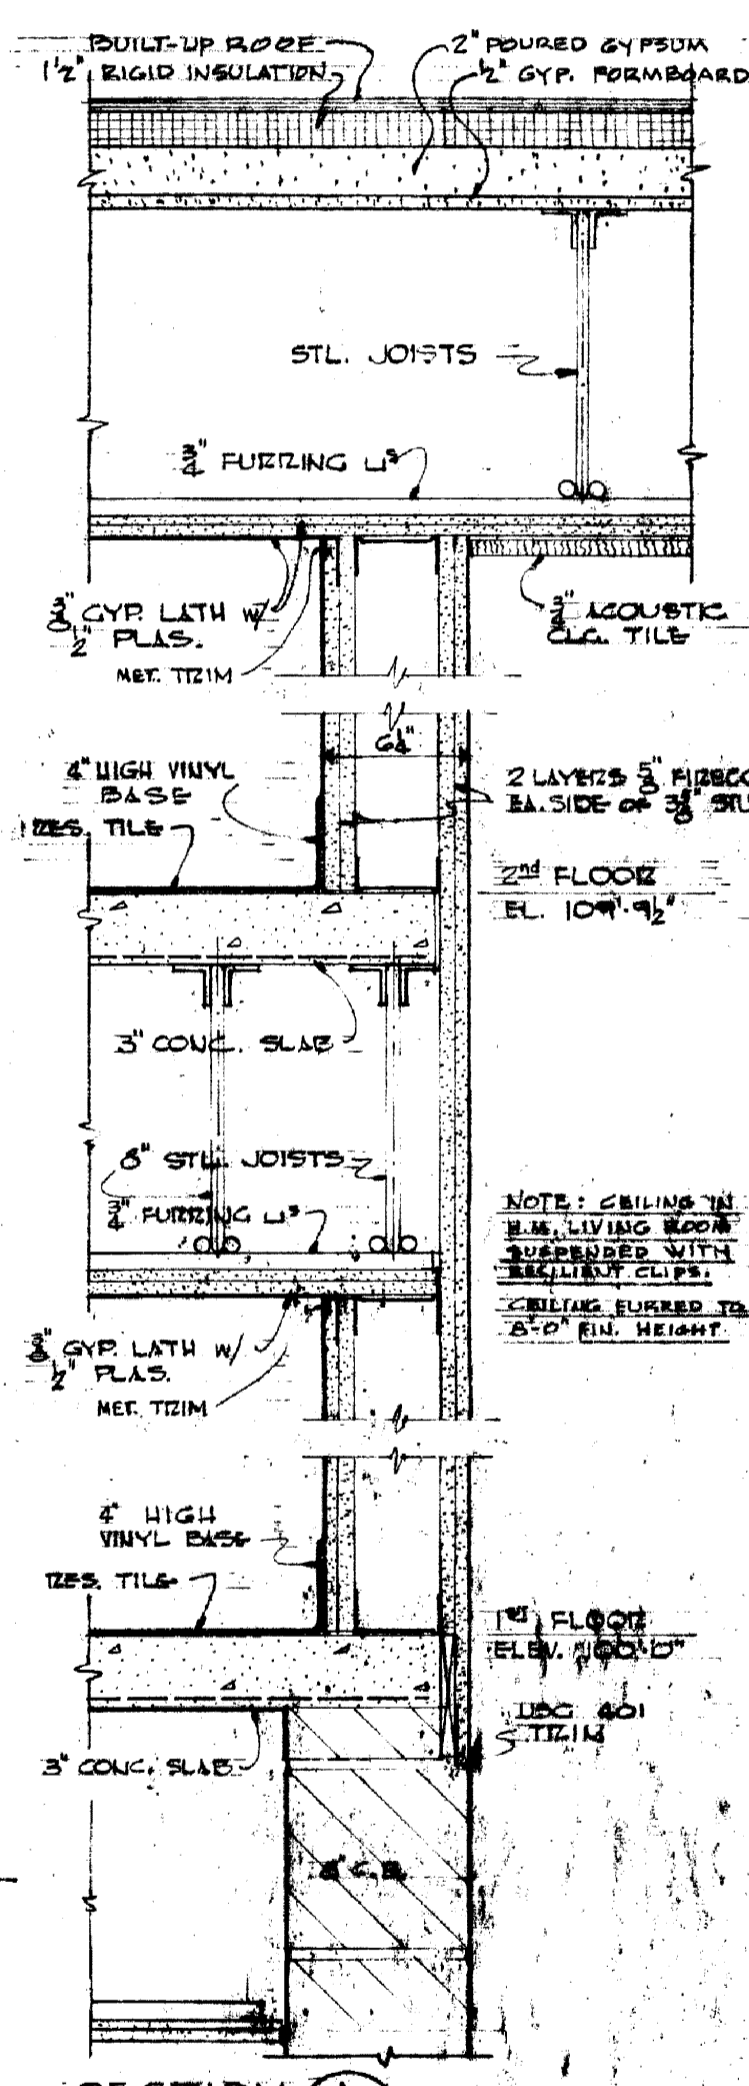


SECTION A-A
 SCALE: 1/8" = 1'-0"

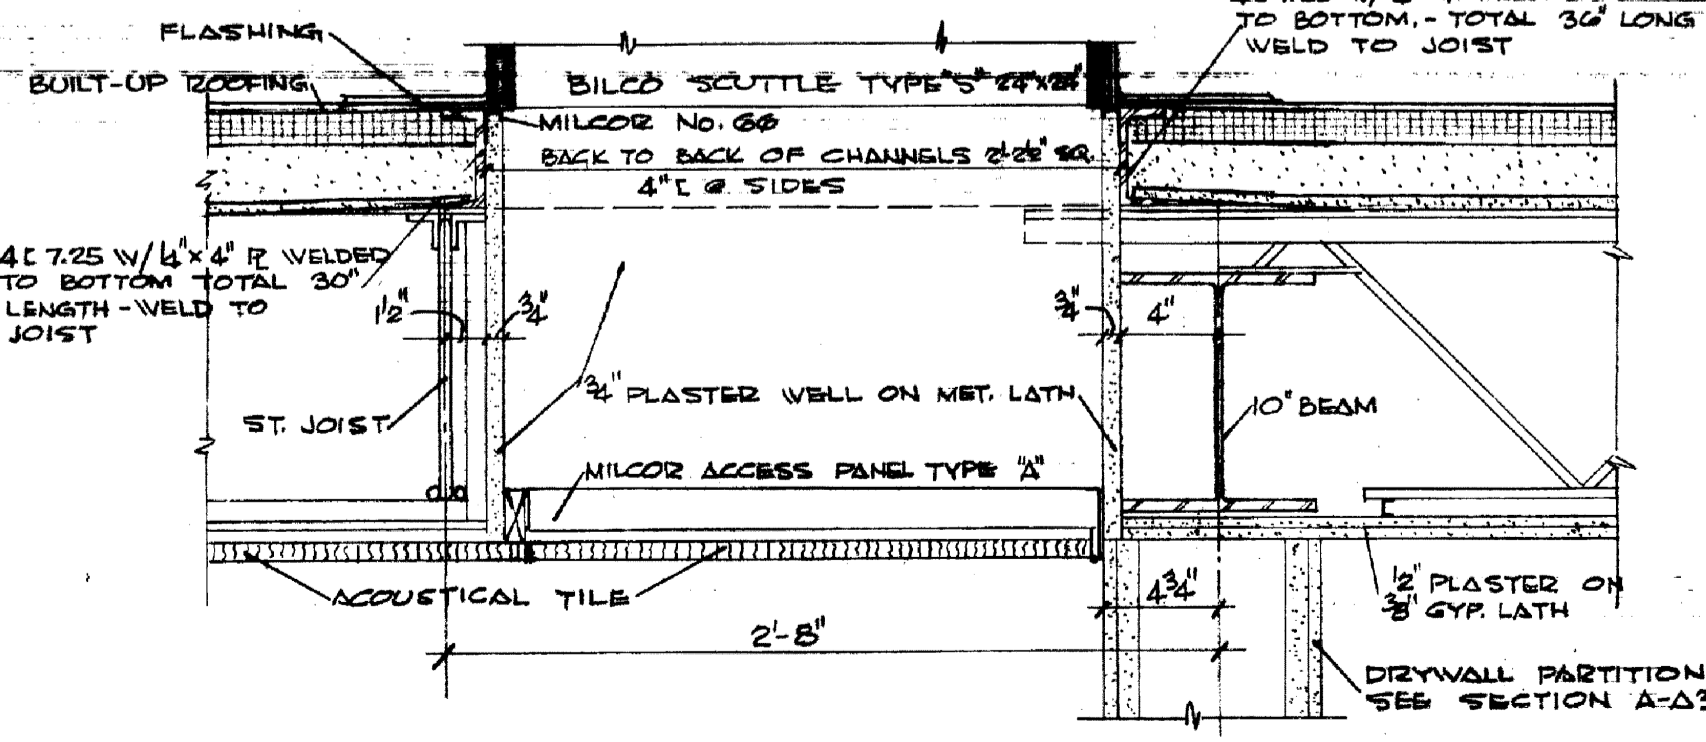


DETAIL OF ACCESS TO ROOF IN STAIR S-1
 SCALE: 1/2" = 1'-0"

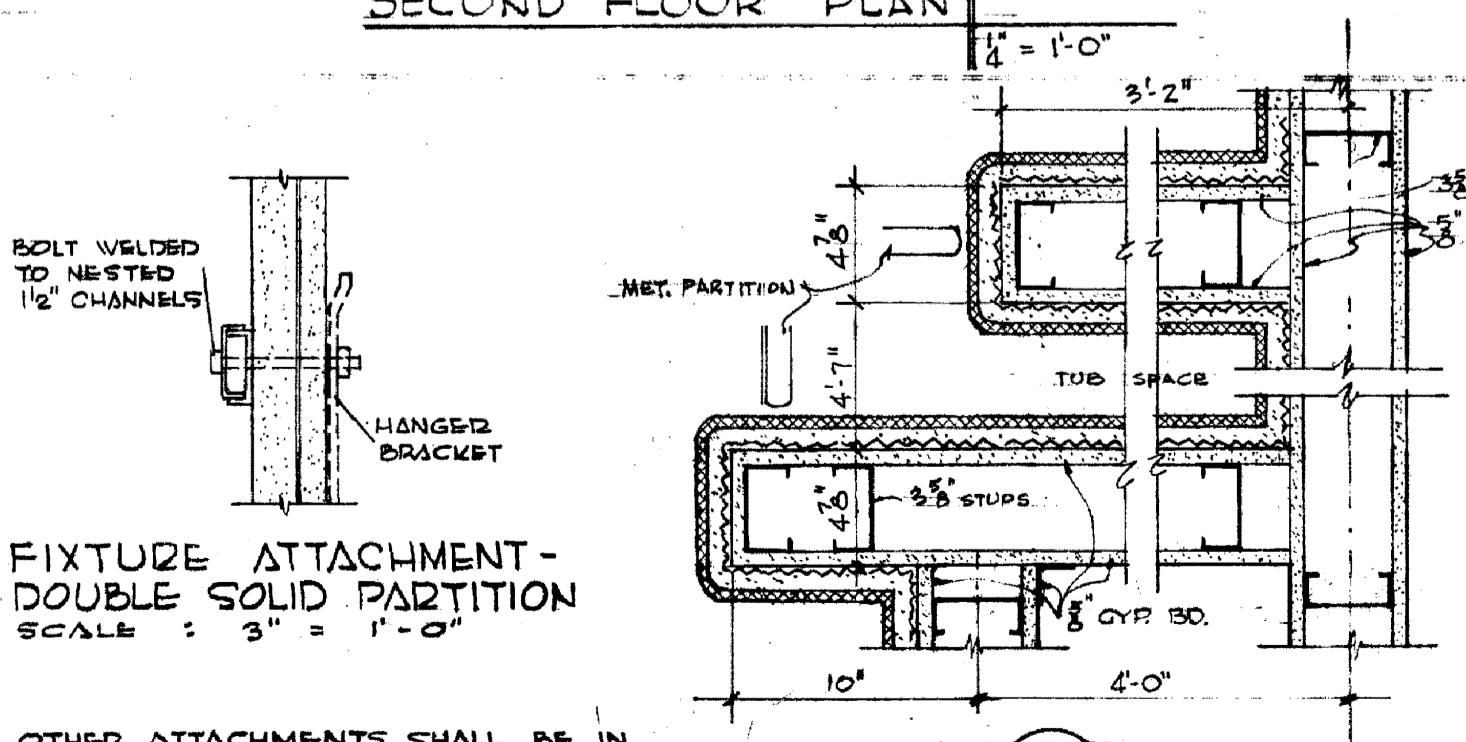

FIXTURE ATTACHMENT - DOUBLE SOLID PARTITION
 SCALE: 3/8" = 1'-0"

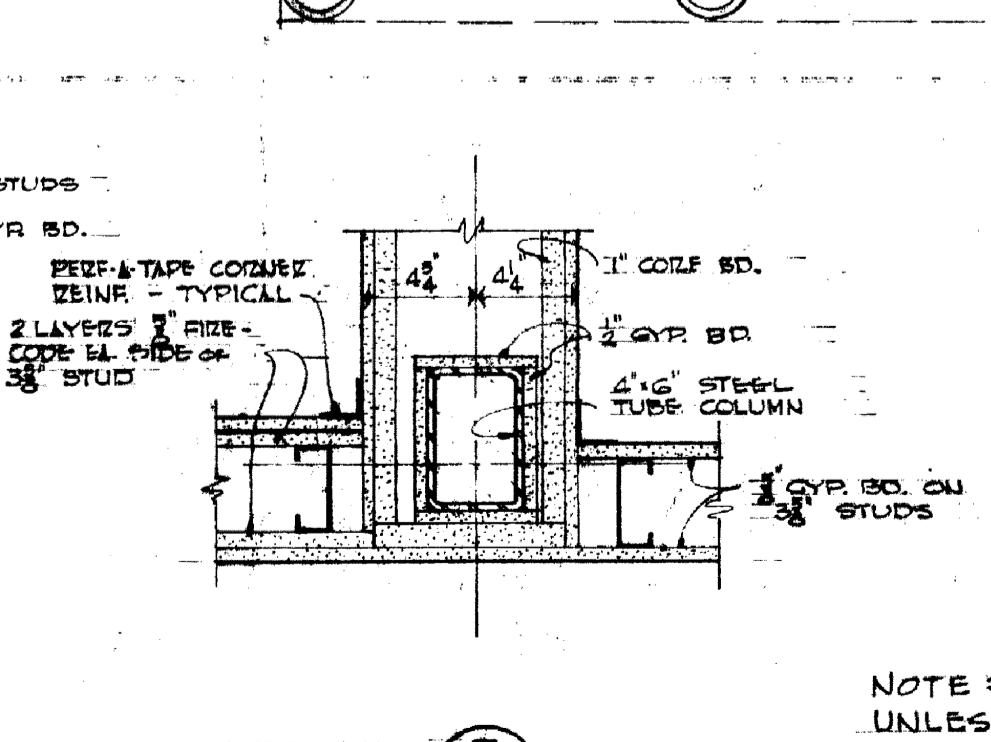

DETAIL D
 SCALE: 1/2" = 1'-0"

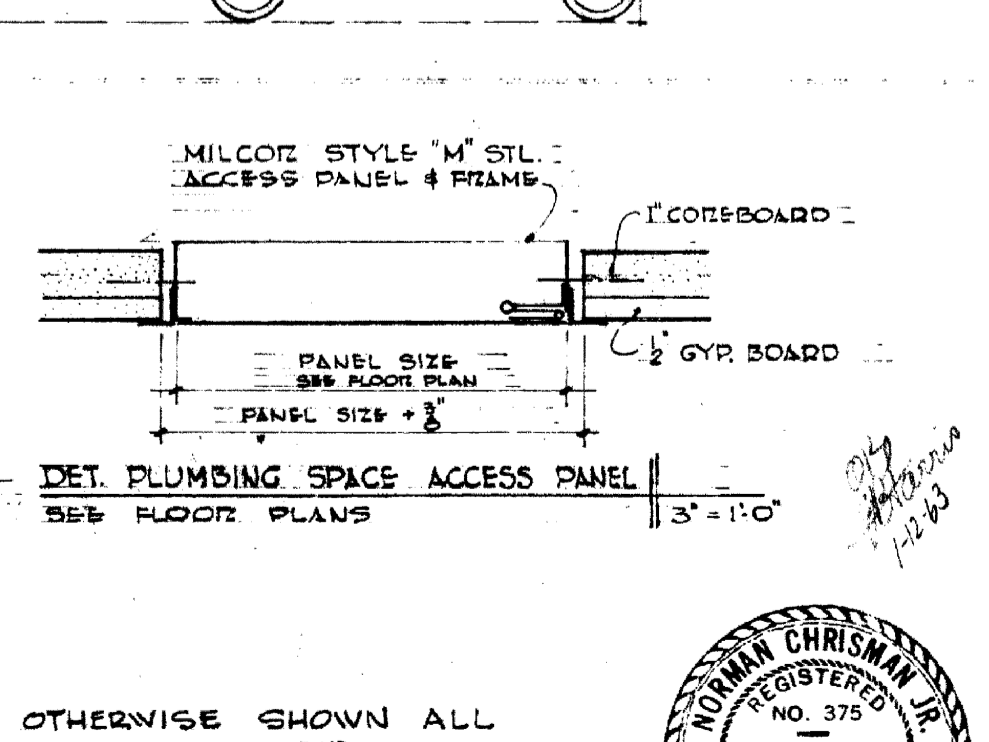


DETAIL E
 SCALE: 1/2" = 1'-0"

NOTE: UNLESS OTHERWISE SHOWN ALL INTERIOR WALLS ON 2ND FL. ARE DRYWALL CONST. USING 3/8\"/>







SECOND FLOOR PLAN - DETAILS		
DELTA GAMMA SORORITY HOUSE UNIVERSITY OF KENTUCKY LEXINGTON KENTUCKY		
DRAWN BY NC CH	ARCHITECTURAL	DATE 1-8-63
TRACED BY PP	GILLIG • CHRISMAN & MILLER ARCHITECTS ASSOCIATED	SCALE AS SHOWN
CHECKED BY UC	180 WALNUT STREET LEXINGTON, KENTUCKY	SPEC. NO.
REVISIONS	COMMONWEALTH OF KENTUCKY DEPARTMENT OF FINANCE ENGINEERING STAFF FRANKFORT KENTUCKY	DRAWING NO. A-4
APPROVED BY <i>Mark D. Chrisman</i> DATE 1-25-63		
APPROVED BY <i>David A. Patcher</i> DATE		

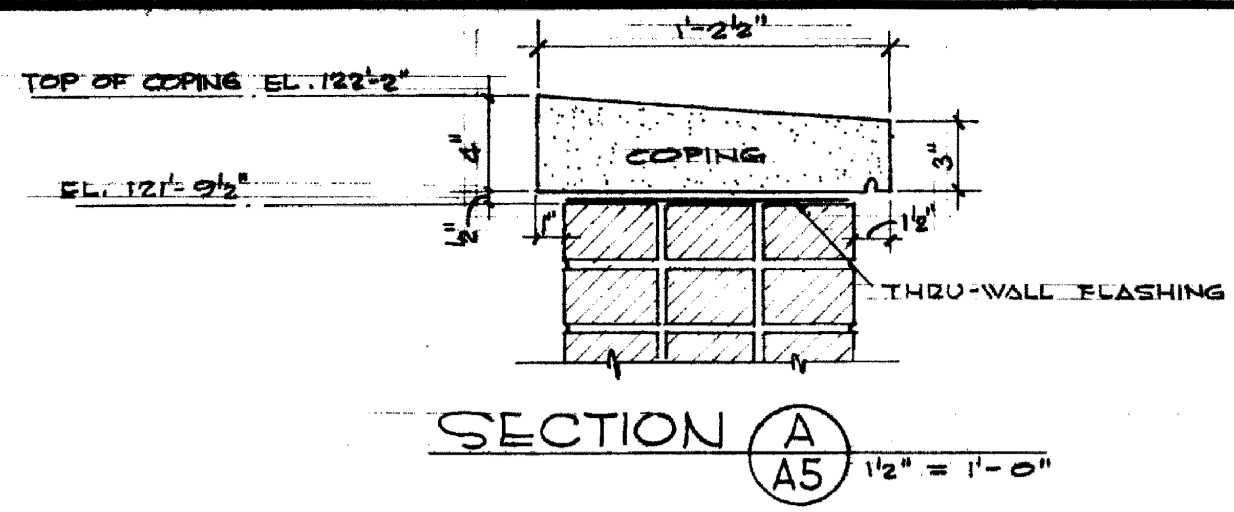

SECTION A A5 1/2" = 1'-0"














FRONT (WEST) ELEVATION 1/4" = 1'-0"

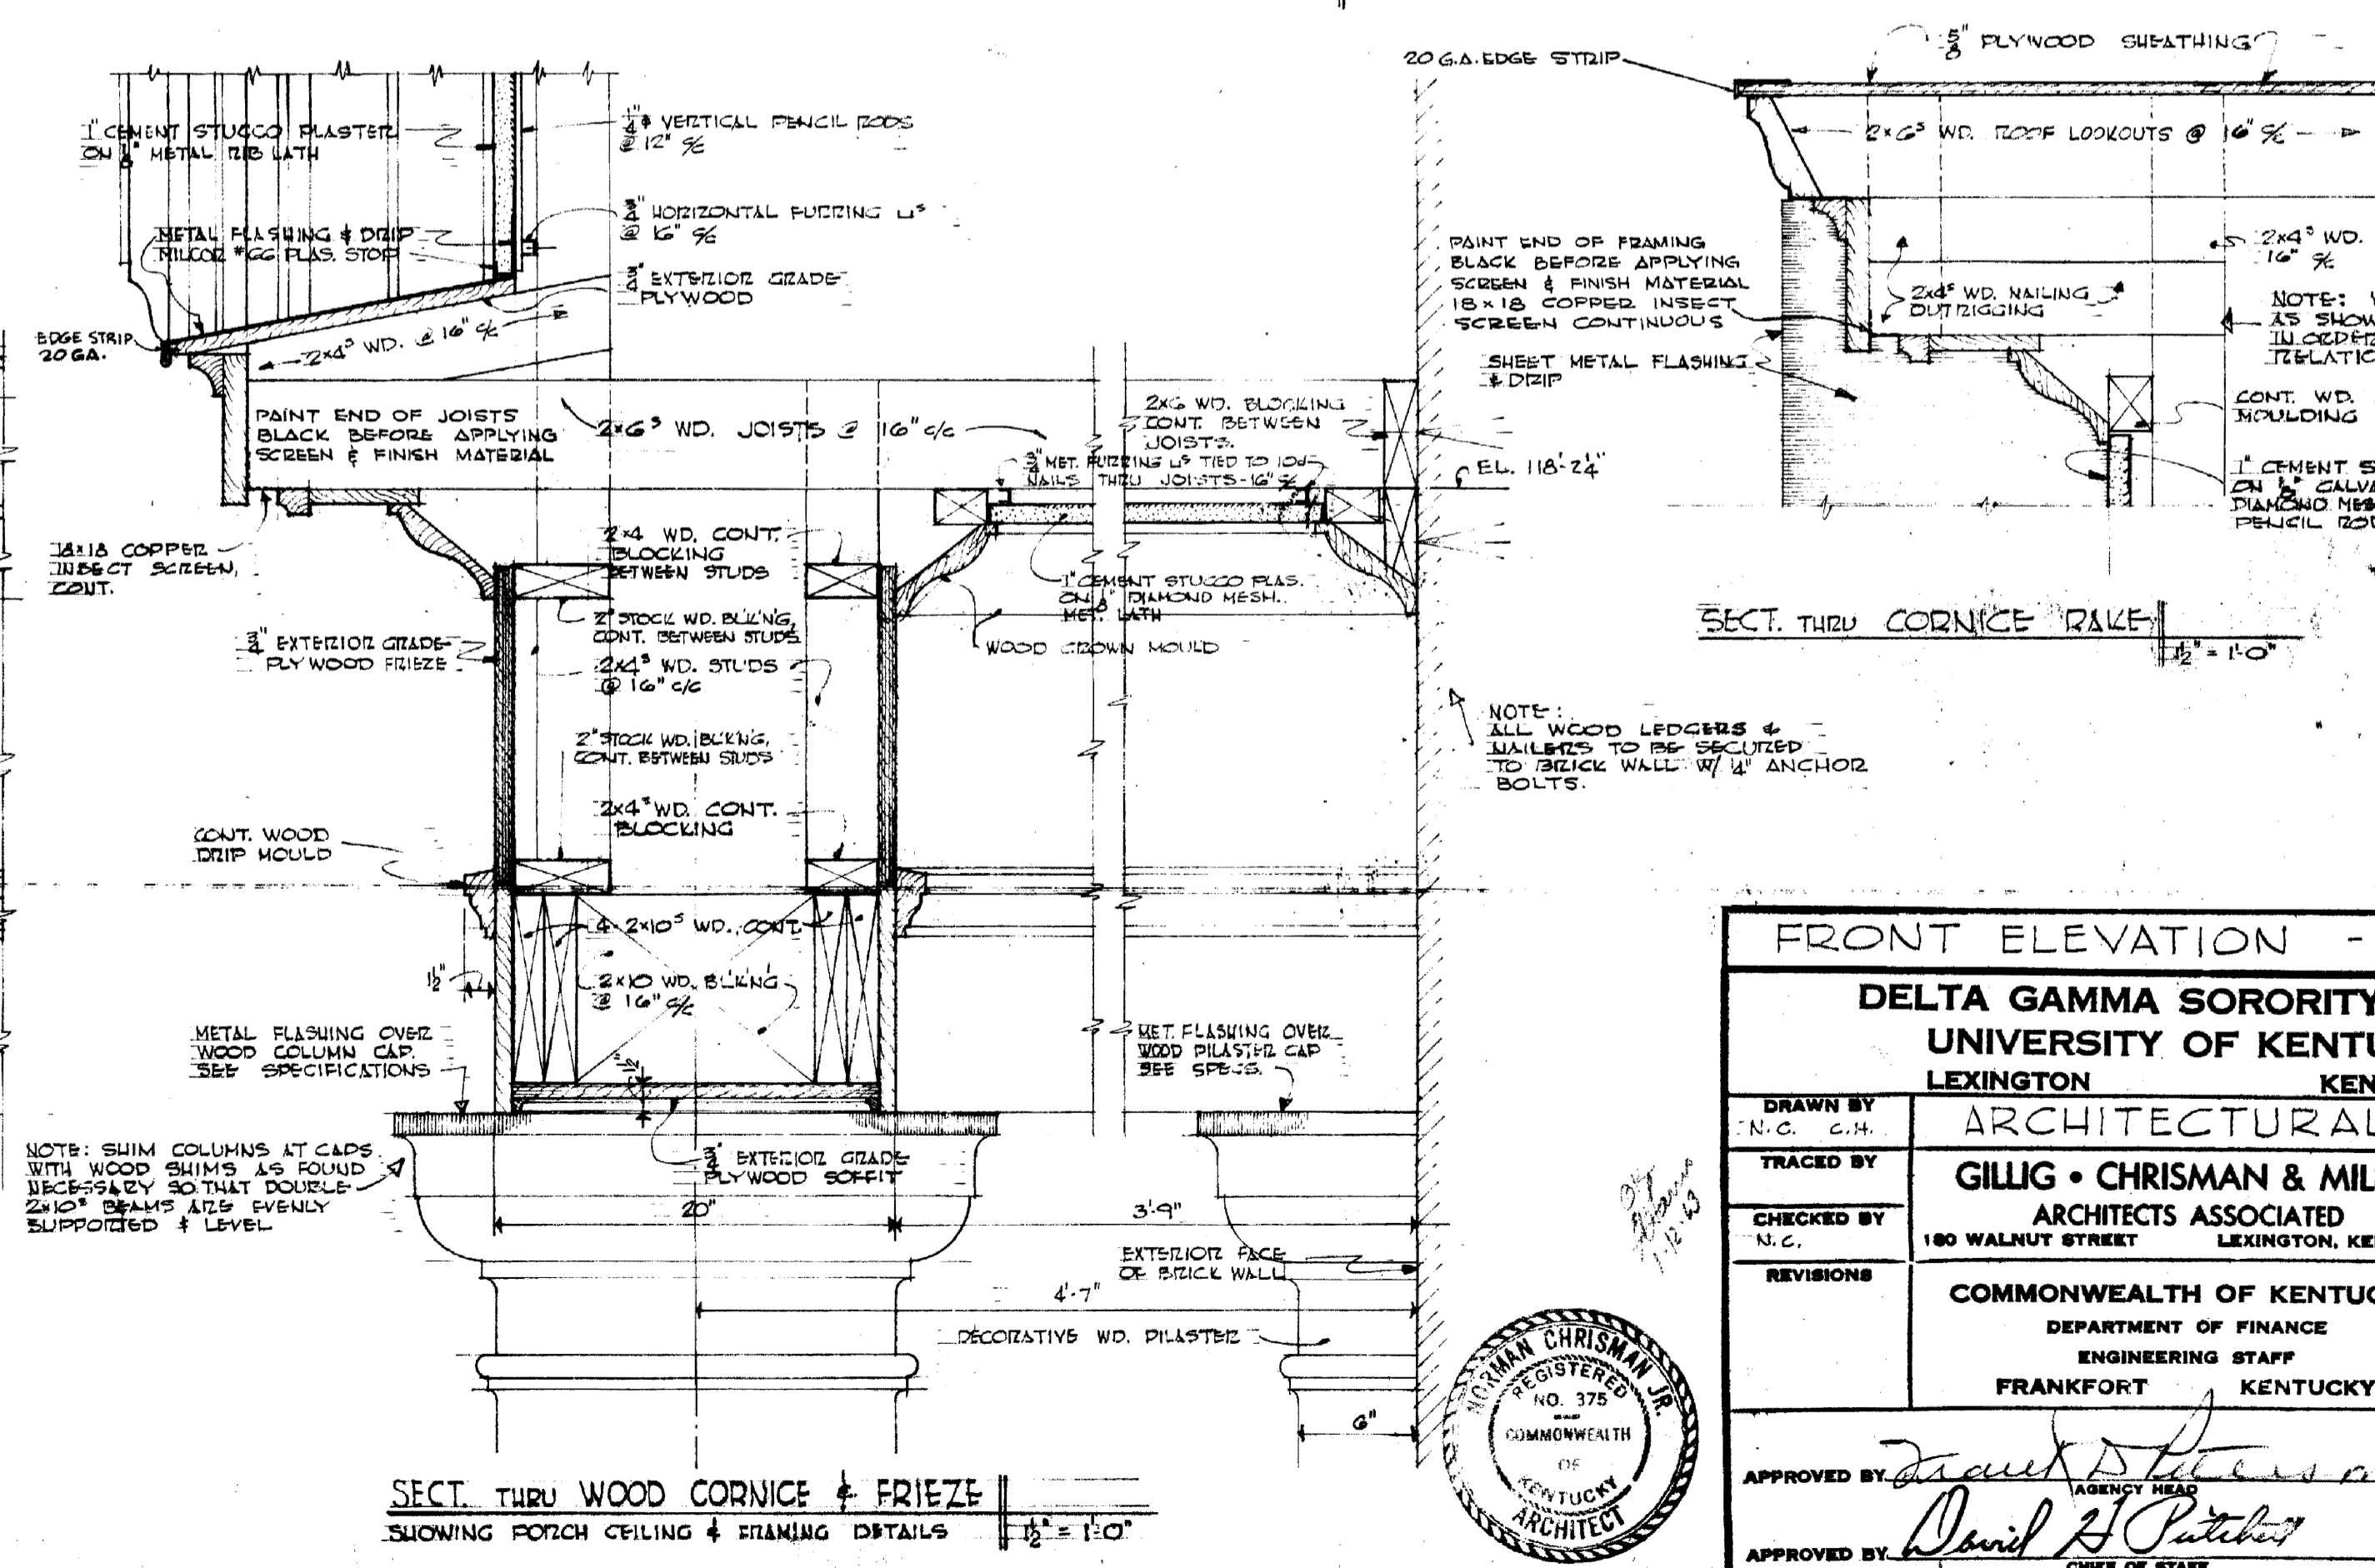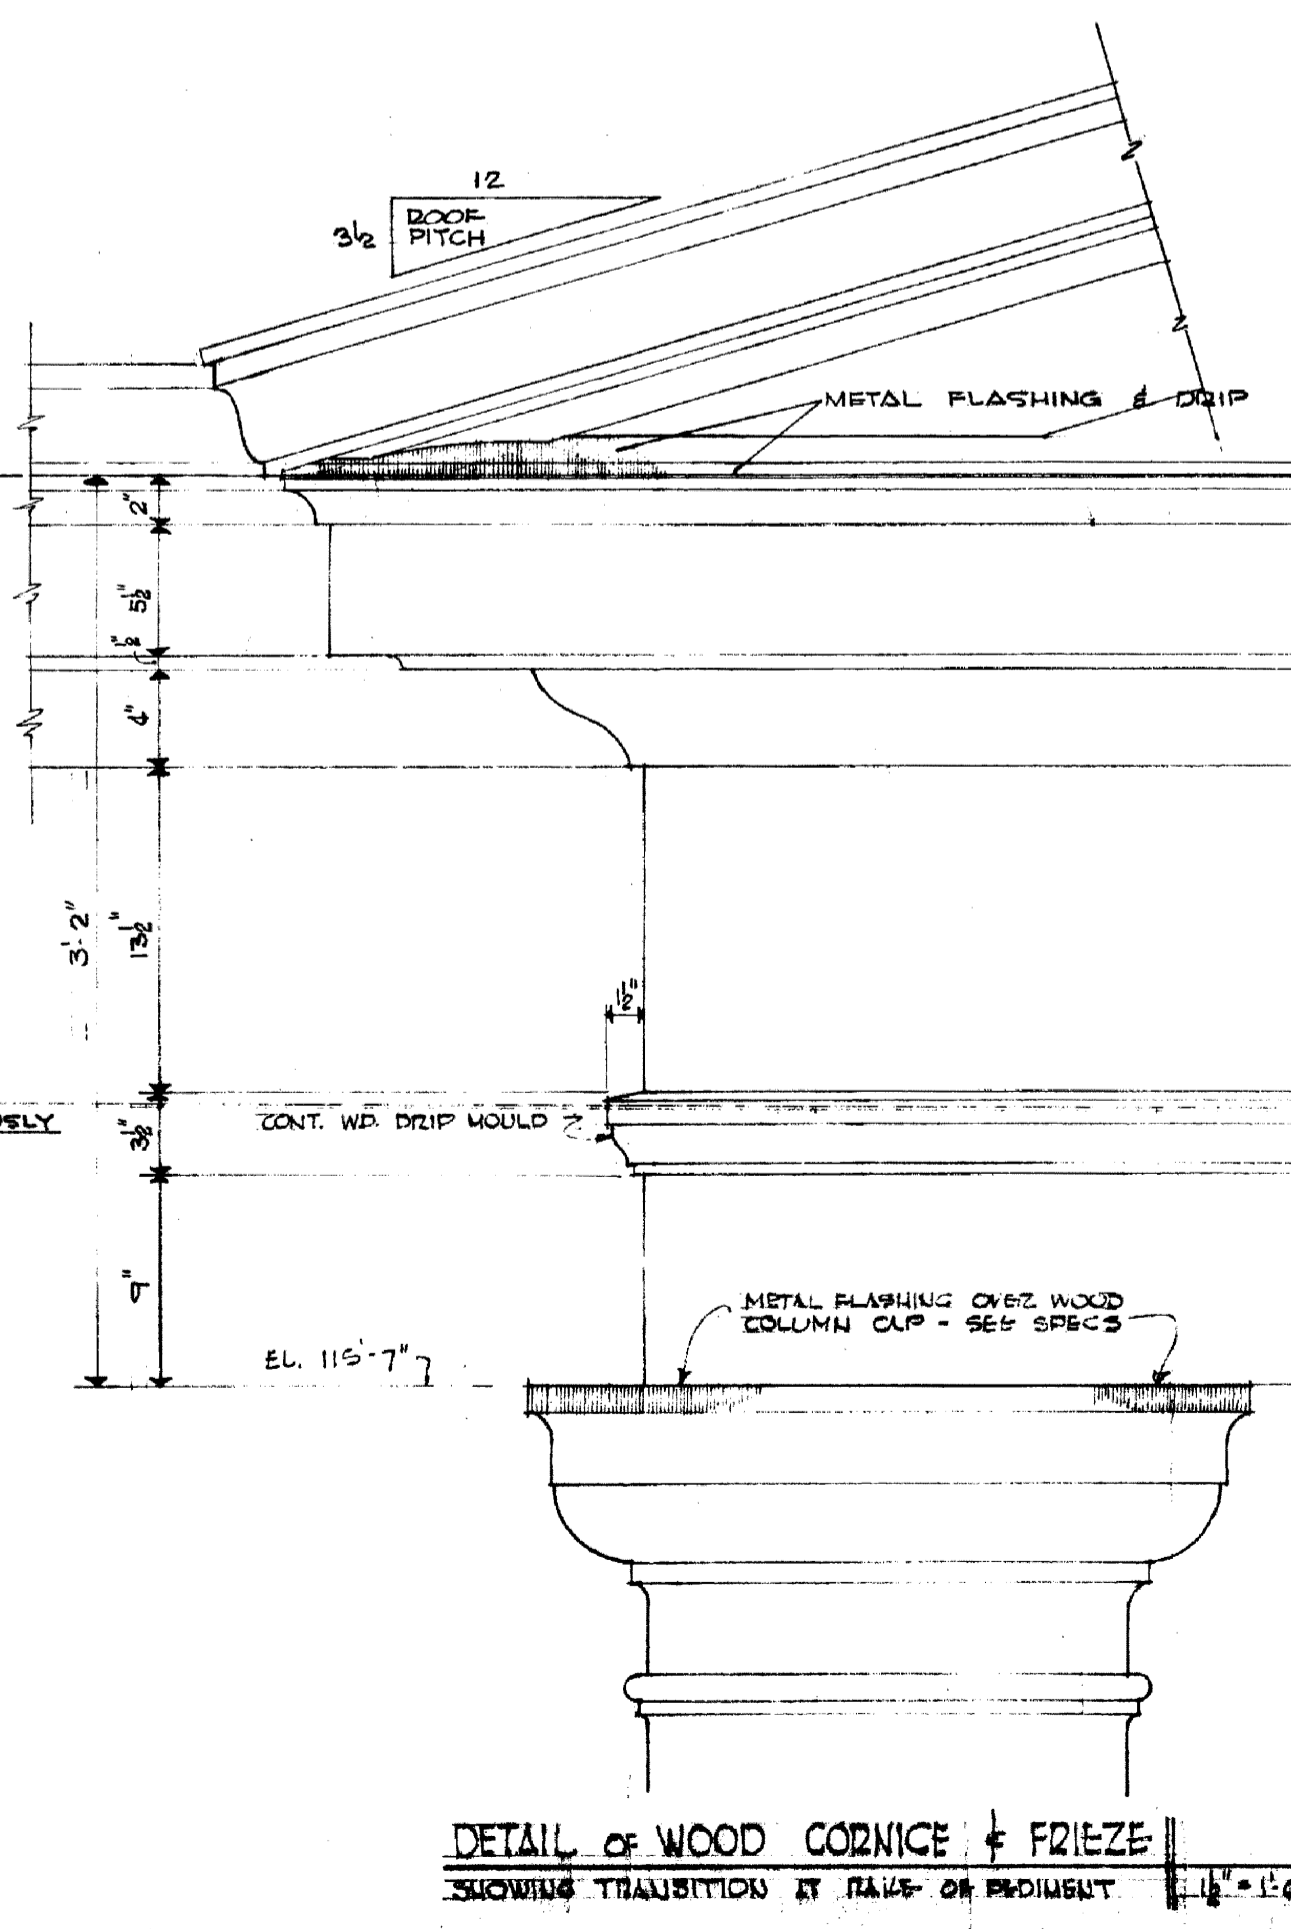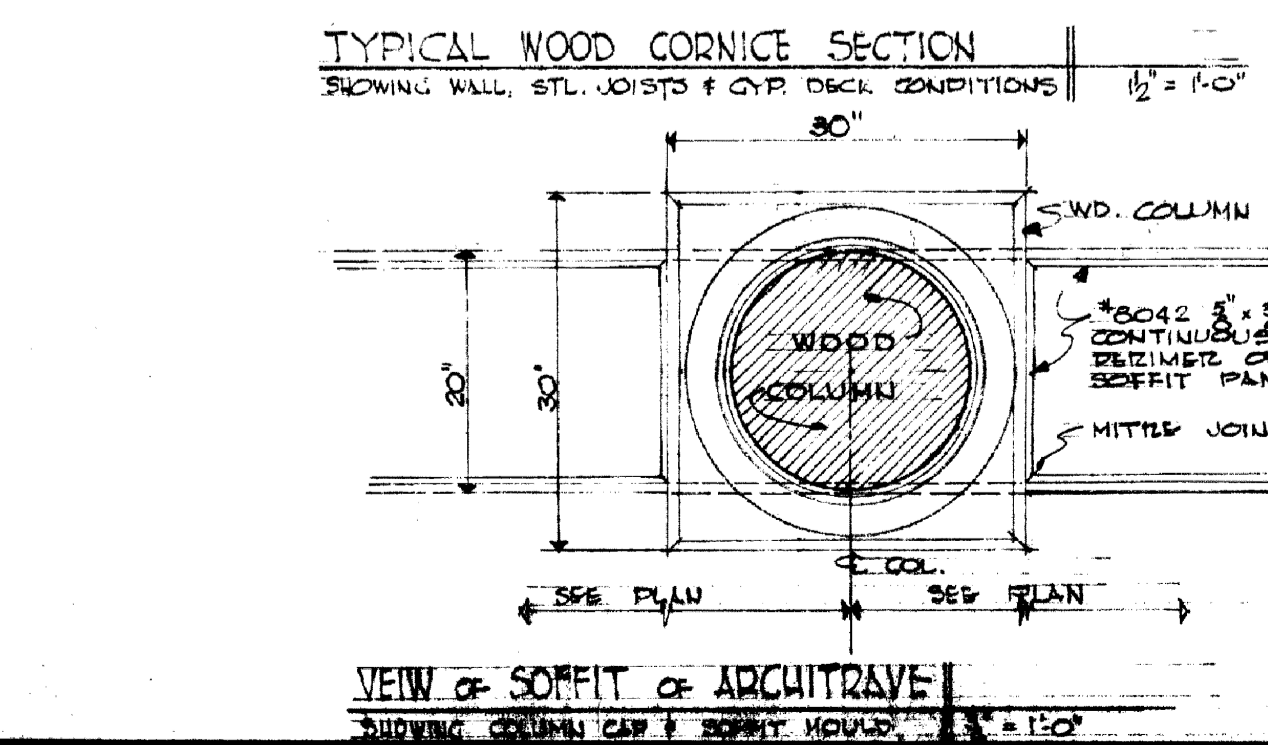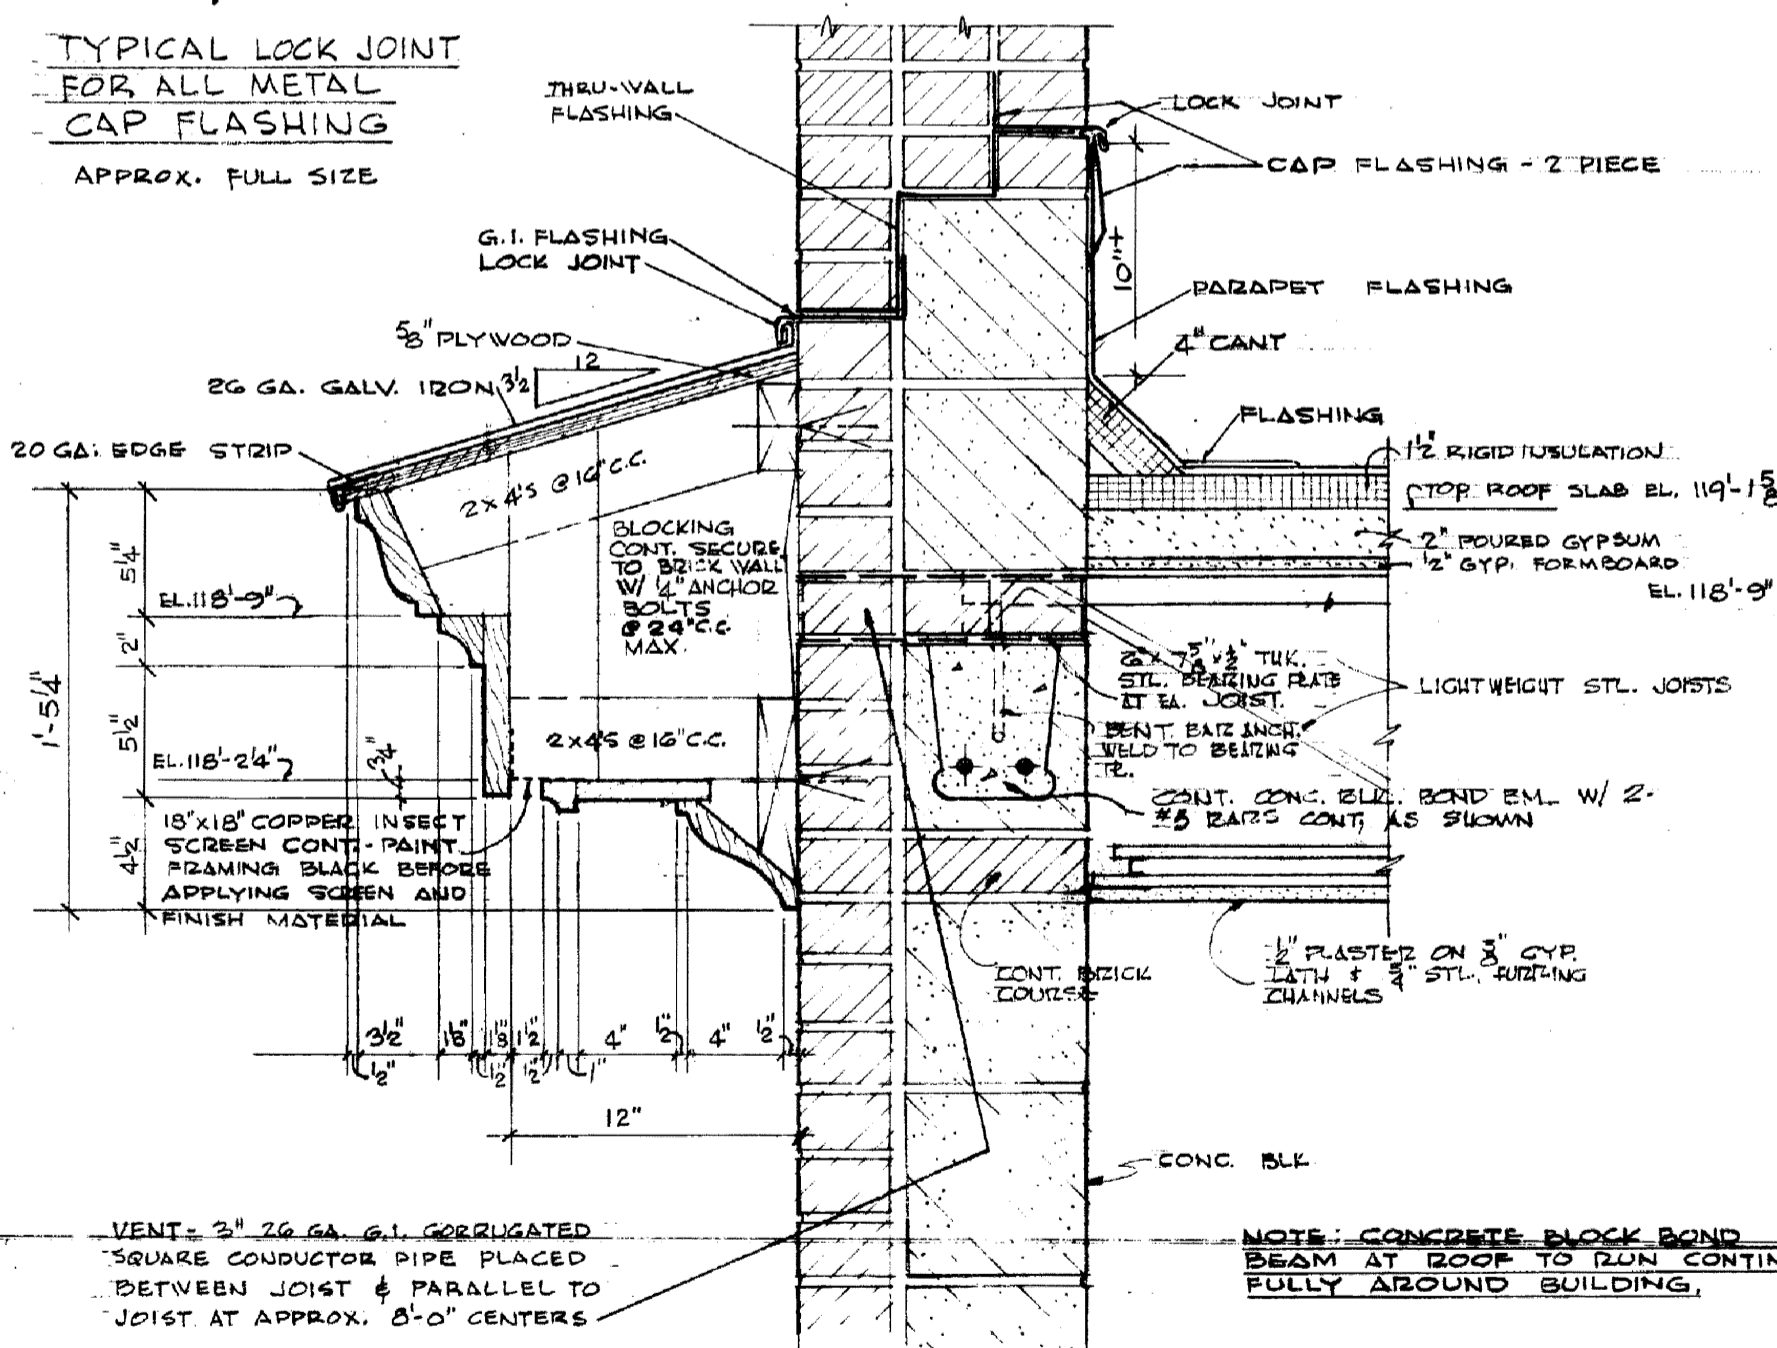



FRONT ELEVATION - DETAILS			
DELTA GAMMA SORORITY HOUSE			
UNIVERSITY OF KENTUCKY			
LEXINGTON KENTUCKY			
DRAWN BY N.C. C.H.	ARCHITECTURAL	DATE 1-8-33	
TRACED BY GILLIG • CHRISMAN & MILLER		SCALE AS SHOWN	
CHECKED BY N.C.	ARCHITECTS ASSOCIATED	SPEC. NO.	
REVISIONS	180 WALNUT STREET LEXINGTON, KENTUCKY	DRAWING NO.	
	COMMONWEALTH OF KENTUCKY		
	DEPARTMENT OF FINANCE		
	ENGINEERING STAFF		
	FRANKFORT KENTUCKY		
APPROVED BY <i>David J. Pritchard</i>	AGENCY HEAD	DATE	
APPROVED BY <i>David J. Pritchard</i>	CHIEF OF STAFF	DATE	

U-1888

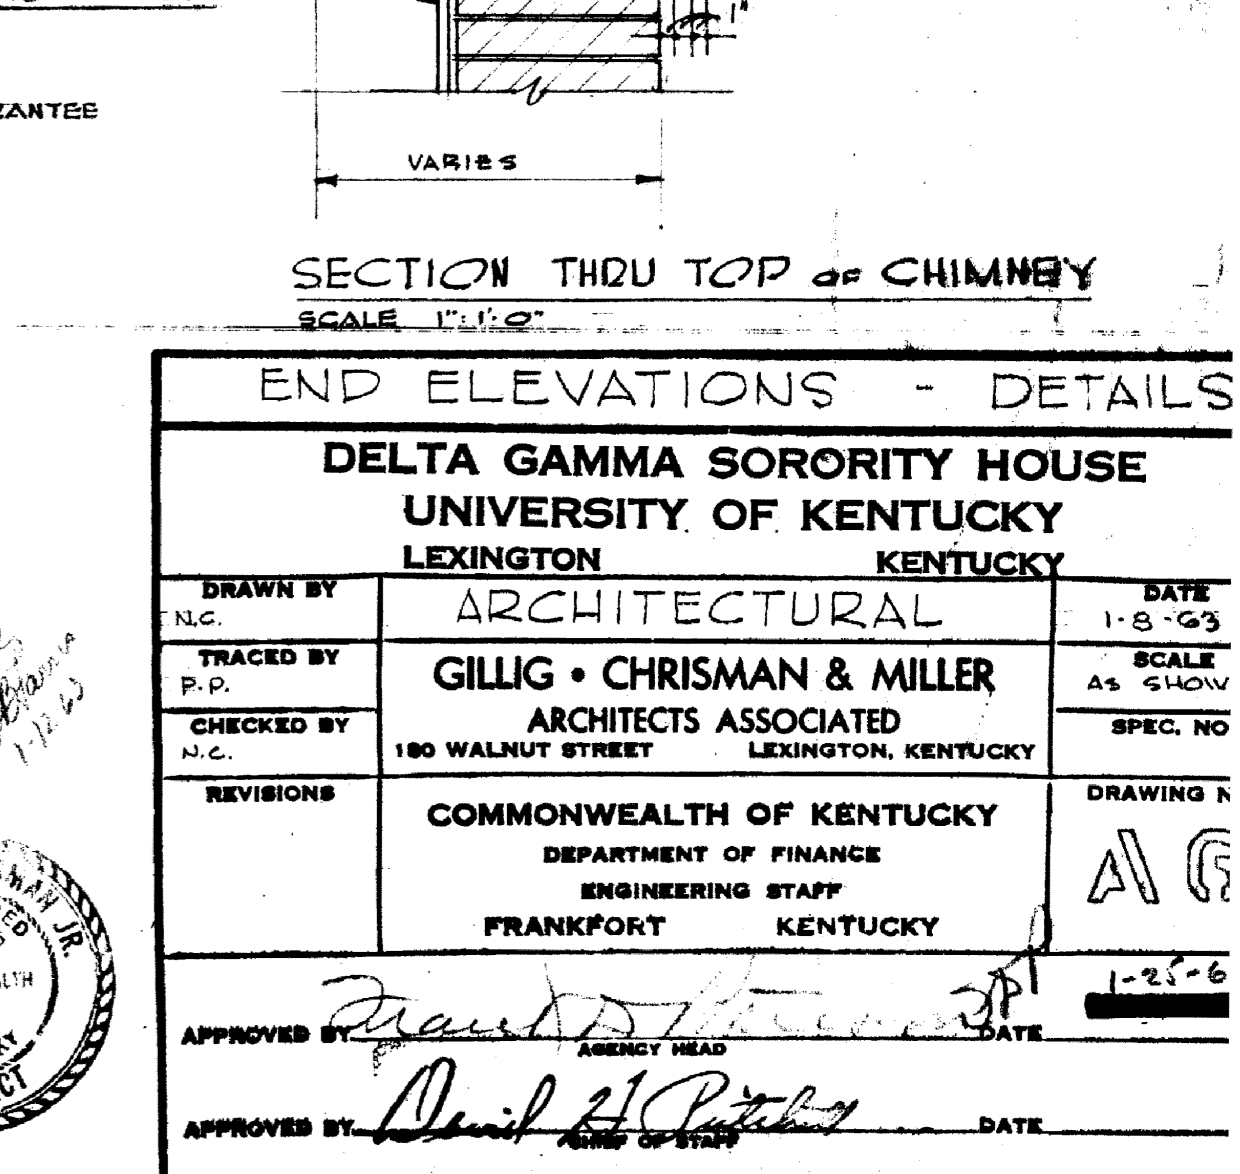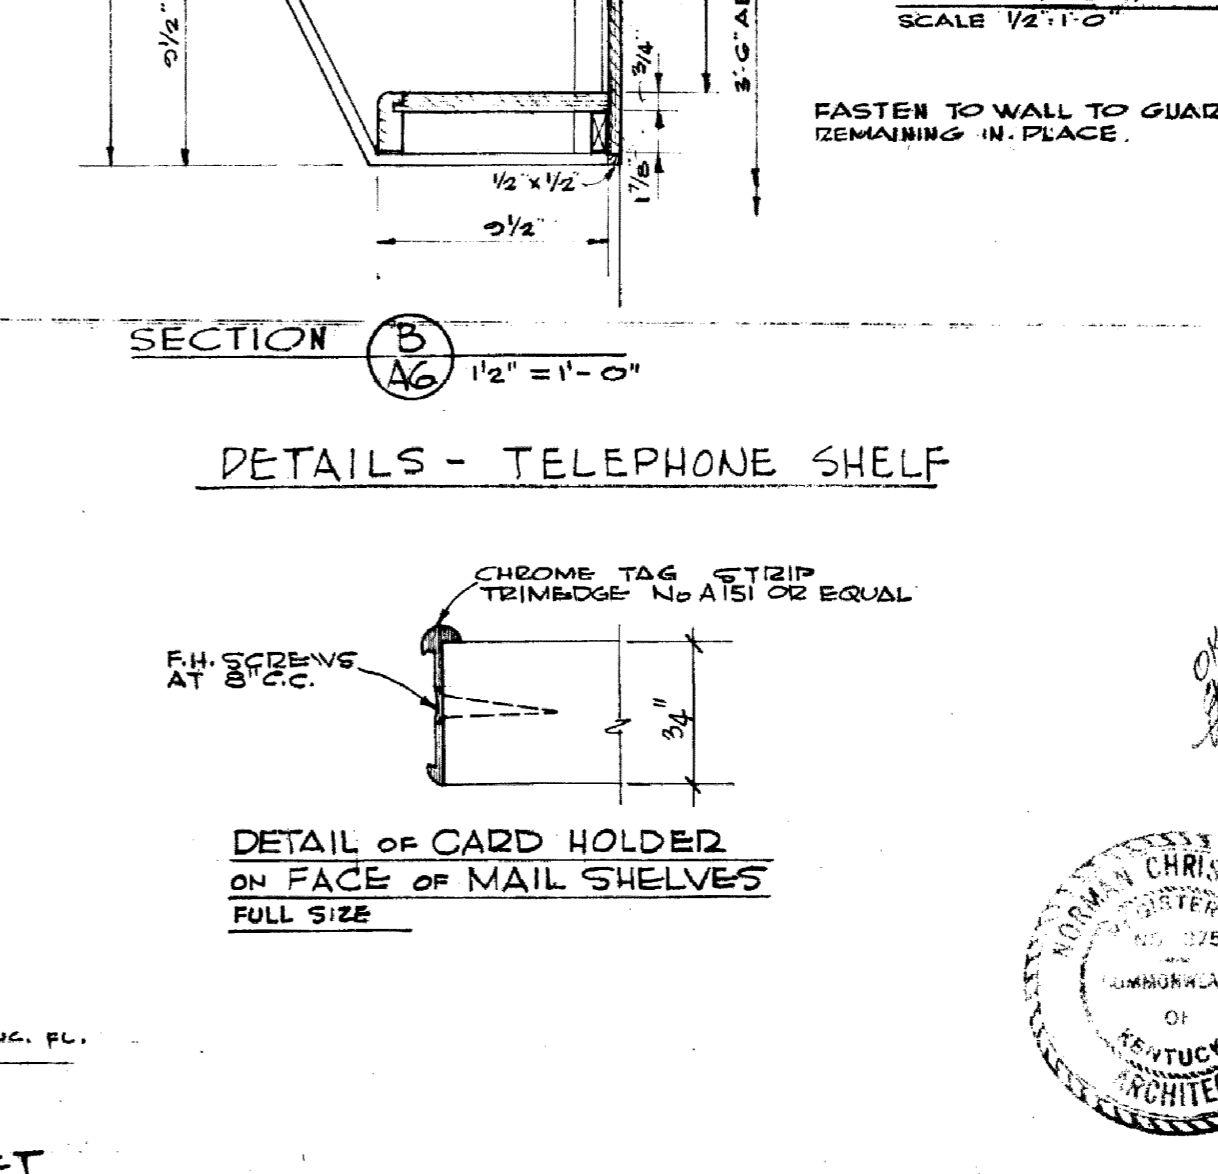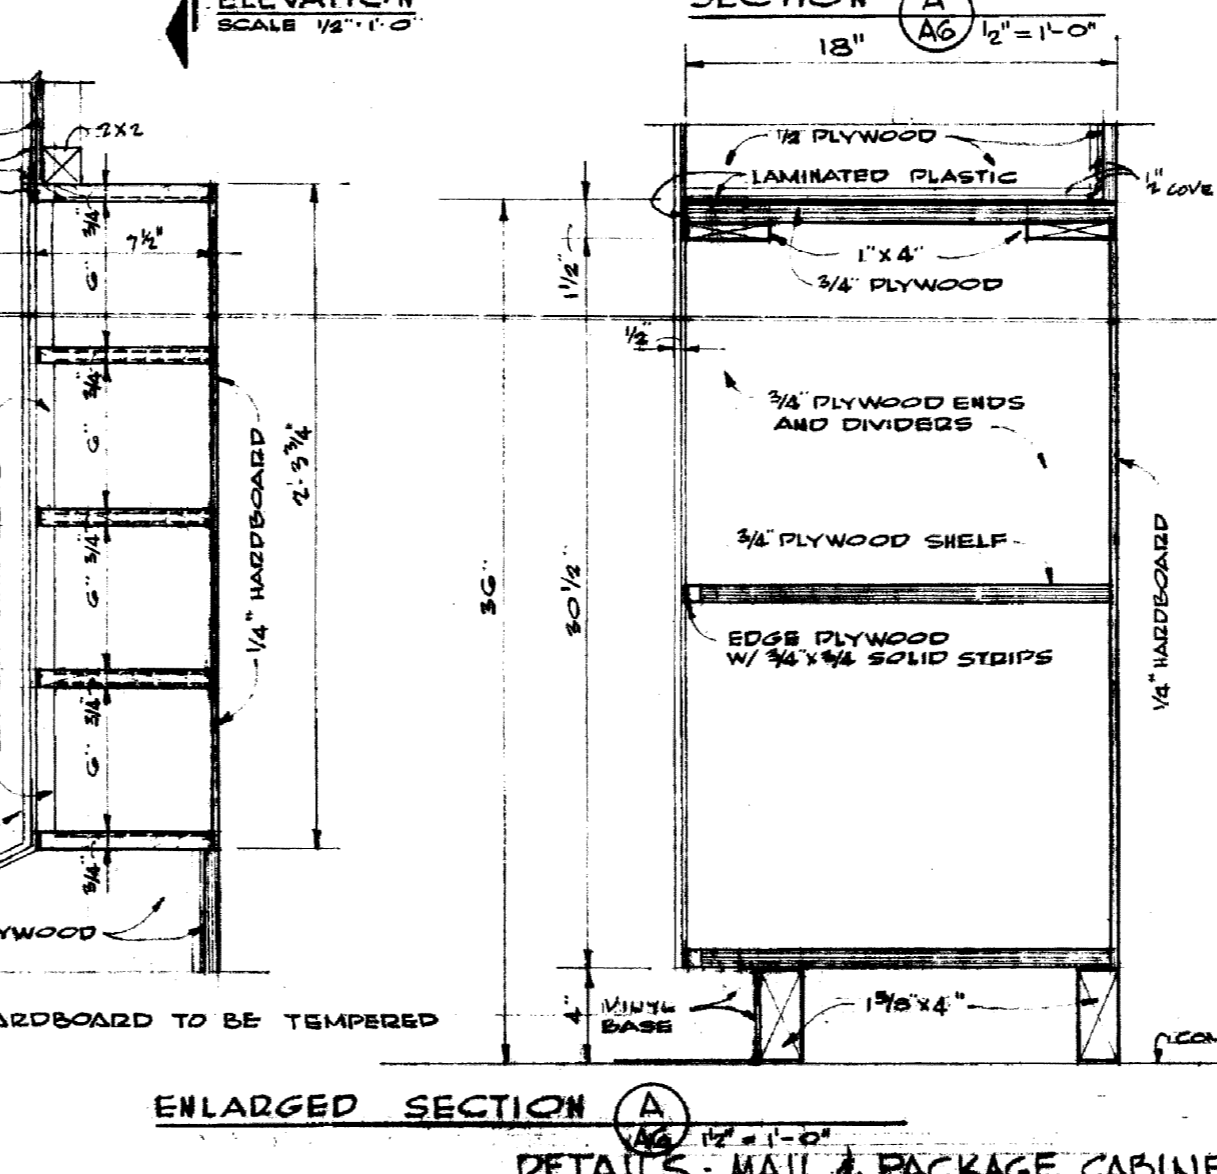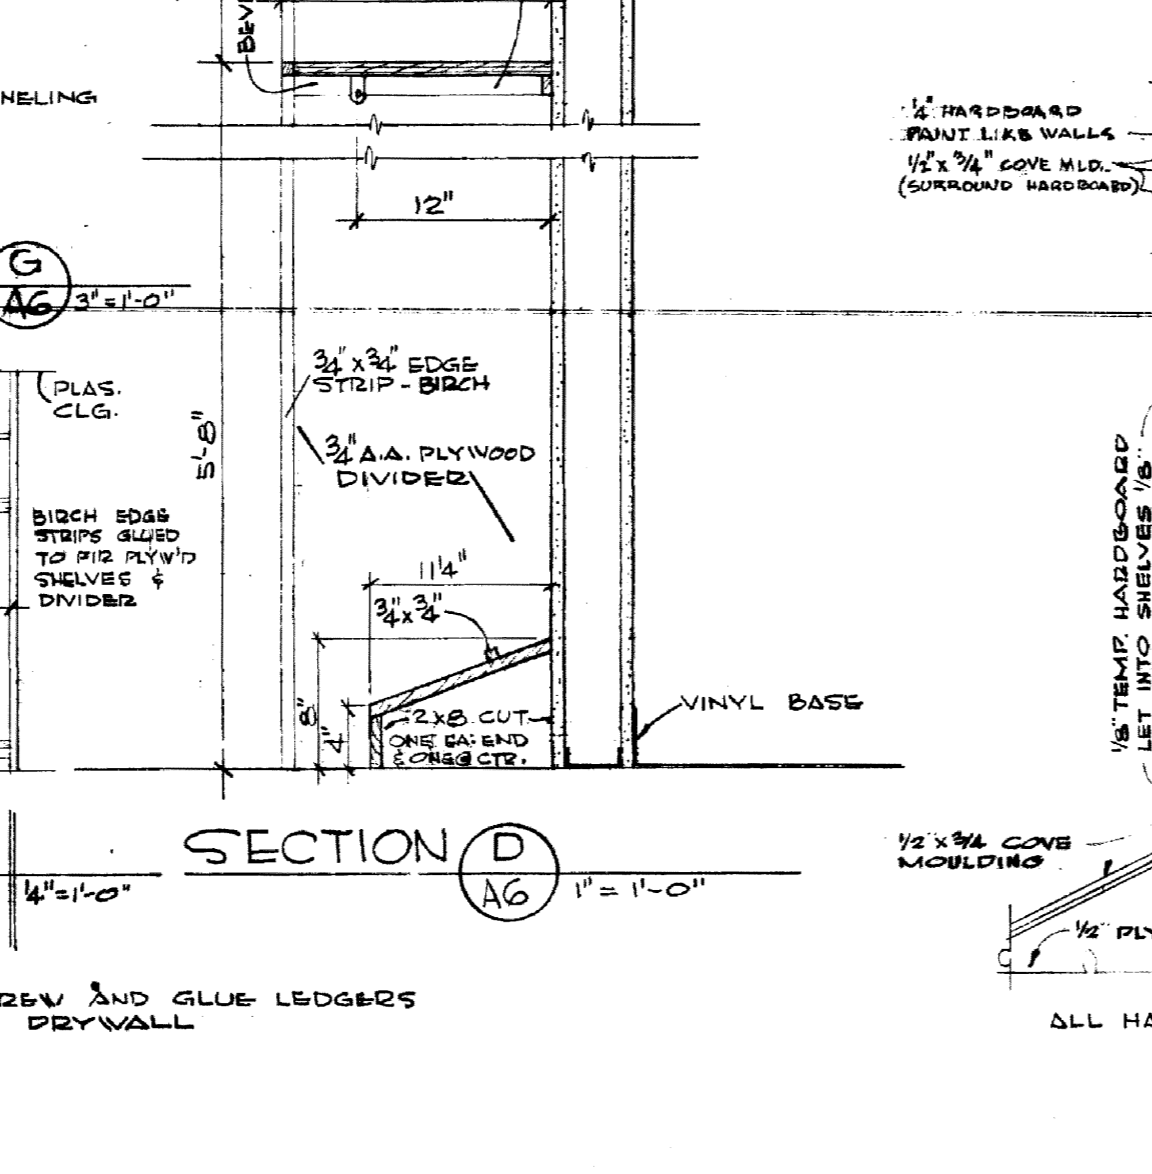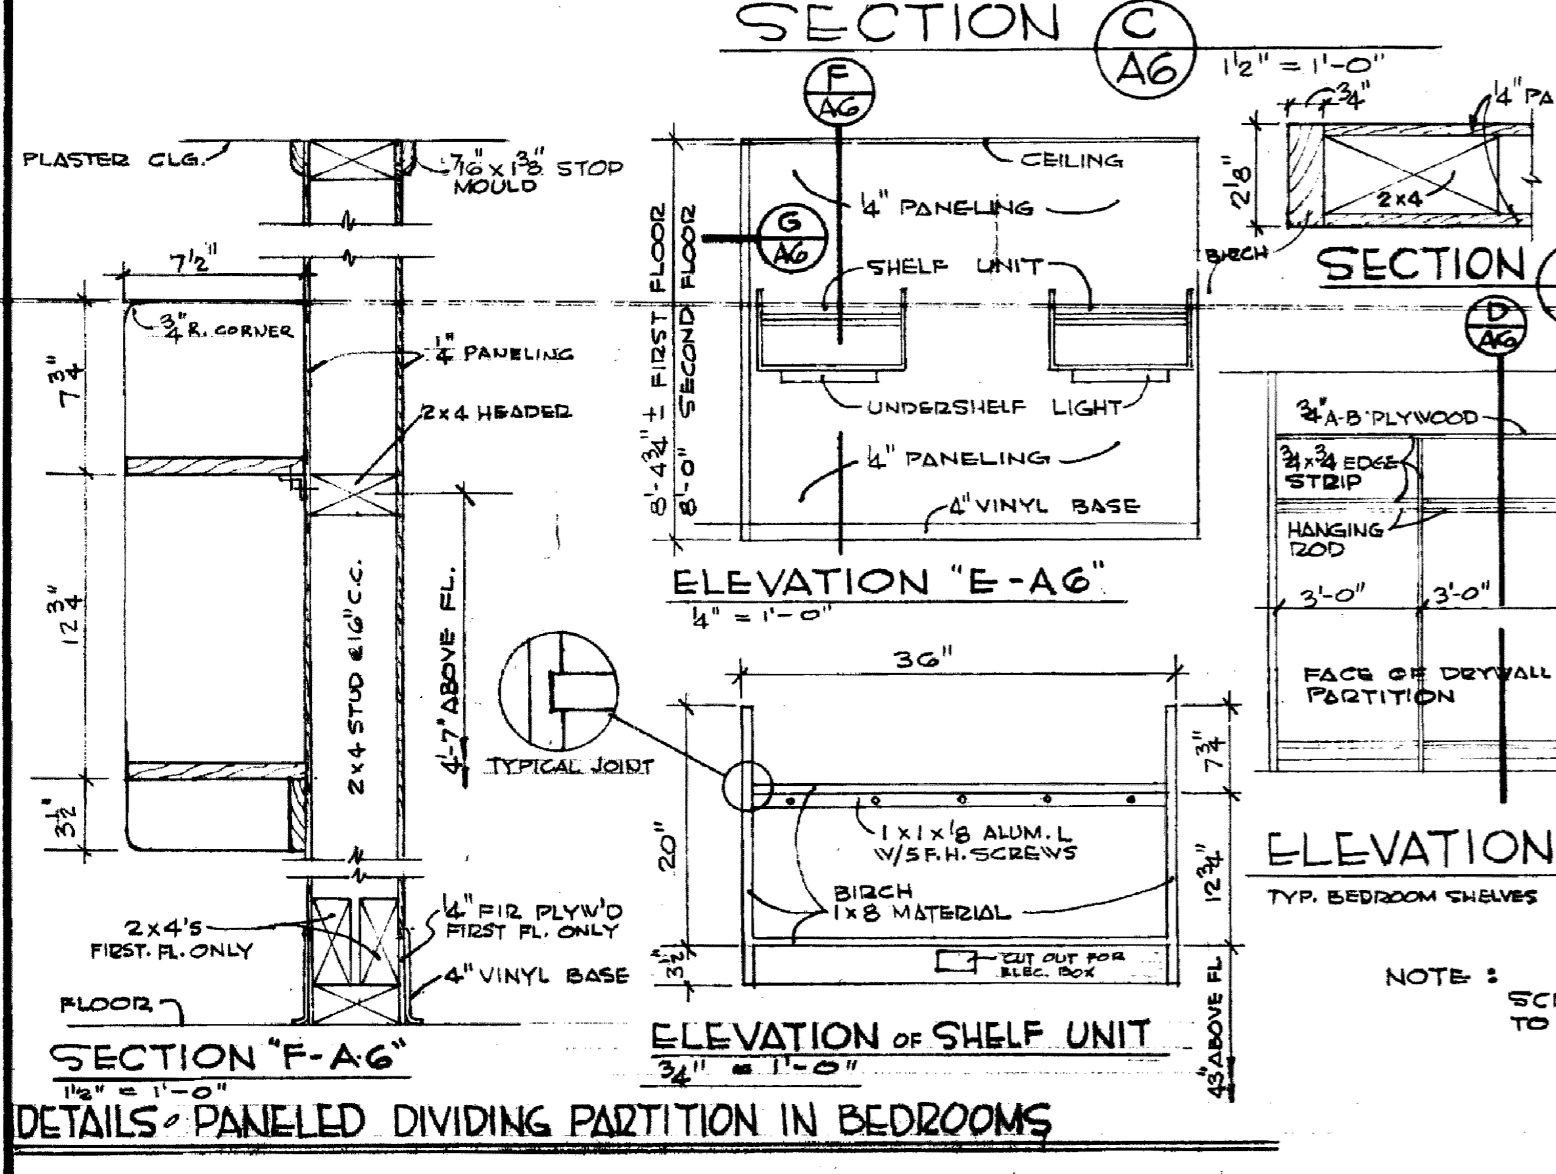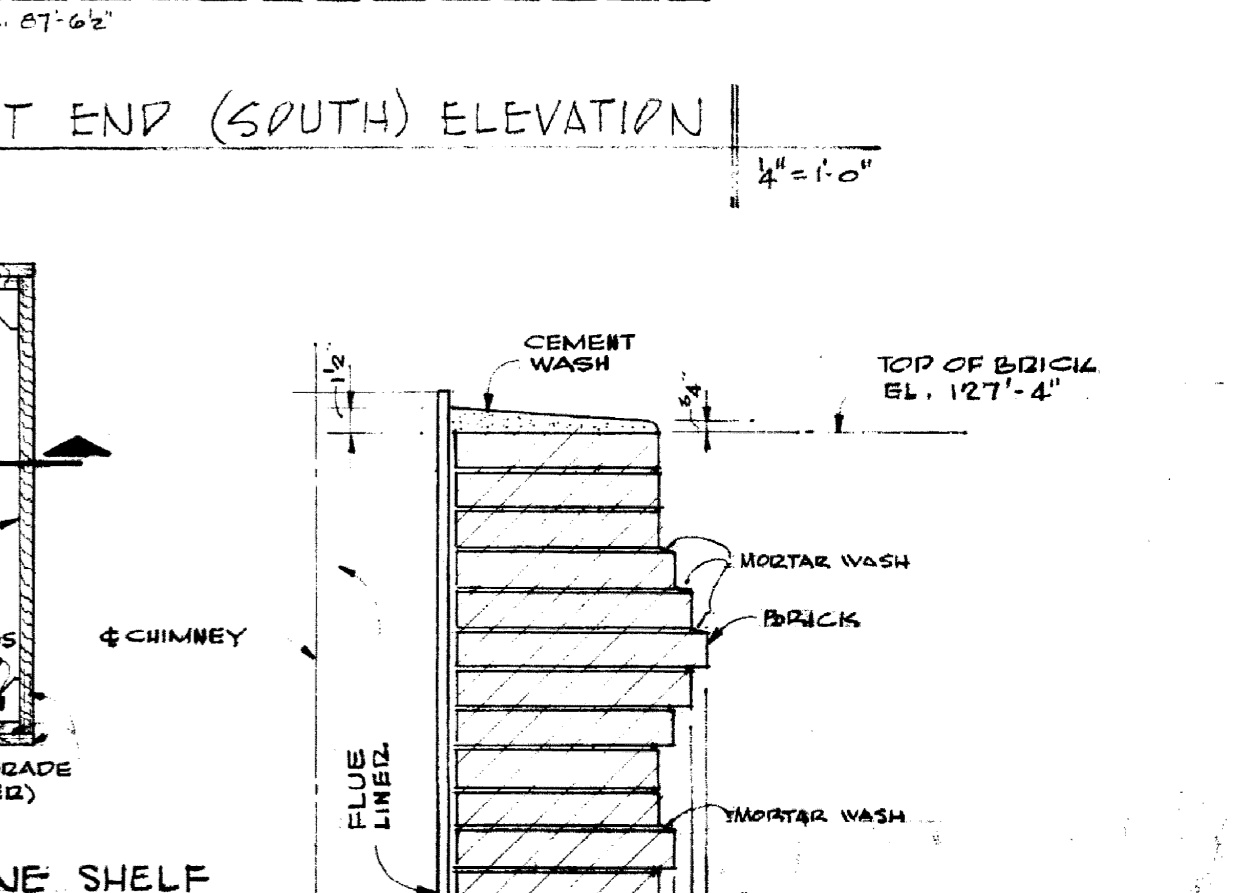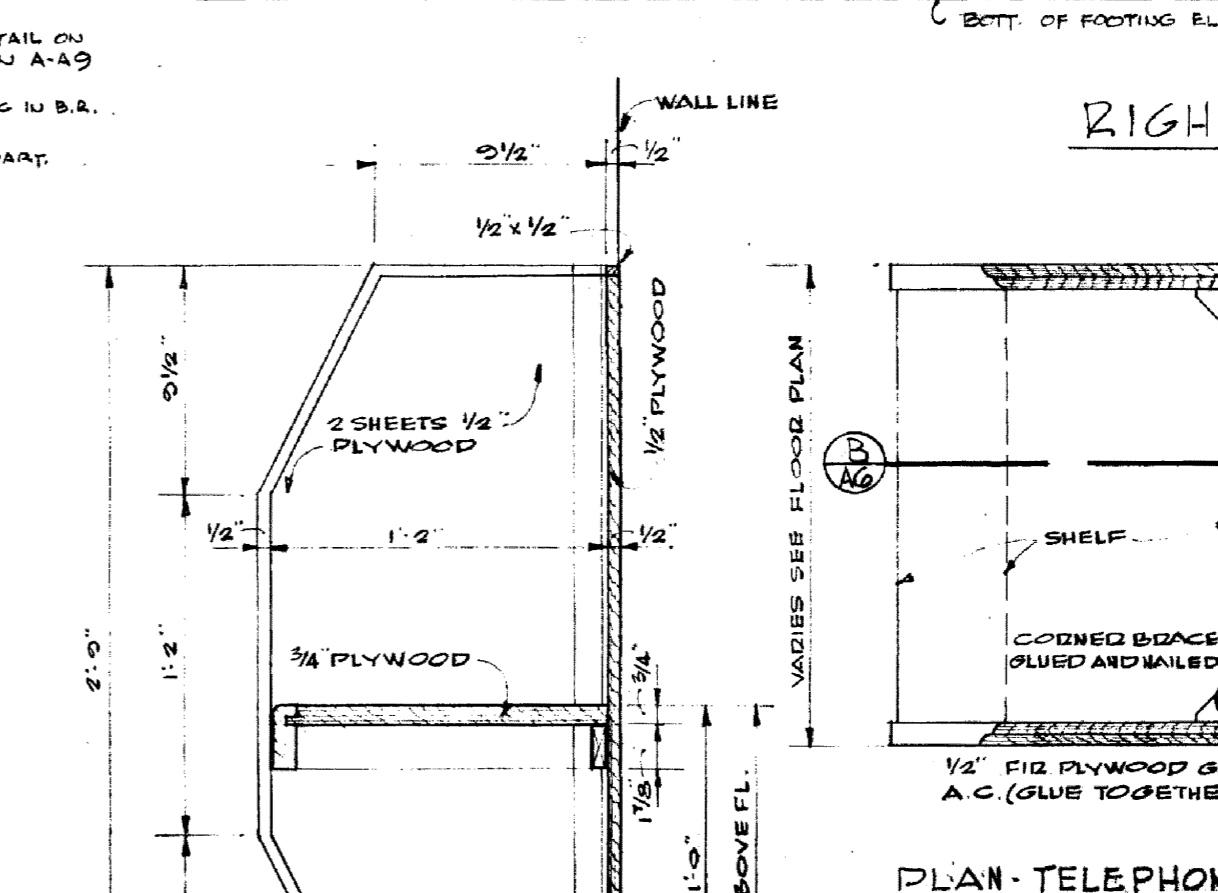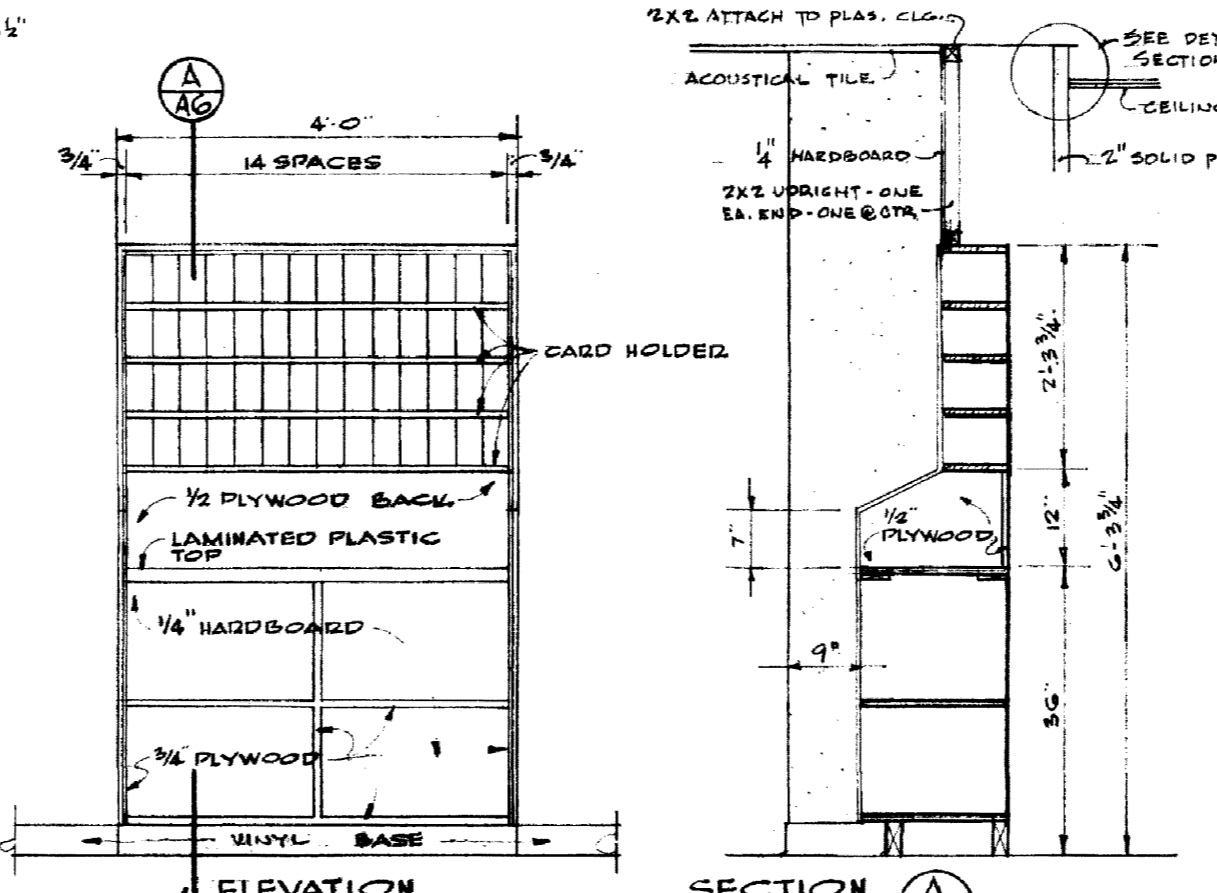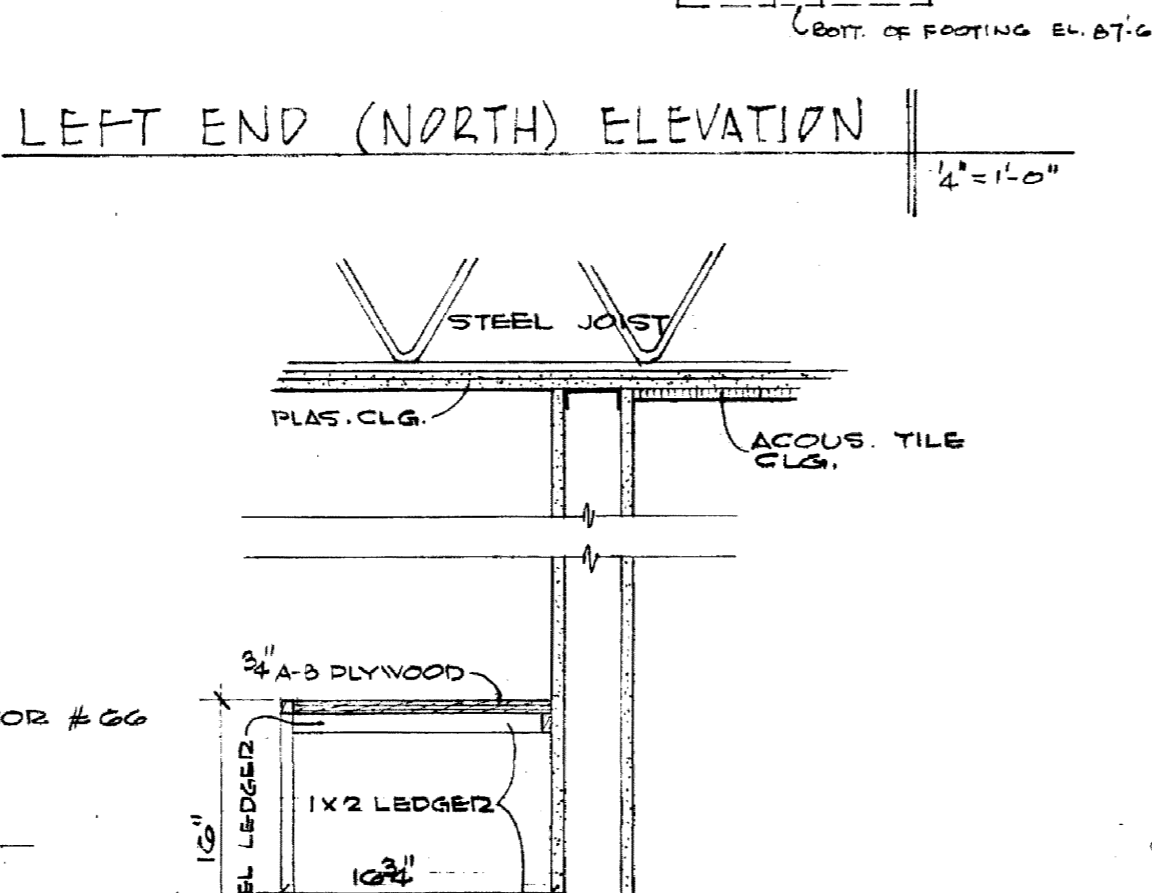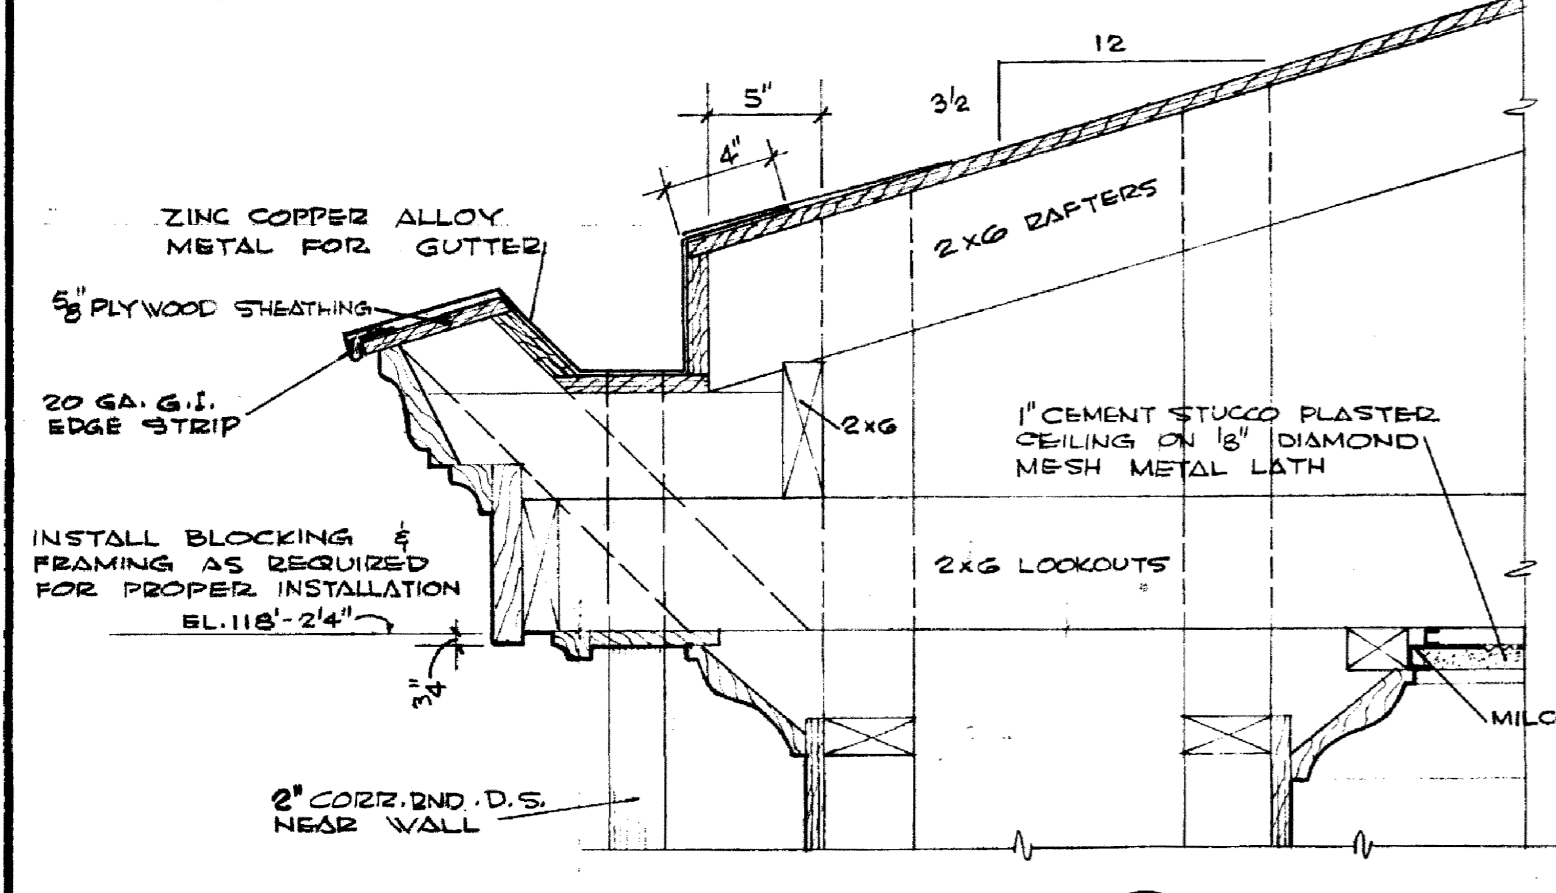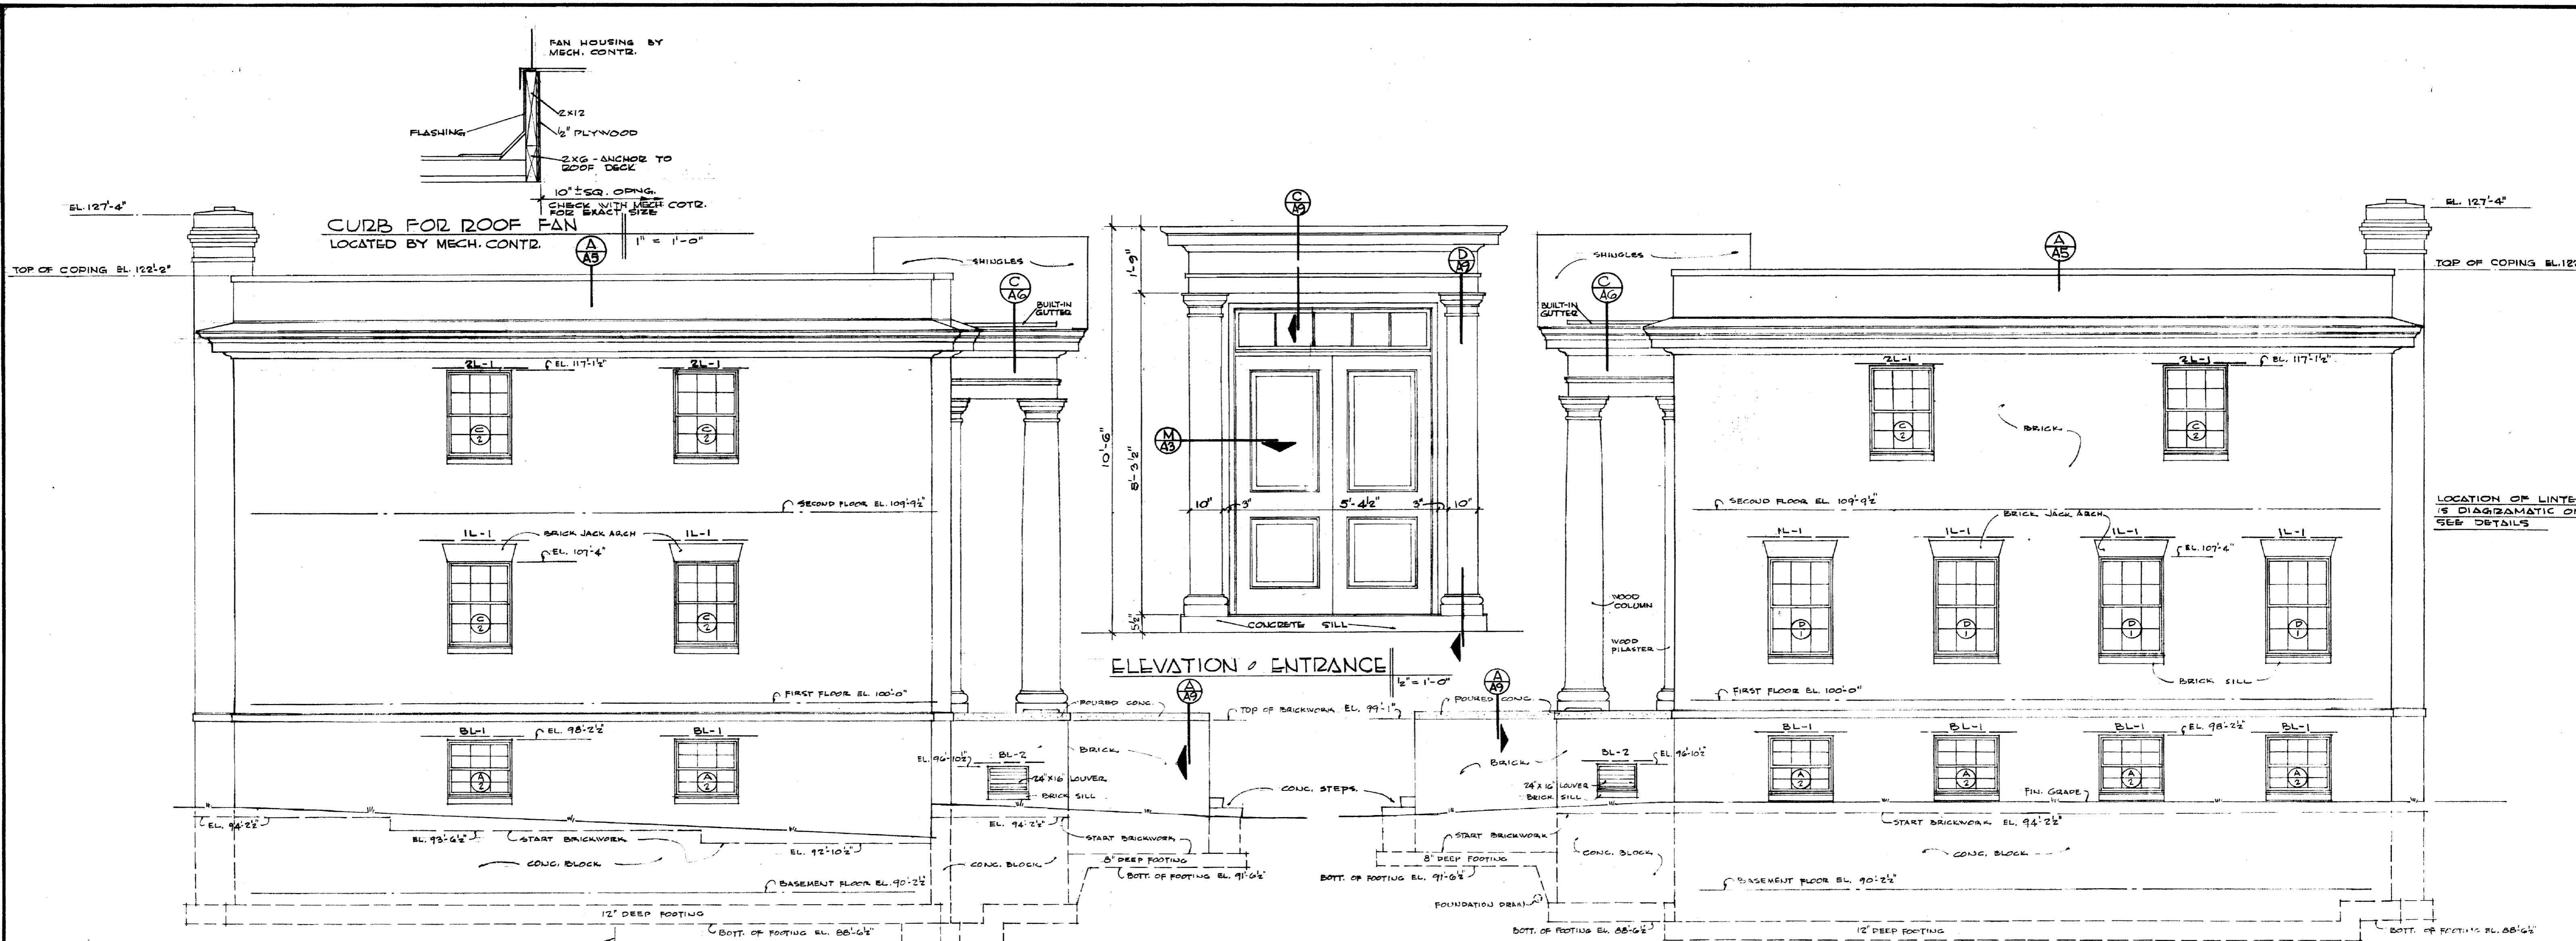


END ELEVATIONS - DETAILS			
DELTA GAMMA SORORITY HOUSE UNIVERSITY OF KENTUCKY LEXINGTON, KENTUCKY			
DRAWN BY N.C.	ARCHITECTURAL	DATE 1-5-59	SCALE AS SHOWN
TRACED BY N.C.	GILLIG • CHRISMAN & MILLER ARCHITECTS ASSOCIATED 180 WALNUT STREET LEXINGTON, KENTUCKY	SPEC. NO.	
CHECKED BY N.C.		DRAWING NO.	
REVISIONS	COMMONWEALTH OF KENTUCKY DEPARTMENT OF FINANCE ENGINEERING STAFF FRANKFORT, KENTUCKY	DATE	
APPROVED BY: <i>[Signature]</i>		DATE	
APPROVED BY: <i>[Signature]</i>		DATE	

U-1889

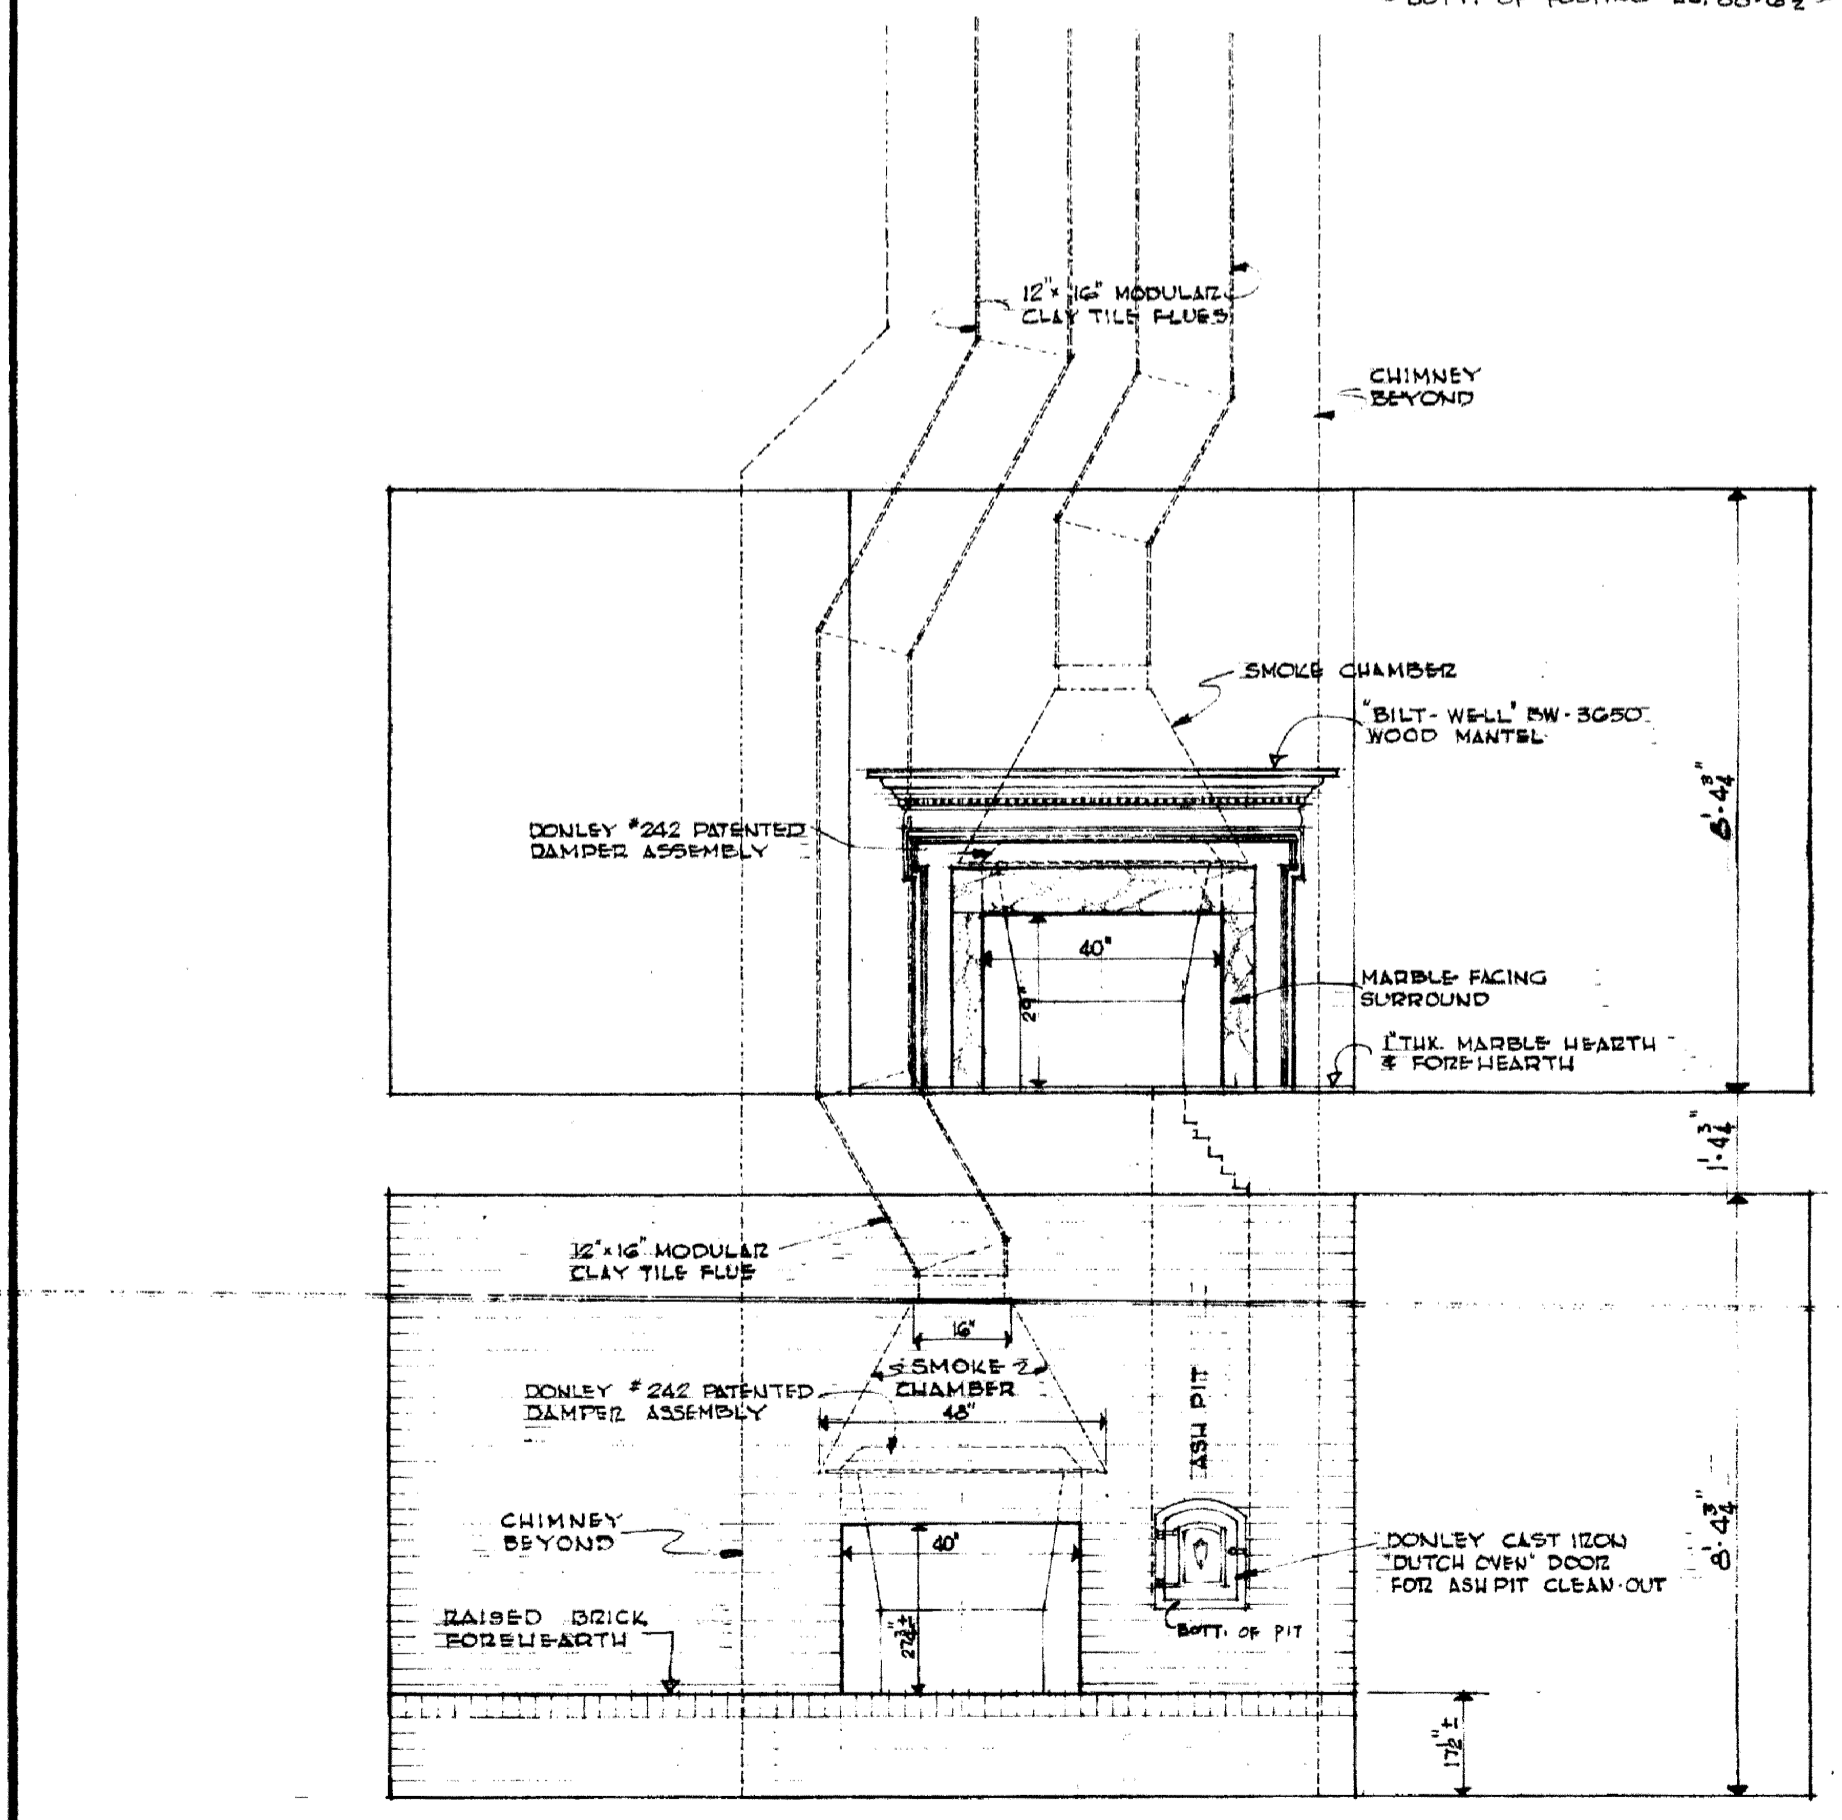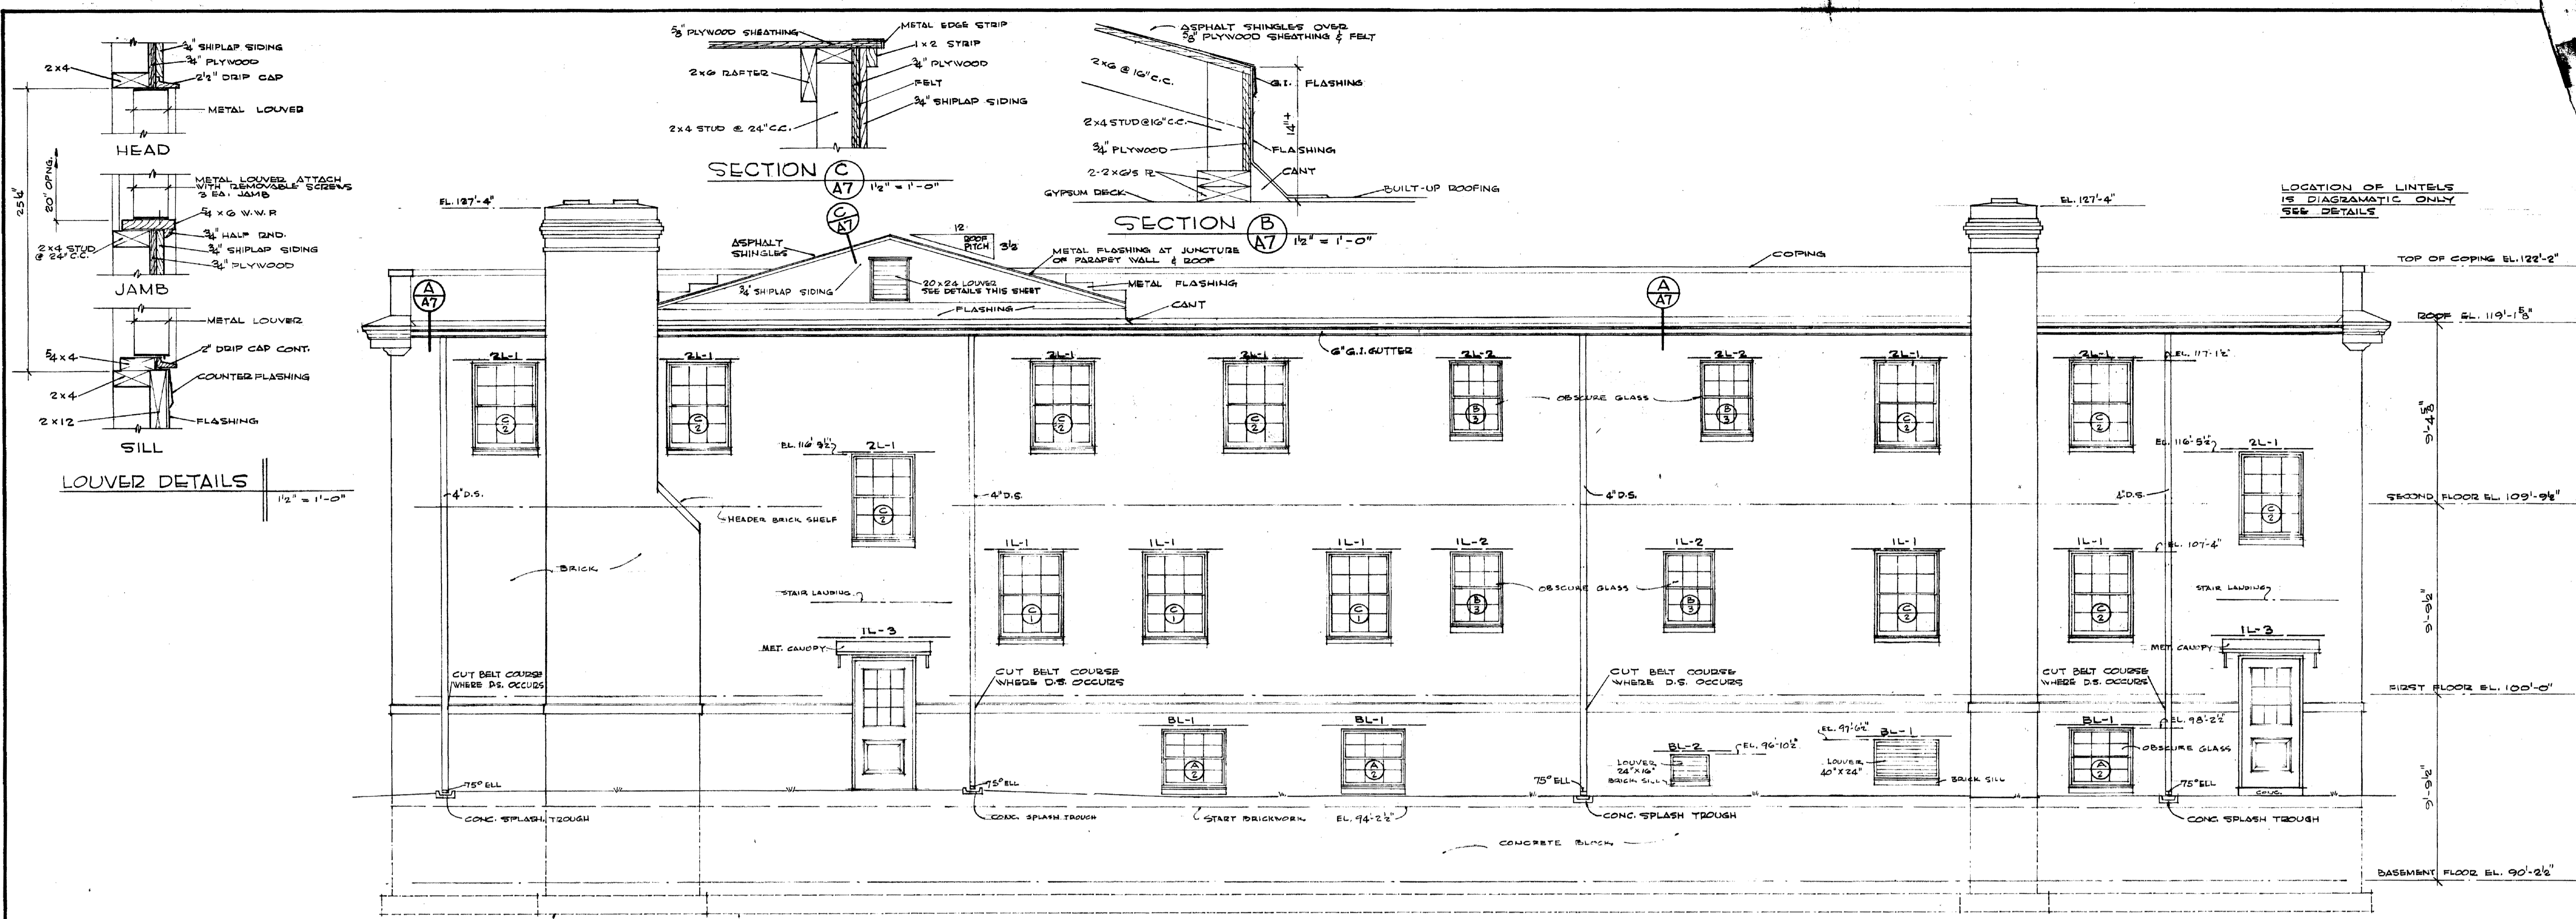


ELEVATION OF FIREPLACES
SHOWING DISPOSITION OF FLUES, ASH PIT, SMOKE CHAMBERS, DAMPERS, ETC. 3/8" = 1'-0"


NOTE: IN EACH STAIRWAY AT FLOOR JOIST LEVEL CUT CONC. BLOCK TO BL IN ORDER TO START BRICKWORK AT FLOOR LEVEL ON COURSE

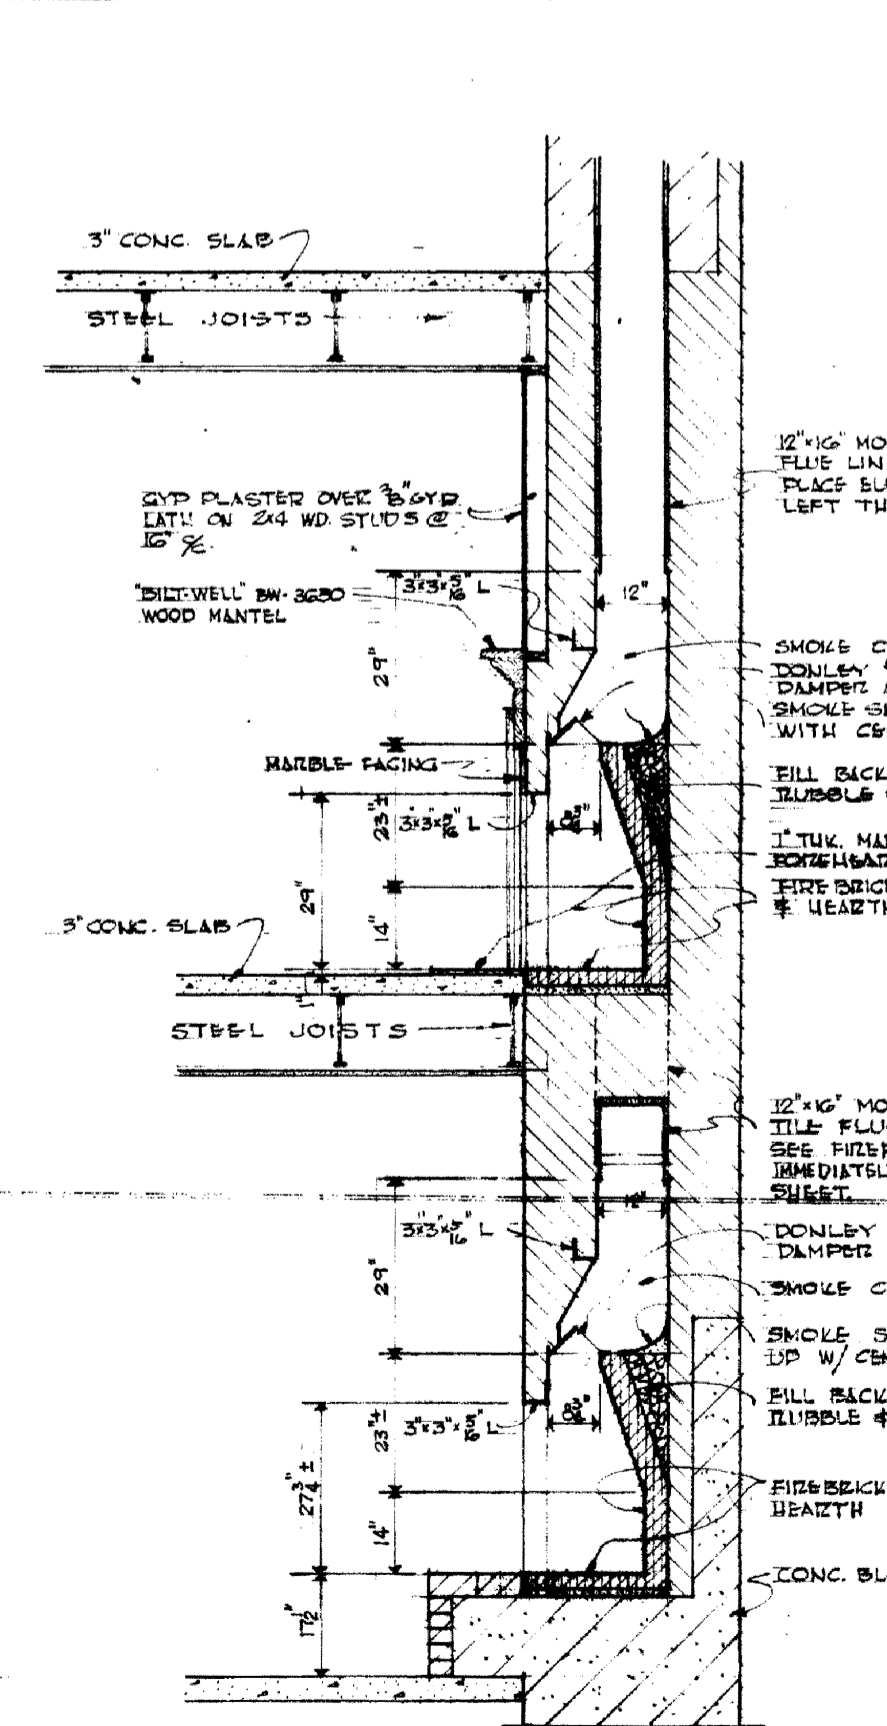


SECTION THRU FIREPLACES & CHIMNEY 1/8" = 1'-0"

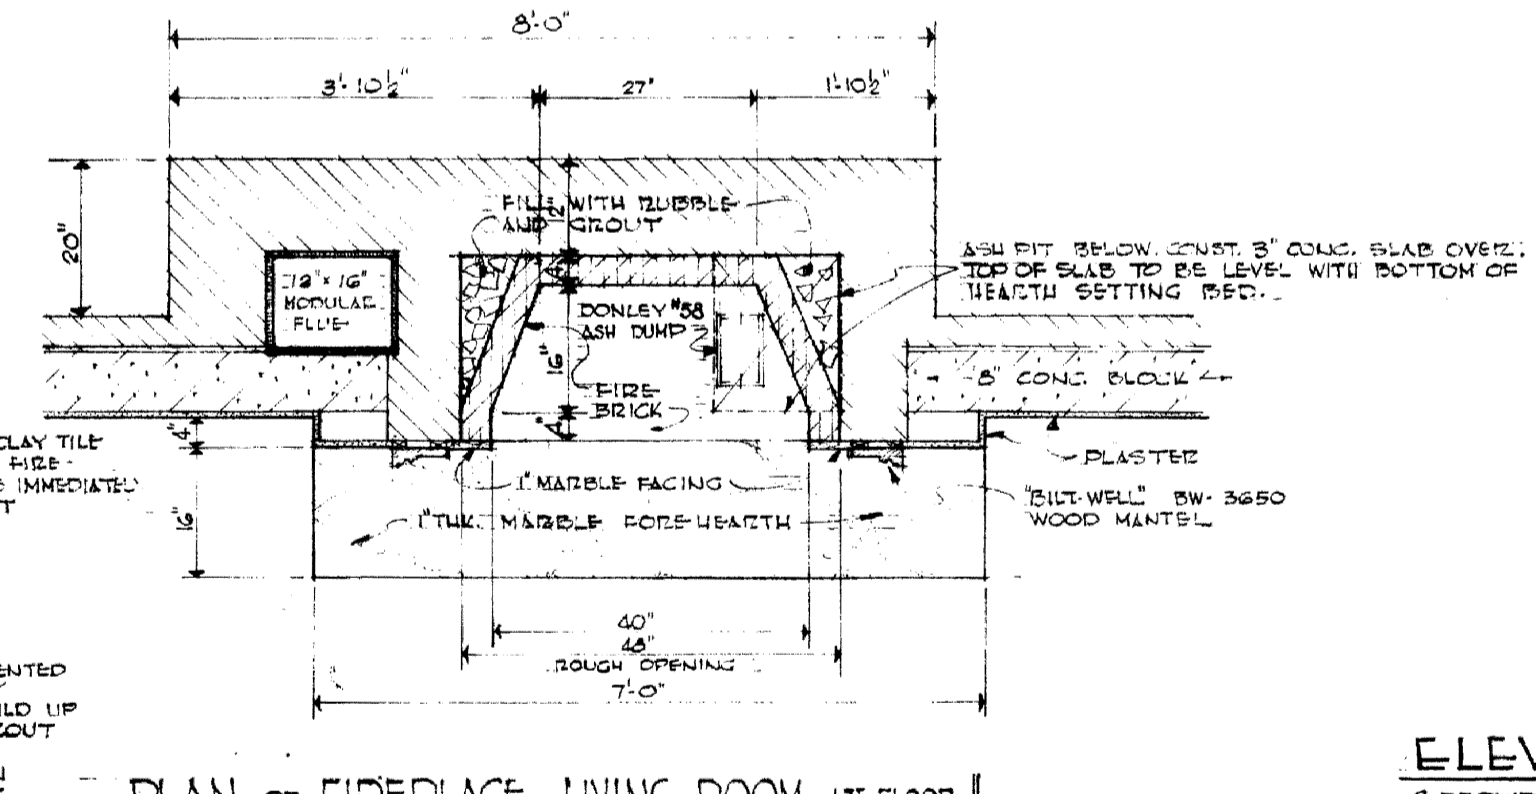


PLAN OF FIREPLACE - LIVING ROOM 1ST FLOOR 1/2" = 1'-0"

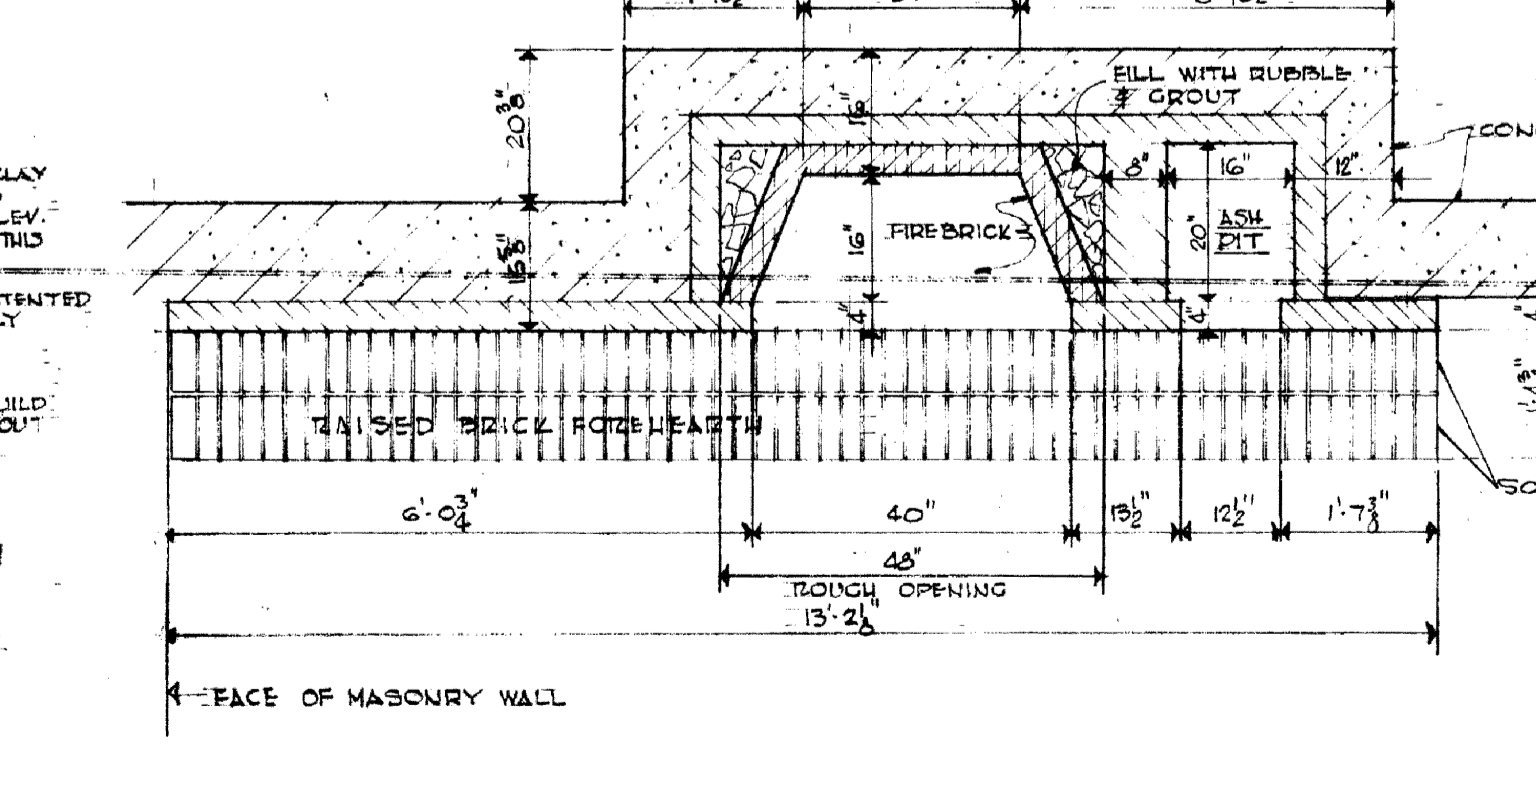

PLAN OF FIREPLACE - BASEMENT RECREATION ROOM 1/2" = 1'-0"

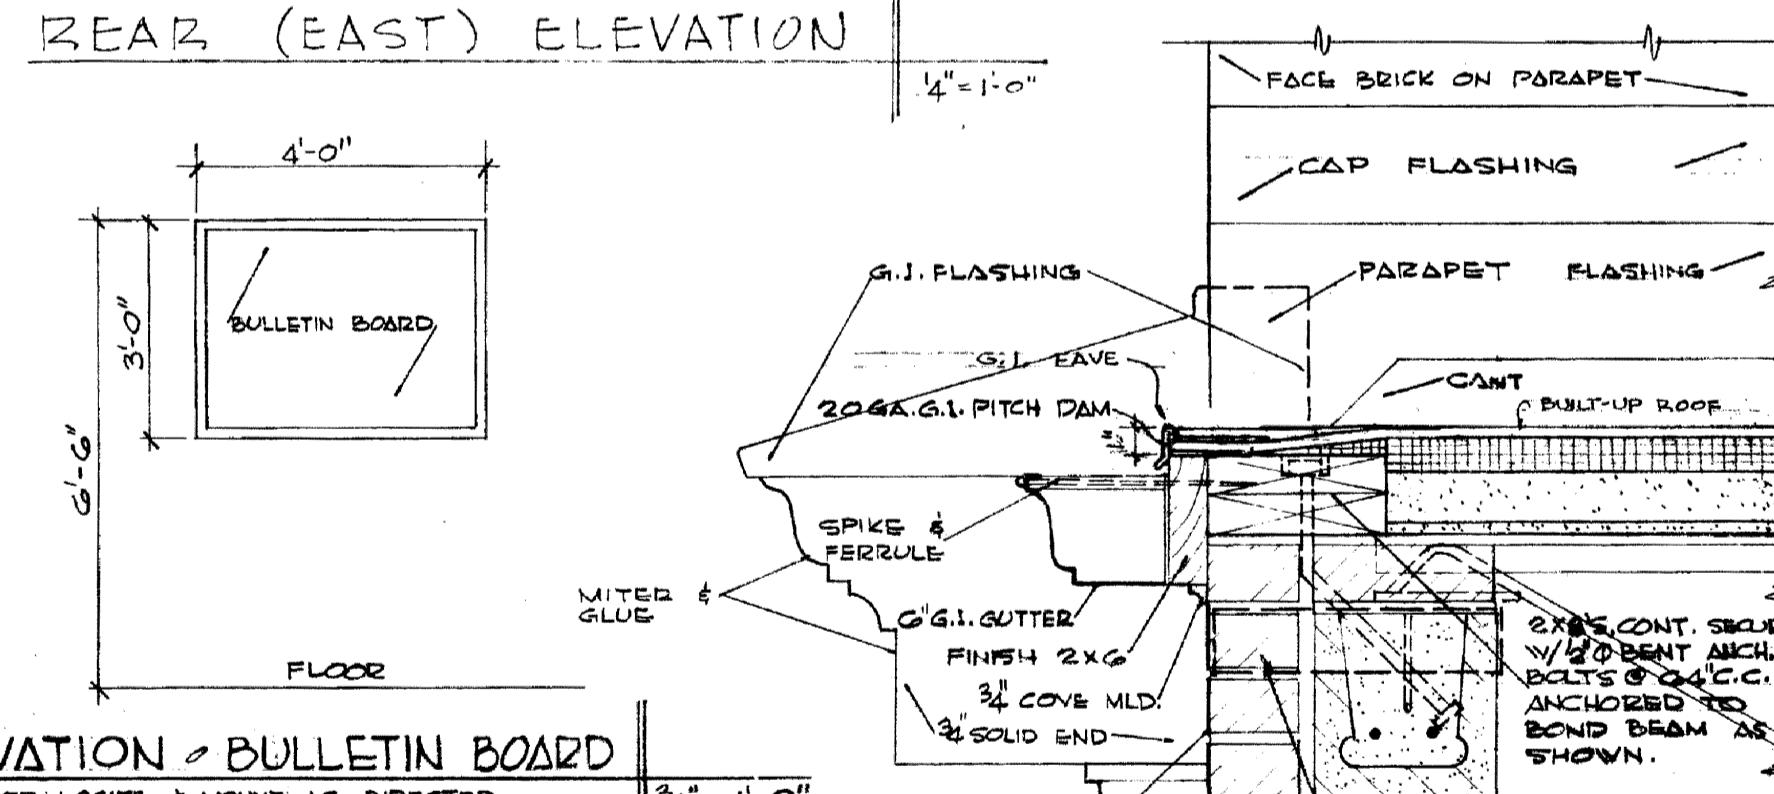

ELEVATION OF BULLETIN BOARD 3/8" = 1'-0"

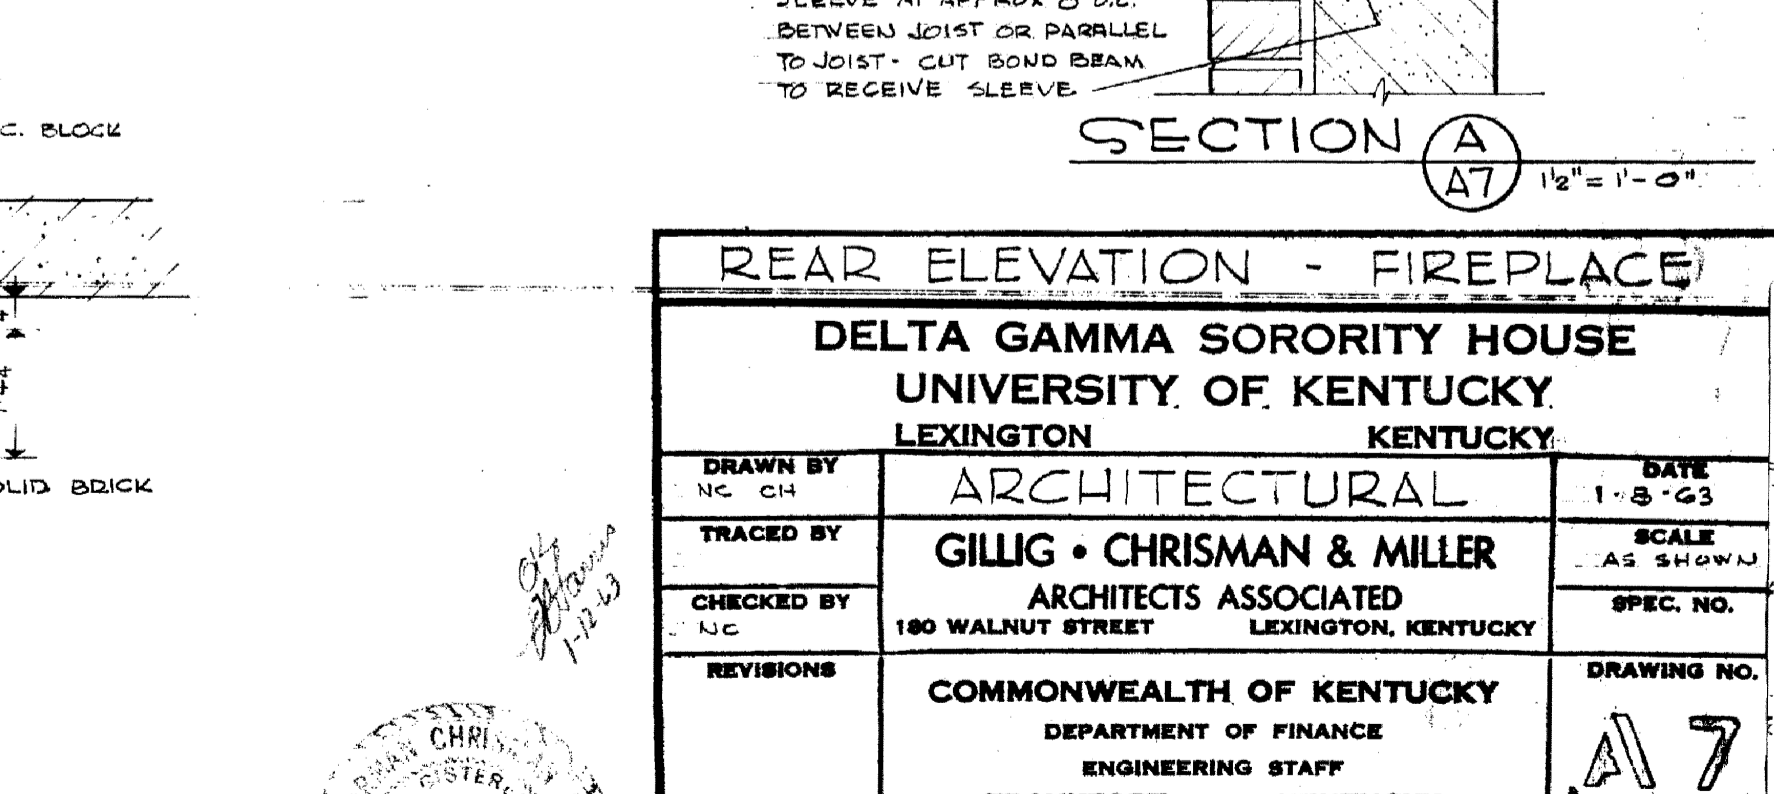

SECTION A 1/2" = 1'-0"

REAR ELEVATION - FIREPLACE			
DELTA GAMMA SORORITY HOUSE UNIVERSITY OF KENTUCKY LEXINGTON, KENTUCKY			
DRAWN BY NC CH	ARCHITECTURAL	DATE 1-8-63	SCALE AS SHOWN
TRACED BY	GILLIG • CHRISMAN & MILLER	ARCHITECTS ASSOCIATED	SPEC. NO.
CHECKED BY NC	180 WALNUT STREET	LEXINGTON, KENTUCKY	
REVISIONS	COMMONWEALTH OF KENTUCKY DEPARTMENT OF FINANCE ENGINEERING STAFF FRANKFORT, KENTUCKY	DRAWING NO. A7	DATE 1-25-63
APPROVED BY	AGENCY HEAD	DATE	
APPROVED BY	CHIEF OF STAFF	DATE	

121
C-2

COMMONWEALTH OF KENTUCKY

DEPARTMENT OF FINANCE

ENGINEERING STAFF

DELTA GAMMA SORORITY HOUSE

UNIVERSITY OF KENTUCKY

GILLIG · CHRISMAN AND MILLER

ARCHITECTS ASSOCIATED

HUGH DILLEHAY & ASSOCIATES

CONSULTING ENGINEERS

PERRY EADES

STRUCTURAL ENGINEER

FEBRUARY 1963


H.H.F.A. PROJECT NO. KY-15-CH-70(D)




ARCHITECTURAL & STRUCTURAL

U-1183A


Document #
08887
Sheet
121 C-2

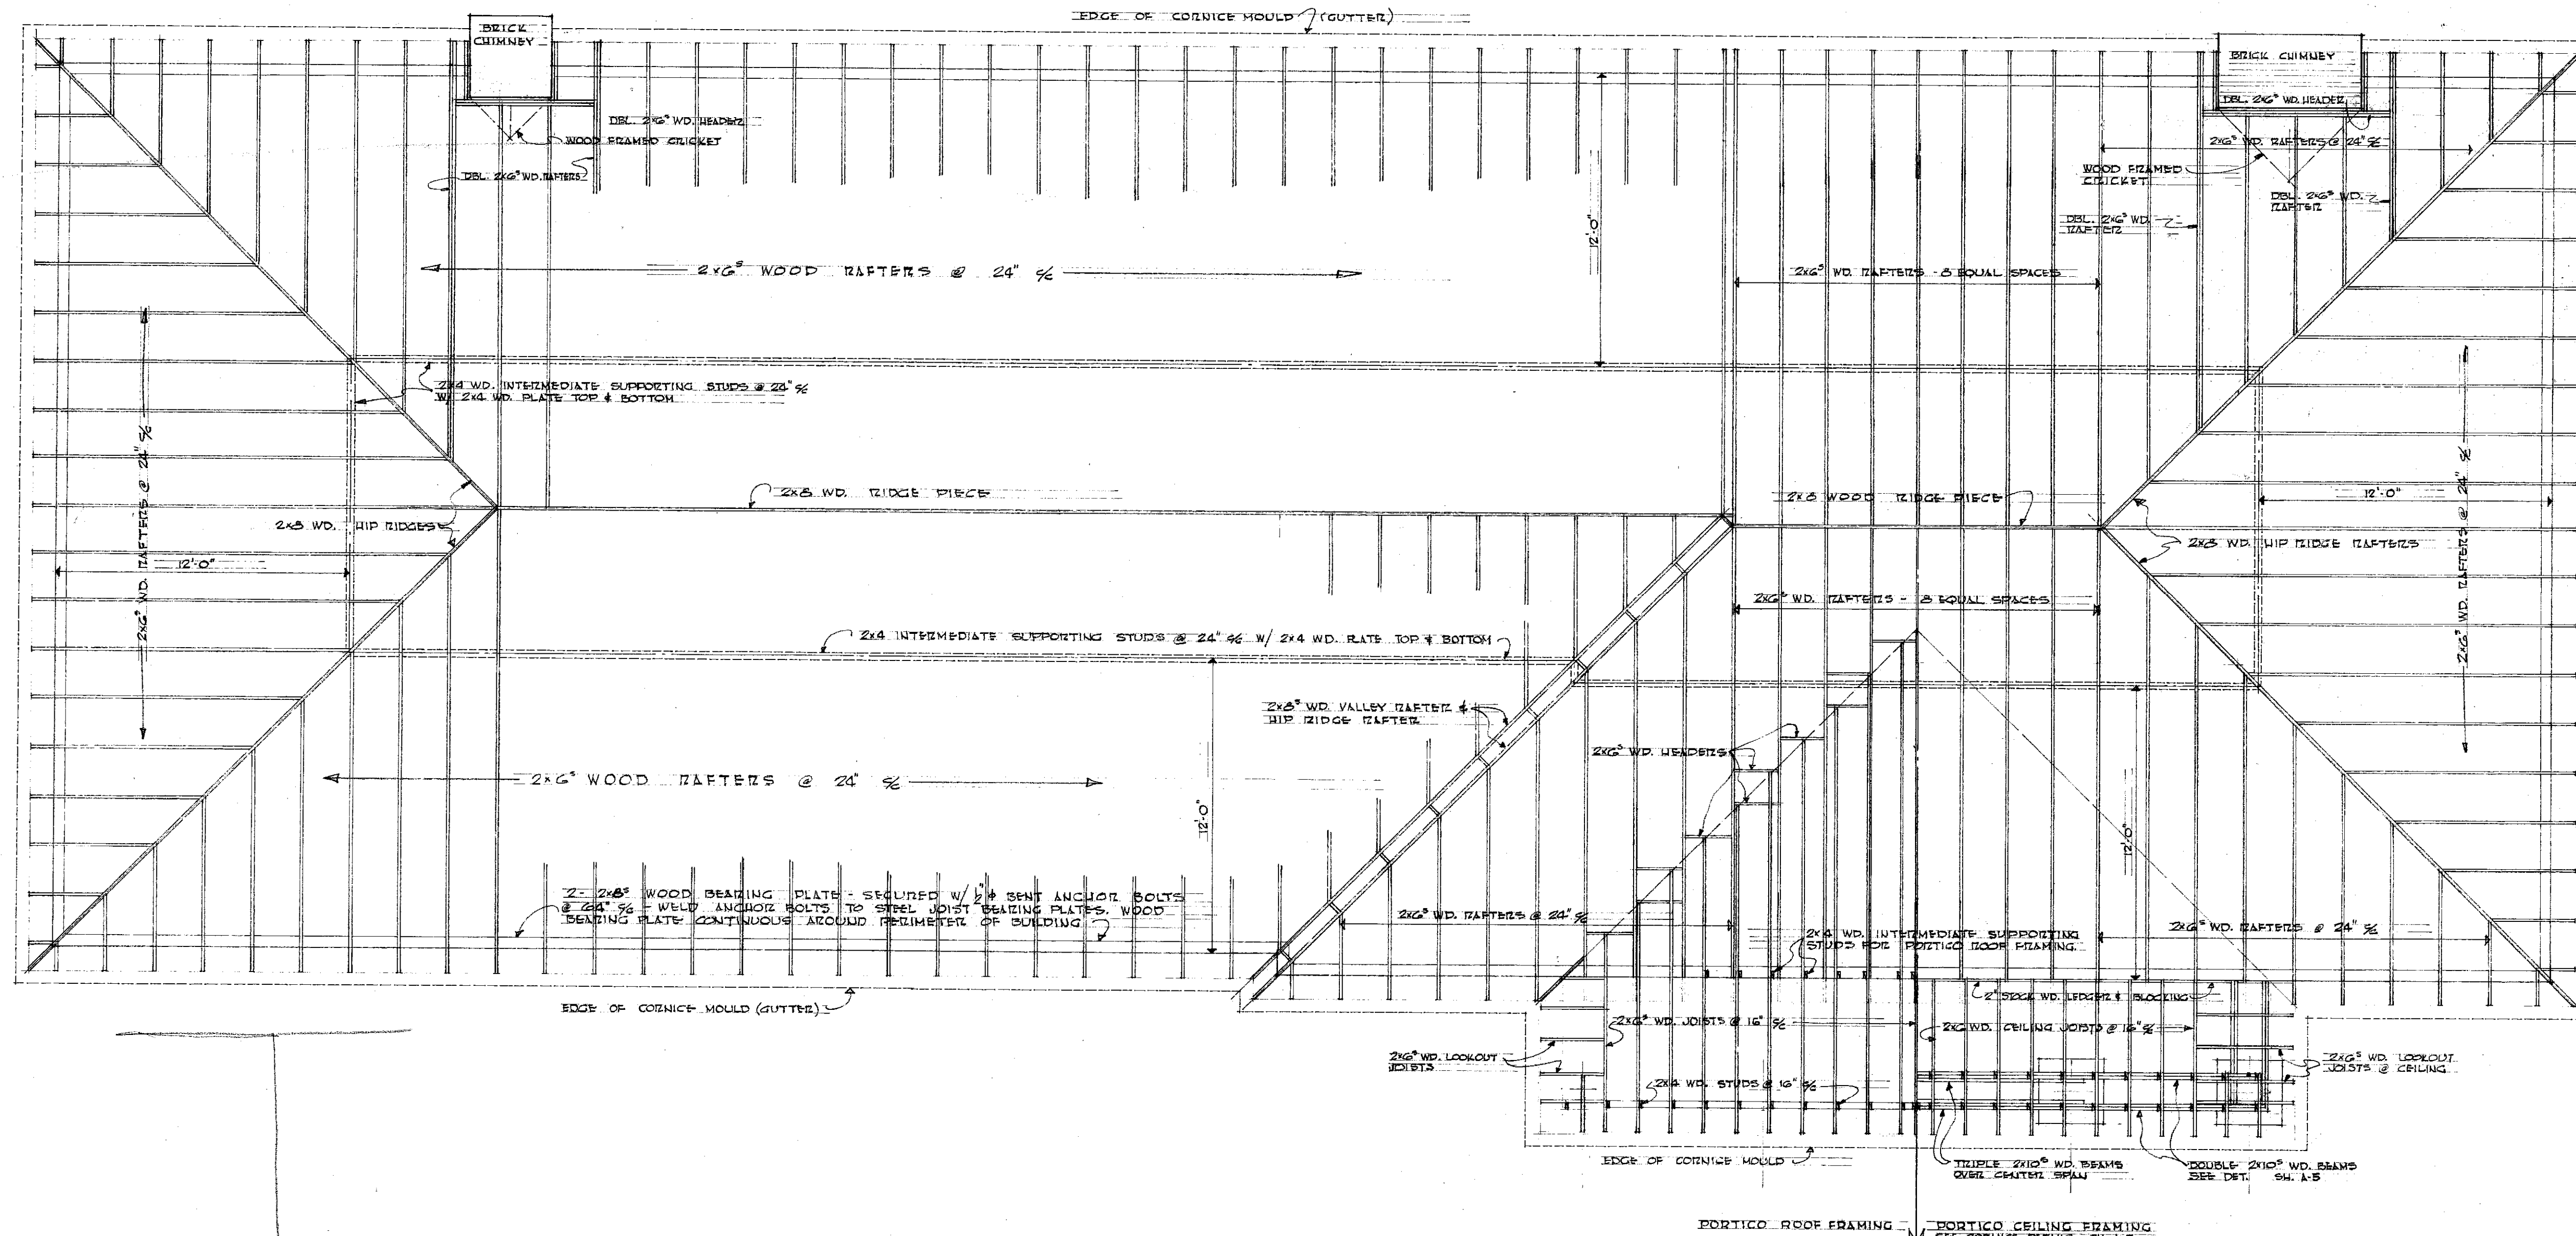


ROOF FRAMING PLAN

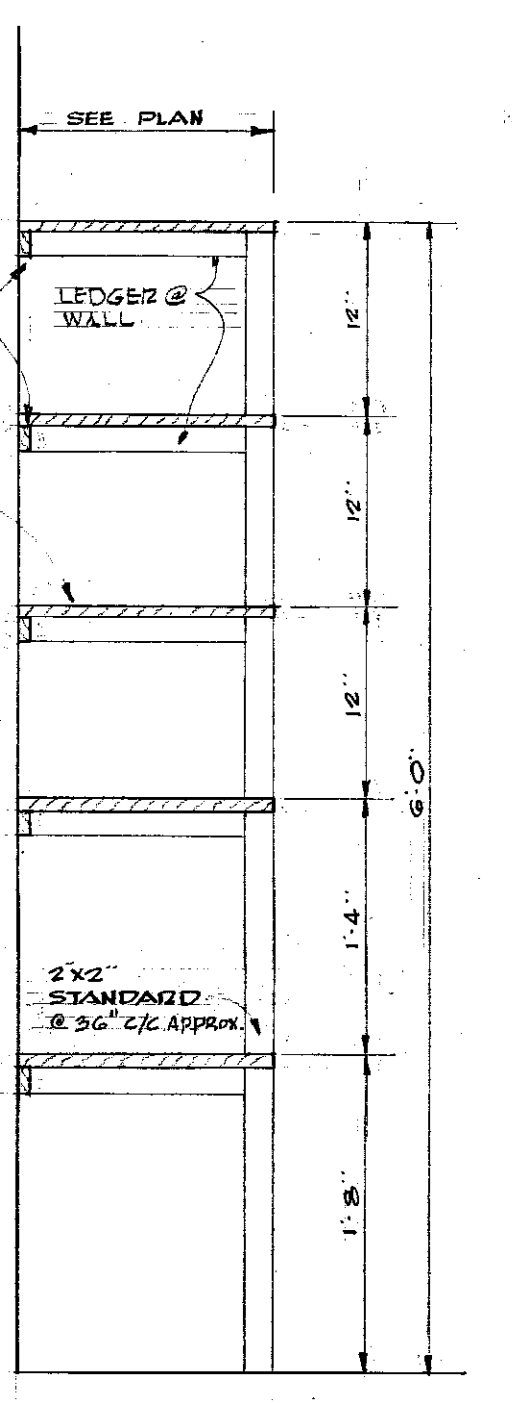


DETAIL OF SHELVING, R.M. (13)
SCALE 1"=1'-0"

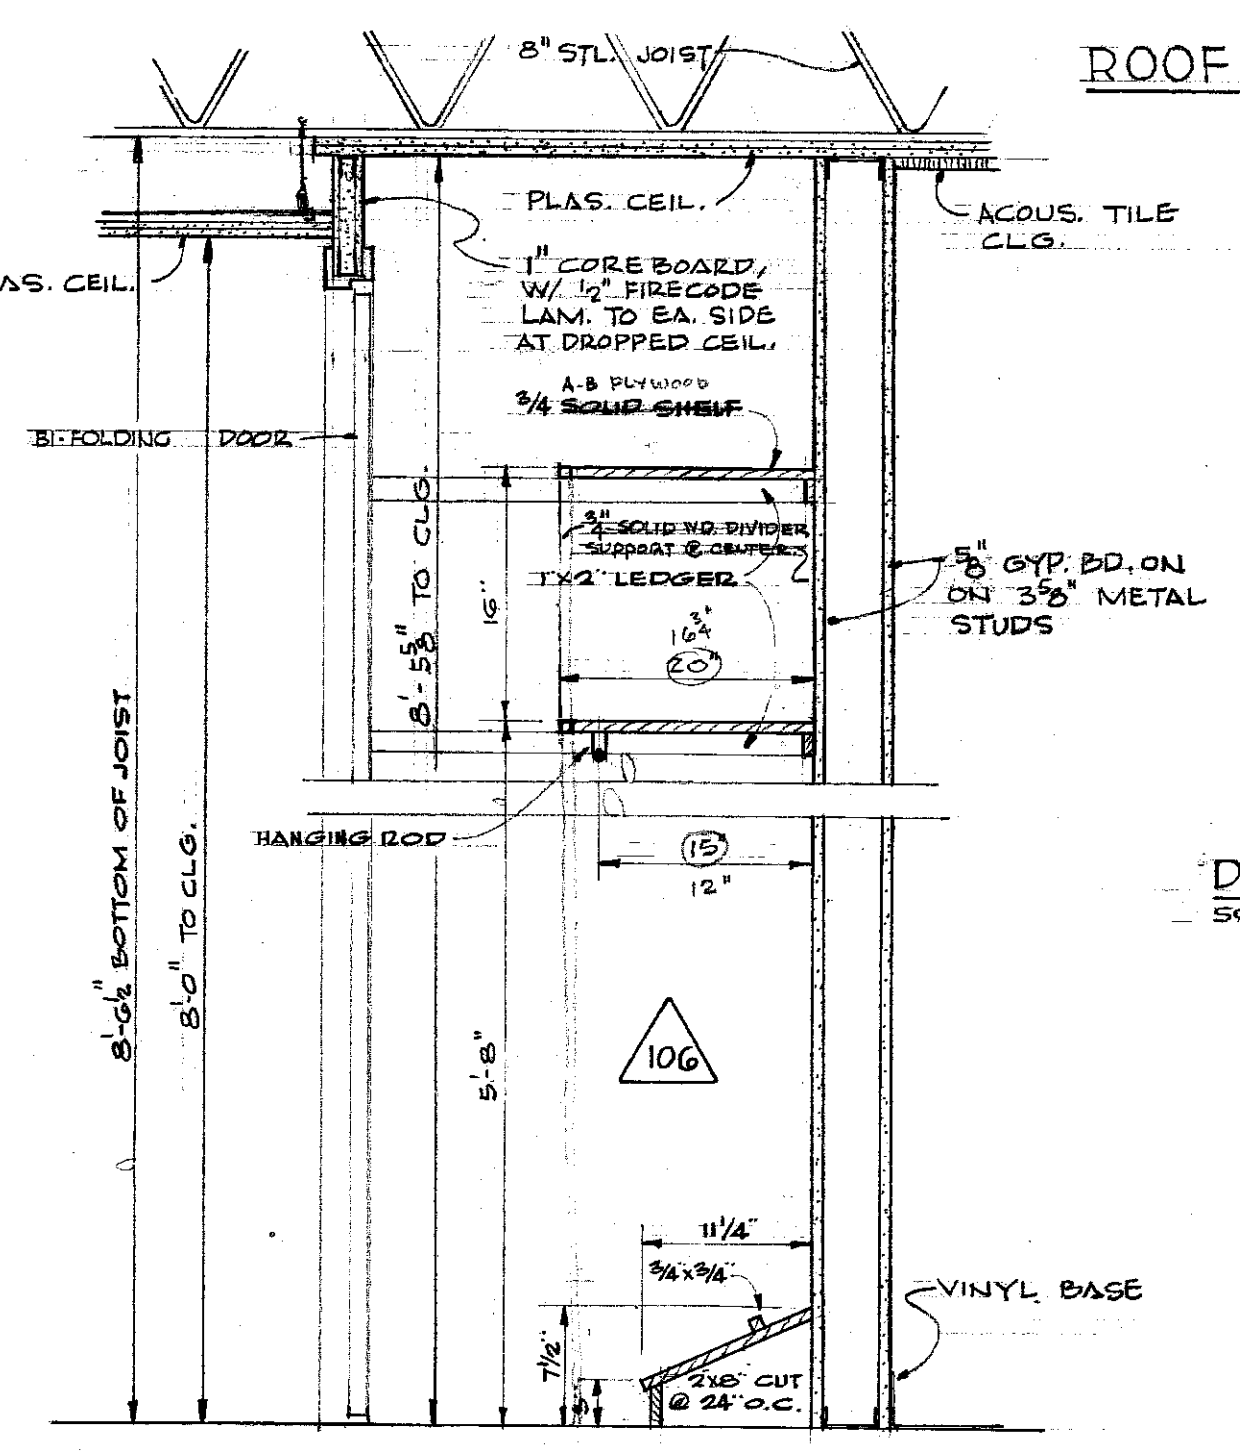


SECTION A-A
SCALE 1"=1'-0"

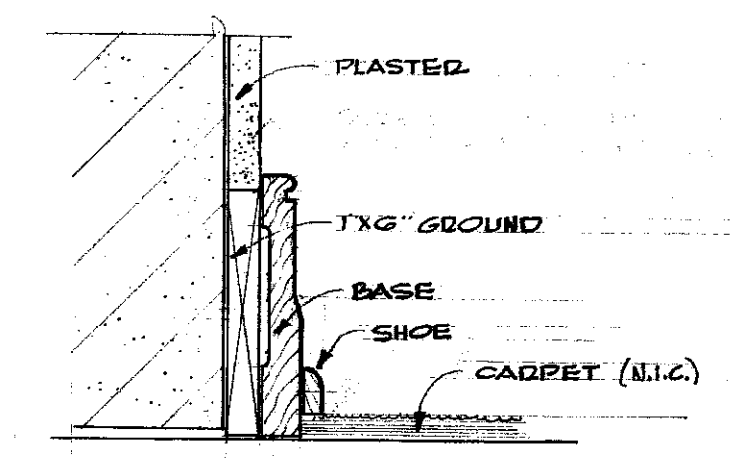


DETAIL OF BASE AT EXTERIOR WALL
SCALE 3"=1'-0"

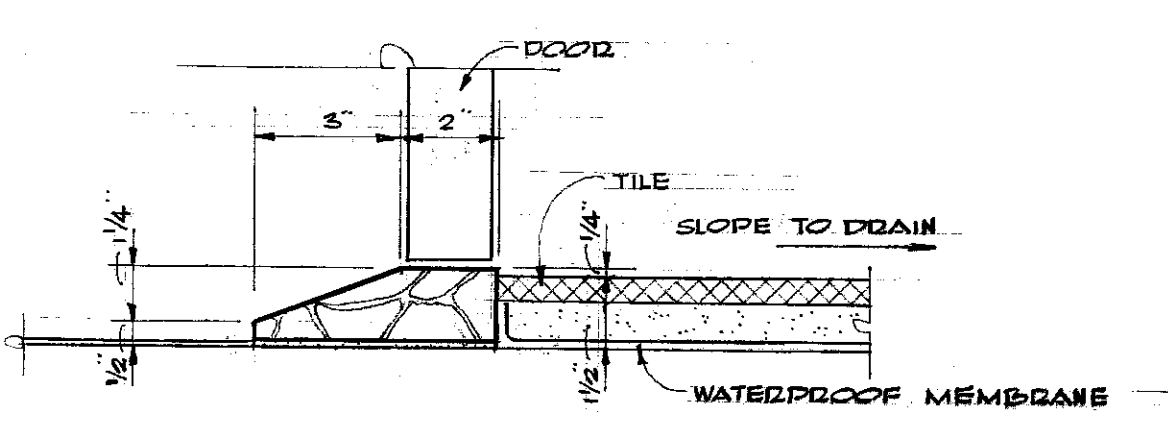

DETAIL OF MARBLE THRESHOLD
SCALE 3"=1'-0"

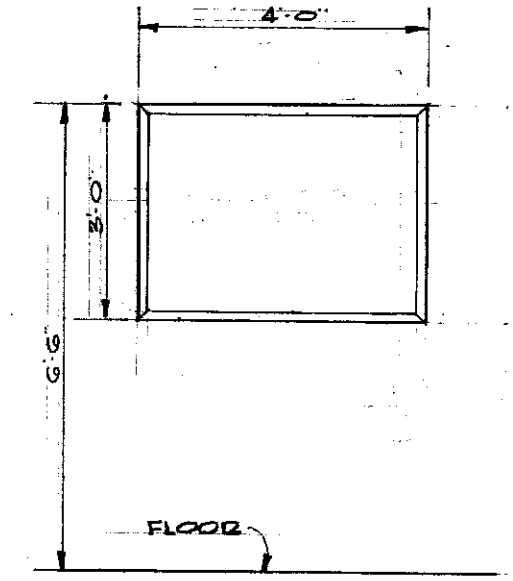

ELEVATION OF BULLETIN BOARD
SCALE 3/8"=1'-0"

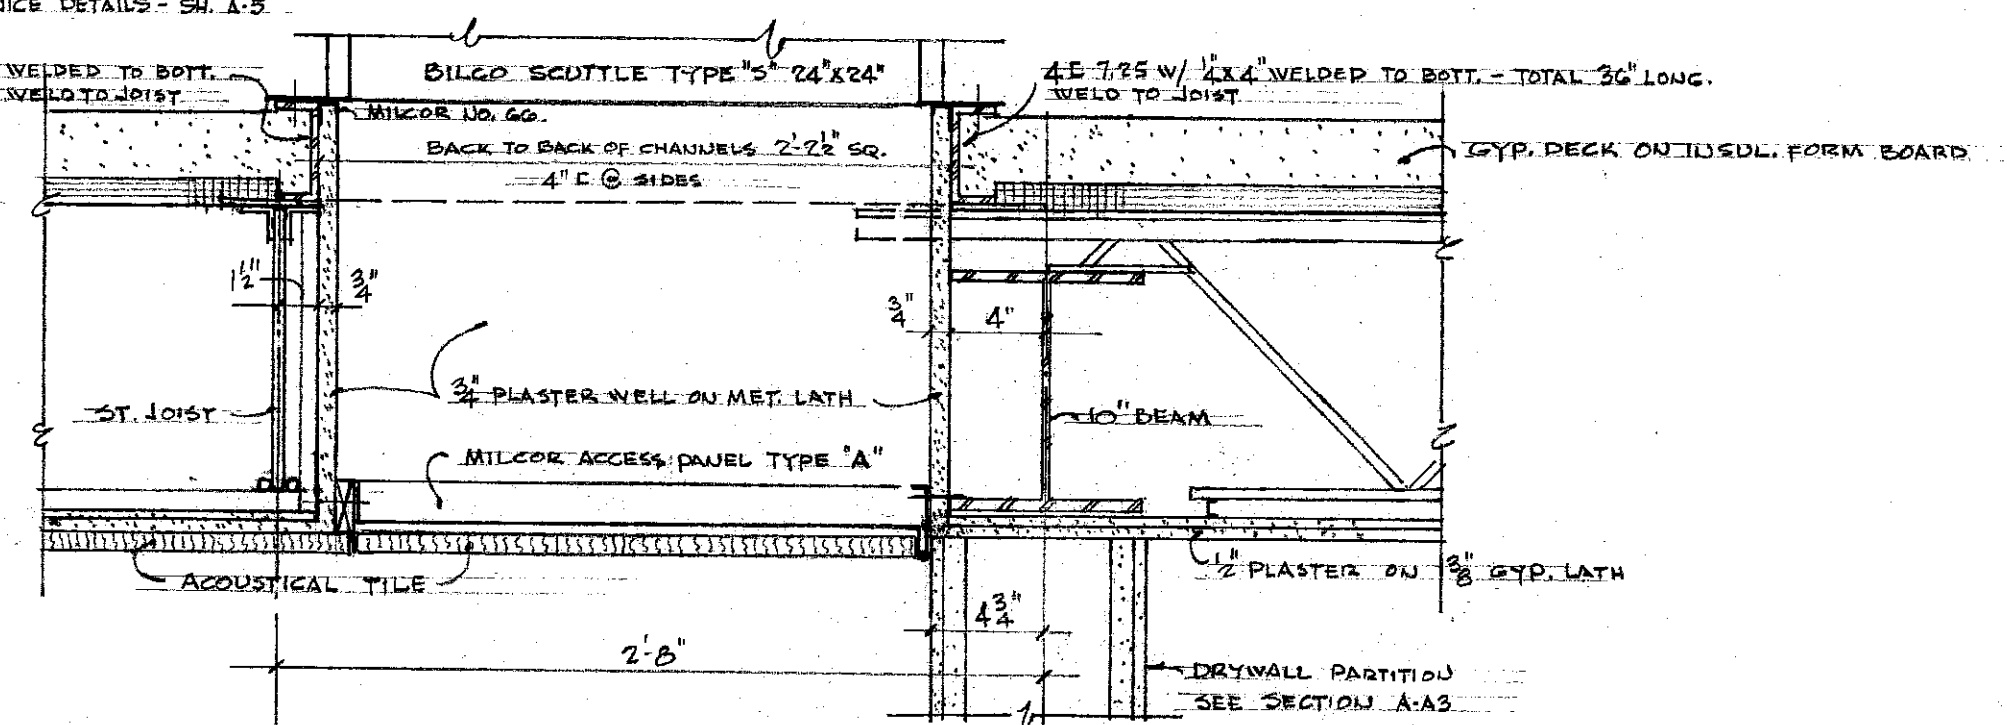

DETAIL - ACCESS TO ATTIC IN STAIR "S-1"
SCALE 1/2"=1'-0"

VOID



VOID

VOID





ROOF FRAMING PLAN, ETC.			
DELTA GAMMA SORORITY HOUSE UNIVERSITY OF KENTUCKY, LEXINGTON KENTUCKY			
DRAWN BY CH	ARCHITECTURAL	DATE 2-15-62	
TRACED BY FP	GILLIG • CHRISMAN & MILLER ARCHITECTS ASSOCIATED	SCALE AS SHOWN	
CHECKED BY NC	180 WALNUT STREET LEXINGTON, KENTUCKY	SPEC. NO.	
REVISIONS	COMMONWEALTH OF KENTUCKY DEPARTMENT OF FINANCE ENGINEERING STAFF FRANKFORT KENTUCKY	DRAWING NO. A-88	
APPROVED BY <i>Frank Chrisman</i>	AGENCY HEAD	DATE 2-26-62	
APPROVED BY <i>David H. Patten</i>	CHIEF OF STAFF		

V-1891

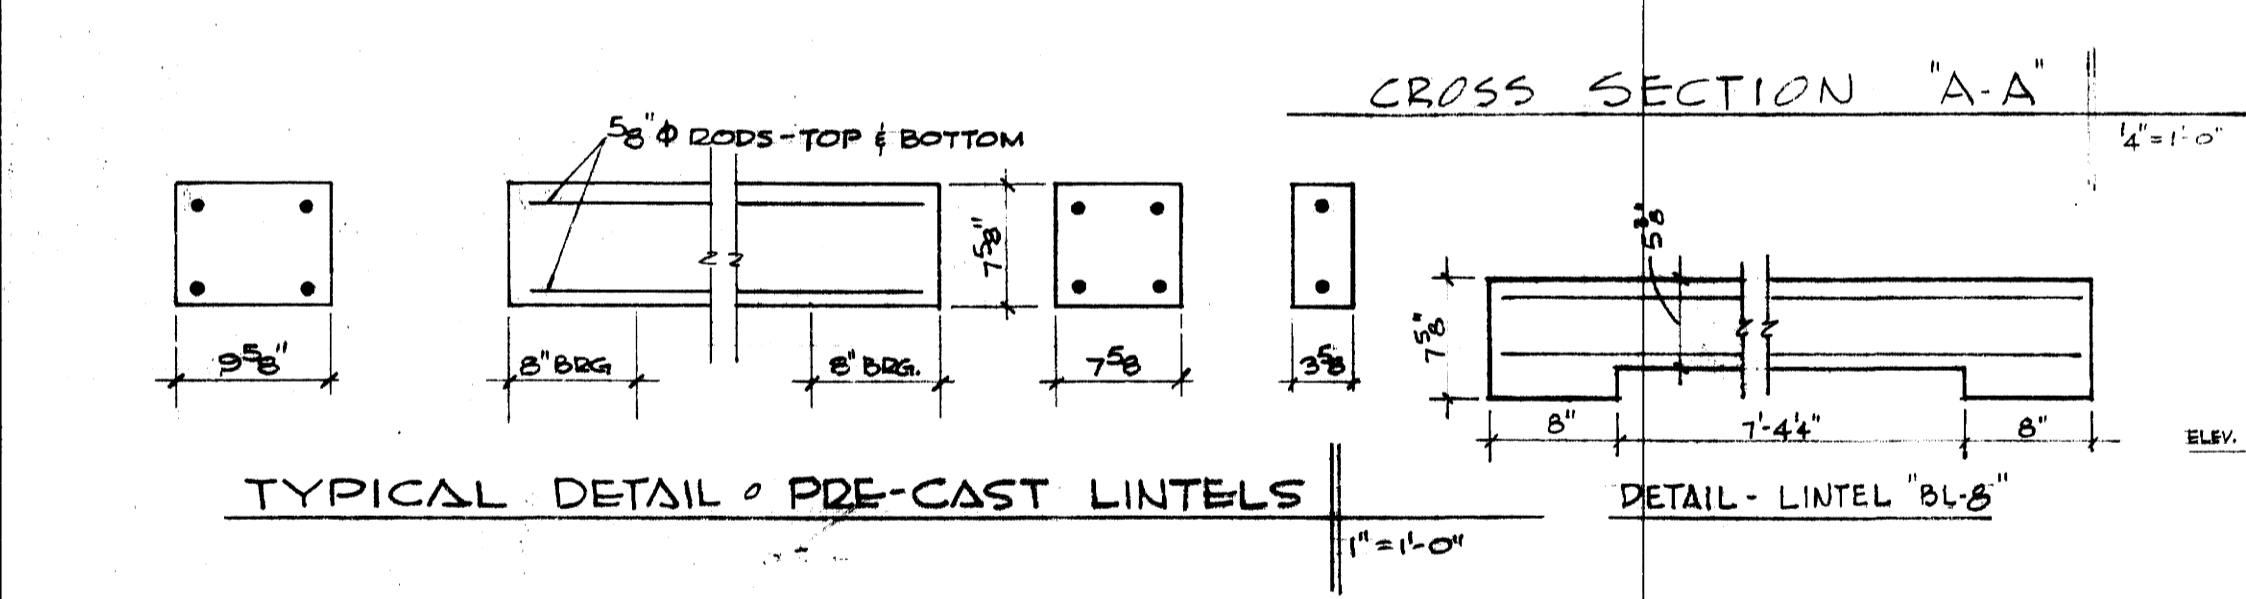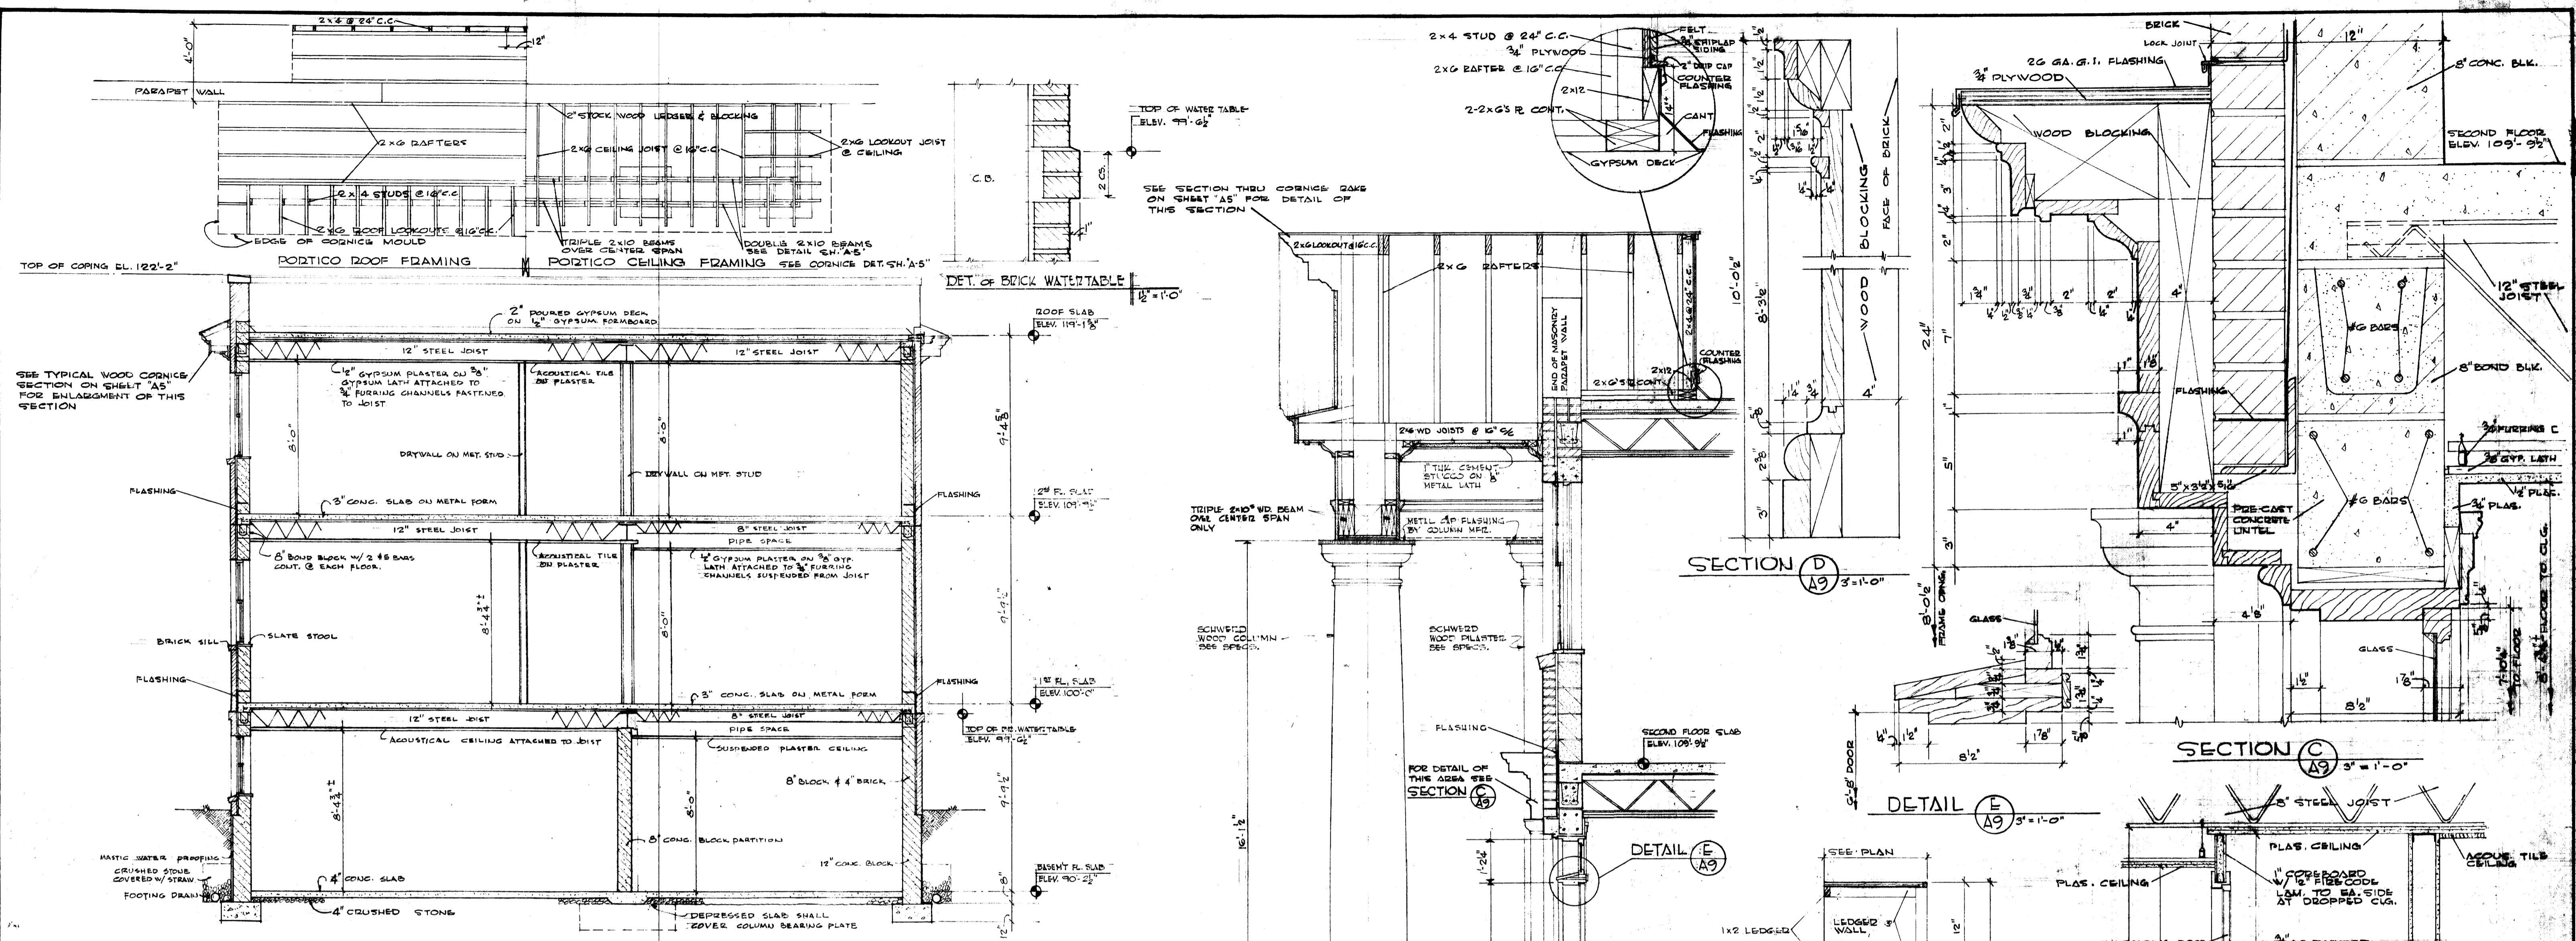

FLOOR	LINTEL		SCHEDULE		REMARKS
	MARK	M.O.	STEEL LINTEL	CONCRETE LINTEL	
BASEMENT	BL-1	3'-4 1/2"	1L-3/2x3/2x5/8	7 3/8 7 3/8 2-5/8φ 2-5/8φ	WINDOWS
	BL-2	2'-0"	5/8x11x3-0"R		METAL LOUVER
	BL-3	3'-4"		7 3/8 7 3/8 2-5/8φ 2-5/8φ	
	BL-4	3'-0"		7 3/8 7 3/8 2-5/8φ 2-5/8φ	
	BL-5	4'-0"		7 3/8 7 3/8 2-5/8φ 2-5/8φ	
	BL-6	5'-8"		7 3/8 7 3/8 2-5/8φ 2-5/8φ	
	BL-7	2'-8"		7 3/8 7 3/8 2-5/8φ 2-5/8φ	
	BL-8	7'-4 1/2"		9 3/8 7 3/8 2-3/4φ 2-3/4φ	SEE DETAIL ABOVE
	BL-9	3'-4"		5 3/8 7 3/8 2-5/8φ 2-5/8φ	
	BL-10	2'-8"		5 3/8 7 3/8 2-5/8φ 2-5/8φ	
	BL-11	2'-4"		5 3/8 7 3/8 2-5/8φ 2-5/8φ	
	BL-12	4'-0"		3 3/8 7 3/8 1-5/8φ 1-5/8φ	
	BL-13	3'-0"		5 3/8 7 3/8 2-5/8φ 2-5/8φ	
	BL-14	2'-6"		5 3/8 7 3/8 2-5/8φ 2-5/8φ	
SECOND FLOOR	2L-1	3'-4 1/2"	1L-3/2x3/2x5/8	7 3/8 7 3/8 2-5/8φ 2-5/8φ	WINDOWS
	2L-2	2'-8 1/2"	1L-3/2x3/2x5/8	7 3/8 7 3/8 2-5/8φ 2-5/8φ	WINDOWS
	2L-3	3'-8"	1L-3/2x3/2x5/8	7 3/8 7 3/8 2-5/8φ 2-5/8φ	DOOR

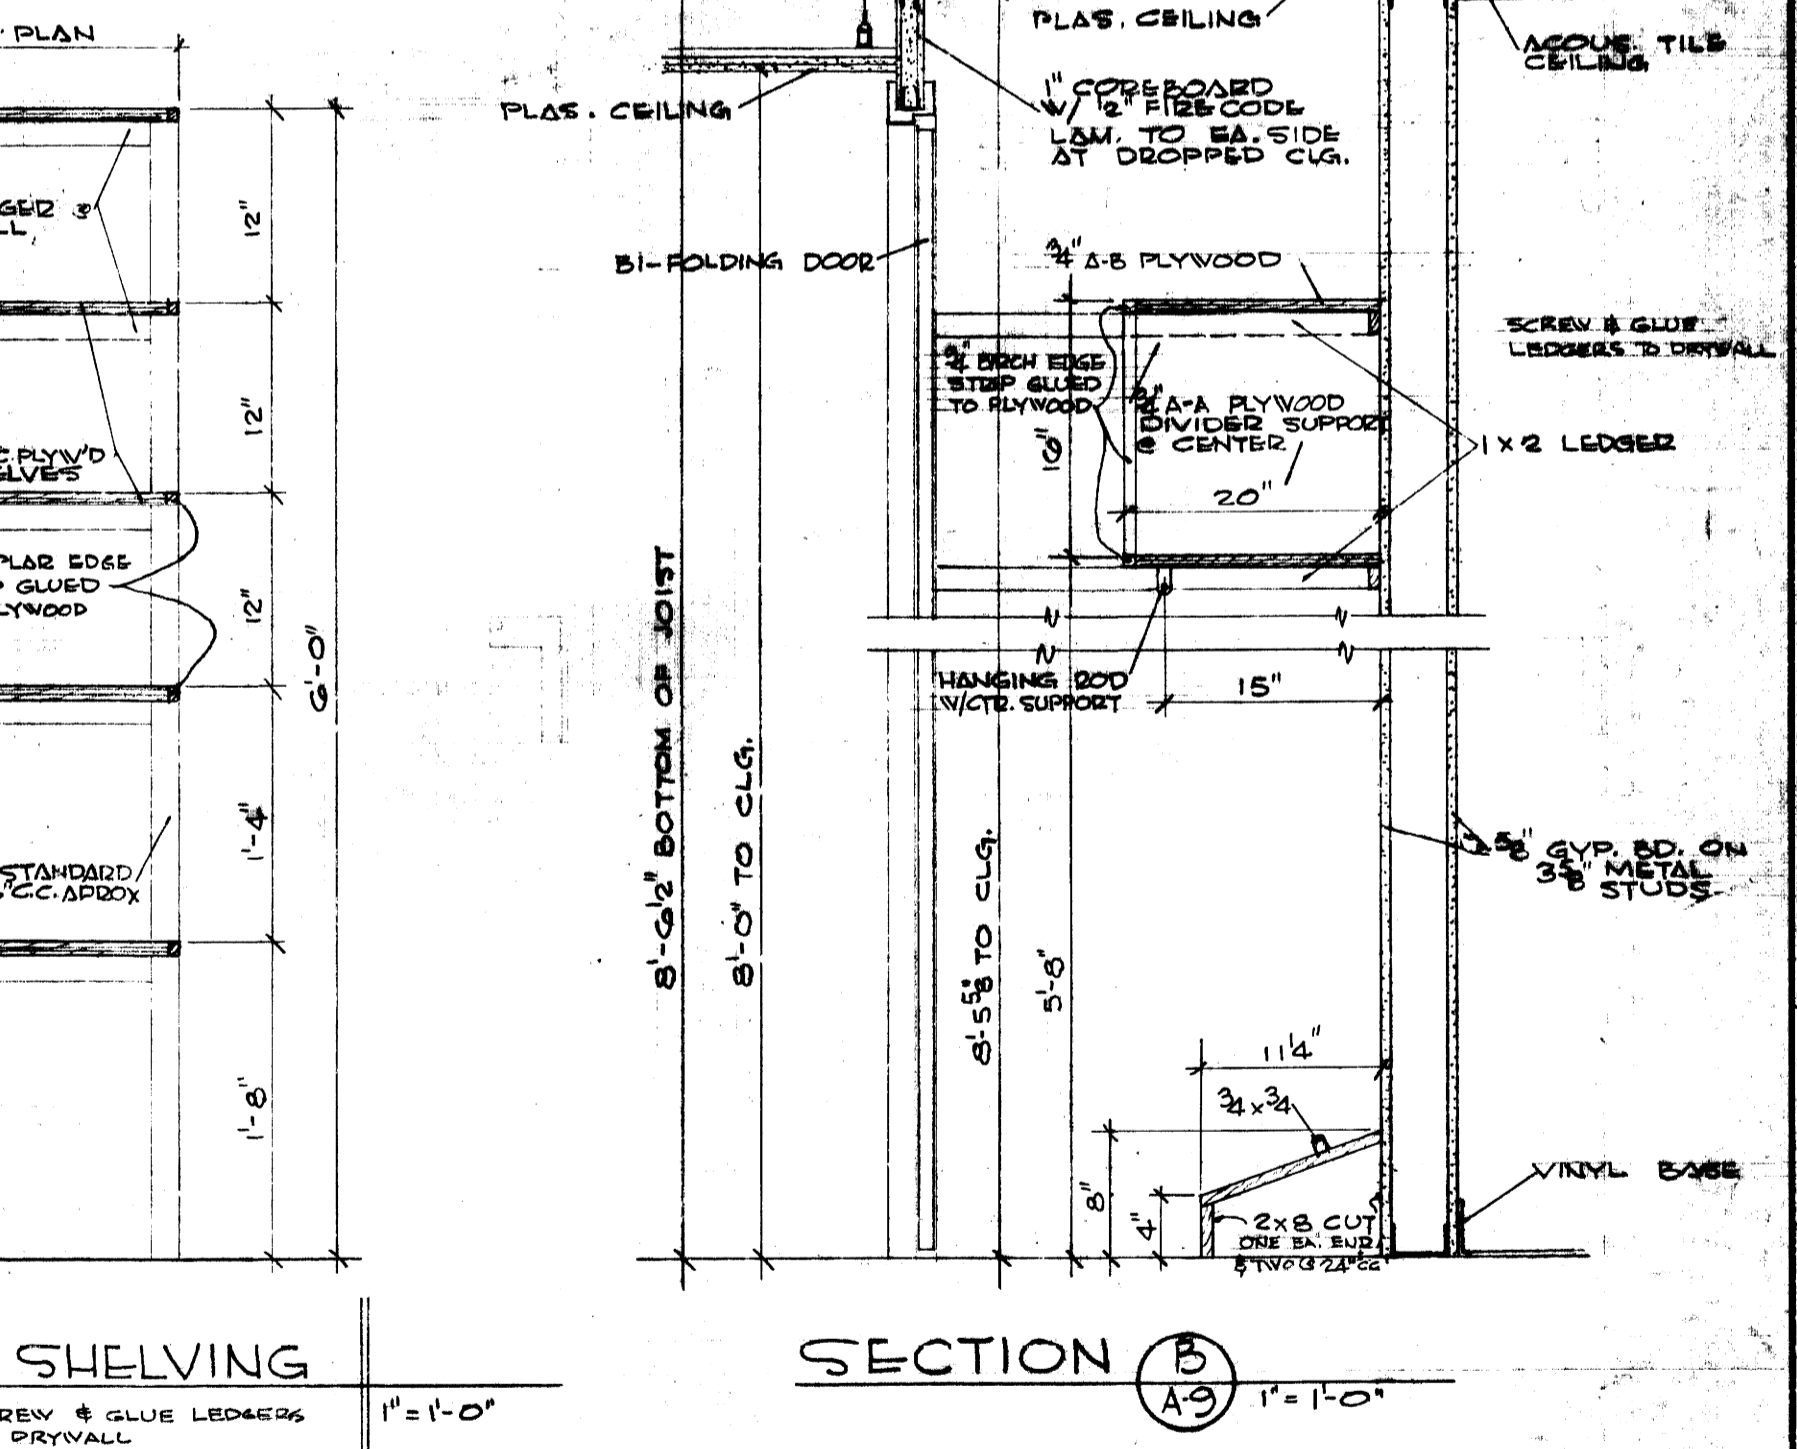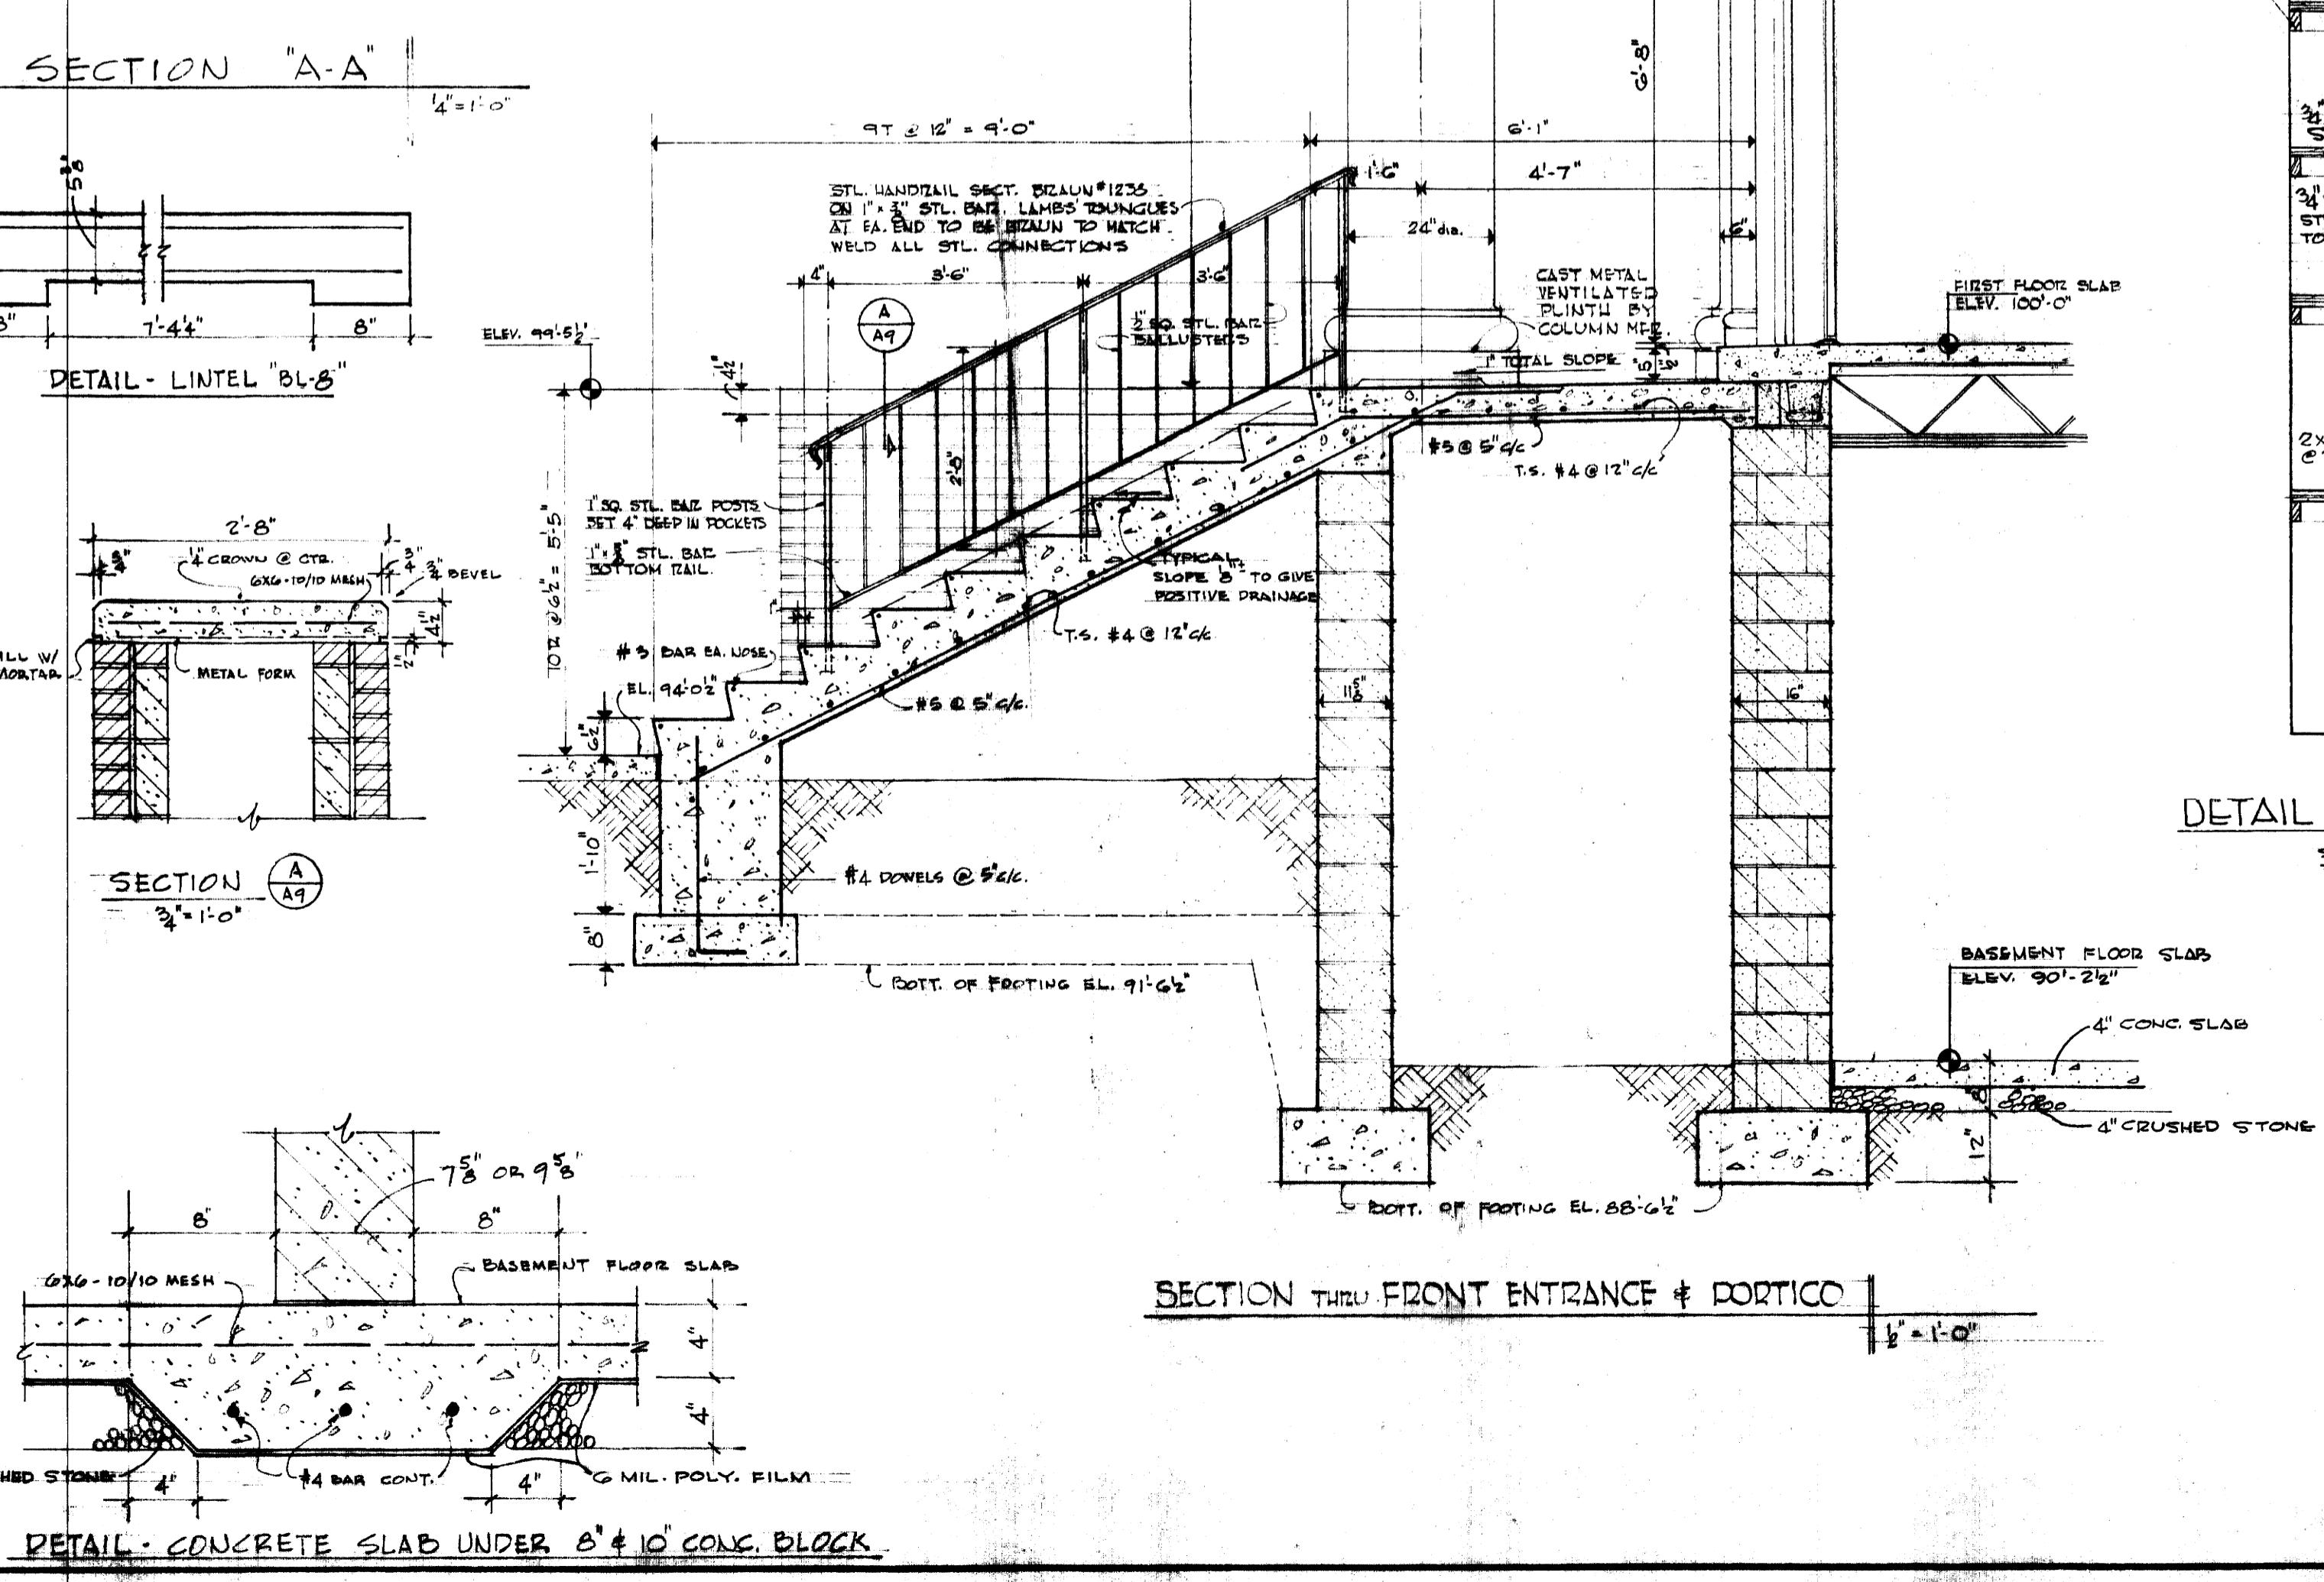







SECTION - PORTICO DETAILS			
DELTA GAMMA SORORITY HOUSE			
UNIVERSITY OF KENTUCKY			
LEXINGTON		KENTUCKY	
DRAWN BY	ARCHITECTURAL	DATE	1-8-63
TRACED BY	GILLIG • CHRISMAN & MILLER	SCALE	AS SHOWN
CHECKED BY	ARCHITECTS ASSOCIATED	SPEC. NO.	
NO.	180 WALNUT STREET	LEXINGTON, KENTUCKY	
REVISIONS	COMMONWEALTH OF KENTUCKY	DRAWING NO.	A 9
	DEPARTMENT OF FINANCE		
	ENGINEERING STAFF		
	FRANKFORT KENTUCKY		
APPROVED BY	<i>David H. Patton</i>	DATE	1-25-63
	CHIEF OF STAFF		

008096

U-1892

ROOM NO.	ROOM DESIGNATION	FLOOR	BASE	WALLS	CEILING	REMARKS
01	LOBBY	VINYL ASBEST.	VINYL	PAINT C.B.	ACOUS. CLG. 2 HR. CLG.	
02	RECREATION ROOM	DO.	DO.	DO.	DO.	
03	CLOSET	ASPHALT TILE	DO.	DO.	SAND FIN. PLAS. WALLS & VARNISH & FIR PLYV'D	
04	CLOSET	DO.	DO.	DO.	DO.	
05	CLOSET	DO.	DO.	DO.	DO.	
06	VENDING MACHINES	VINYL ASBEST.	DO.	DO.	ACOUS. CLG. 2 HR. CLG.	
07	DINING ROOM	DO.	DO.	DO.	DO.	
08	STORAGE ROOM	ASPHALT TILE	DO.	DO.	SAND FIN. PLAS.	
09	MAID'S CLOSET	HARD CONC.	NONE	DO.	DO.	
10	LAUNDRY	DO.	DO.	DO.	DO.	
11	WOMEN EMPLOYEES	ASPHALT TILE	VINYL	DO.	DO.	
12	TOILET	CERAMIC TILE	CERAMIC TILE	DO.	DO.	
13	STORAGE	HARD CONC.	NONE	DO.	DO.	
14	OMITTED					
15	OMITTED					
16	CORRIDOR	ASPHALT TILE	VINYL	DO.	ACOUS. CLG. 2 HR. CLG.	
17	MECHANICAL ROOM	HARD CONC.	NONE	DO.	SAND FIN. PLAS.	
18	KITCHEN	VINYL ASBEST.	VINYL	DO.	SMOOTH FIN. PLAS. 8'-0" CEIL. HT.	
19	KITCHEN STORAGE	DO.	NONE	DO.	SAND FIN. PLAS.	
20	PASSAGE	ASPHALT TILE	VINYL	DO.	DO.	
21	MEN'S TOILET	CERAMIC TILE	CERAMIC TILE	DO.	DO.	

DOOR AND FRAME SCHEDULE										
MARK	OPENING	SIZE	THICKNESS	MATERIAL	TYPE	OPNG	FRAME		REMARKS	HANDICAP GROUP
							MAT'L	TYPE		
01	3'-4" x 6'-8"	1' 1/2"	1 1/2"	WD. G	90°	MET.	B	8 1/2" x 1 1/2" PWS	"B" LABEL, 1/2 HR.	1
02	4'-0" x 6'-8" (PR)	1 1/2"	1 1/2"	WD. G	90°	MET.	F	3 1/2"	UNDERCUT DOORS 1"	2
03	4'-0" x 6'-8" (PR)	1 1/2"	1 1/2"	WD. G	90°	MET.	F	3 1/2"	DO	2
04	4'-0" x 6'-8" (PR)	1 1/2"	1 1/2"	WD. G	90°	MET.	F	3 1/2"	DO	3
05	2'-8" x 6'-8"	1 1/2"	1 1/2"	WD. G	90°	MET.	B	8 1/2" x 1 1/2" PWS		3
06	2'-8" x 6'-8"	1 1/2"	1 1/2"	WD. G	90°	MET.	B	8 1/2" x 1 1/2" PWS		3
07	3'-0" x 6'-8"	1 1/2"	1 1/2"	WD. G	90°	MET.	B	8 1/2" x 1 1/2" PWS		1
08	4'-0" x 6'-8" (PR)	1 1/2"	1 1/2"	WD. G	90°	MET.	F	3 1/2"	UNDERCUT DOORS 1"	2
09	2'-6" x 6'-8"	1 1/2"	1 1/2"	WD. G	90°	MET.	B	8 1/2" x 1 1/2" PWS		4
10	3'-0" x 6'-8"	1 1/2"	1 1/2"	WD. G	90°	MET.	B	8 1/2" x 1 1/2" PWS		5
11	2'-4" x 6'-8"	1 1/2"	1 1/2"	WD. G	90°	MET.	B	8 1/2" x 1 1/2" PWS		5
12	2'-6" x 6'-8"	1 1/2"	1 1/2"	WD. G	90°	MET.	B	8 1/2" x 1 1/2" PWS		5
13	3'-0" x 6'-8"	1 1/2"	1 1/2"	WD. G	90°	MET.	B	8 1/2" x 1 1/2" PWS		4
14	OMITTED									
15	OMITTED									
16	3'-4" x 6'-8"	1 1/2"	1 1/2"	WD. G	90°	MET.	B	8 1/2" x 1 1/2" PWS	"B" LABEL, 1/2 HR.	1
17	3'-4" x 6'-8"	1 1/2"	1 1/2"	WD. G	90°	MET.	B	8 1/2" x 1 1/2" PWS	"B" LABEL, 1/2 HR.	4
18	3'-0" x 6'-8"	1 1/2"	1 1/2"	WD. G	90°	MET.	B	8 1/2" x 1 1/2" PWS		8
19	3'-0" x 6'-8"	1 1/2"	1 1/2"	WD. G	90°	MET.	D	6 1/2"	16" HIGH LOUVER	4
20	2'-8" x 6'-8"	1 1/2"	1 1/2"	WD. G	90°	MET.	D	6 1/2"		8
21	2'-4" x 6'-8"	1 1/2"	1 1/2"	WD. G	90°	MET.	D	6 1/2"		7
22	2'-8" x 6'-8"	1 1/2"	1 1/2"	WD. G	90°	MET.	B	8 1/2" x 1 1/2" PWS	"B" LABEL, 1/2 HR.	1

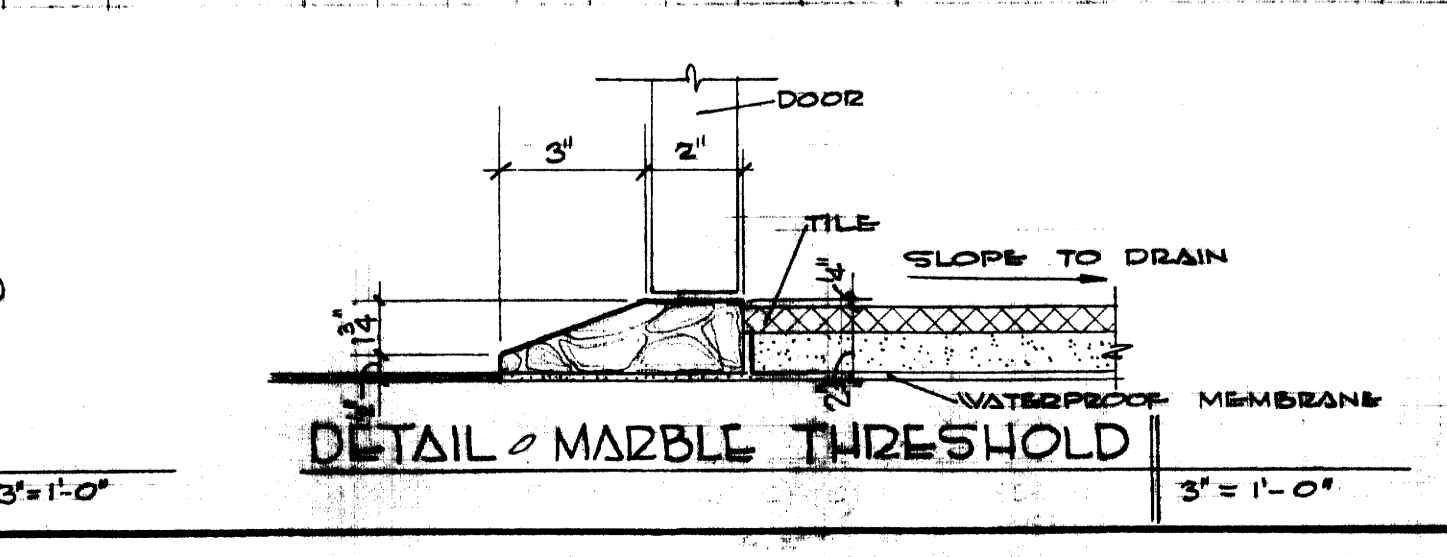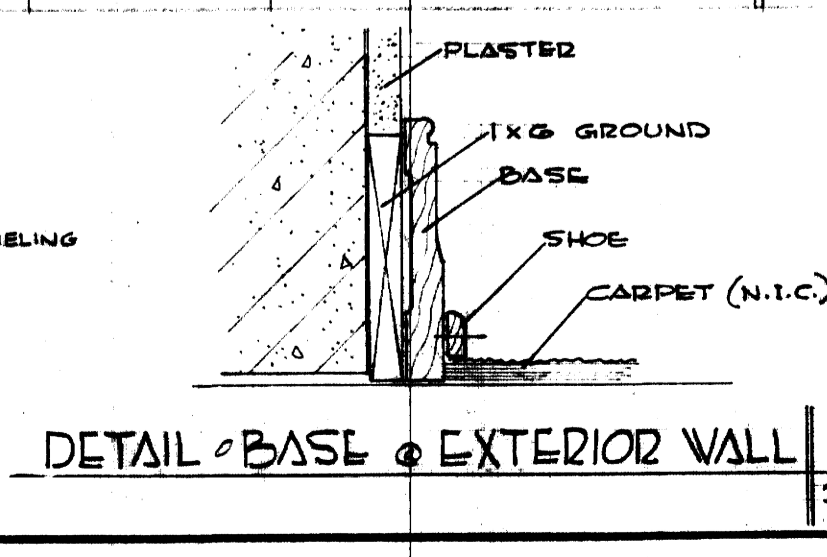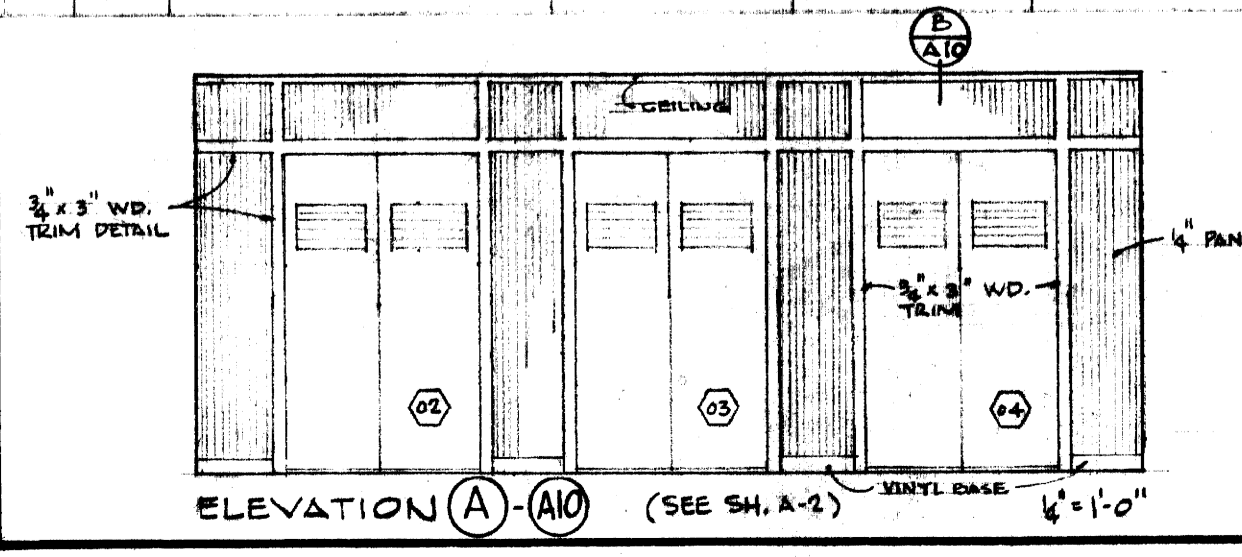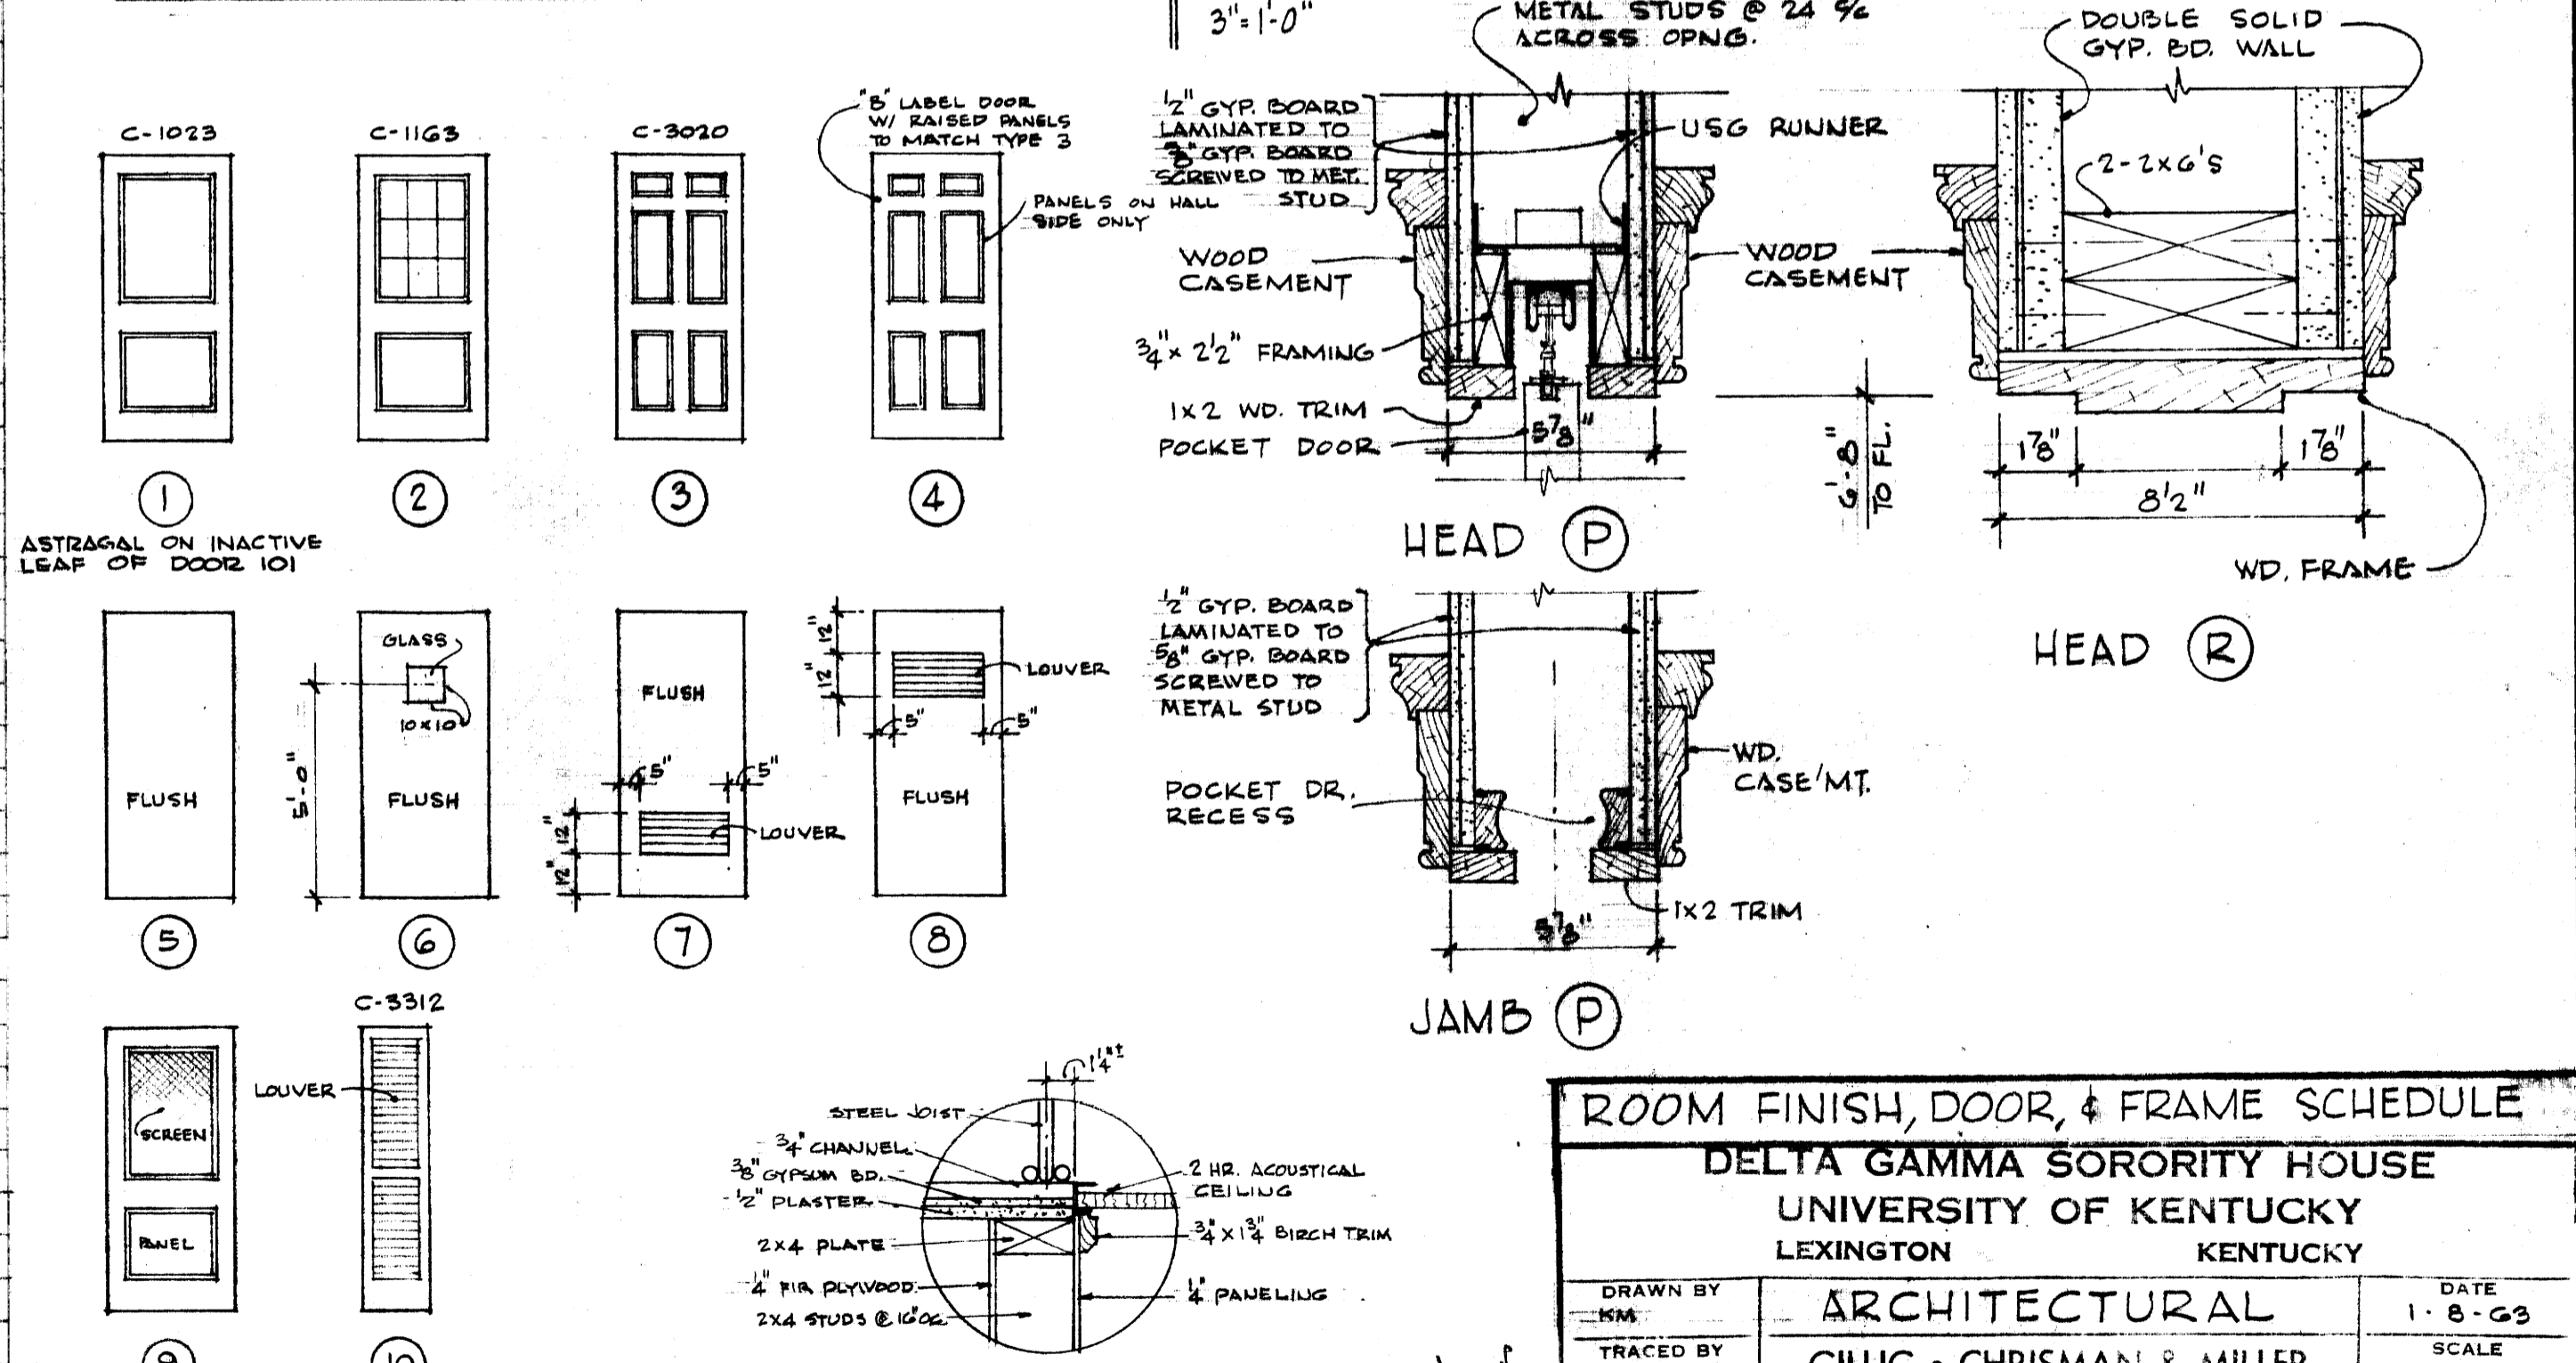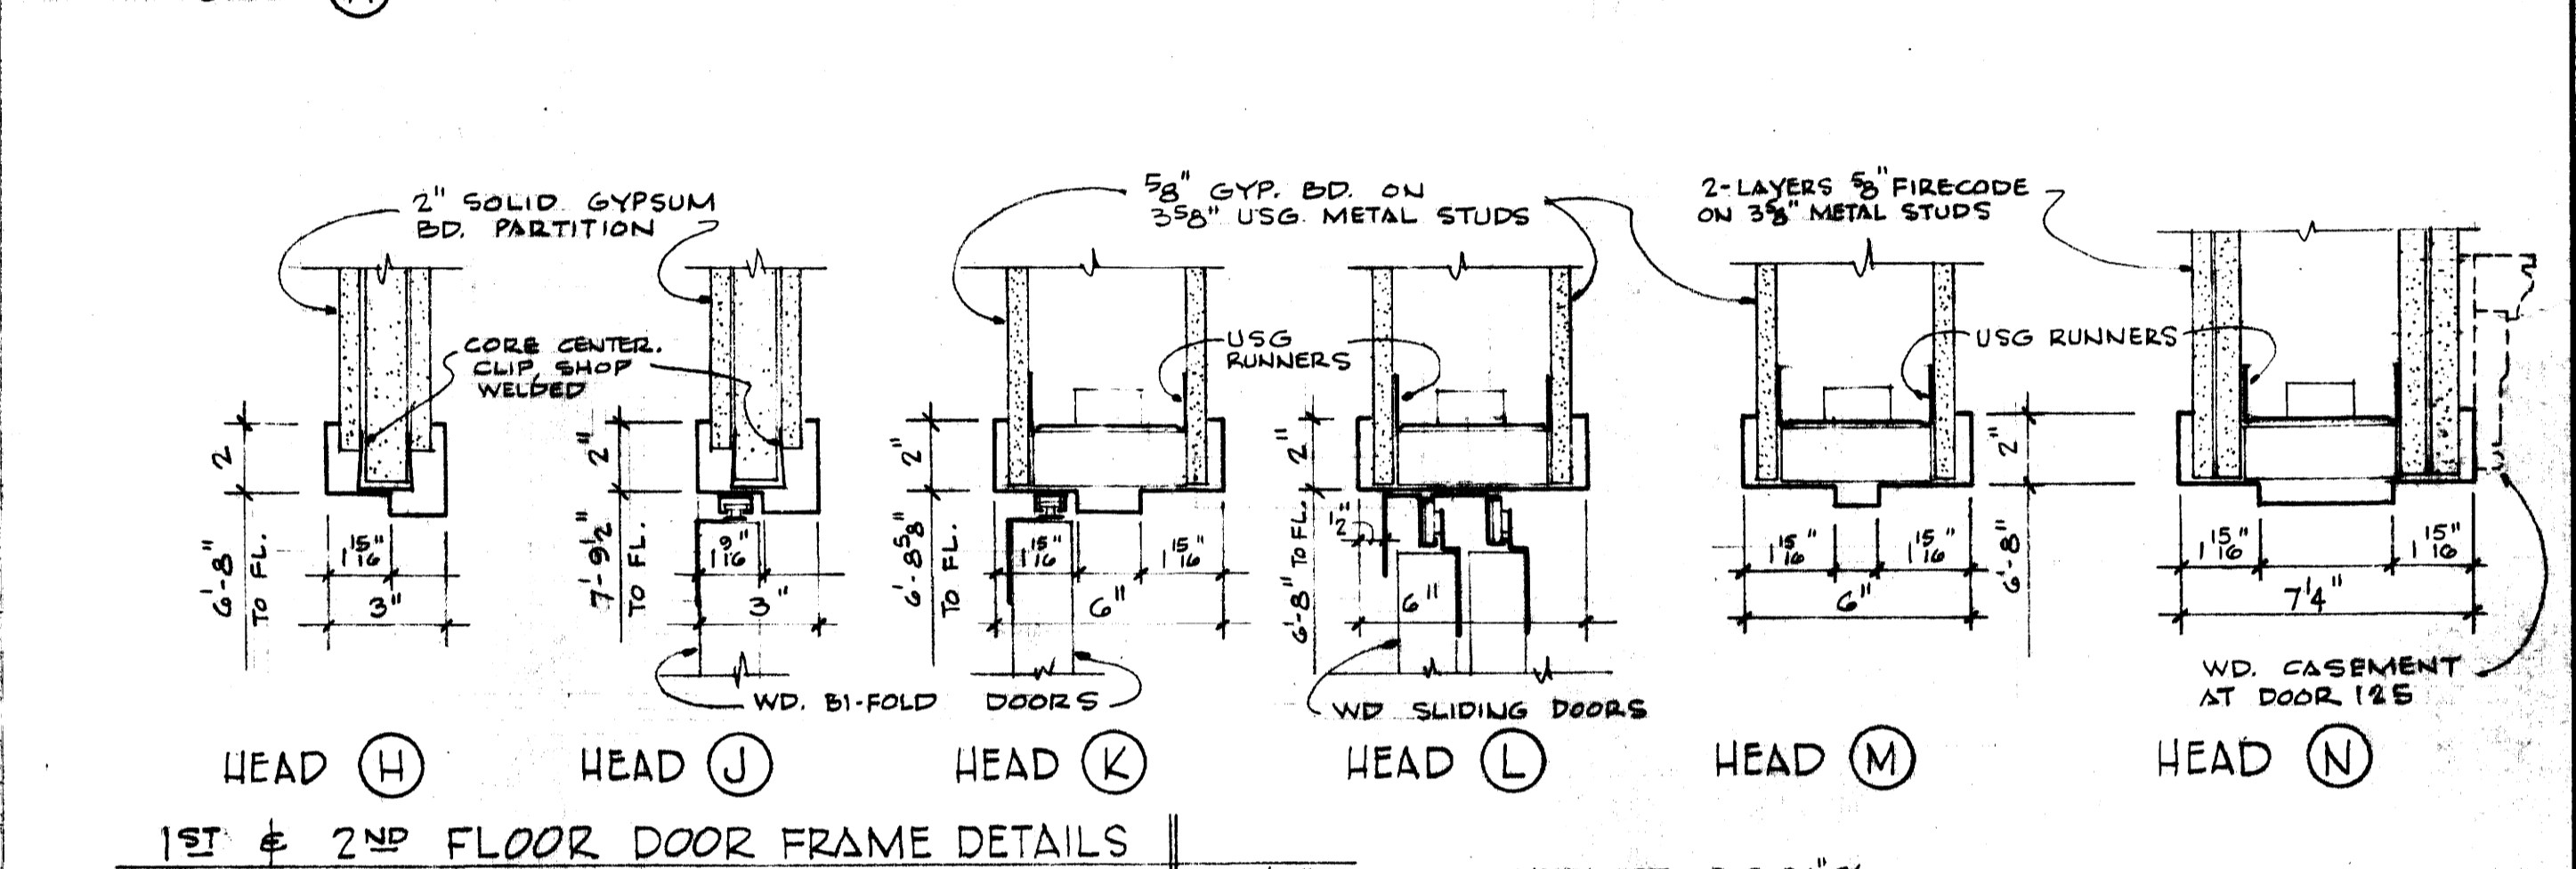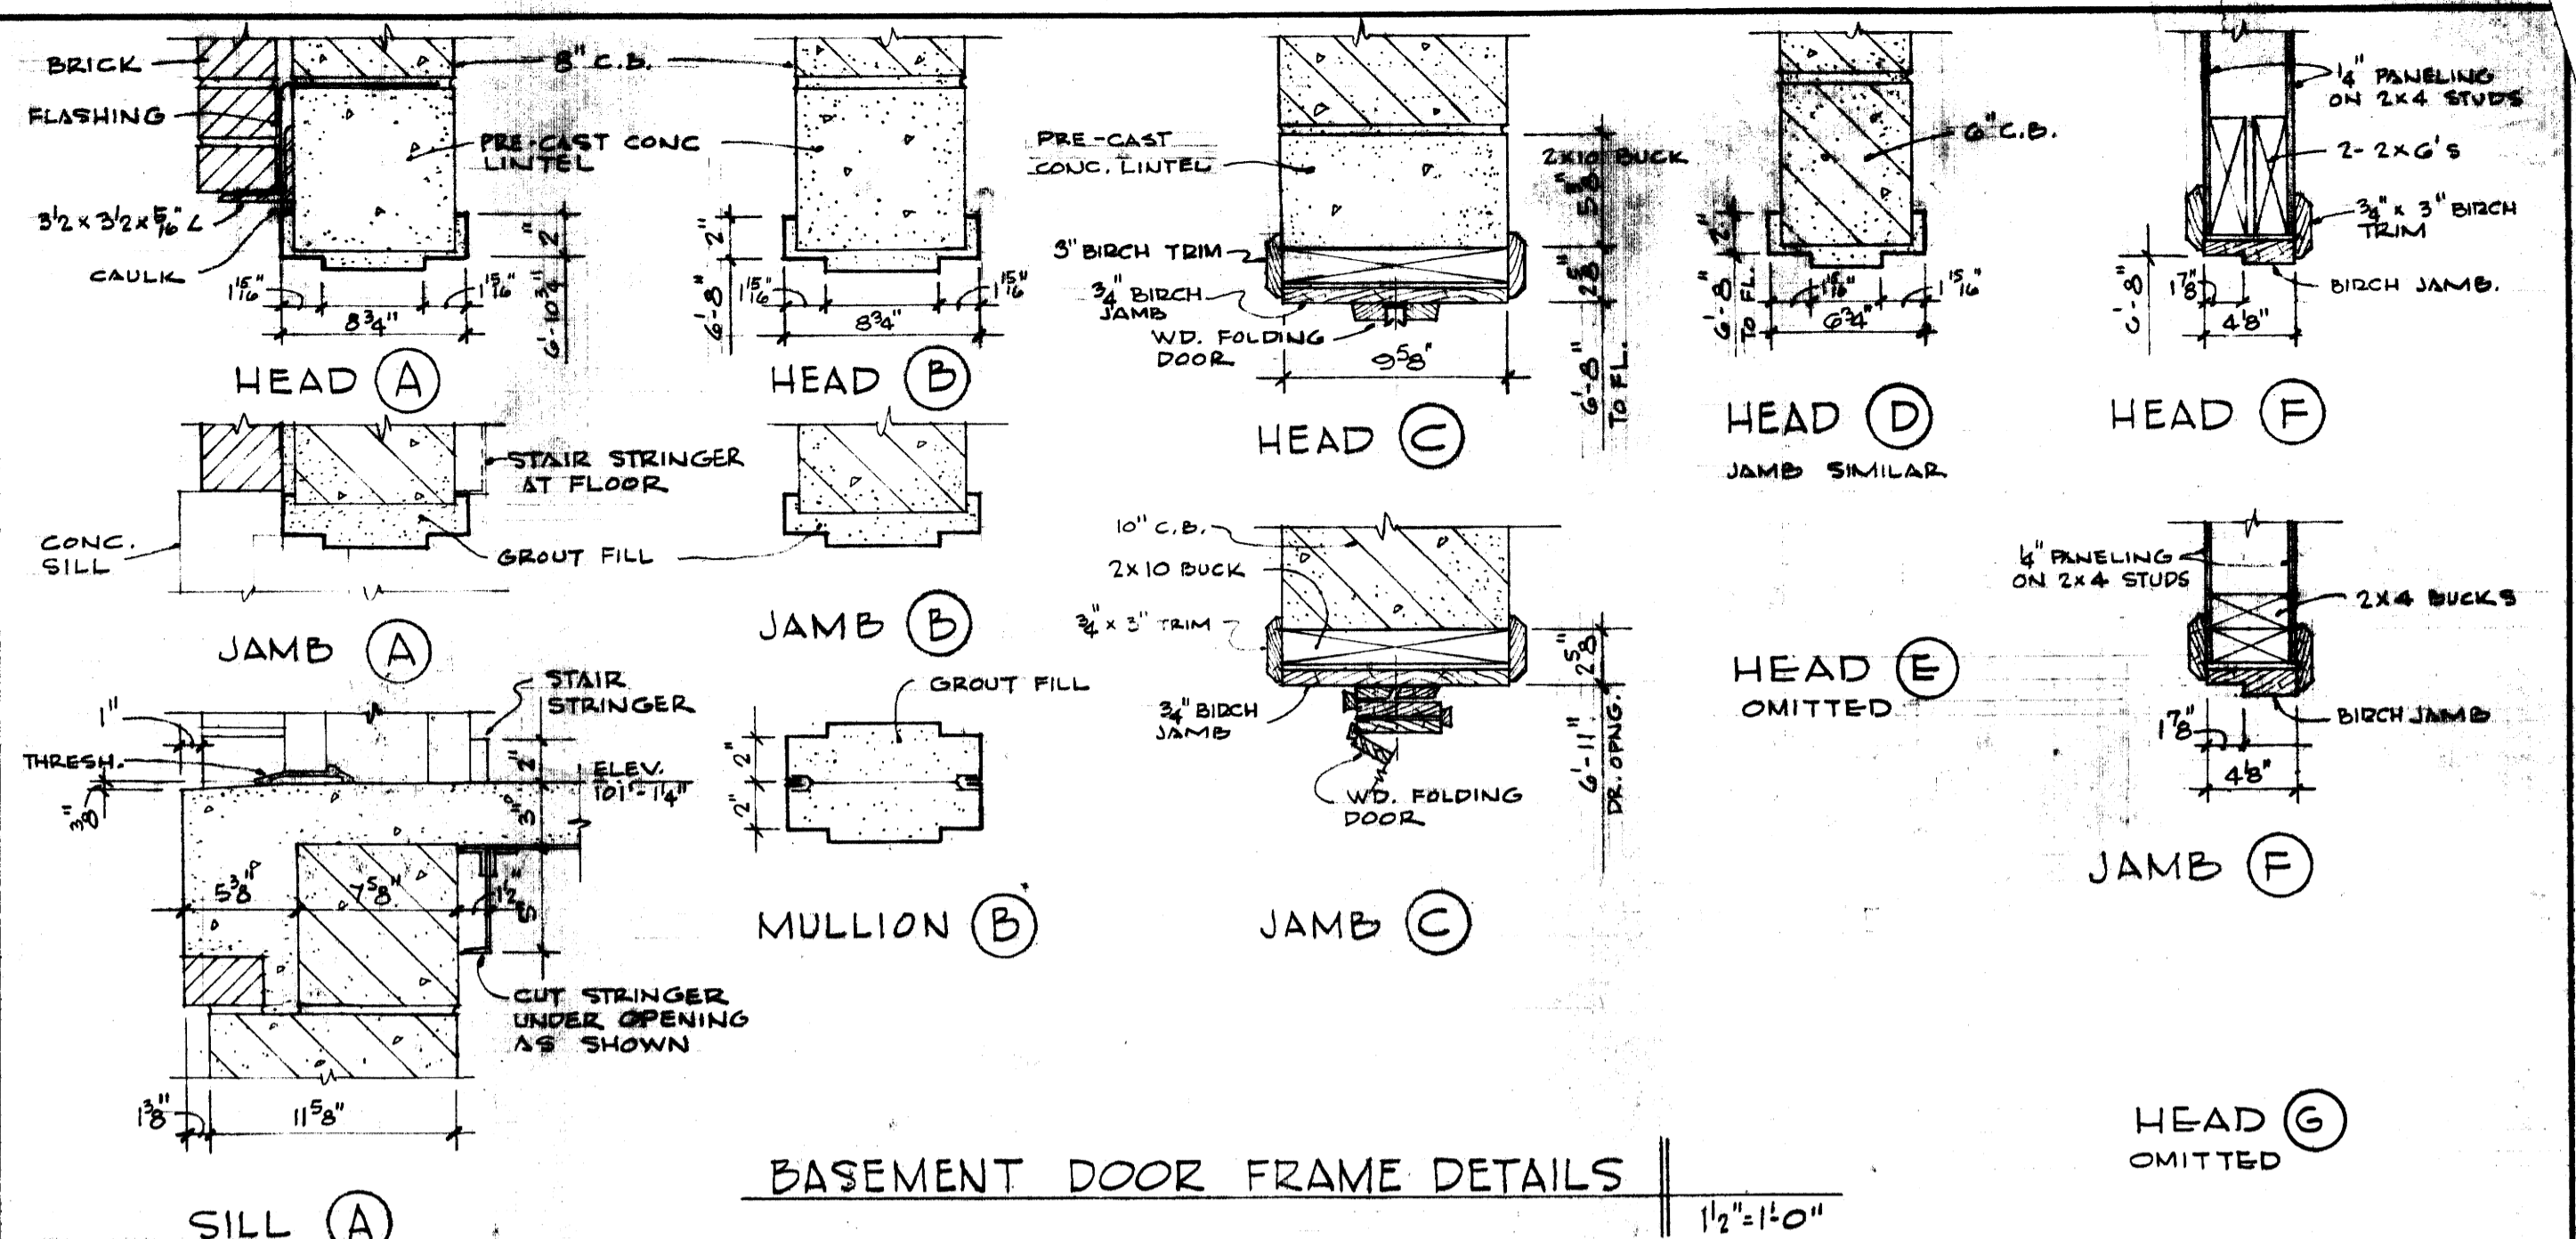


ROOM FINISH, DOOR, & FRAME SCHEDULE			
DELTA GAMMA SORORITY HOUSE UNIVERSITY OF KENTUCKY LEXINGTON KENTUCKY			
DRAWN BY R.W.K.	ARCHITECTURAL	DATE	1-8-63
TRACED BY	GILLIG • CHRISMAN & MILLER	SCALE	AS SHOWN
CHECKED BY J.G.	ARCHITECTS ASSOCIATED 109 WALNUT STREET LEXINGTON, KENTUCKY	SPEC. NO.	
REVISIONS	COMMONWEALTH OF KENTUCKY DEPARTMENT OF FINANCE ENGINEERING STAFF FRANKFORT KENTUCKY	DRAWING NO.	A10
APPROVED BY	<i>Frank D. Miller</i> ARCHITECT	DATE	1-25-63
APPROVED BY	<i>David H. Patton</i> CHIEF OF STAFF	DATE	



00097

1-1093

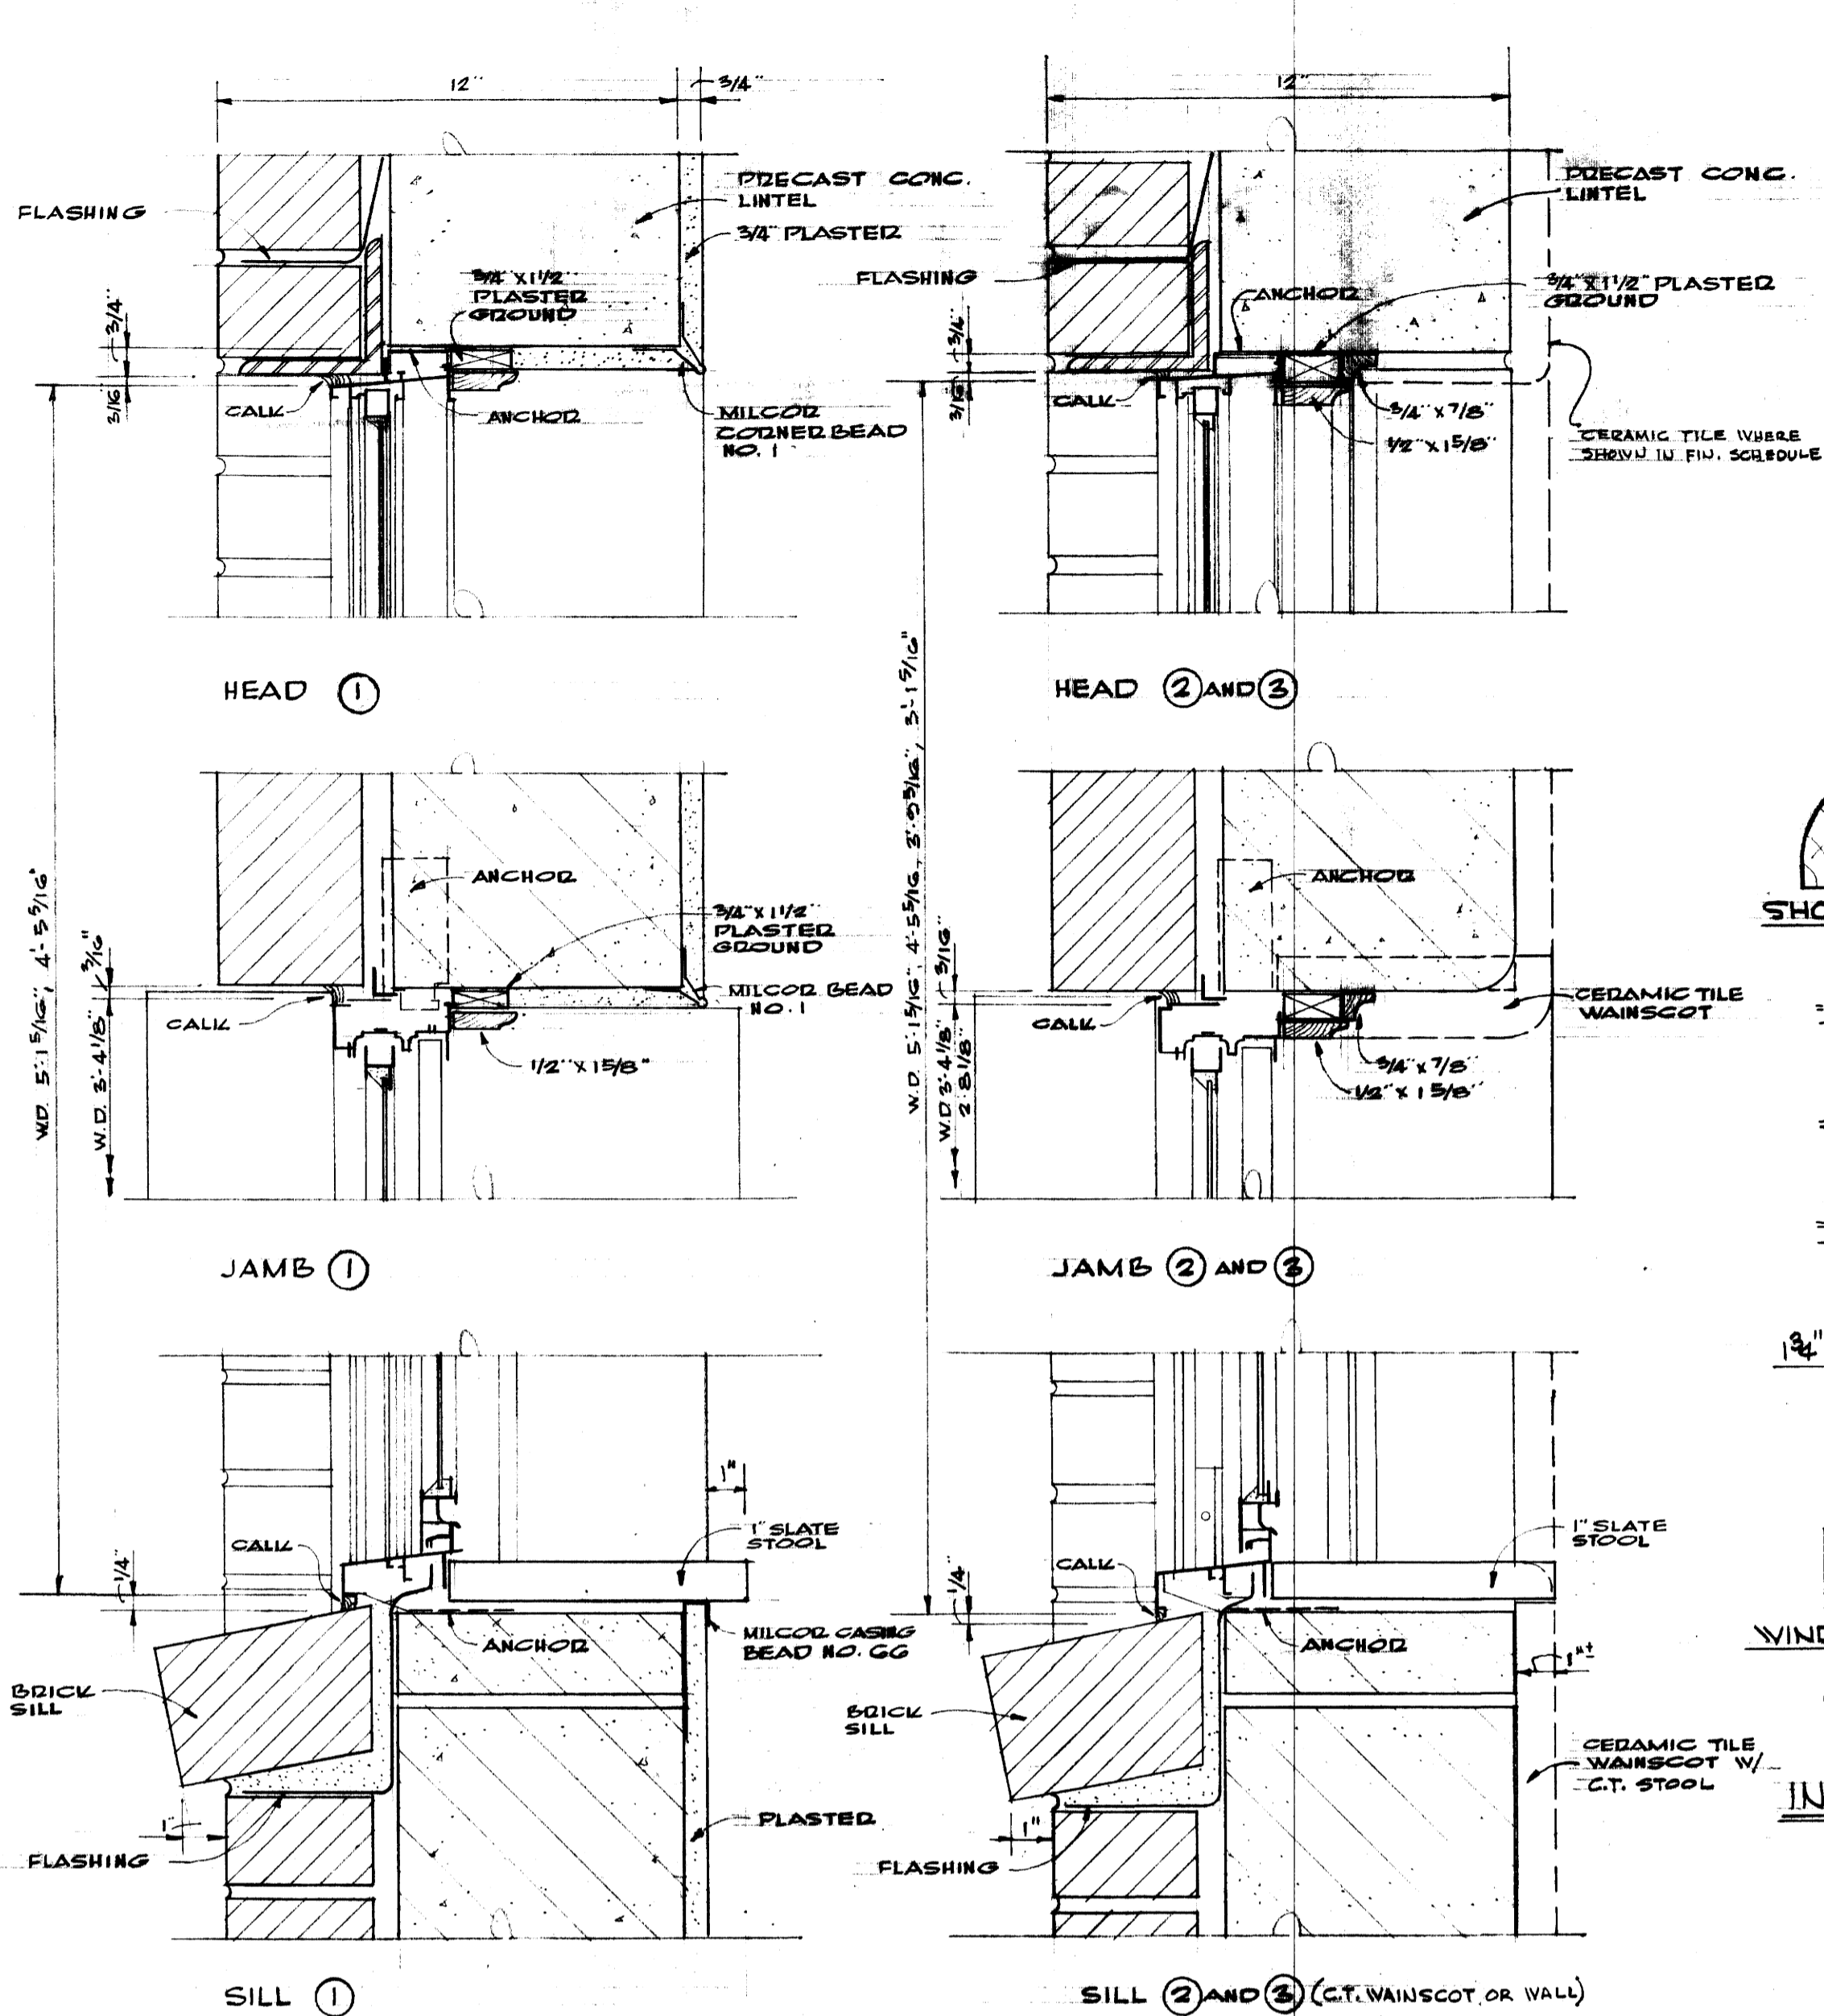

HEAD ①

HEAD ② AND ③


JAMB ①

JAMB ② AND ③


SILL ①

SILL ② AND ③ (C.T. WAINSCOT OR WALL)


WINDOW DETAILS
SCALE 3/4" = 1'-0"

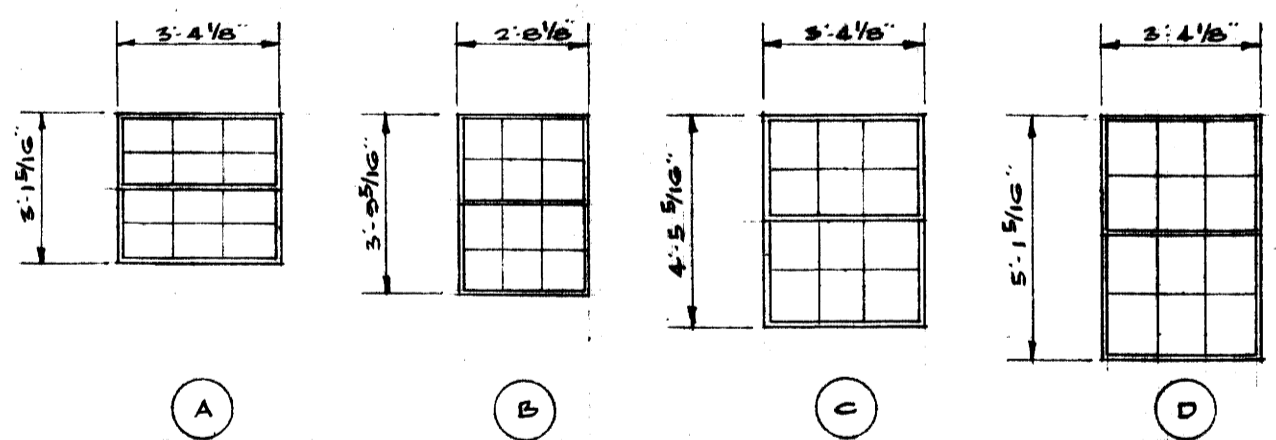

WINDOW TYPES
SCALE 1/2" = 1'-0"

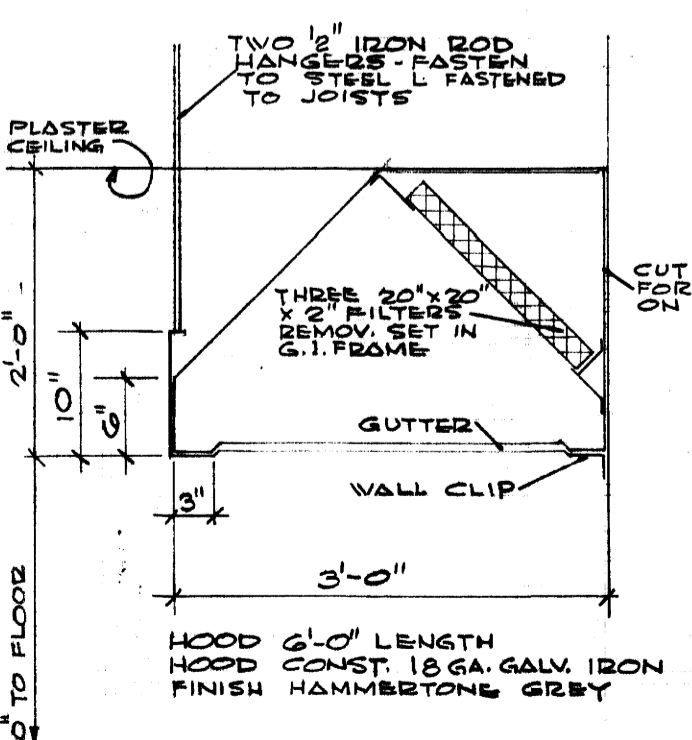


DETAIL - RANGE HOOD
3/4" = 1'-0"

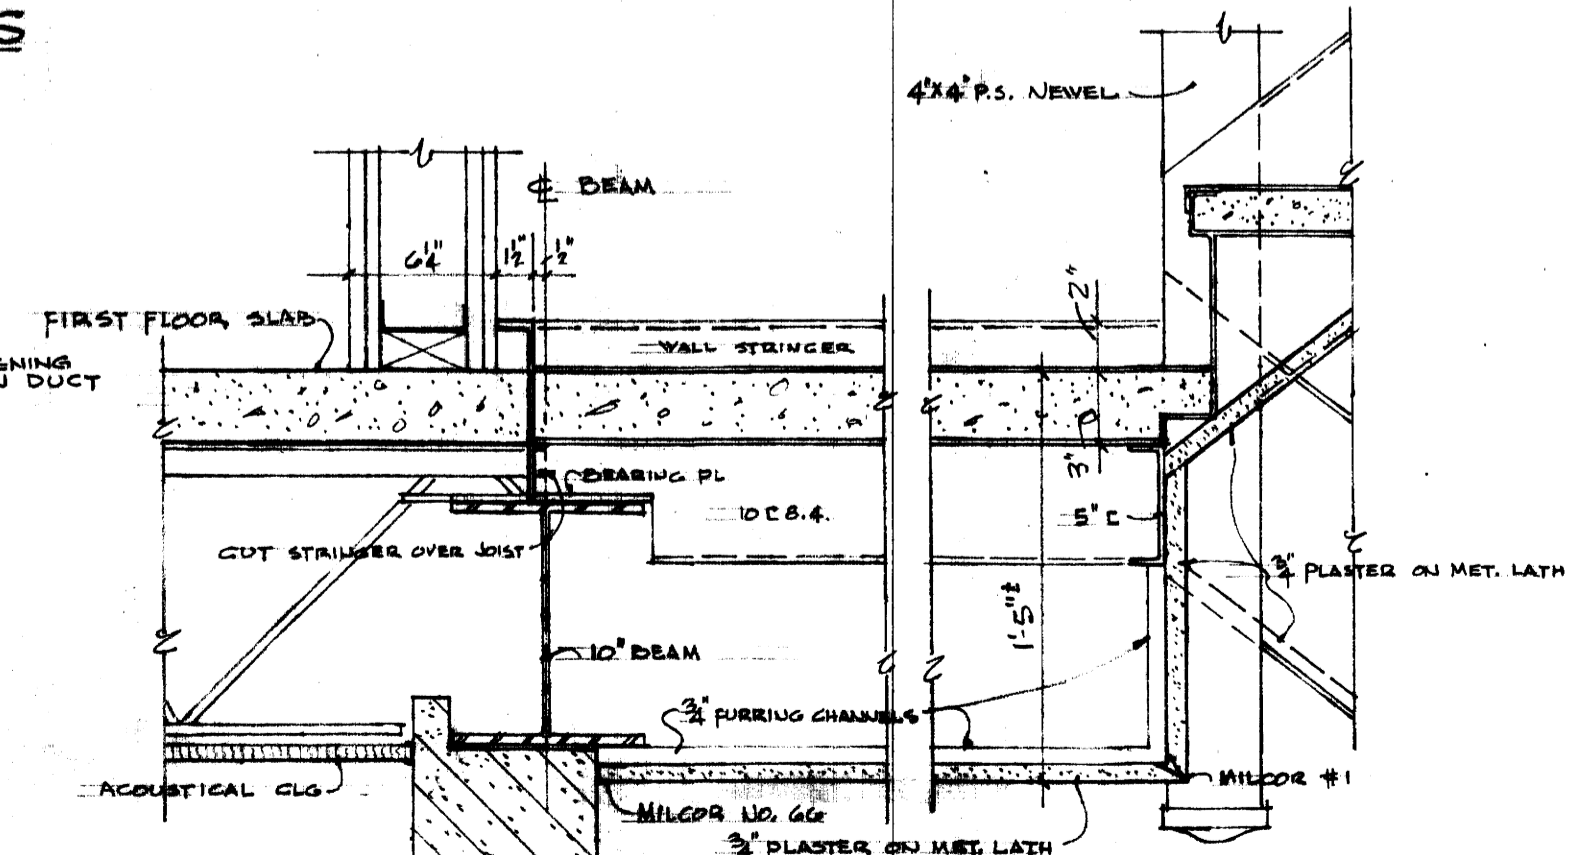


SECTION D
SCALE 1 1/2\"/>

THIS DETAIL SIMILAR AT FIRST & SECOND FLOOR FOR BOTH STAIRS UP & DOWN

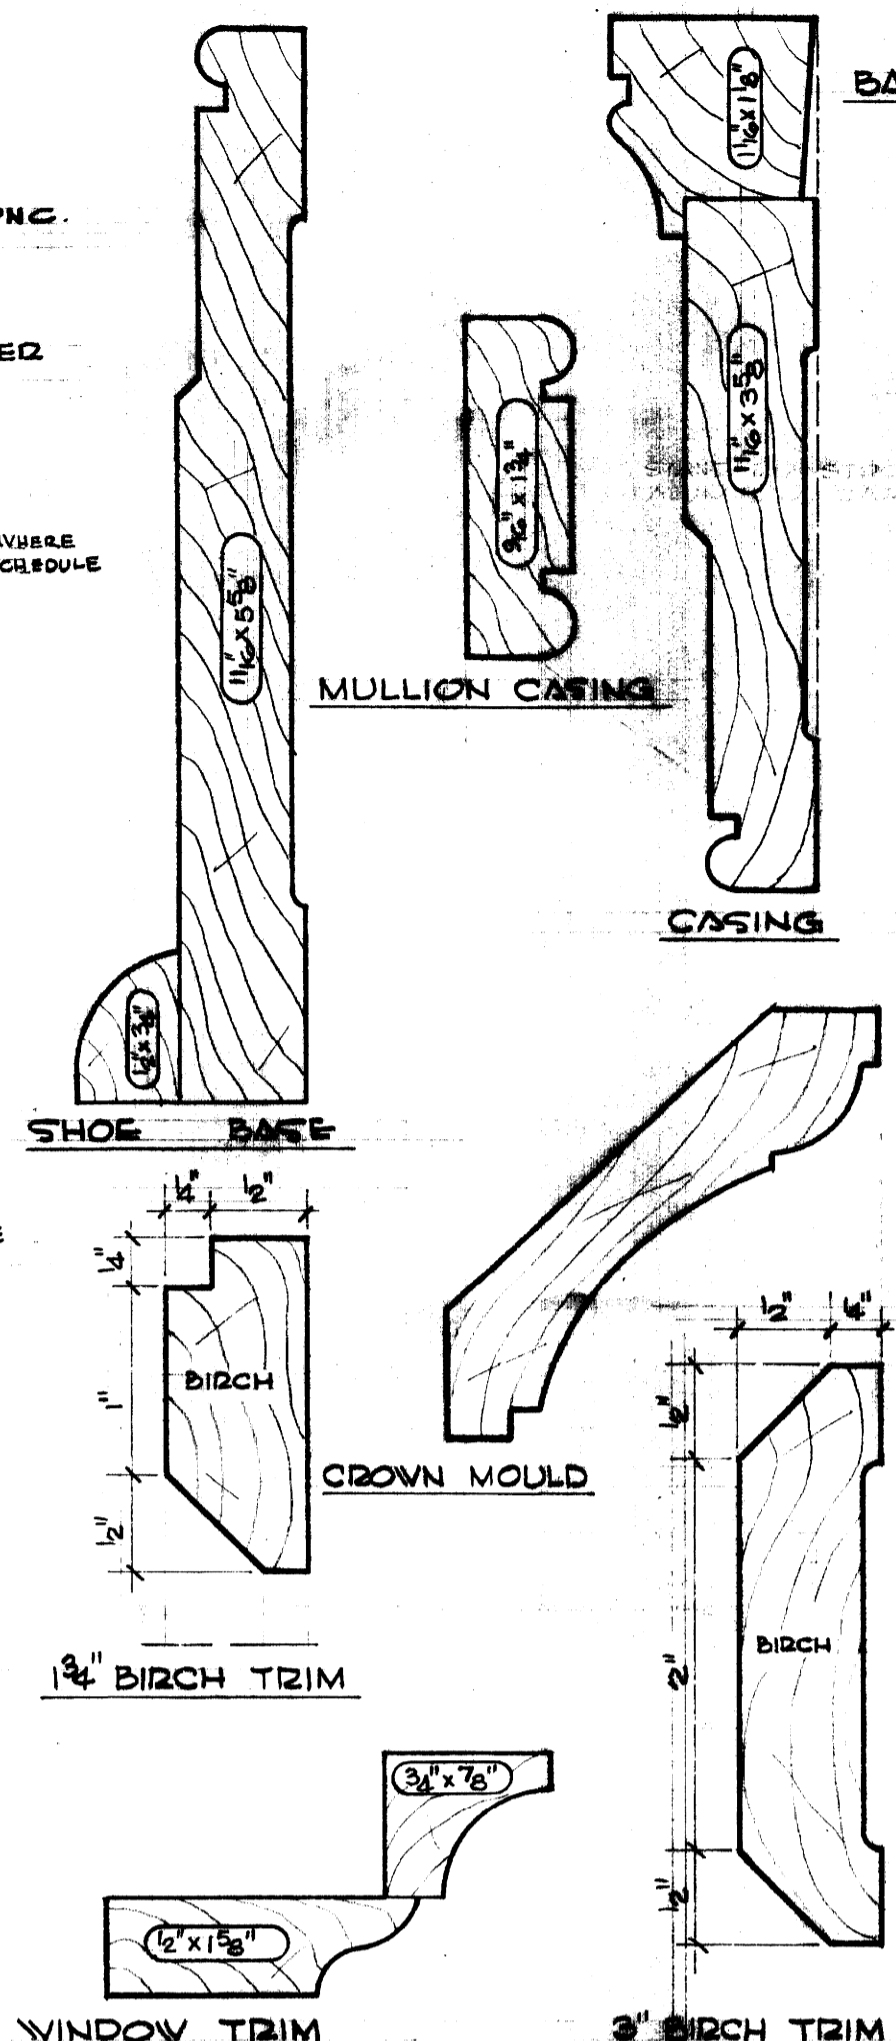

INTERIOR WOOD TRIM - FULL SIZE
NOTE: ALL TRIM W.M.P. EXCEPT AS OTHERWISE INDICATED

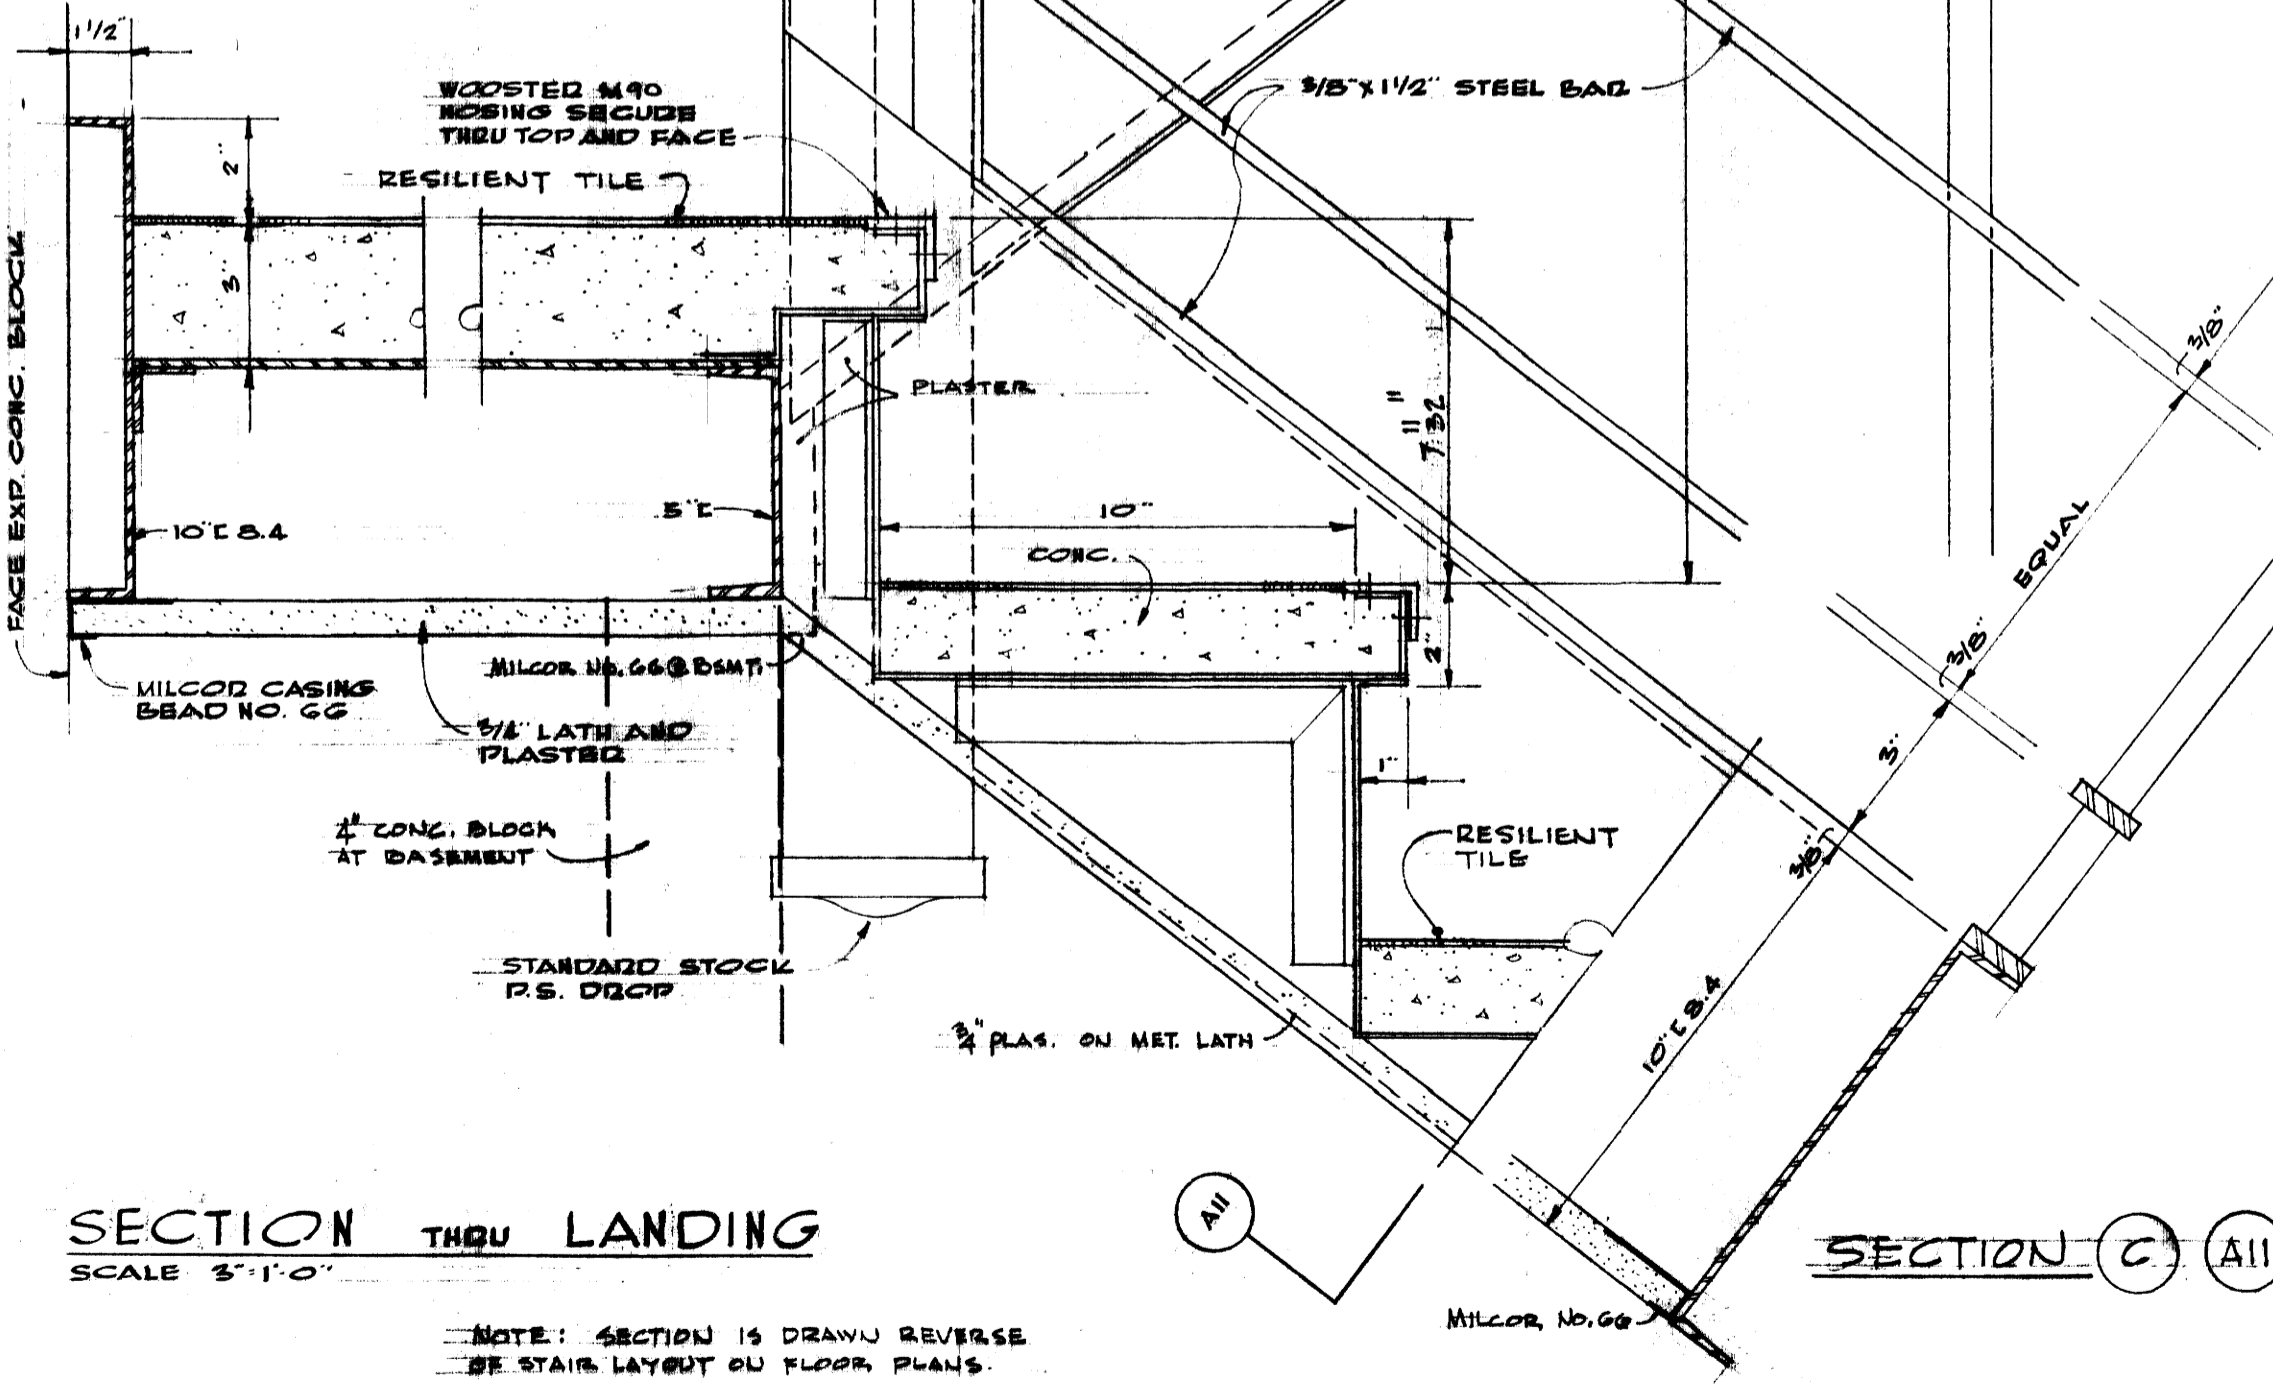

SECTION THRU LANDING
SCALE 3/4" = 1'-0"


NOTE: SECTION IS DRAWN REVERSE OF STAIR LAYOUT ON FLOOR PLANS

STAIR DETAILS


SECTION C (A11)

SECTION B (A11)

NOTE: SECTION IS DRAWN REVERSE OF STAIR LAYOUT ON FLOOR PLAN

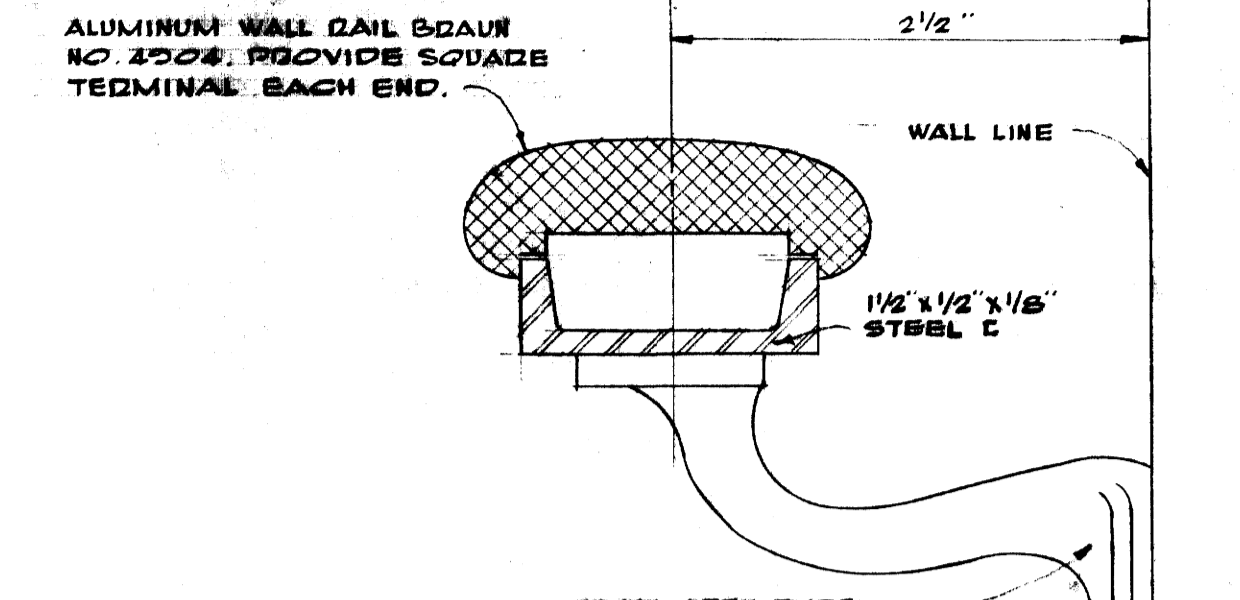

E.S. WALL RAIL AND BRACKET

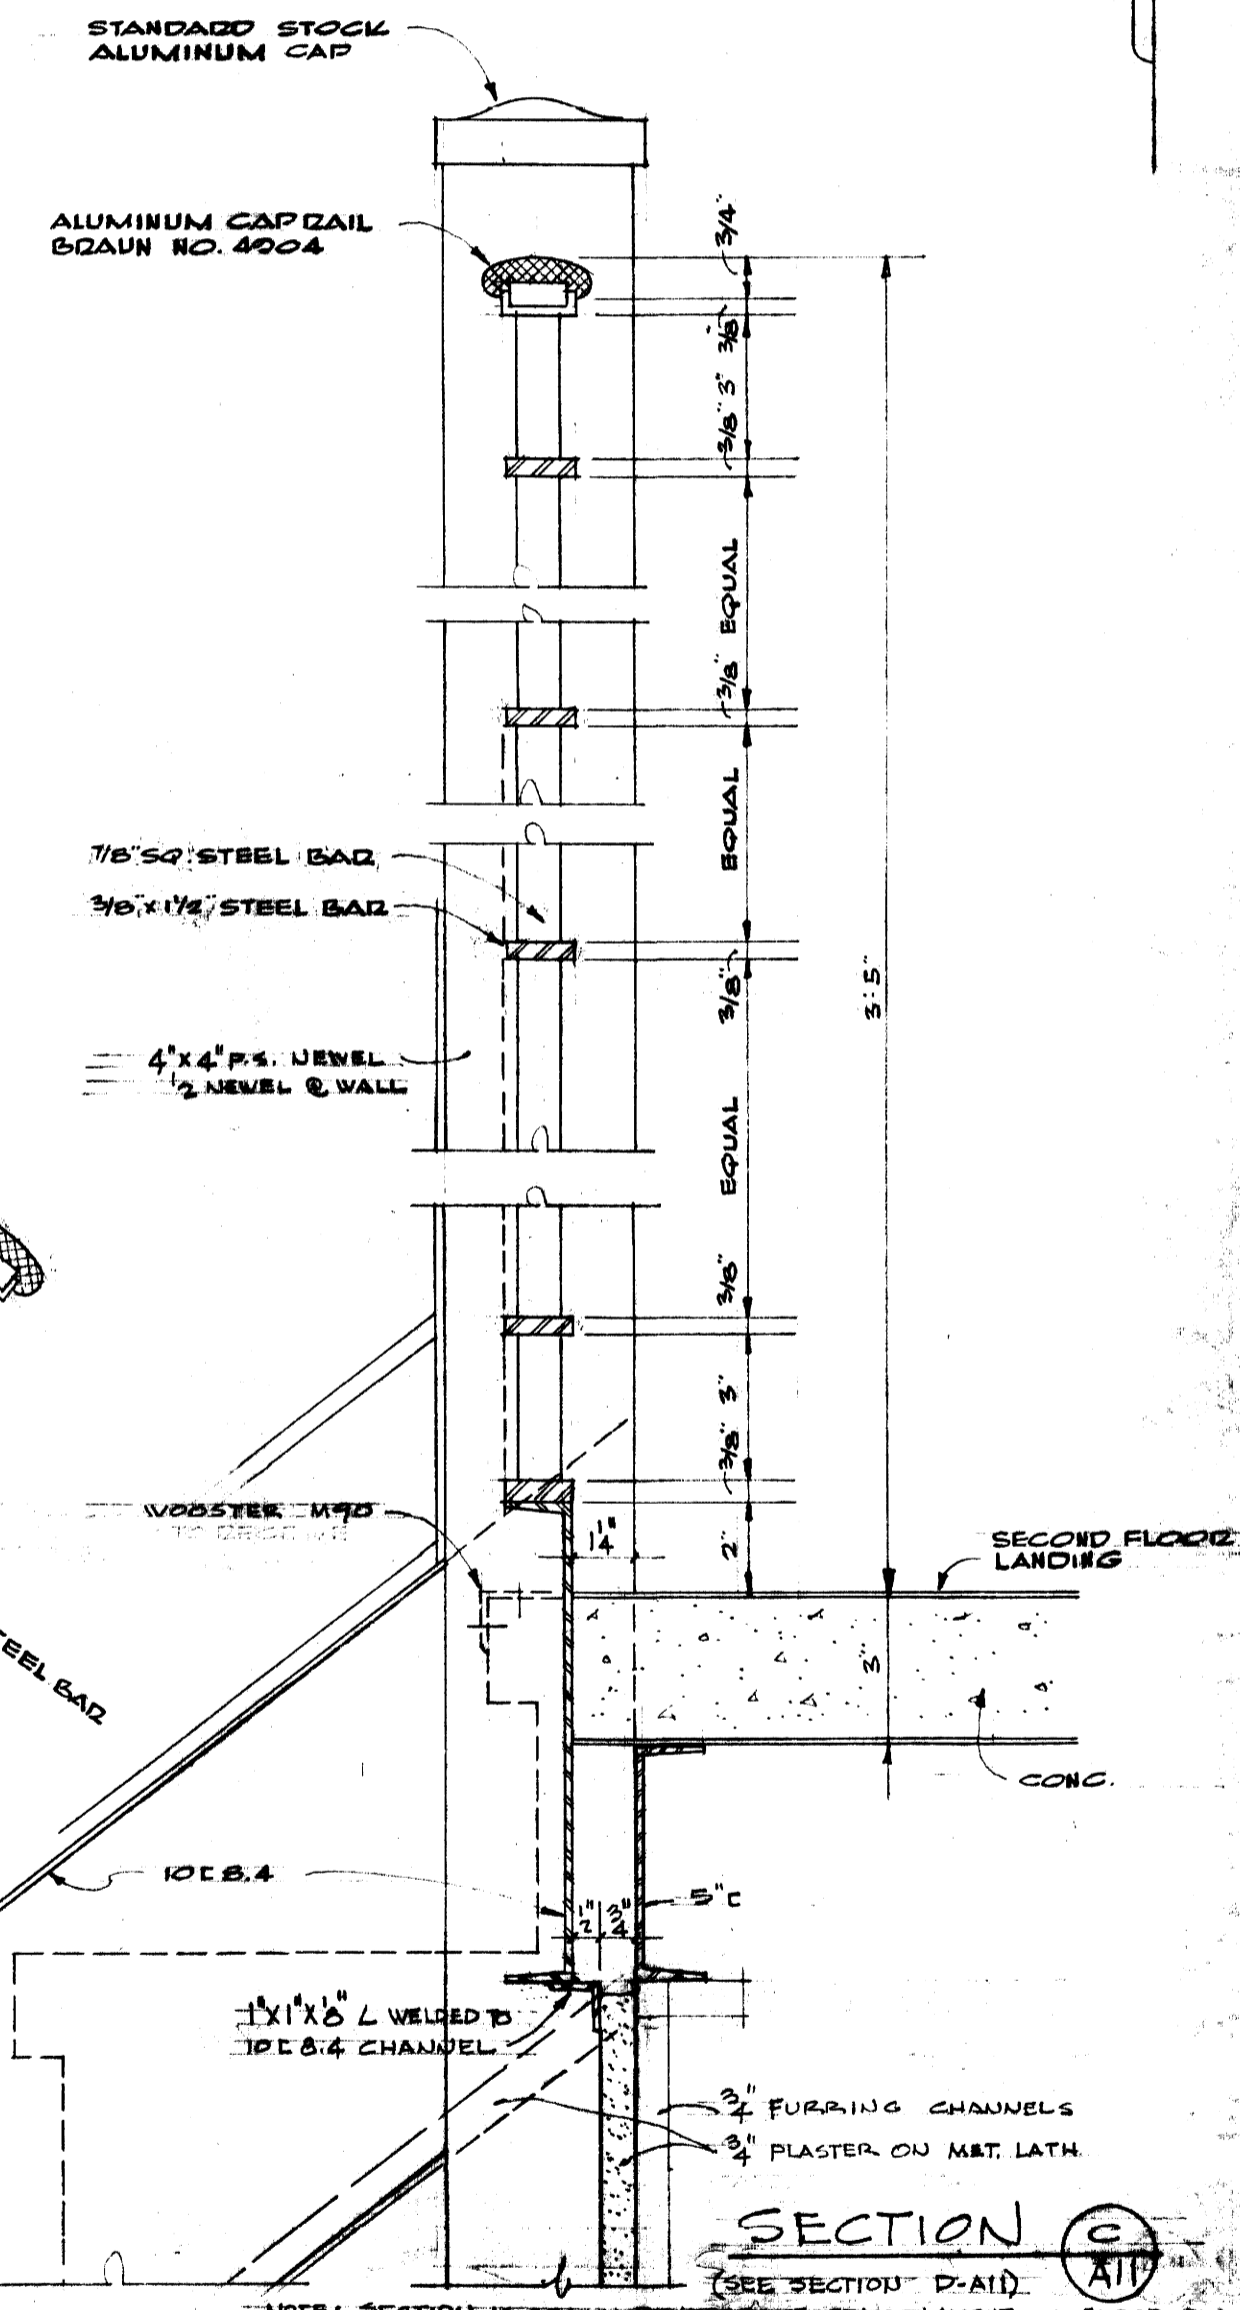

SECTION C (A11)

NOTE: SECTION IS DRAWN REVERSE OF STAIR LAYOUT ON FLOOR PLANS

DELTA GAMMA SORORITY HOUSE
UNIVERSITY OF KENTUCKY
LEXINGTON, KENTUCKY

DRAWN BY VIC	ARCHITECTURAL	DATE 1-8-63
TRACED BY DP	GILLIG • CHRISMAN & MILLER ARCHITECTS ASSOCIATED	SCALE AS SHOWN
CHECKED BY J.C.	180 WALNUT STREET LEXINGTON, KENTUCKY	SPEC. NO.
REVISIONS	COMMONWEALTH OF KENTUCKY DEPARTMENT OF FINANCE ENGINEERING STAFF FRANKFORT, KENTUCKY	DRAWING NO. 1-25-63

APPROVED BY: *[Signature]* DATE: *[Date]*
APPROVED BY: *[Signature]* CHIEF OF STAFF DATE: *[Date]*





0080 98

121 C-2

U-1894


STEEL COLUMN SCHEDULE						
FLOOR	COLUMN NUMBER	COLUMN SIZE	LEVELING PLATE SIZE	BASE PLATE SIZE	ELEVATION BOTTOM OF COLUMN BASE PLATE	ELEVATION TOP OF COLUMN BASE PLATE
BASEMENT	1	8WF28	12x12x4	12x12x1/2	89'-8 1/2"	98'-8 1/2"
	2	8WF28	12x12x4	12x12x1/2	89'-8 1/2"	98'-8 1/2"
	3	8WF28	12x12x4	12x12x1/2	89'-8 1/2"	98'-8 1/2"
	4	8WF28	12x12x4	12x12x1/2	89'-8 1/2"	98'-8 1/2"
	5	8WF28	12x12x4	12x12x1/2	89'-8 1/2"	98'-8 1/2"
	6	8WF28	12x12x4	12x12x1/2	89'-8 1/2"	98'-8 1/2"
FIRST FLOOR	1	8x4x34.48		9x4x1/2	99'-7"	108'-6"
	2	8x4x34.48		9x4x1/2	99'-7"	108'-6"
	3	8x4x34.48		9x4x1/2	99'-7"	108'-6"
	4	8x4x34.48		9x4x1/2	99'-7"	108'-6"
	5	8x4x34.48		9x4x1/2	99'-7"	108'-6"
	6	8x4x34.48		9x4x1/2	99'-7"	108'-6"
SECOND FLOOR	1	6x4x21.94		9x4x1/2	109'-4 1/2"	117'-10 3/8"
	2	6x4x21.94		9x4x1/2	109'-4 1/2"	117'-10 3/8"
	3	6x4x21.94		9x4x1/2	109'-4 1/2"	117'-10 3/8"
	4	6x4x21.94		9x4x1/2	109'-4 1/2"	117'-10 3/8"
	5	6x4x21.94		9x4x1/2	109'-4 1/2"	117'-10 3/8"
	6	6x4x21.94		9x4x1/2	109'-4 1/2"	117'-10 3/8"

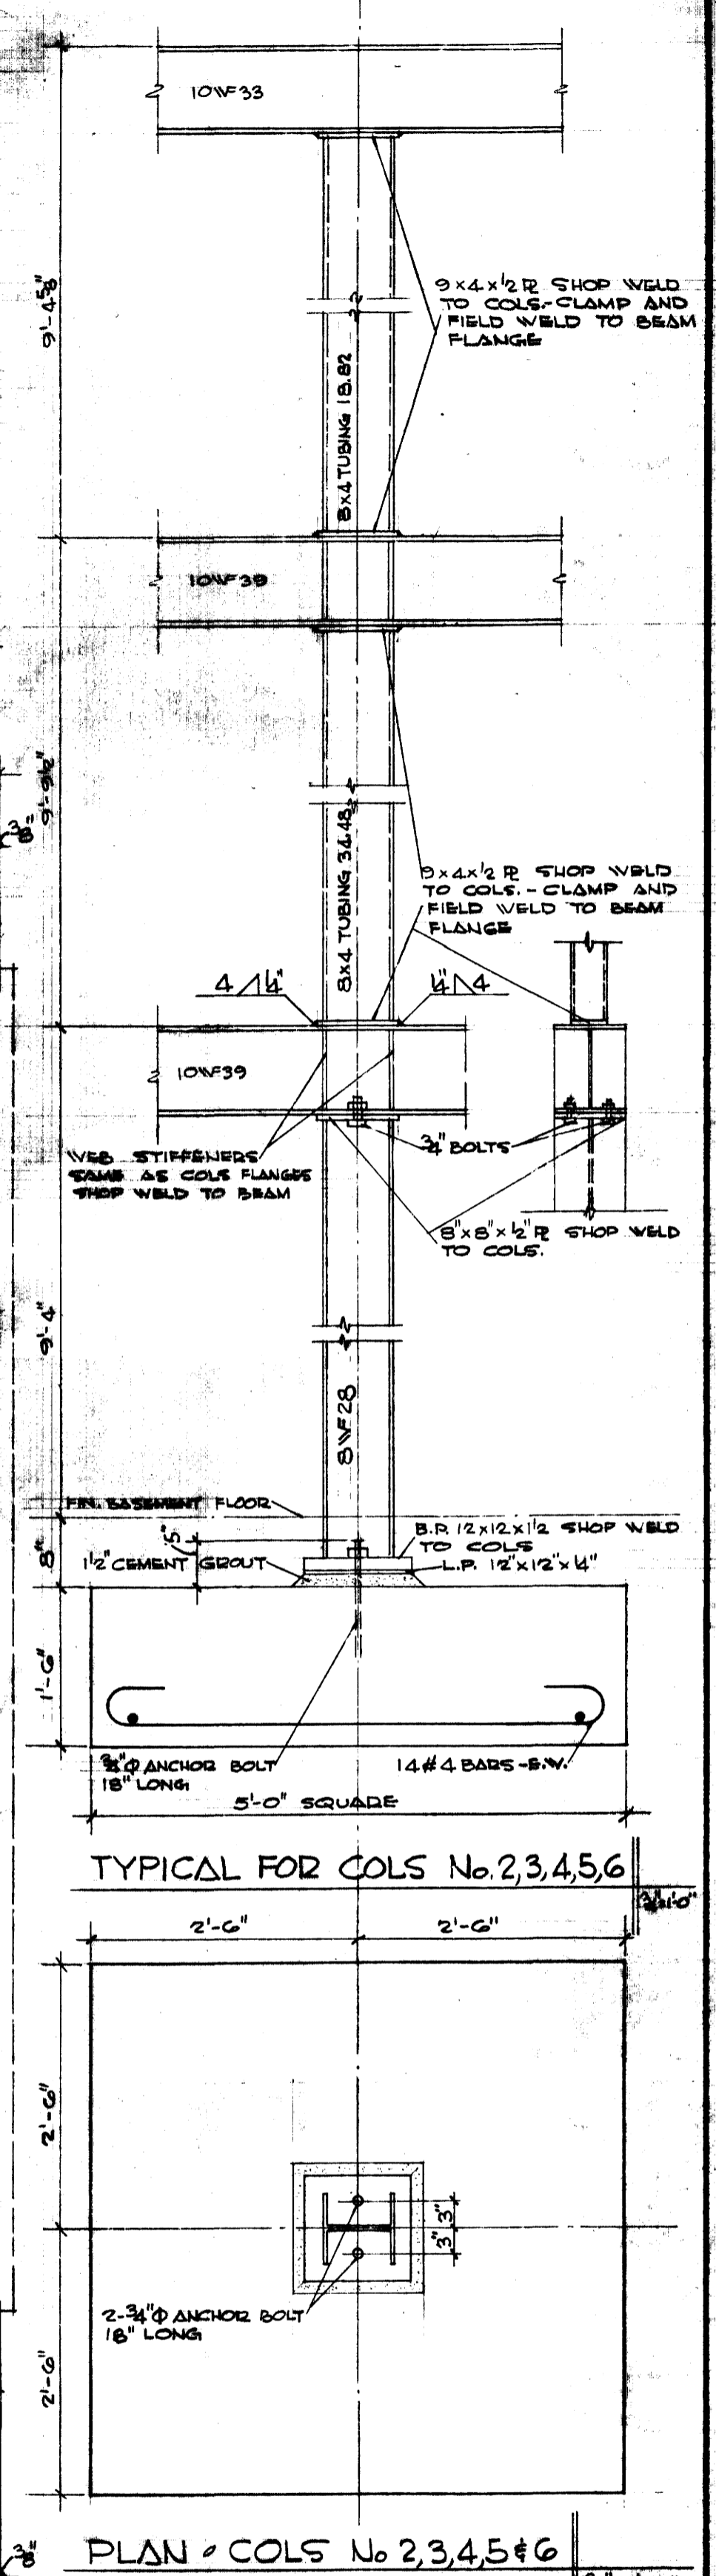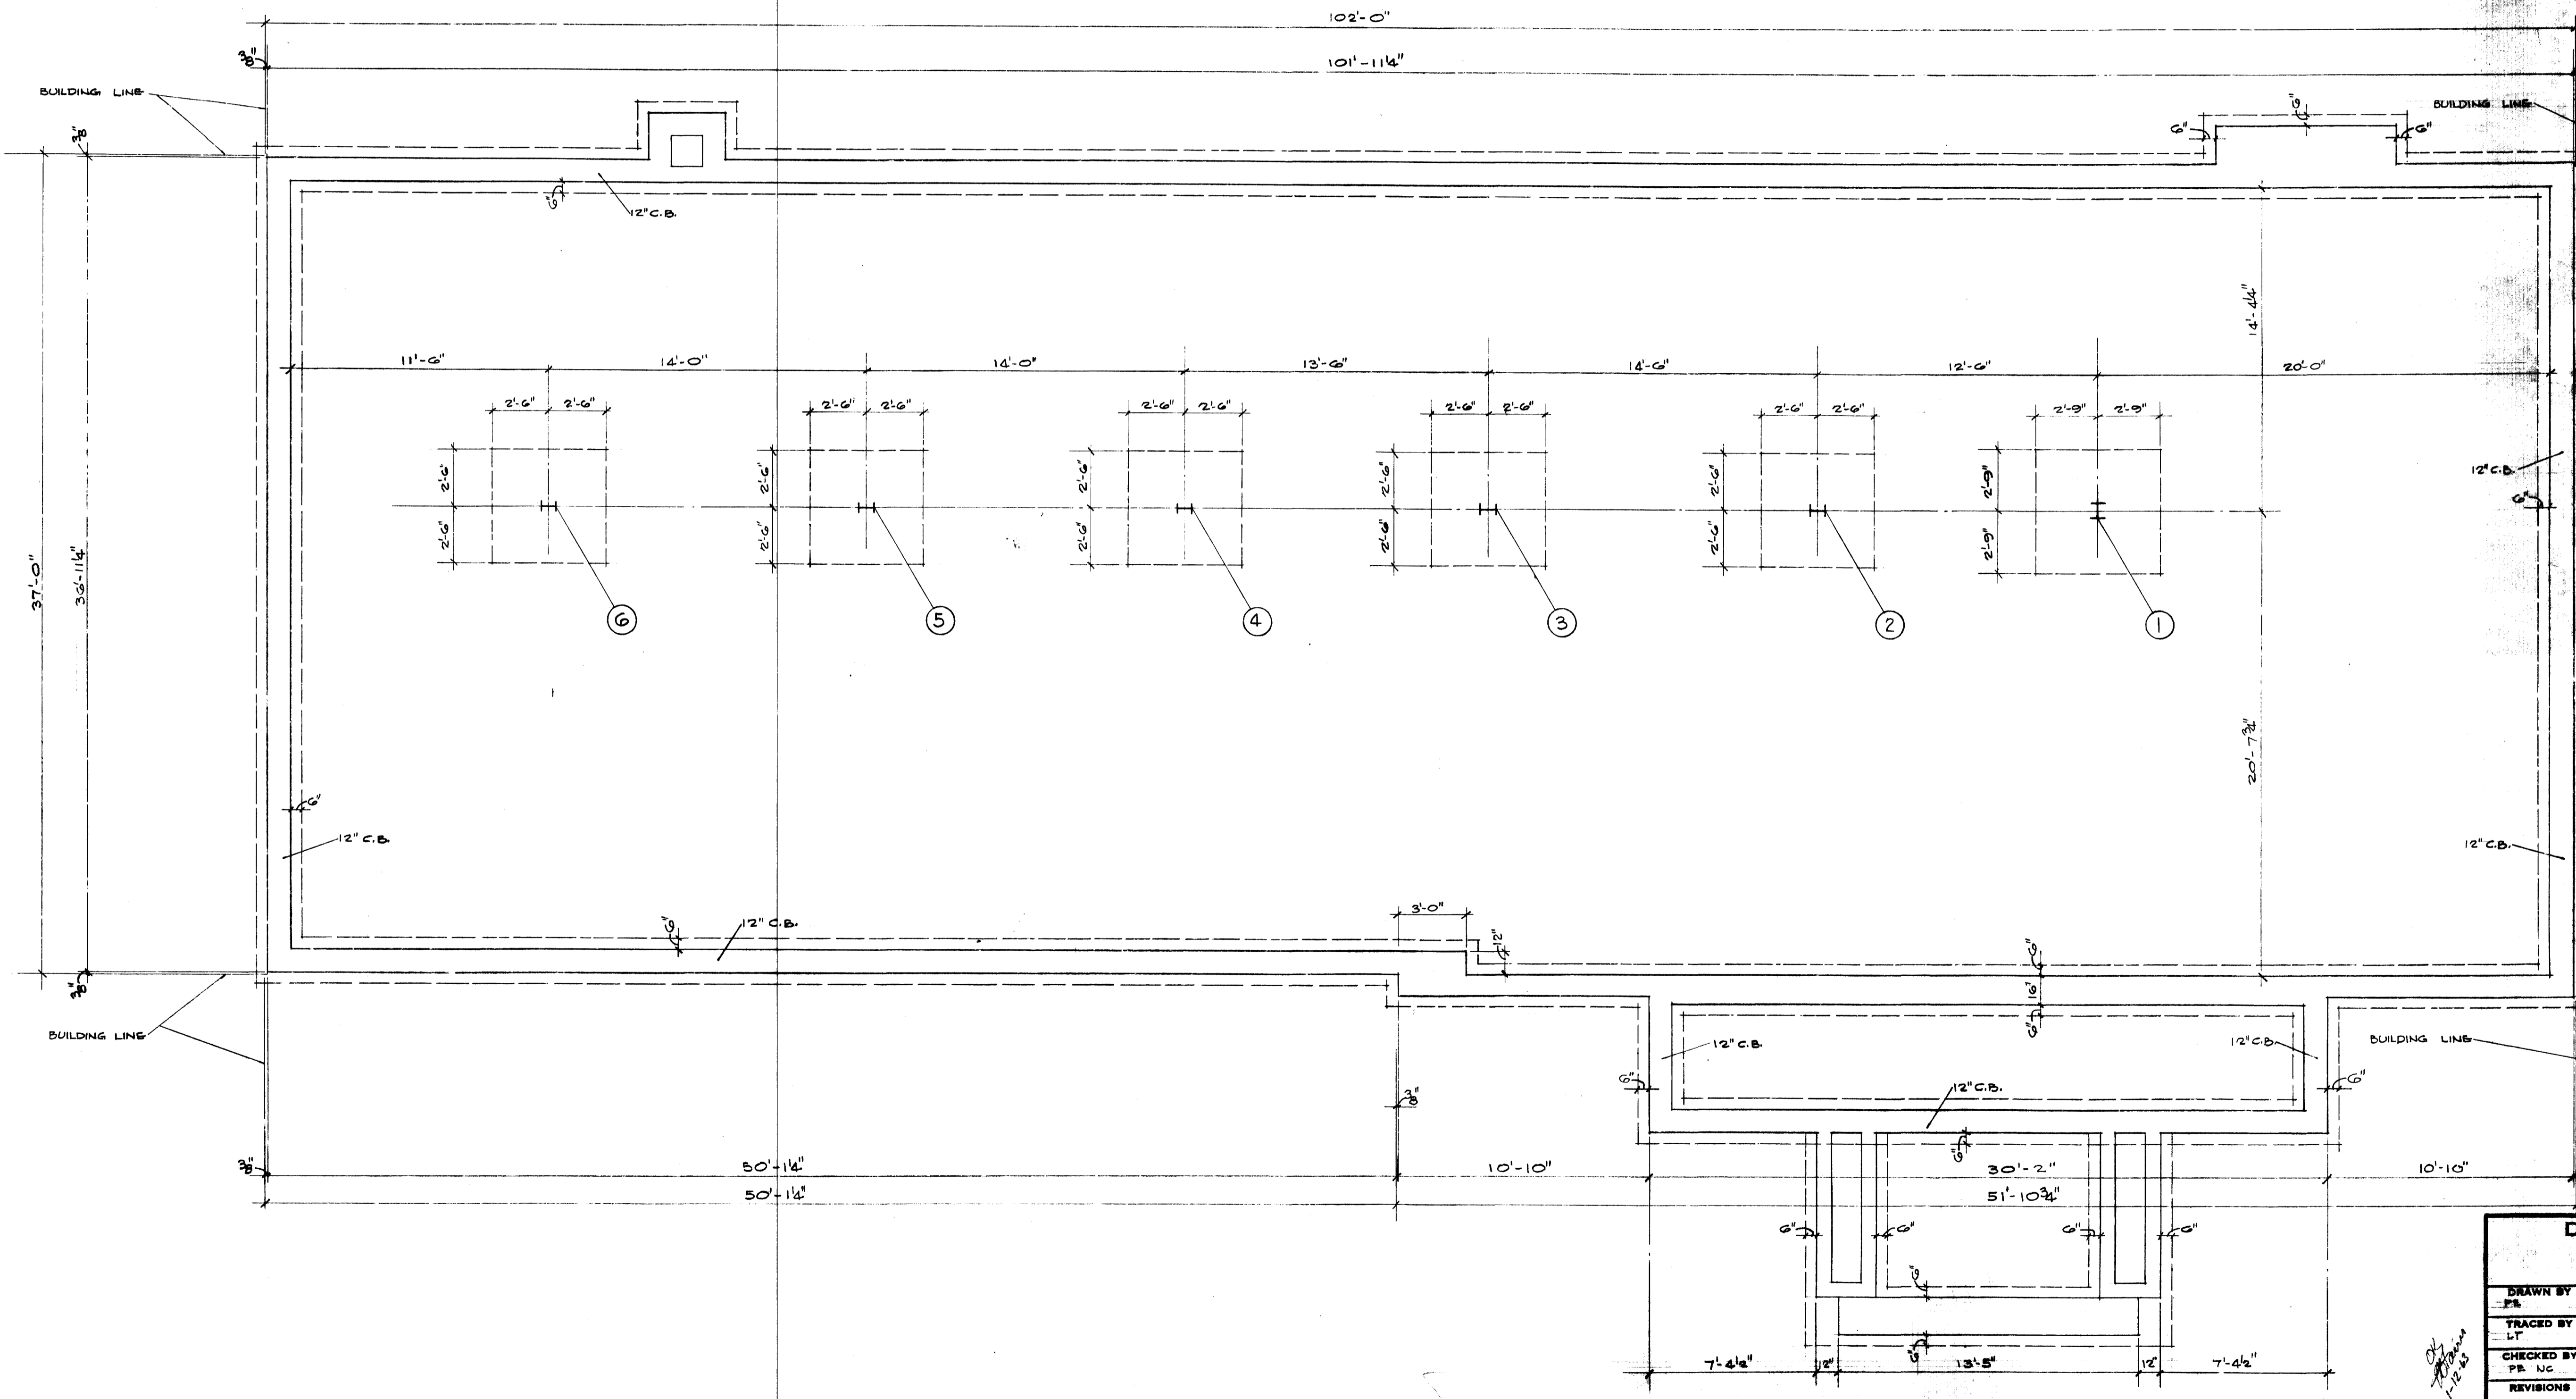

FOUNDATION PLAN



DELTA GAMMA SORORITY HOUSE
UNIVERSITY OF KENTUCKY
 LEXINGTON KENTUCKY

DRAWN BY PK	STRUCTURAL	DATE 1-8-65
TRACED BY LT	GILLIG • CHRISMAN & MILLER ARCHITECTS ASSOCIATED 180 WALNUT STREET LEXINGTON, KENTUCKY	SCALE AS SHOWN SPEC. NO.
CHECKED BY PK	COMMONWEALTH OF KENTUCKY DEPARTMENT OF FINANCE ENGINEERING STAFF FRANKFORT KENTUCKY	DRAWING NO. 51
APPROVED BY <i>Frank Eades</i>	AGENCY HEAD	DATE 1-21-65
APPROVED BY <i>David H. Pritchard</i>	ENGINEER	DATE

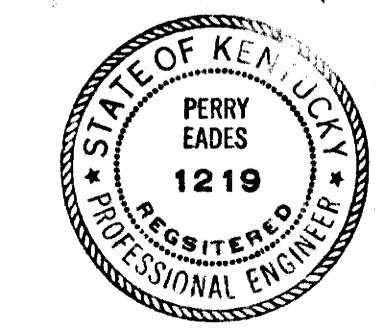

U-1895

00 8099

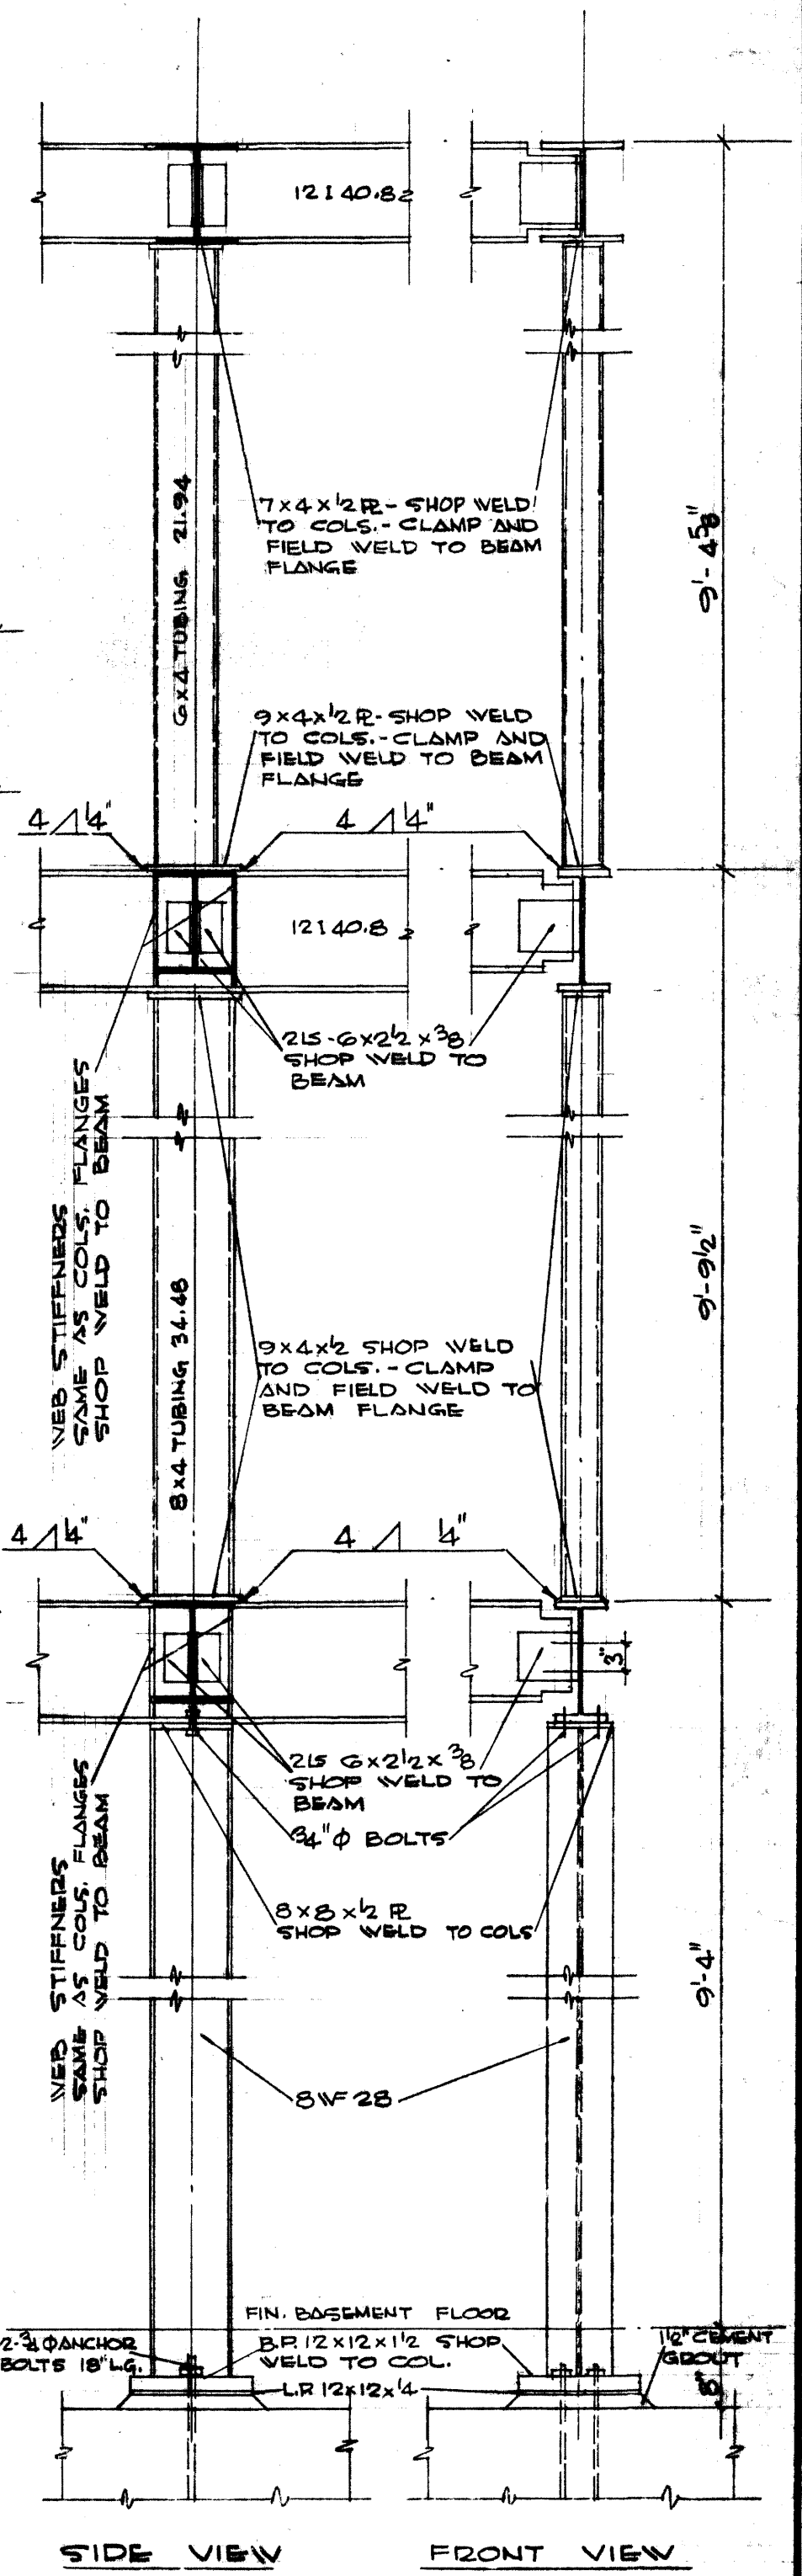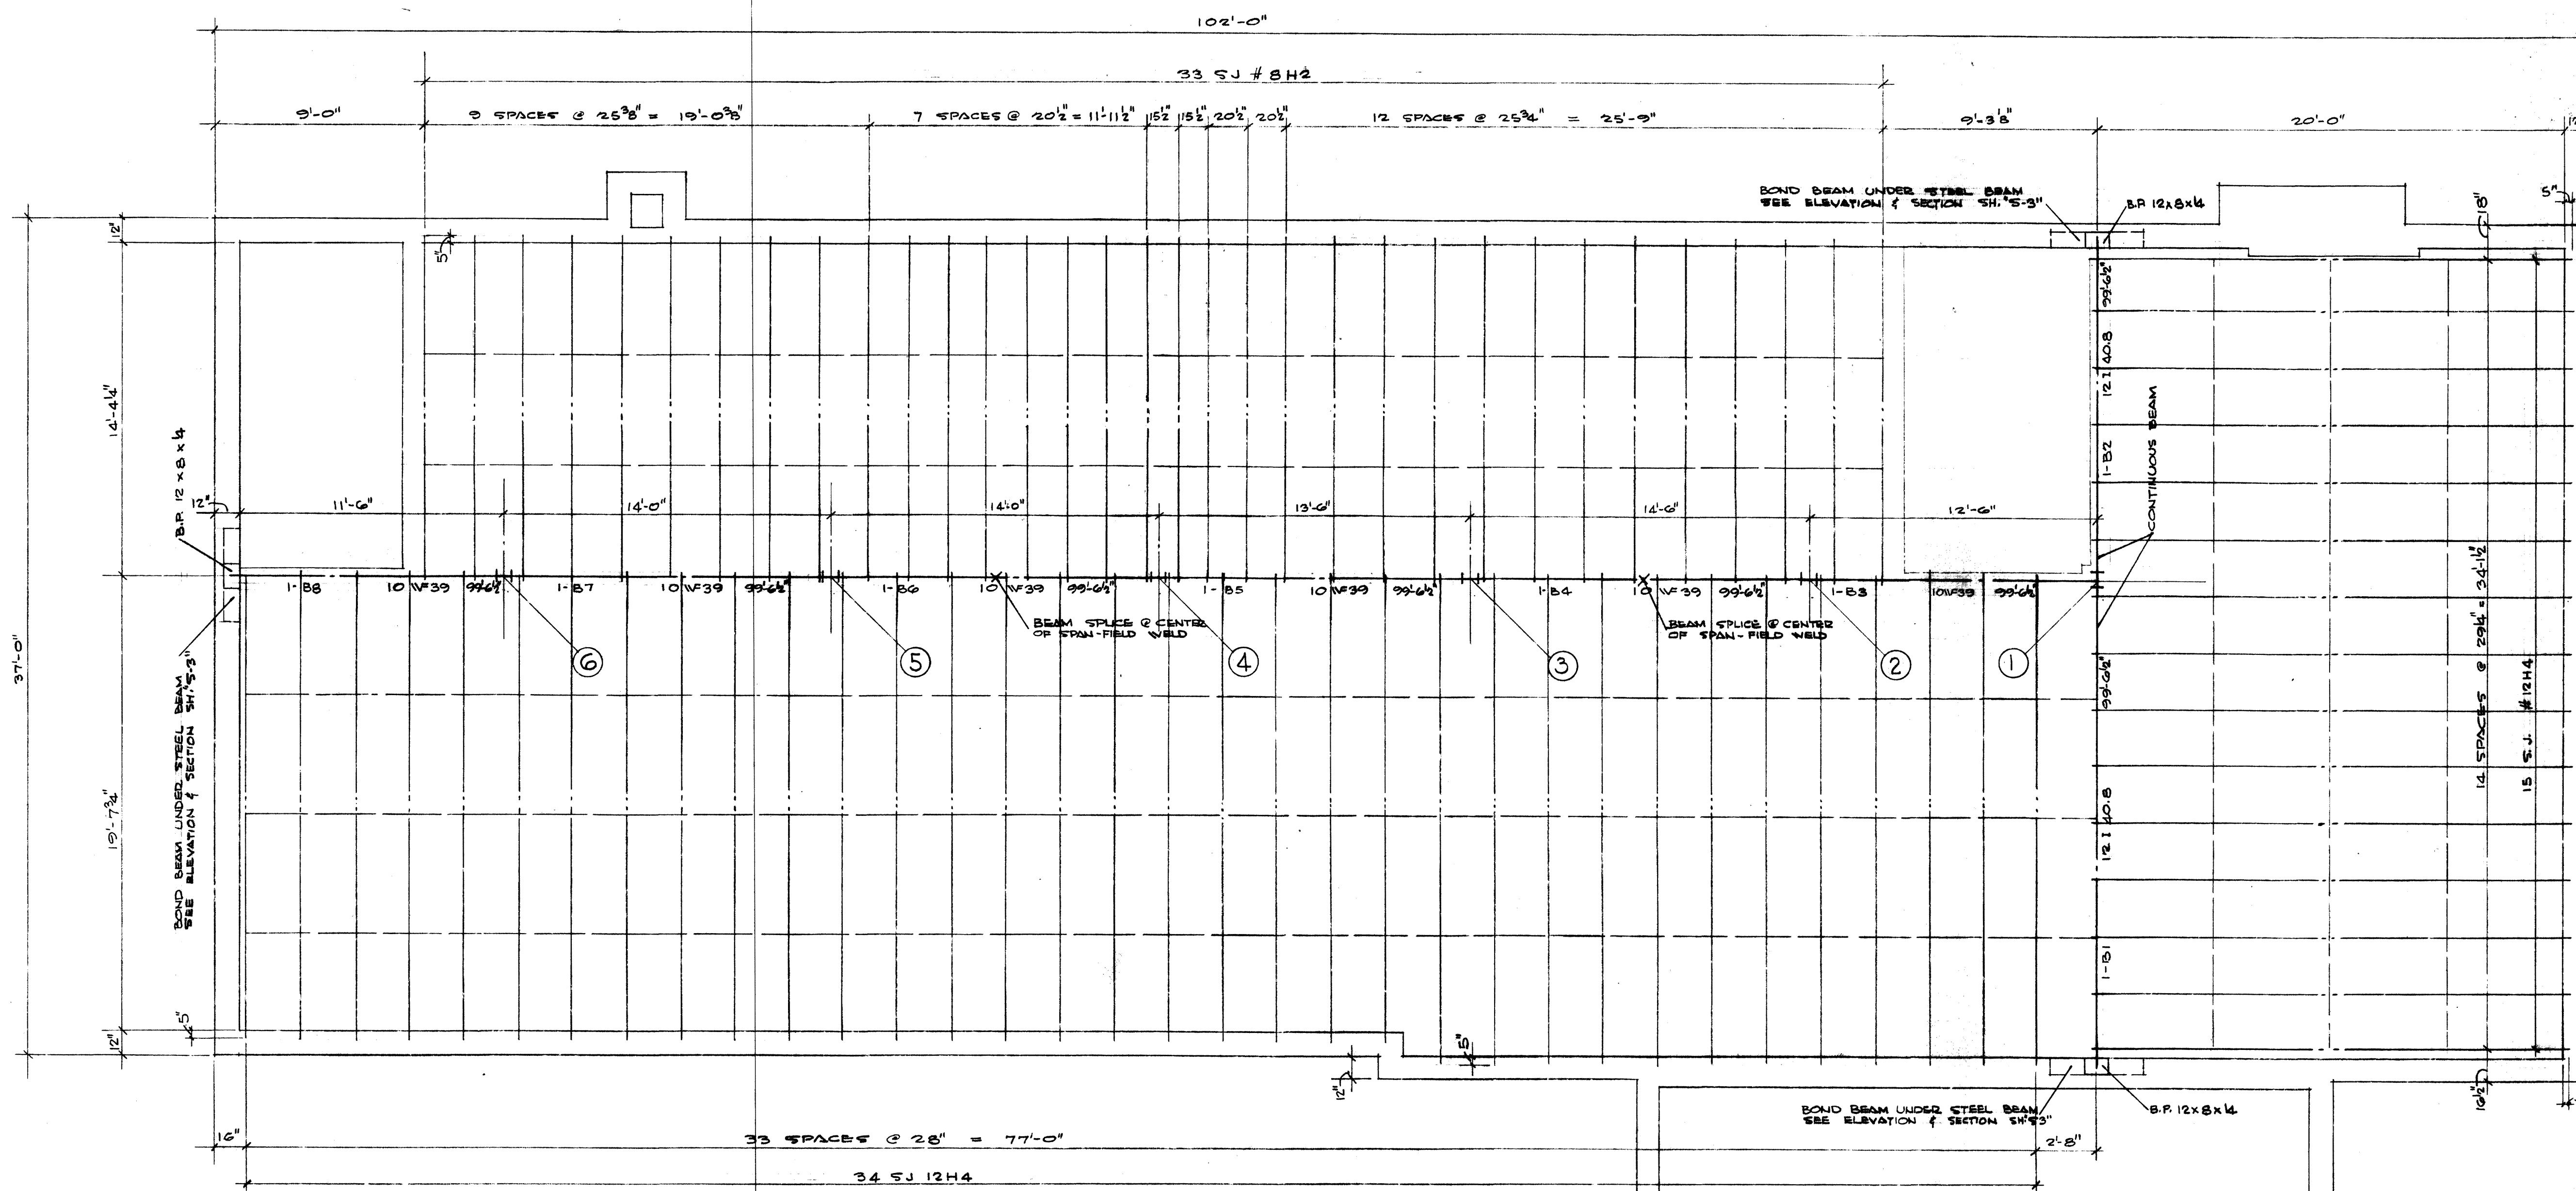


- NOTES:
- 1- ALL BRIDGING FOR JOISTS SHALL BE 5/8" φ RODS SPACED AS SHOWN. EACH LINE OF BRIDGING CONSISTS OF 2 RODS, 1 @ BOTTOM OF TOP CHORD AND 1 @ TOP OF BOTTOM CHORD.
 - 2- ALL JOISTS SHALL HAVE MINIMUM BEARING OF 5" ON MASONRY AND 4" ON STEEL BEAMS.

FIRST FLOOR FRAMING PLAN

1/4" = 1'-0"


DETAIL OF COL. No 1
FOOTING SIMILAR AS TYPICAL FOOTING
DETAILED ON SHEET 5-1
FOOTING SIZE IS 3'-0" x 5'-0" x 1'-6"
REINFORCED W/ 10 # 4 BARS E-W.

DELTA GAMMA SORORITY HOUSE UNIVERSITY OF KENTUCKY LEXINGTON KENTUCKY			
DRAWN BY P.E.	STRUCTURAL	DATE 1-8-53	
TRACED BY L.T.	GILLIG • CHRISMAN & MILLER	SCALE AS SHOWN	
CHECKED BY P.E. N.C.	ARCHITECTS ASSOCIATED 180 WALNUT STREET LEXINGTON, KENTUCKY	SPEC. NO.	
REVISIONS	COMMONWEALTH OF KENTUCKY DEPARTMENT OF FINANCE ENGINEERING STAFF FRANKFORT KENTUCKY	DRAWING NO. 52	
APPROVED BY <i>Frank Eades</i>	AGENT HEAD	DATE 1-22-53	
APPROVED BY <i>Donald H. Patch</i>	CHIEF OF STAFF	DATE	

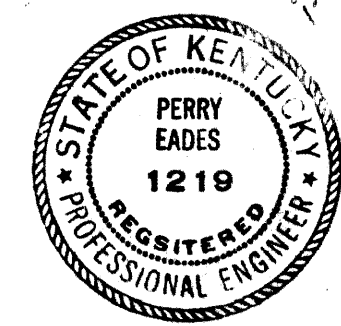


U-1896

008100
121 C-2

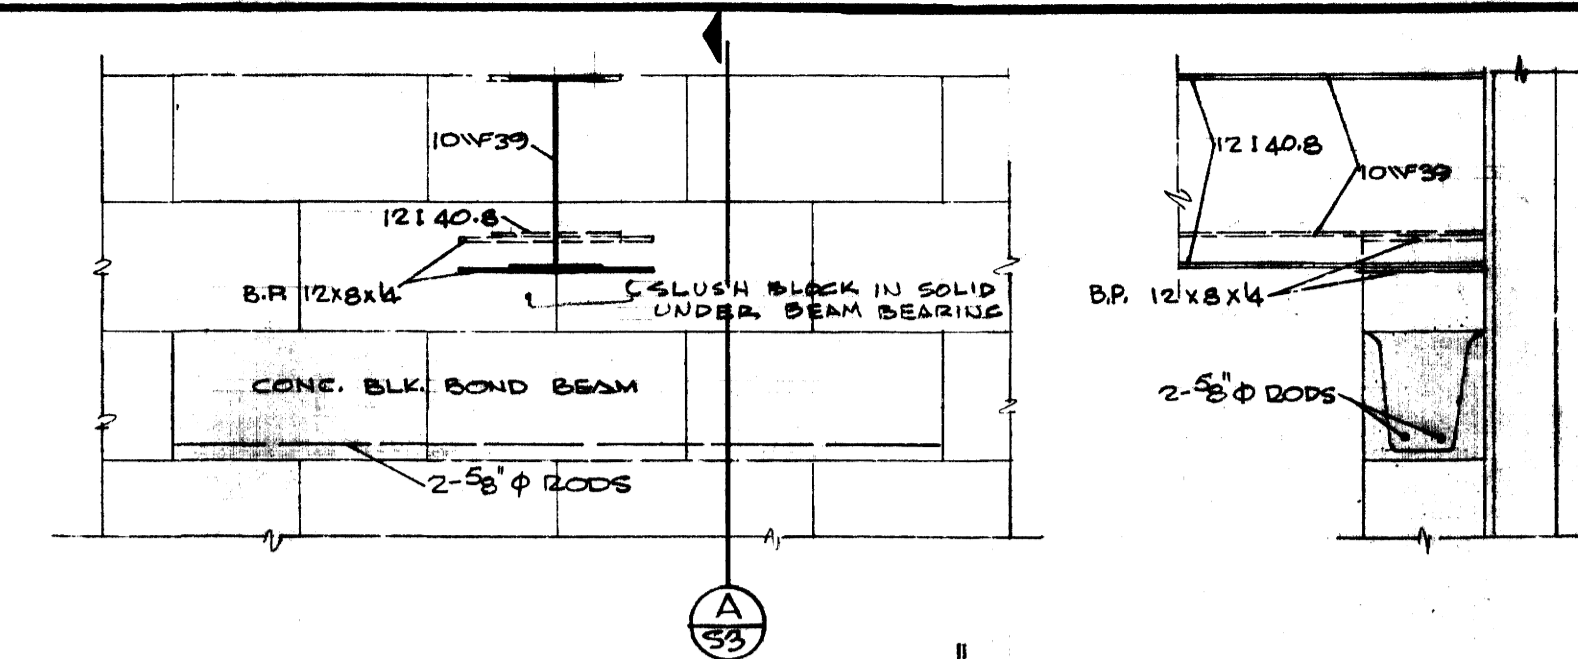

ELEVATION OF BOND BEAM UNDER STEEL BEAMS SECTION A

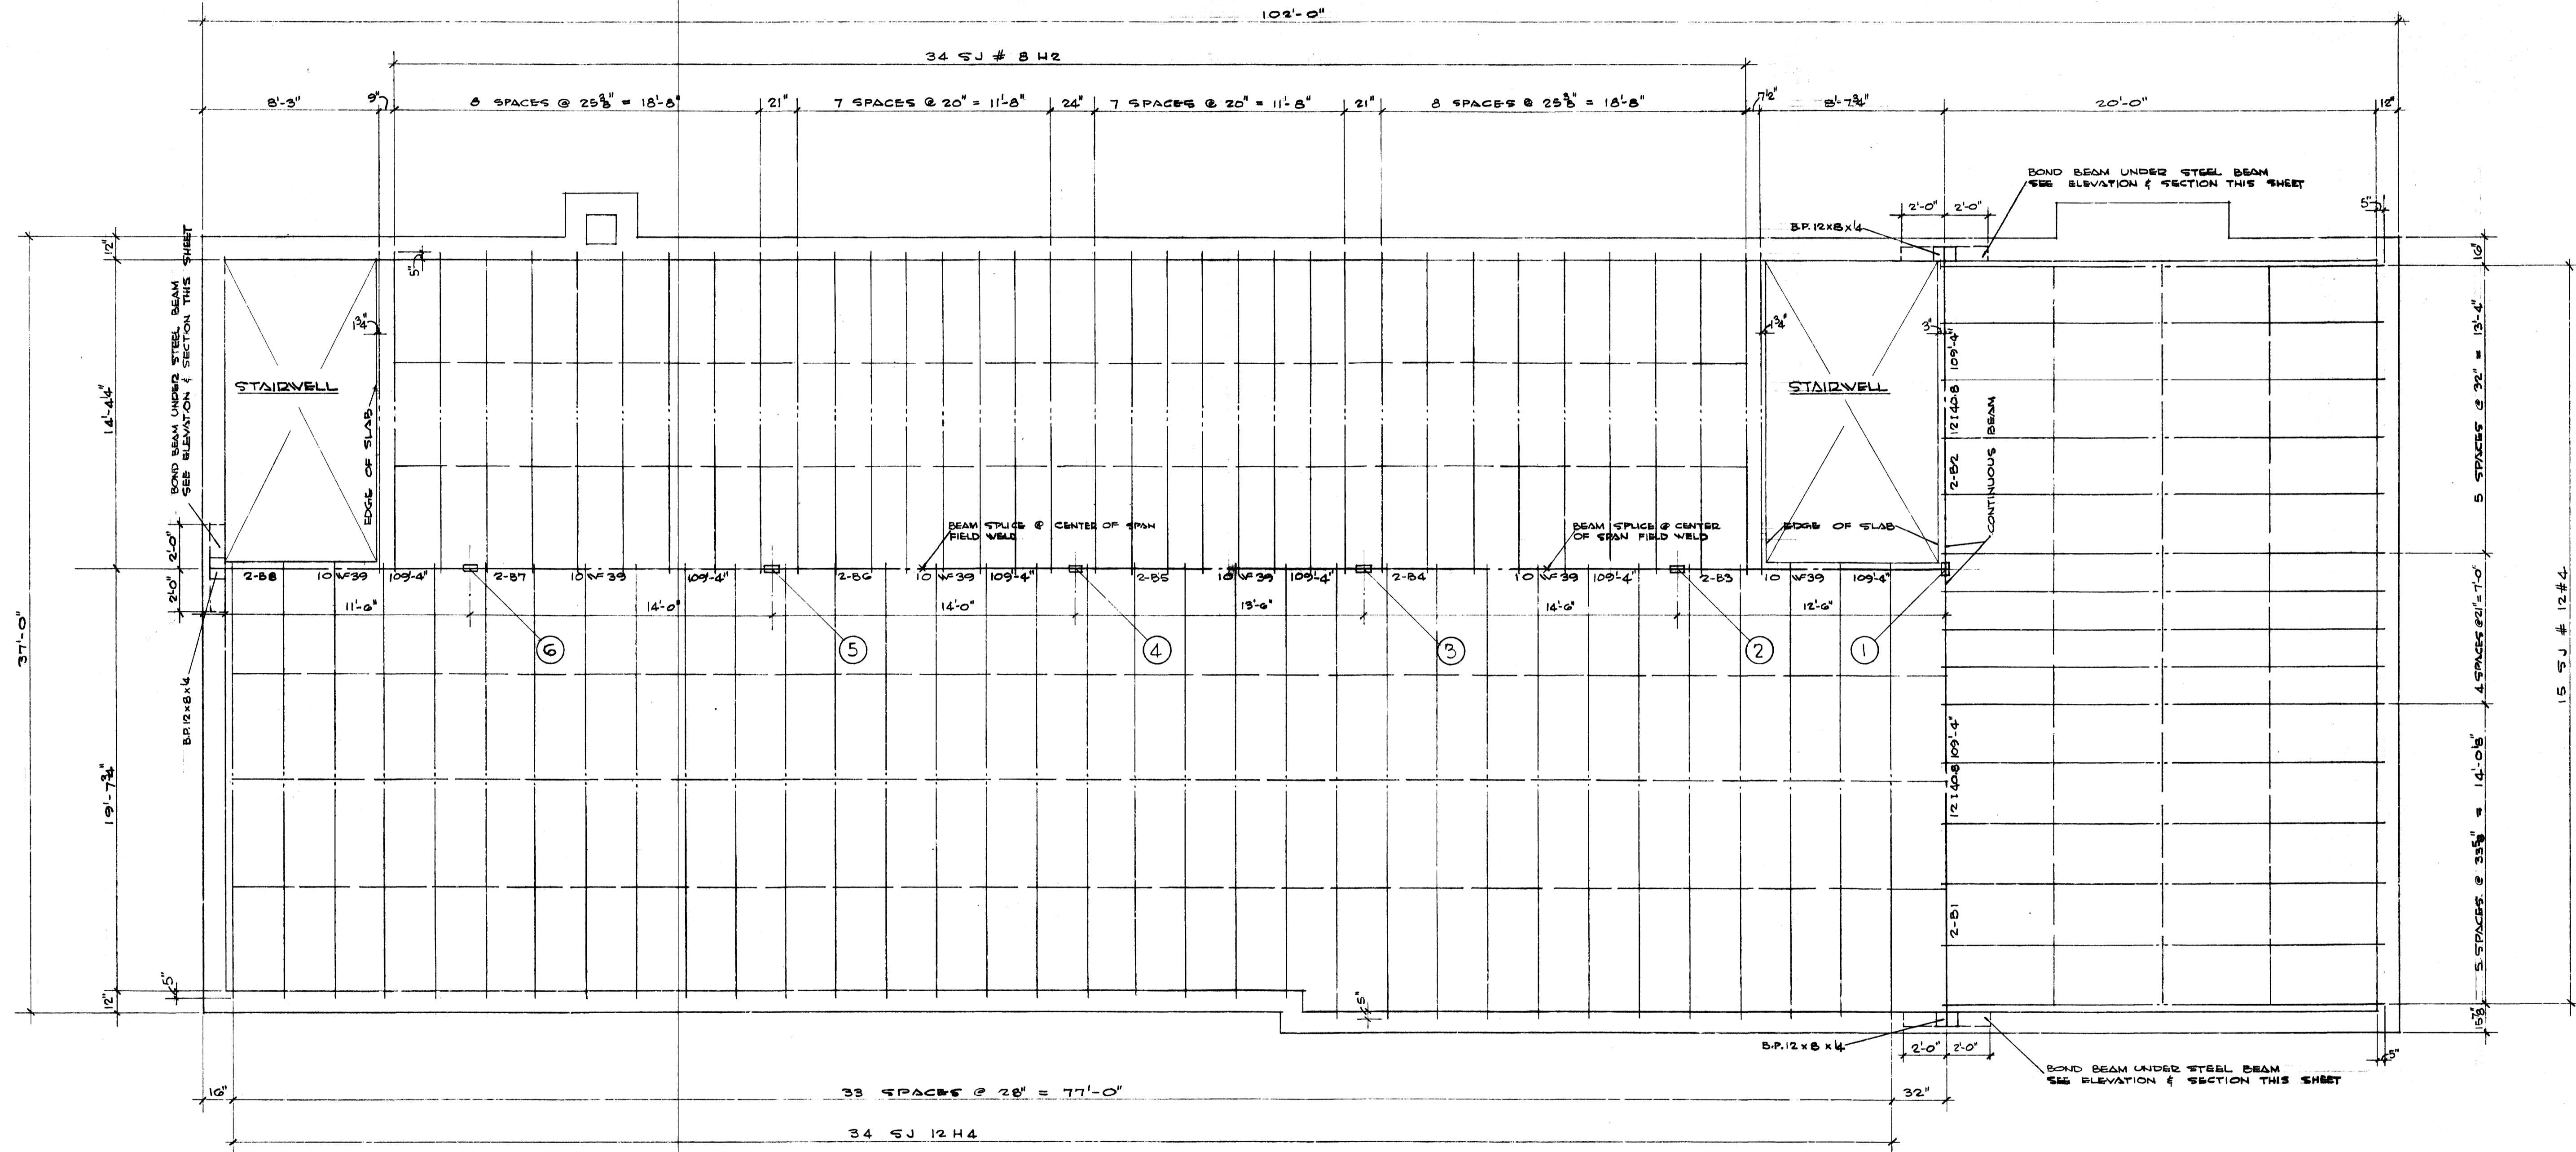



- NOTES:
1. ALL BRIDGING FOR JOISTS SHALL BE $\frac{5}{8}$ " ϕ RODS SPACED AS SHOWN. EACH LINE OF BRIDGING CONSISTS OF 2 RODS, 1 @ BOTTOM OF TOP CHORD AND 1 @ TOP OF BOTTOM CHORD.
 2. ALL JOISTS SHALL HAVE MINIMUM BEARING OF 5" ON MASONRY AND 4" ON STEEL BEAMS.

SECOND FLOOR FRAMING PLAN

DELTA GAMMA SORORITY HOUSE UNIVERSITY OF KENTUCKY LEXINGTON KENTUCKY		
DRAWN BY PE STRUCTURAL	DATE 1-8-63	SCALE AS SHOWN
CHECKED BY P.E. J.E. GILIG • CHRISMAN & MILLER ARCHITECTS ASSOCIATED 180 WALNUT STREET LEXINGTON, KENTUCKY	SPEC. NO.	DRAWING NO. 53
REVISIONS COMMONWEALTH OF KENTUCKY DEPARTMENT OF FINANCE ENGINEERING STAFF FRANKFORT KENTUCKY		
APPROVED BY <i>[Signature]</i> PERRY EADES 1219 REGISTERED PROFESSIONAL ENGINEER	DATE 1-25-63	APPROVED BY <i>[Signature]</i> CHIEF OF STAFF




U-1897

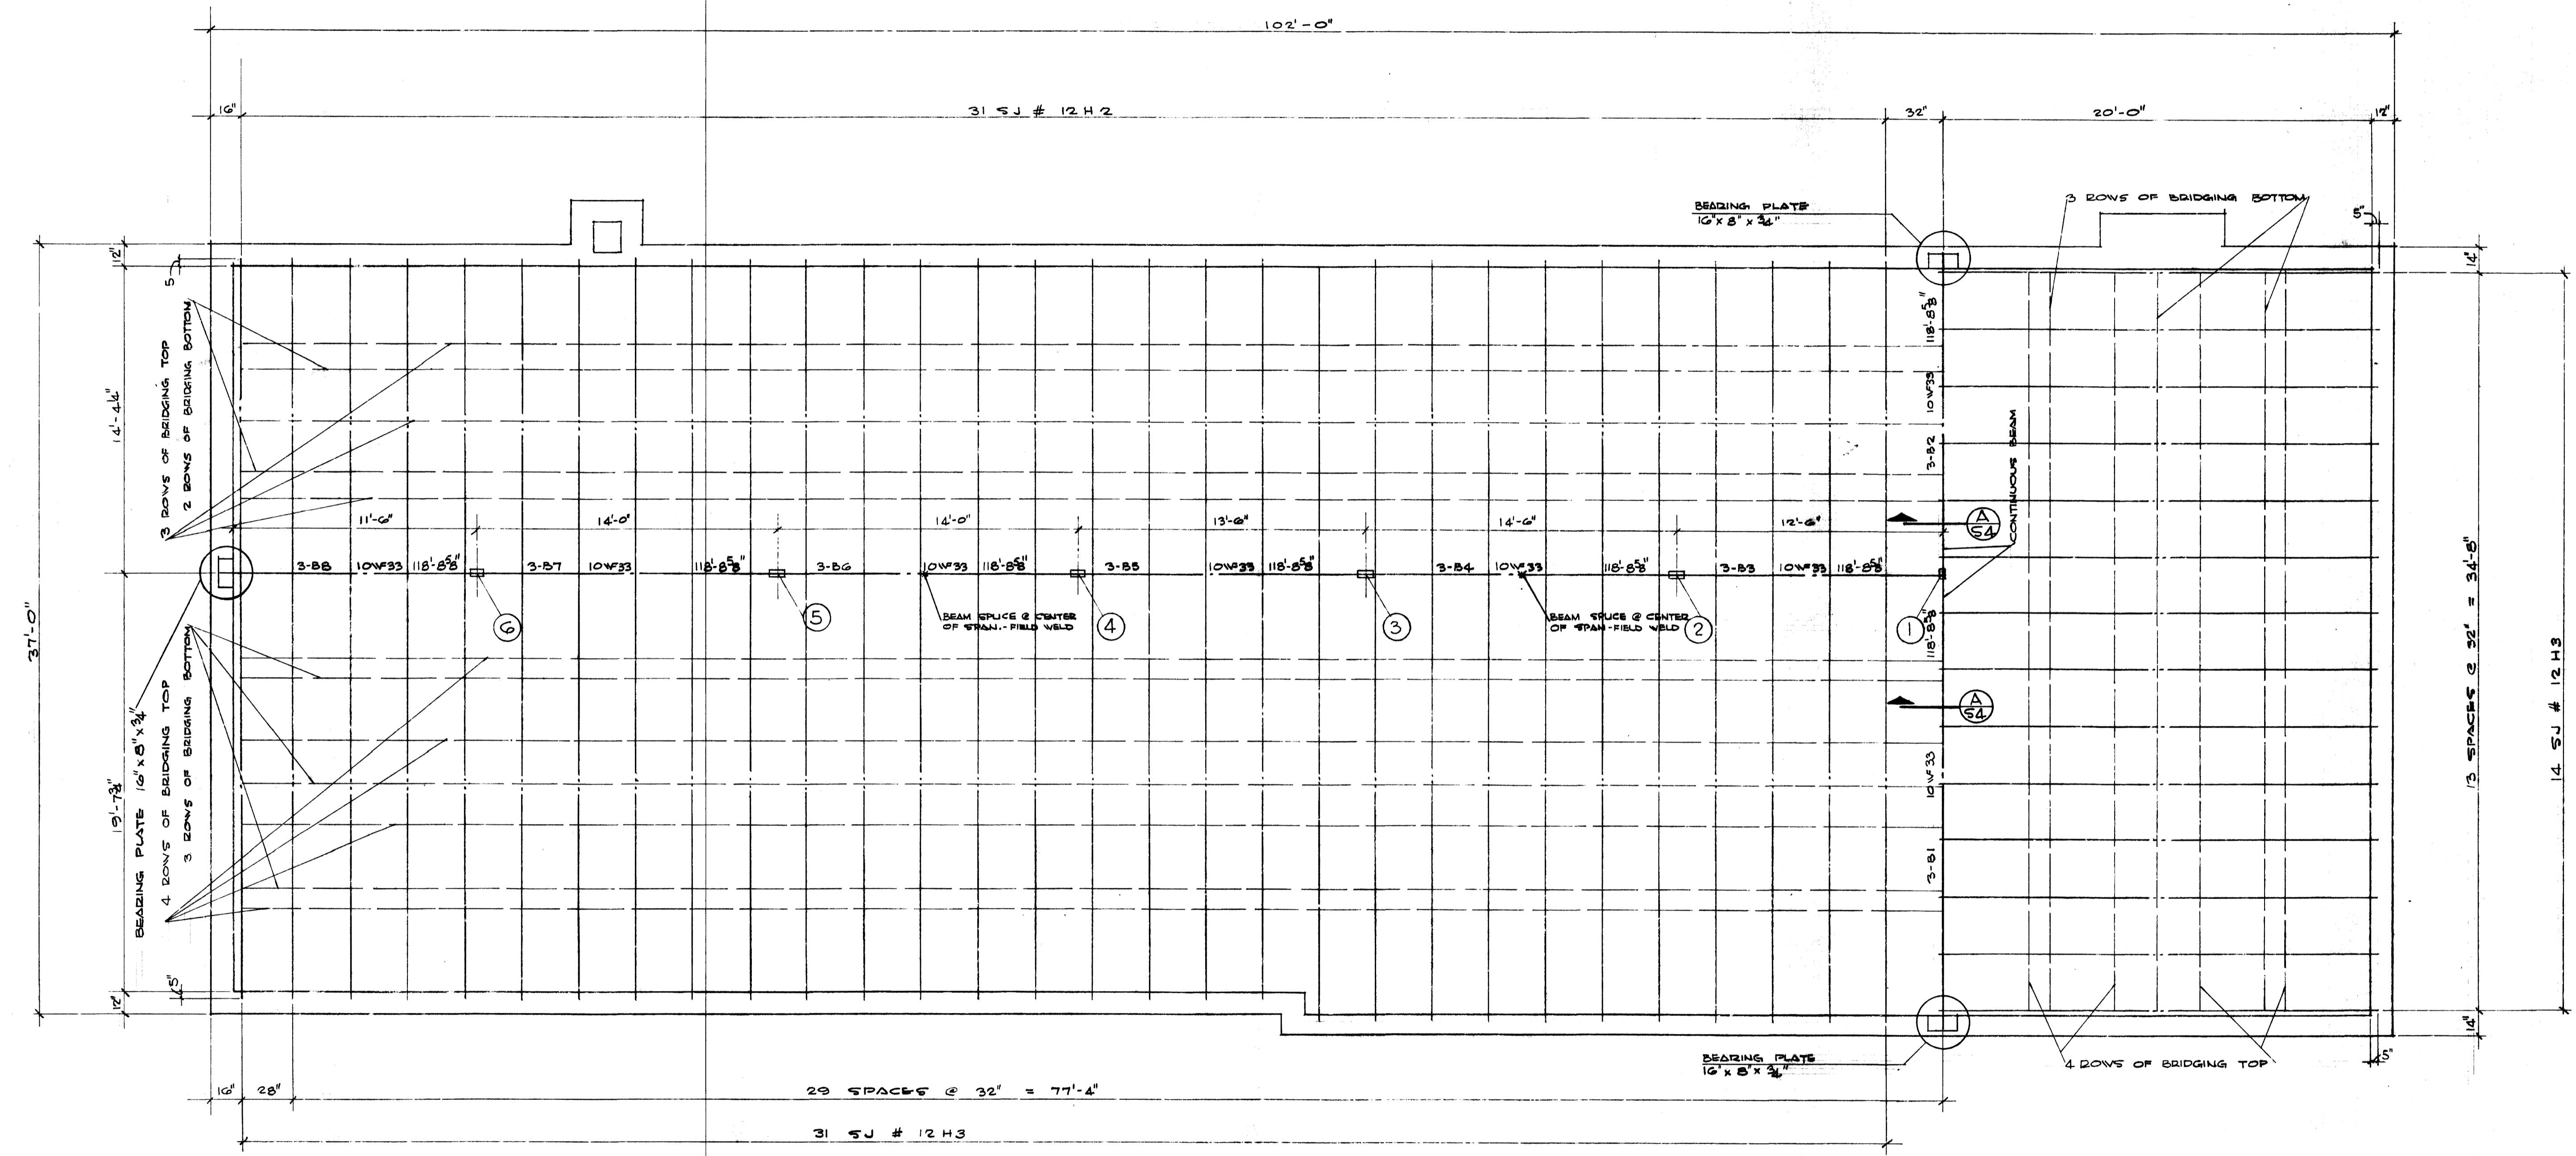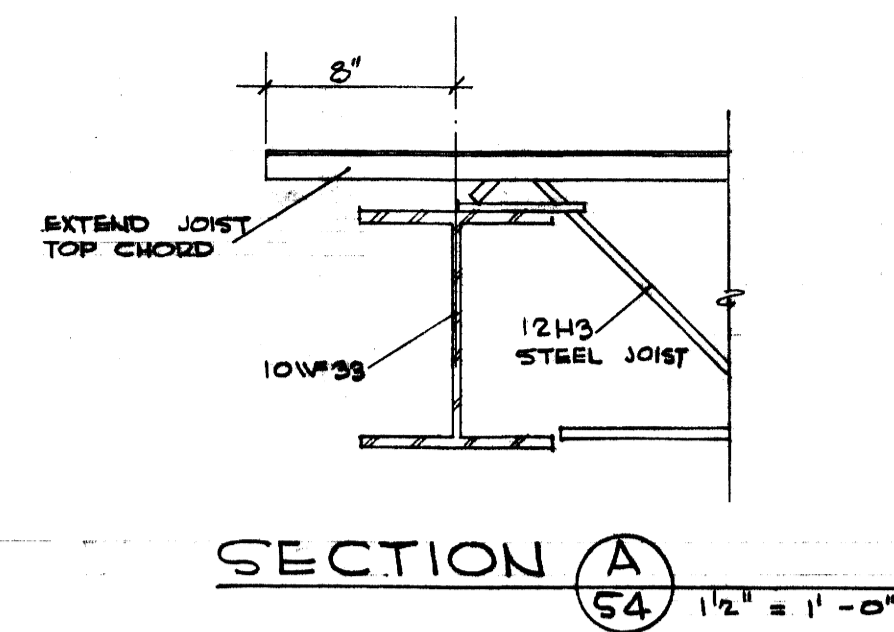

- NOTES:
1. ALL BRIDGING FOR JOISTS SHALL BE 5/8" Ø RODS SPACED AS SHOWN. TOP ROW OF BRIDGING SHALL BE WELDED TO BOTTOM OF TOP CHORD, BOTTOM ROW OF BRIDGING SHALL BE WELDED TO TOP OF BOTTOM CHORD.
 2. ALL JOISTS SHALL HAVE MINIMUM BEARING OF 5" ON MASONRY AND 4" ON STEEL BEAMS.

ROOF FRAMING PLAN

1/2" = 1'-0"

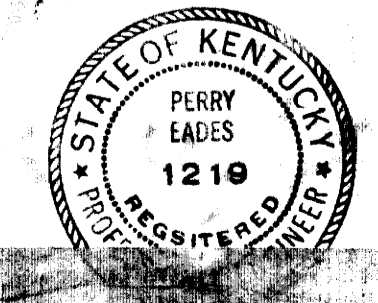

DELTA GAMMA SORORITY HOUSE UNIVERSITY OF KENTUCKY LEXINGTON KENTUCKY		
DRAWN BY PE	STRUCTURAL	DATE 1-8-63
TRACED BY LT	GILLIG • CHRISMAN & MILLER	SCALE AS SHOWN
CHECKED BY PE, INC.	ARCHITECTS ASSOCIATED 180 WALNUT STREET, LEXINGTON, KENTUCKY	SPEC. NO.
REVISIONS	COMMONWEALTH OF KENTUCKY DEPARTMENT OF FINANCE ENGINEERING STAFF FRANKFORT, KENTUCKY	DRAWING NO. 54
APPROVED BY <i>Frank Eades</i>	DATE 1-25-63	121 C-2
BY <i>David H. Patten</i>	DATE	121 C-2

V-1898

008102

COMMONWEALTH OF KENTUCKY

DEPARTMENT OF FINANCE ENGINEERING STAFF

DELTA GAMMA SORORITY HOUSE UNIVERSITY OF KENTUCKY


GILLIG · CHRISMAN AND MILLER	ARCHITECTS ASSOCIATED
HUGH DILLEHAY & ASSOCIATES	CONSULTING ENGINEERS
PERRY EADES	STRUCTURAL ENGINEER

FEBRUARY 1963

H.H.F.A. PROJECT NO. KY-15-CH-70(D)


MECHANICAL & ELECTRICAL



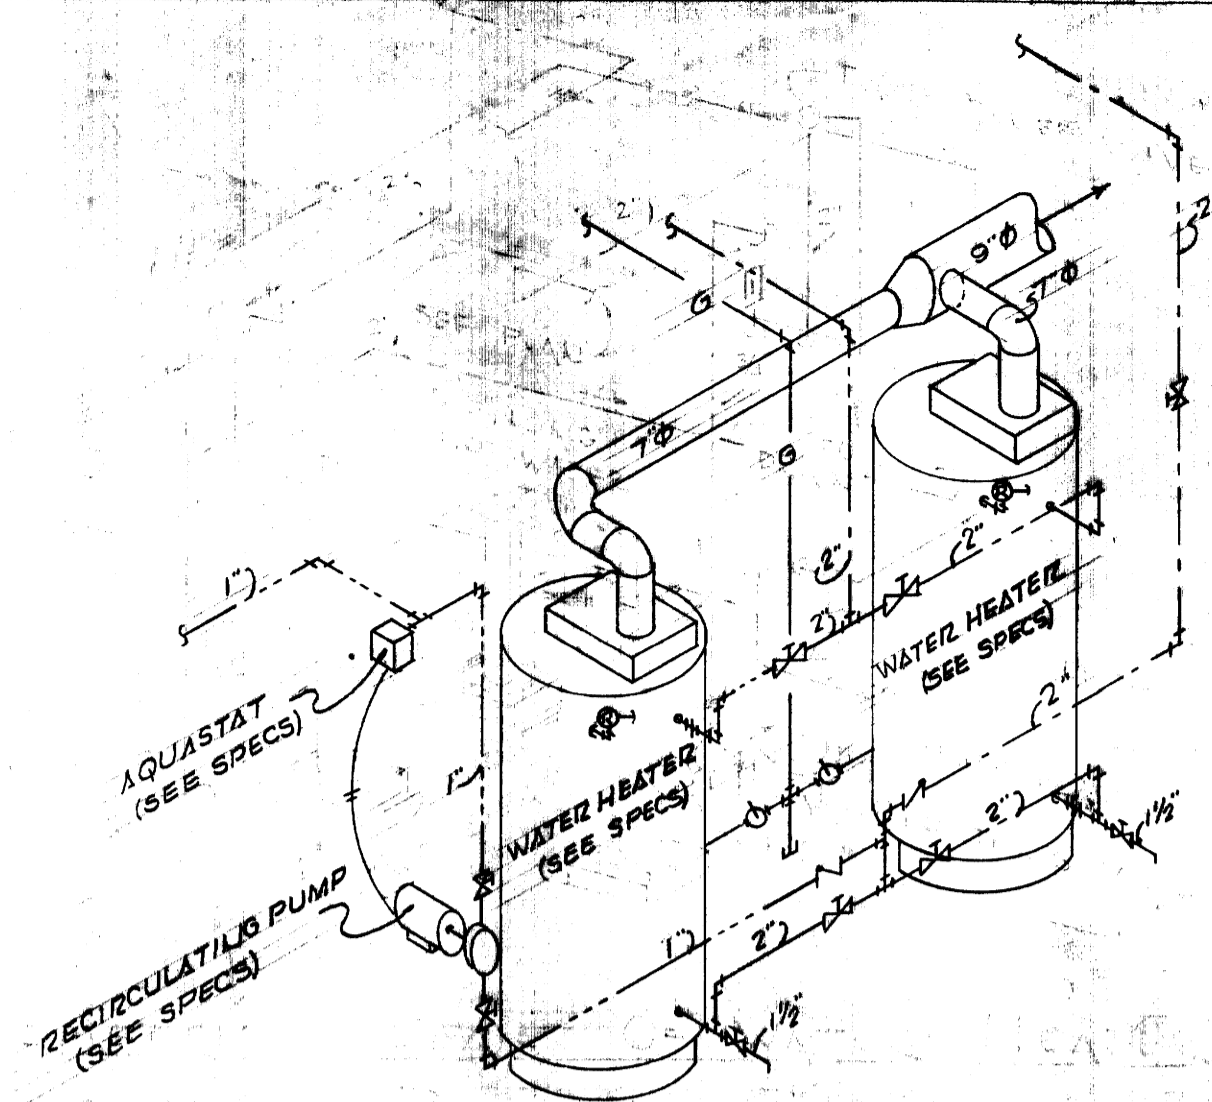


WATER HEATER PIPING DETAIL - 1/8" SCALE

PLUMBING LEGEND	
---	SOIL OR WASTE LINE
---	VENT LINE
---	COLD WATER LINE
---	HOT WATER LINE
---	HOT WATER RECIRCULATION
⊗	GATE VALVE
⊙	GLOBE VALVE
⊘	CHECK VALVE
⊕	UNION
⊖	H.B. HOSE BIBB
⊗	W.H. WALL HYDRANT
⊘	V.T.R. VENT THRU ROOF
⊕	B.T.W. BRACKET TO WALL
⊖	THERMOMETER
⊗	BALANCING VALVE
⊘	GAS VALVE
⊕	RELIEF VALVE


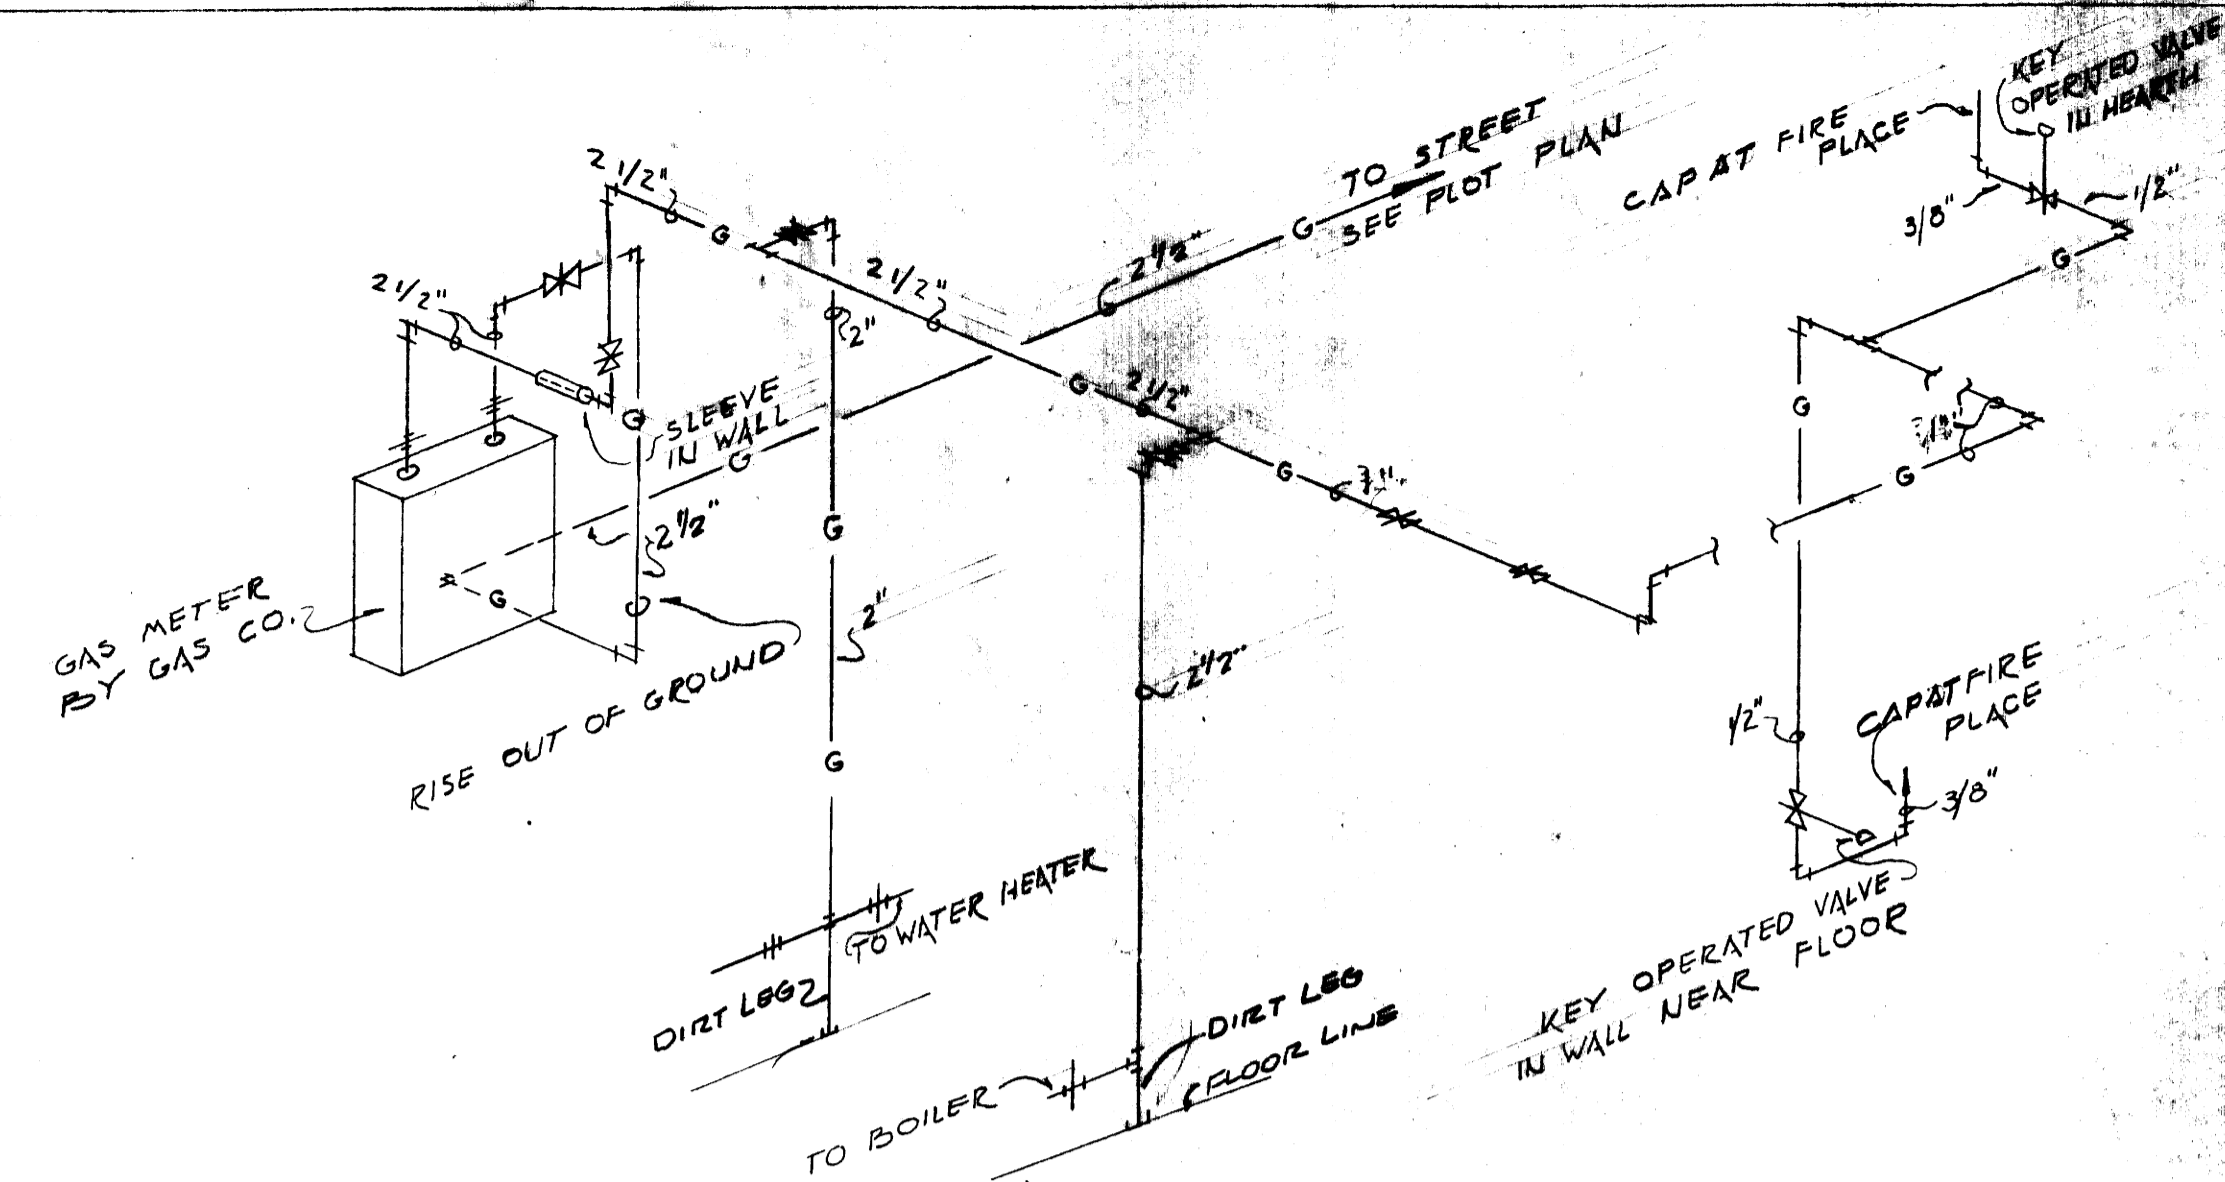


SCHEMATIC OF GAS PIPING
1/8" SCALE

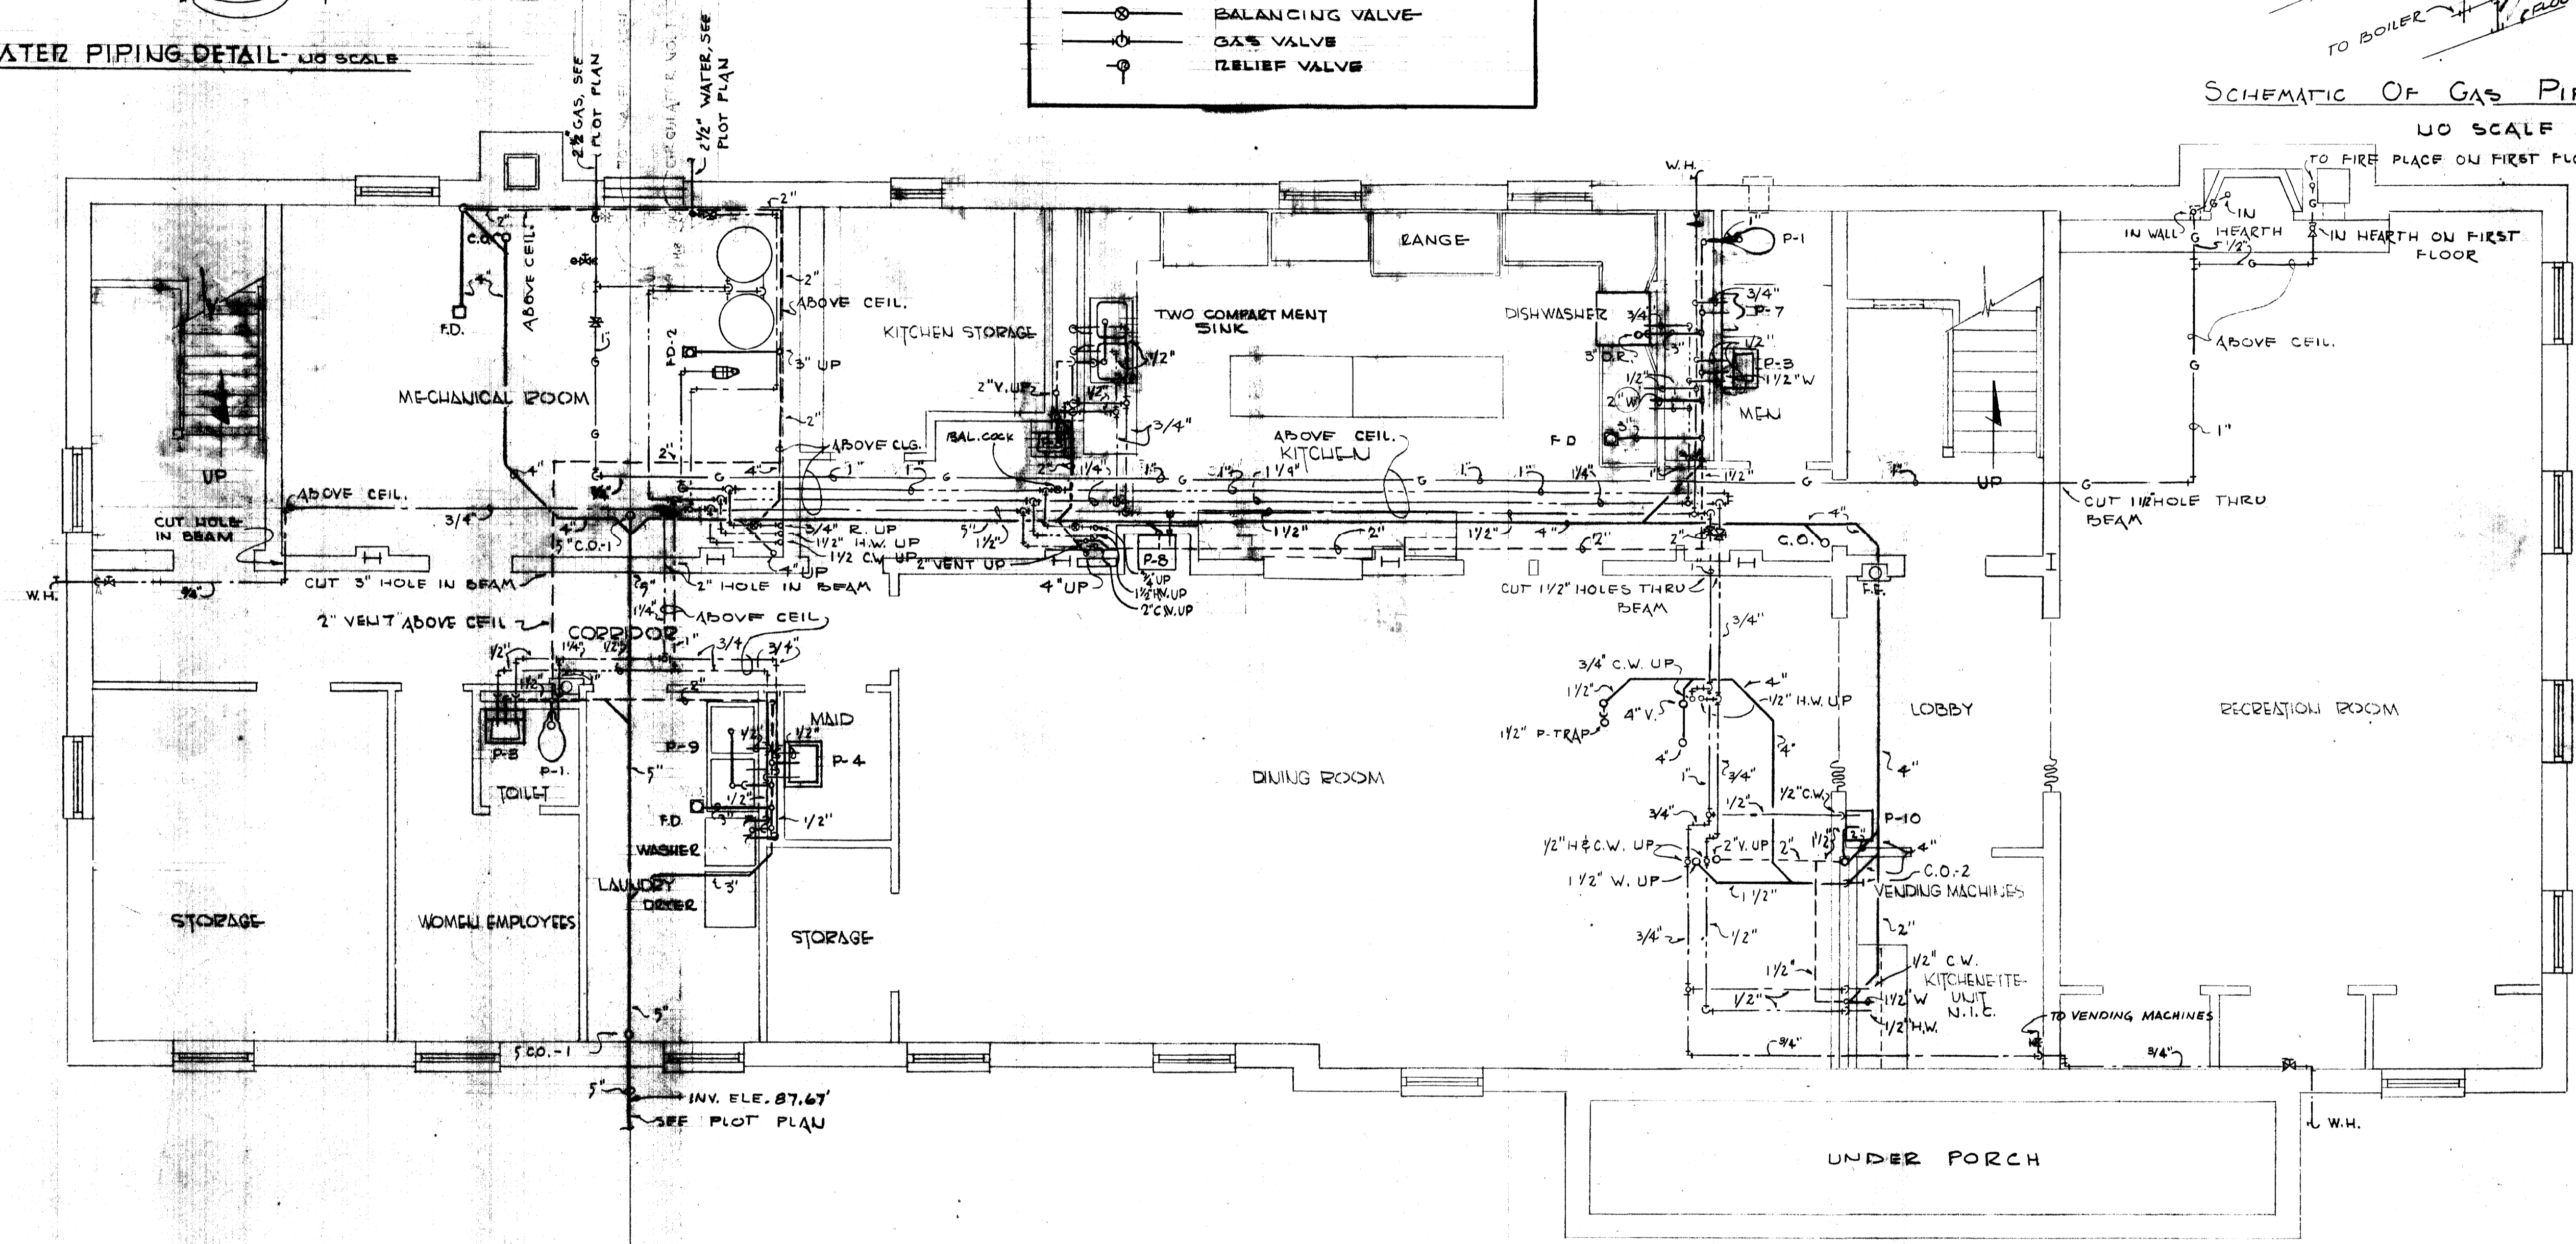

BASEMENT PLUMBING PLAN



SCALE: 1/4"=1'-0"

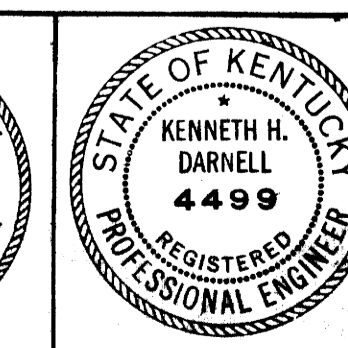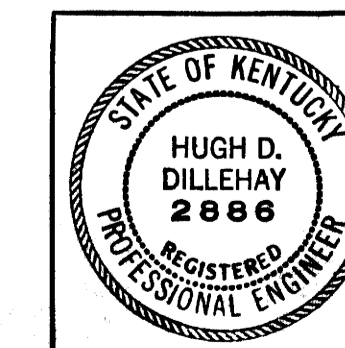


HUGH DILLEHAY AND ASSOCIATES
CONSULTING ENGINEERS
LEXINGTON JOB NO. 6226 KENTUCKY

DELTA GAMMA SORORITY HOUSE UNIVERSITY OF KENTUCKY LEXINGTON KENTUCKY		
DRAWN BY R.L.K.	BASEMENT PLUMBING	DATE 1-8-68
TRACED BY I.C.H.	GILLIG • CHRISMAN & MILLER ARCHITECTS ASSOCIATED	SCALE AS NOTED
CHECKED BY H.D.D.	180 WALNUT STREET LEXINGTON, KENTUCKY	SPEC. NO.
REVISIONS	COMMONWEALTH OF KENTUCKY DEPARTMENT OF FINANCE ENGINEERING STAFF FRANKFORT KENTUCKY	DRAWING NO. 1-23-68
APPROVED BY <i>[Signature]</i> AGENCY HEAD		DATE
APPROVED BY <i>[Signature]</i> DATE		

U-1899

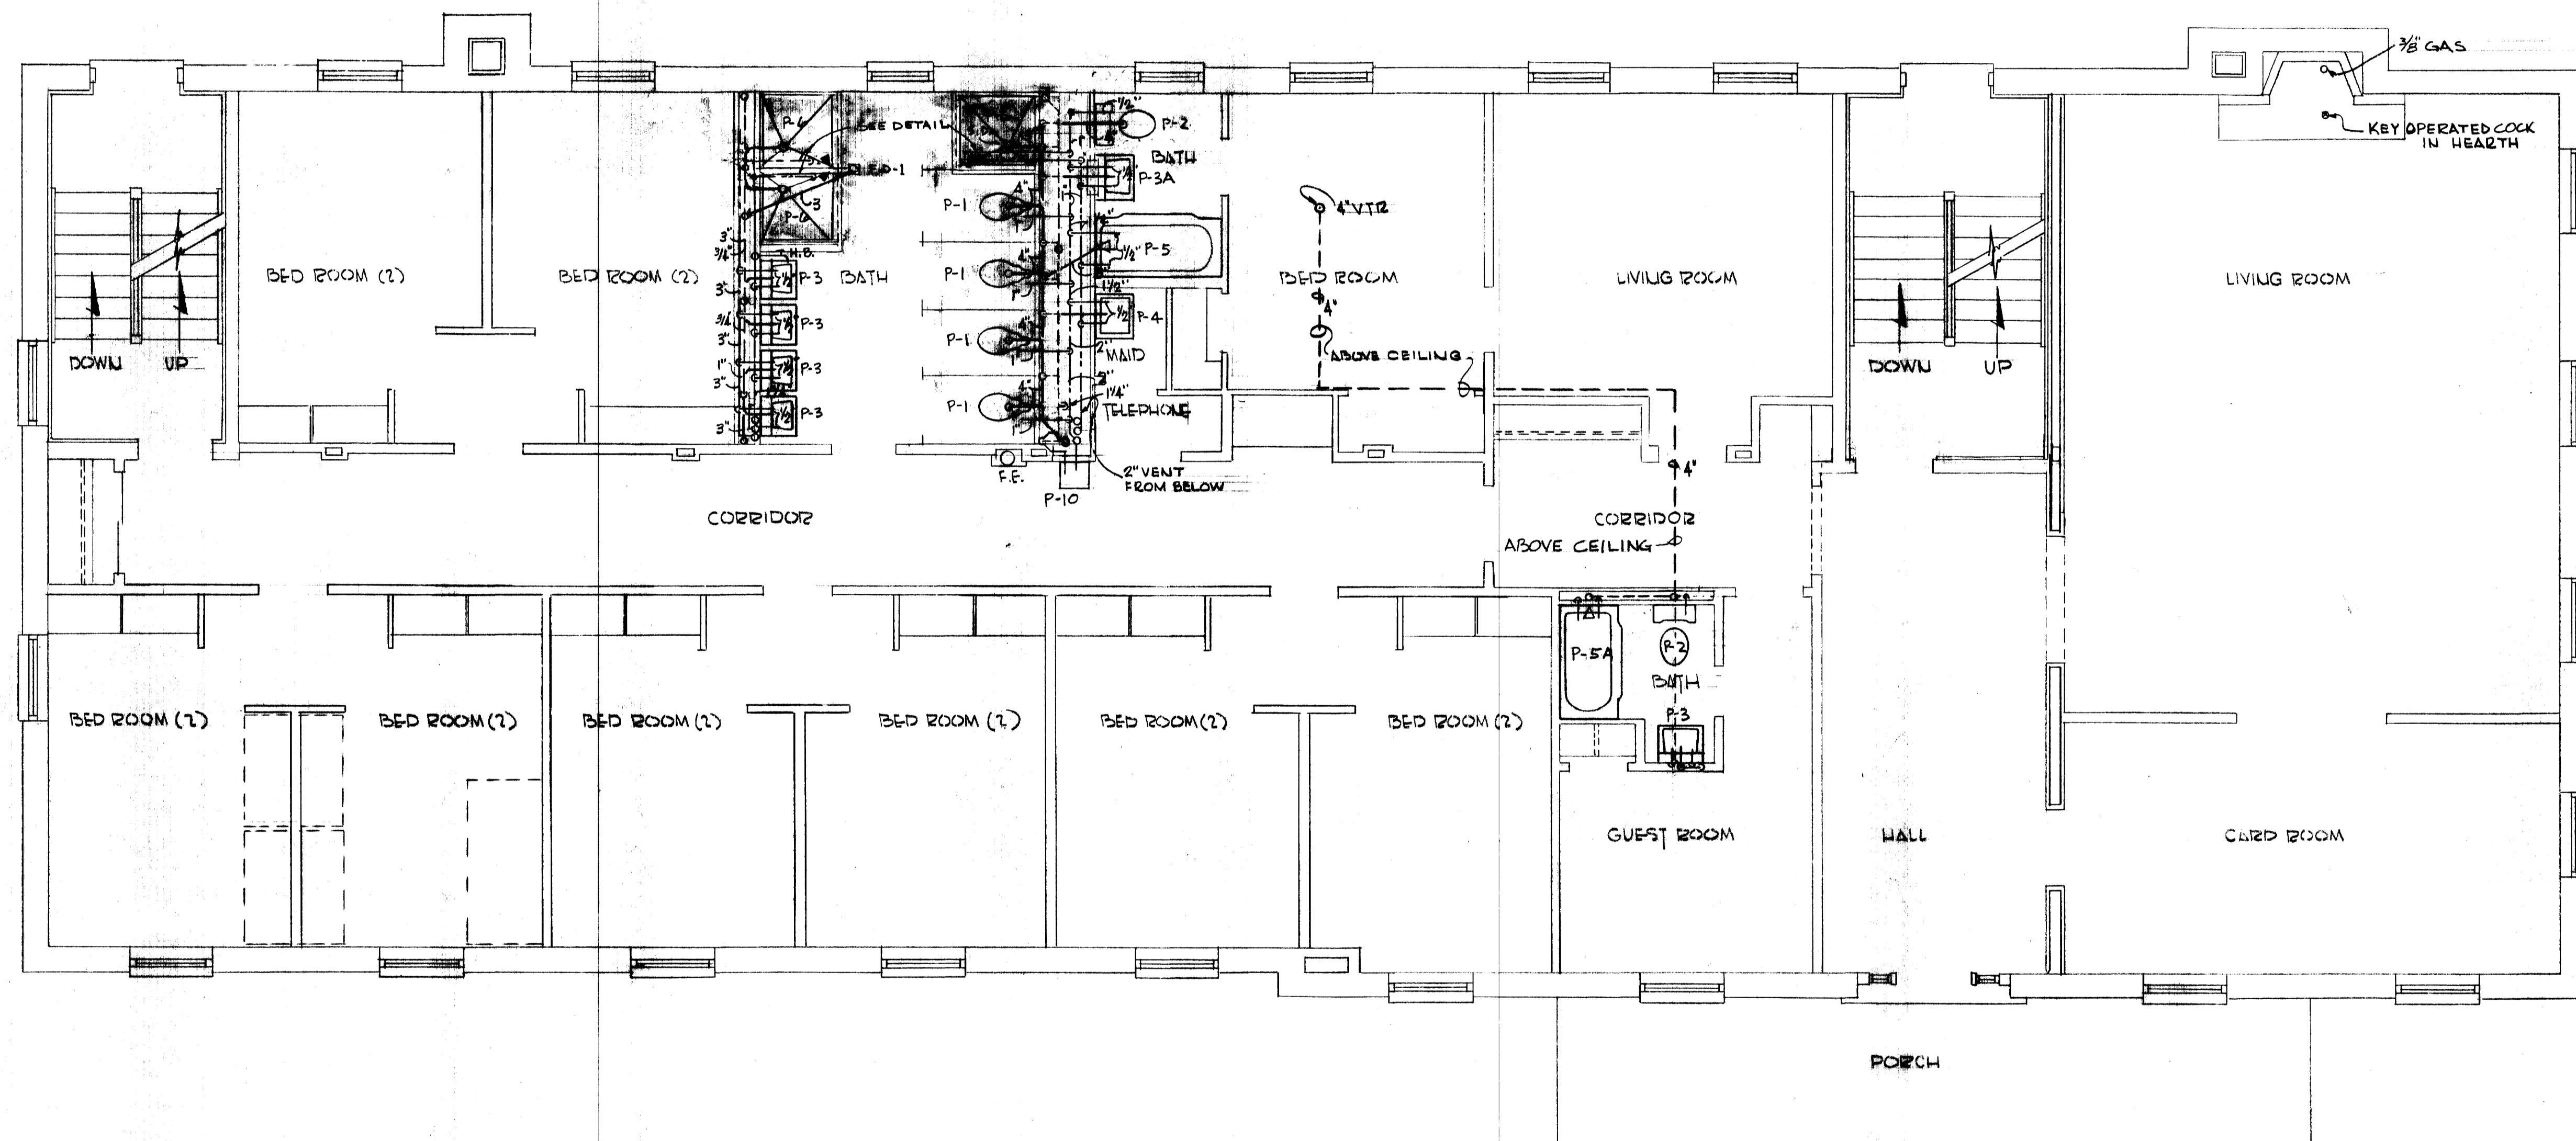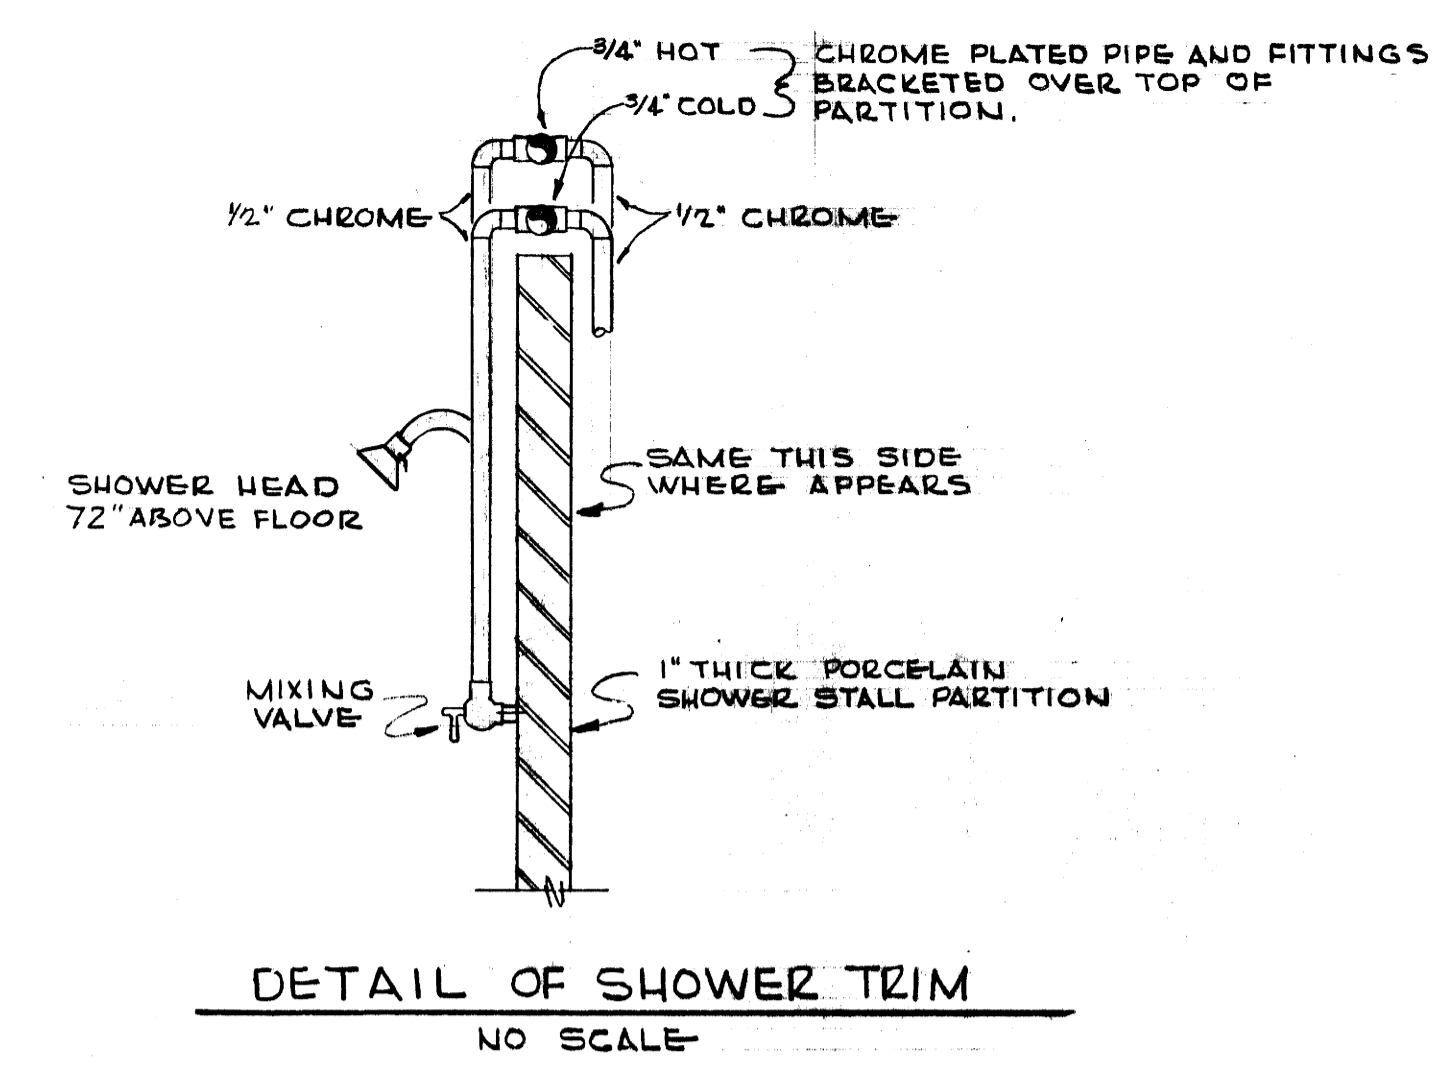

FIRST FLOOR PLUMBING PLAN
SCALE: 1/4" = 1'-0"

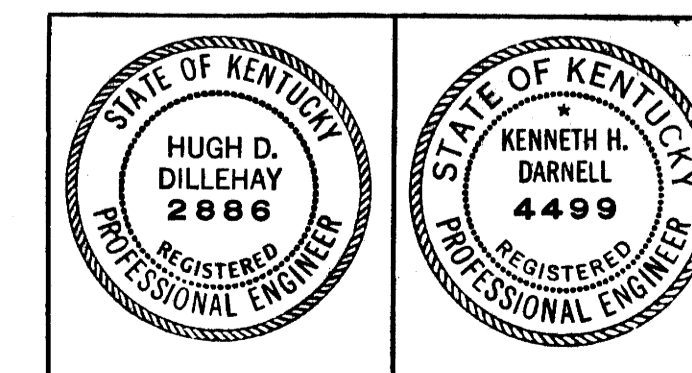


HUGH DILLEHAY AND ASSOCIATES
CONSULTING ENGINEERS
LEXINGTON JOB NO. 6216 KENTUCKY

DELTA GAMMA SORORITY HOUSE UNIVERSITY OF KENTUCKY LEXINGTON KENTUCKY		
DRAWN BY Z.L.K.	FIRST FLOOR PLUMBING	DATE 1-18-63
TRACED BY J.V.C.	GILLIG • CHRISMAN & MILLER ARCHITECTS ASSOCIATED 180 WALNUT STREET LEXINGTON, KENTUCKY	SCALE AS SHOWN SPEC. NO.
CHECKED BY H.D.D.	COMMONWEALTH OF KENTUCKY DEPARTMENT OF FINANCE ENGINEERING STAFF FRANKFORT KENTUCKY	DRAWING NO. 132
REVISIONS	APPROVED BY <i>David H. Pitts</i> CHIEF OF STAFF	DATE 1-23-63

008105


008105

U-1900

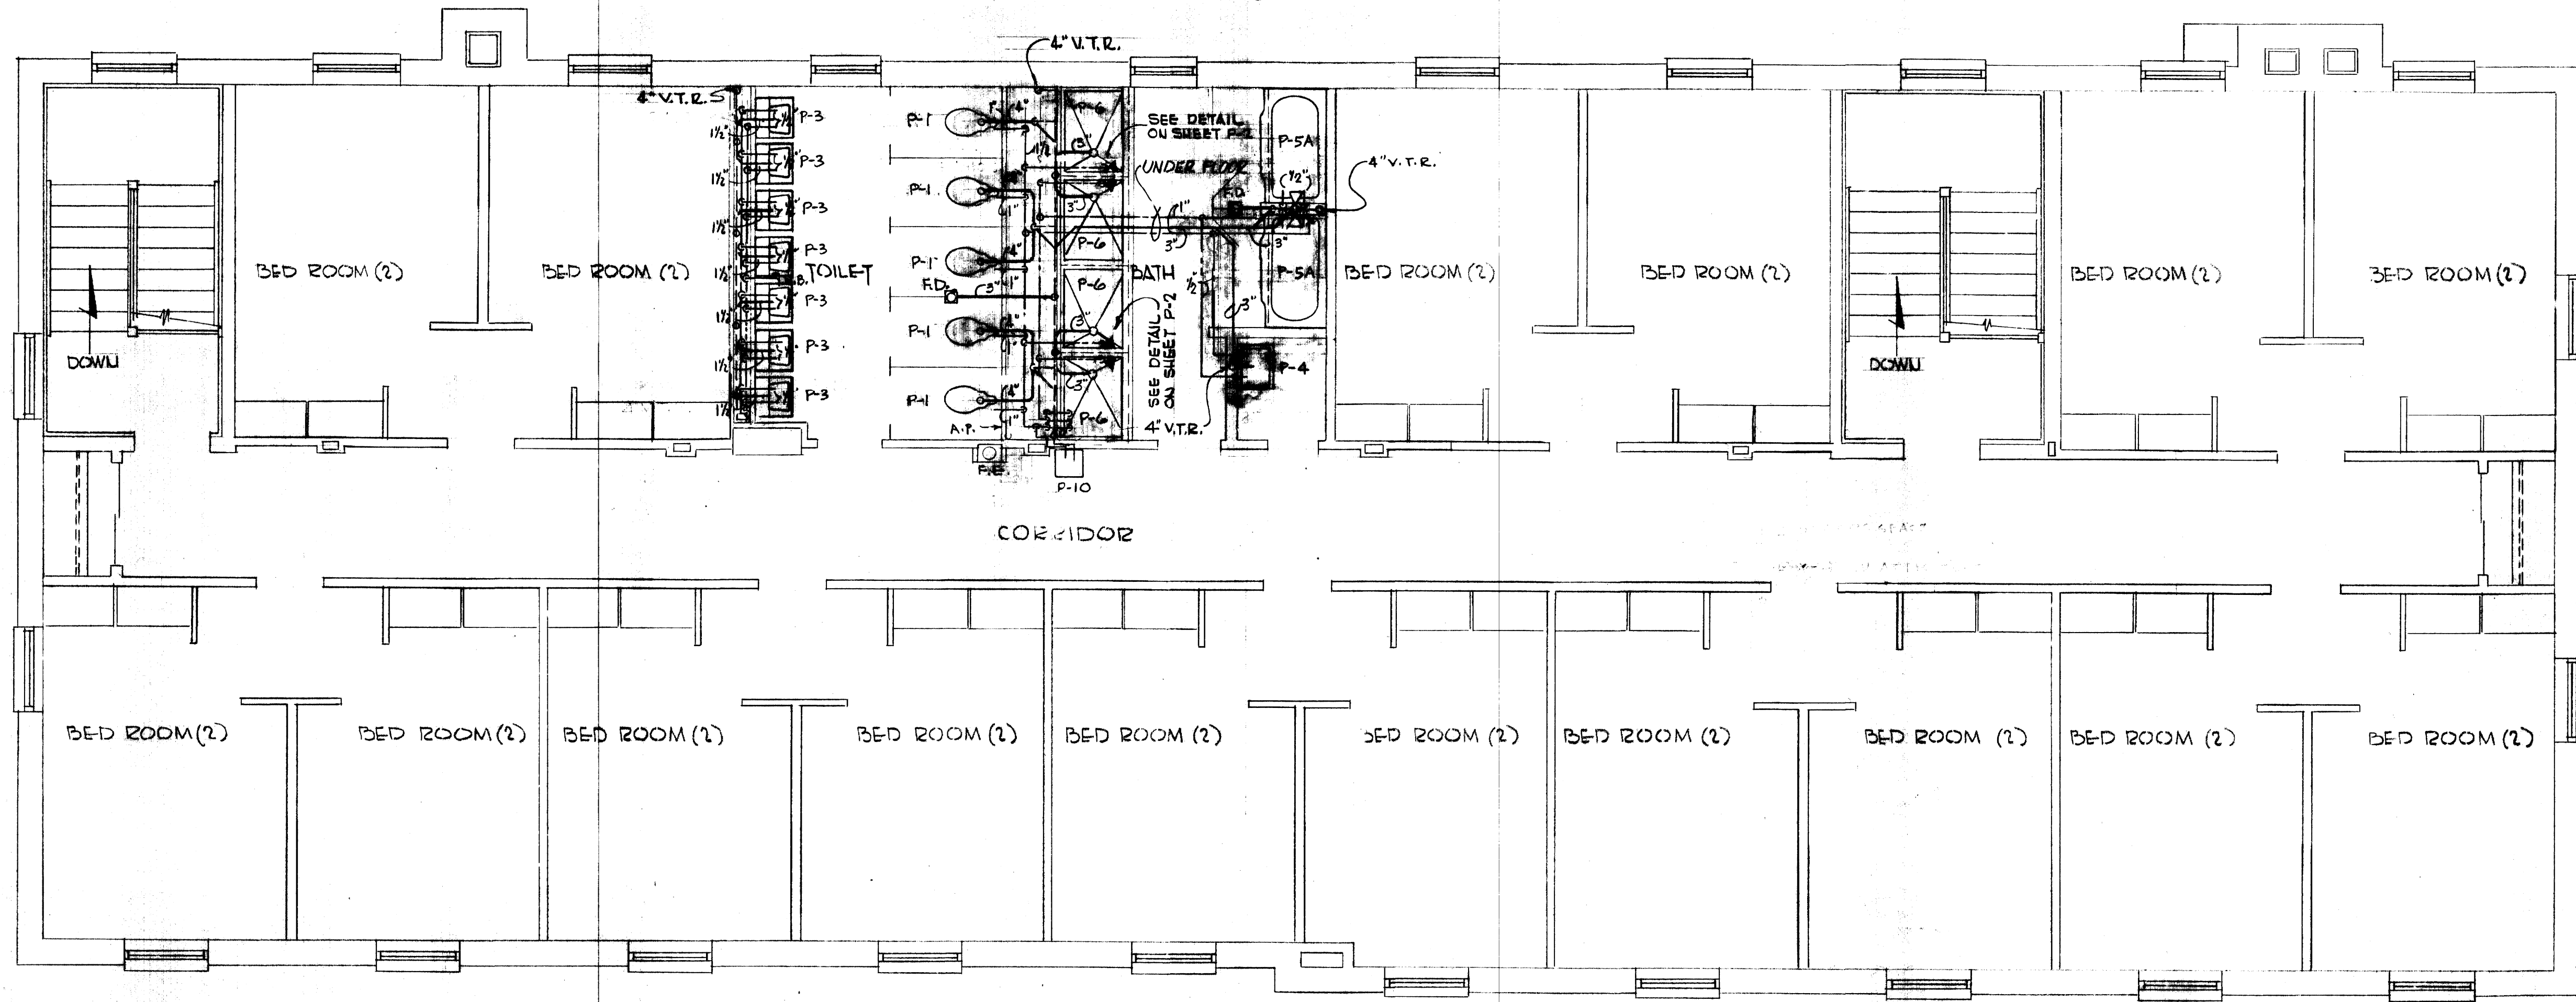

SECOND FLOOR PLUMBING PLAN

SCALE 1/4" = 1'-0"

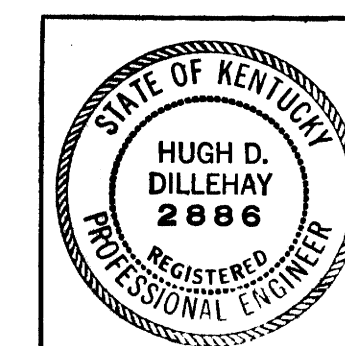


HUGH DILLEHAY AND ASSOCIATES
CONSULTING ENGINEERS
LEXINGTON JOB NO. G-226 KENTUCKY

DELTA GAMMA SORORITY HOUSE UNIVERSITY OF KENTUCKY LEXINGTON KENTUCKY			
DRAWN BY R.L.K.	SECOND FLOOR PLUMBING	DATE 1-25-63	SCALE AS NOTED
CHECKED BY H.D.D.	GILLIG • CHRISMAN & MILLER ARCHITECTS ASSOCIATED 180 WALNUT STREET LEXINGTON, KENTUCKY	SPEC. NO.	DRAWING NO. 103
REVISIONS	COMMONWEALTH OF KENTUCKY DEPARTMENT OF FINANCE ENGINEERING STAFF FRANKFORT KENTUCKY	APPROVED BY <i>Mark Peterson</i> CHIEF OF STAFF	DATE 1-25-63
APPROVED BY HUGH DILLEHAY AND ASSOCIATES CONSULTING ENGINEERS LEXINGTON JOB NO. G-226 KENTUCKY	APPROVED BY <i>David H. Pritchard</i> CHIEF OF STAFF	DATE	DATE

V-1901

008106


Document # 008106
Sheet C-2

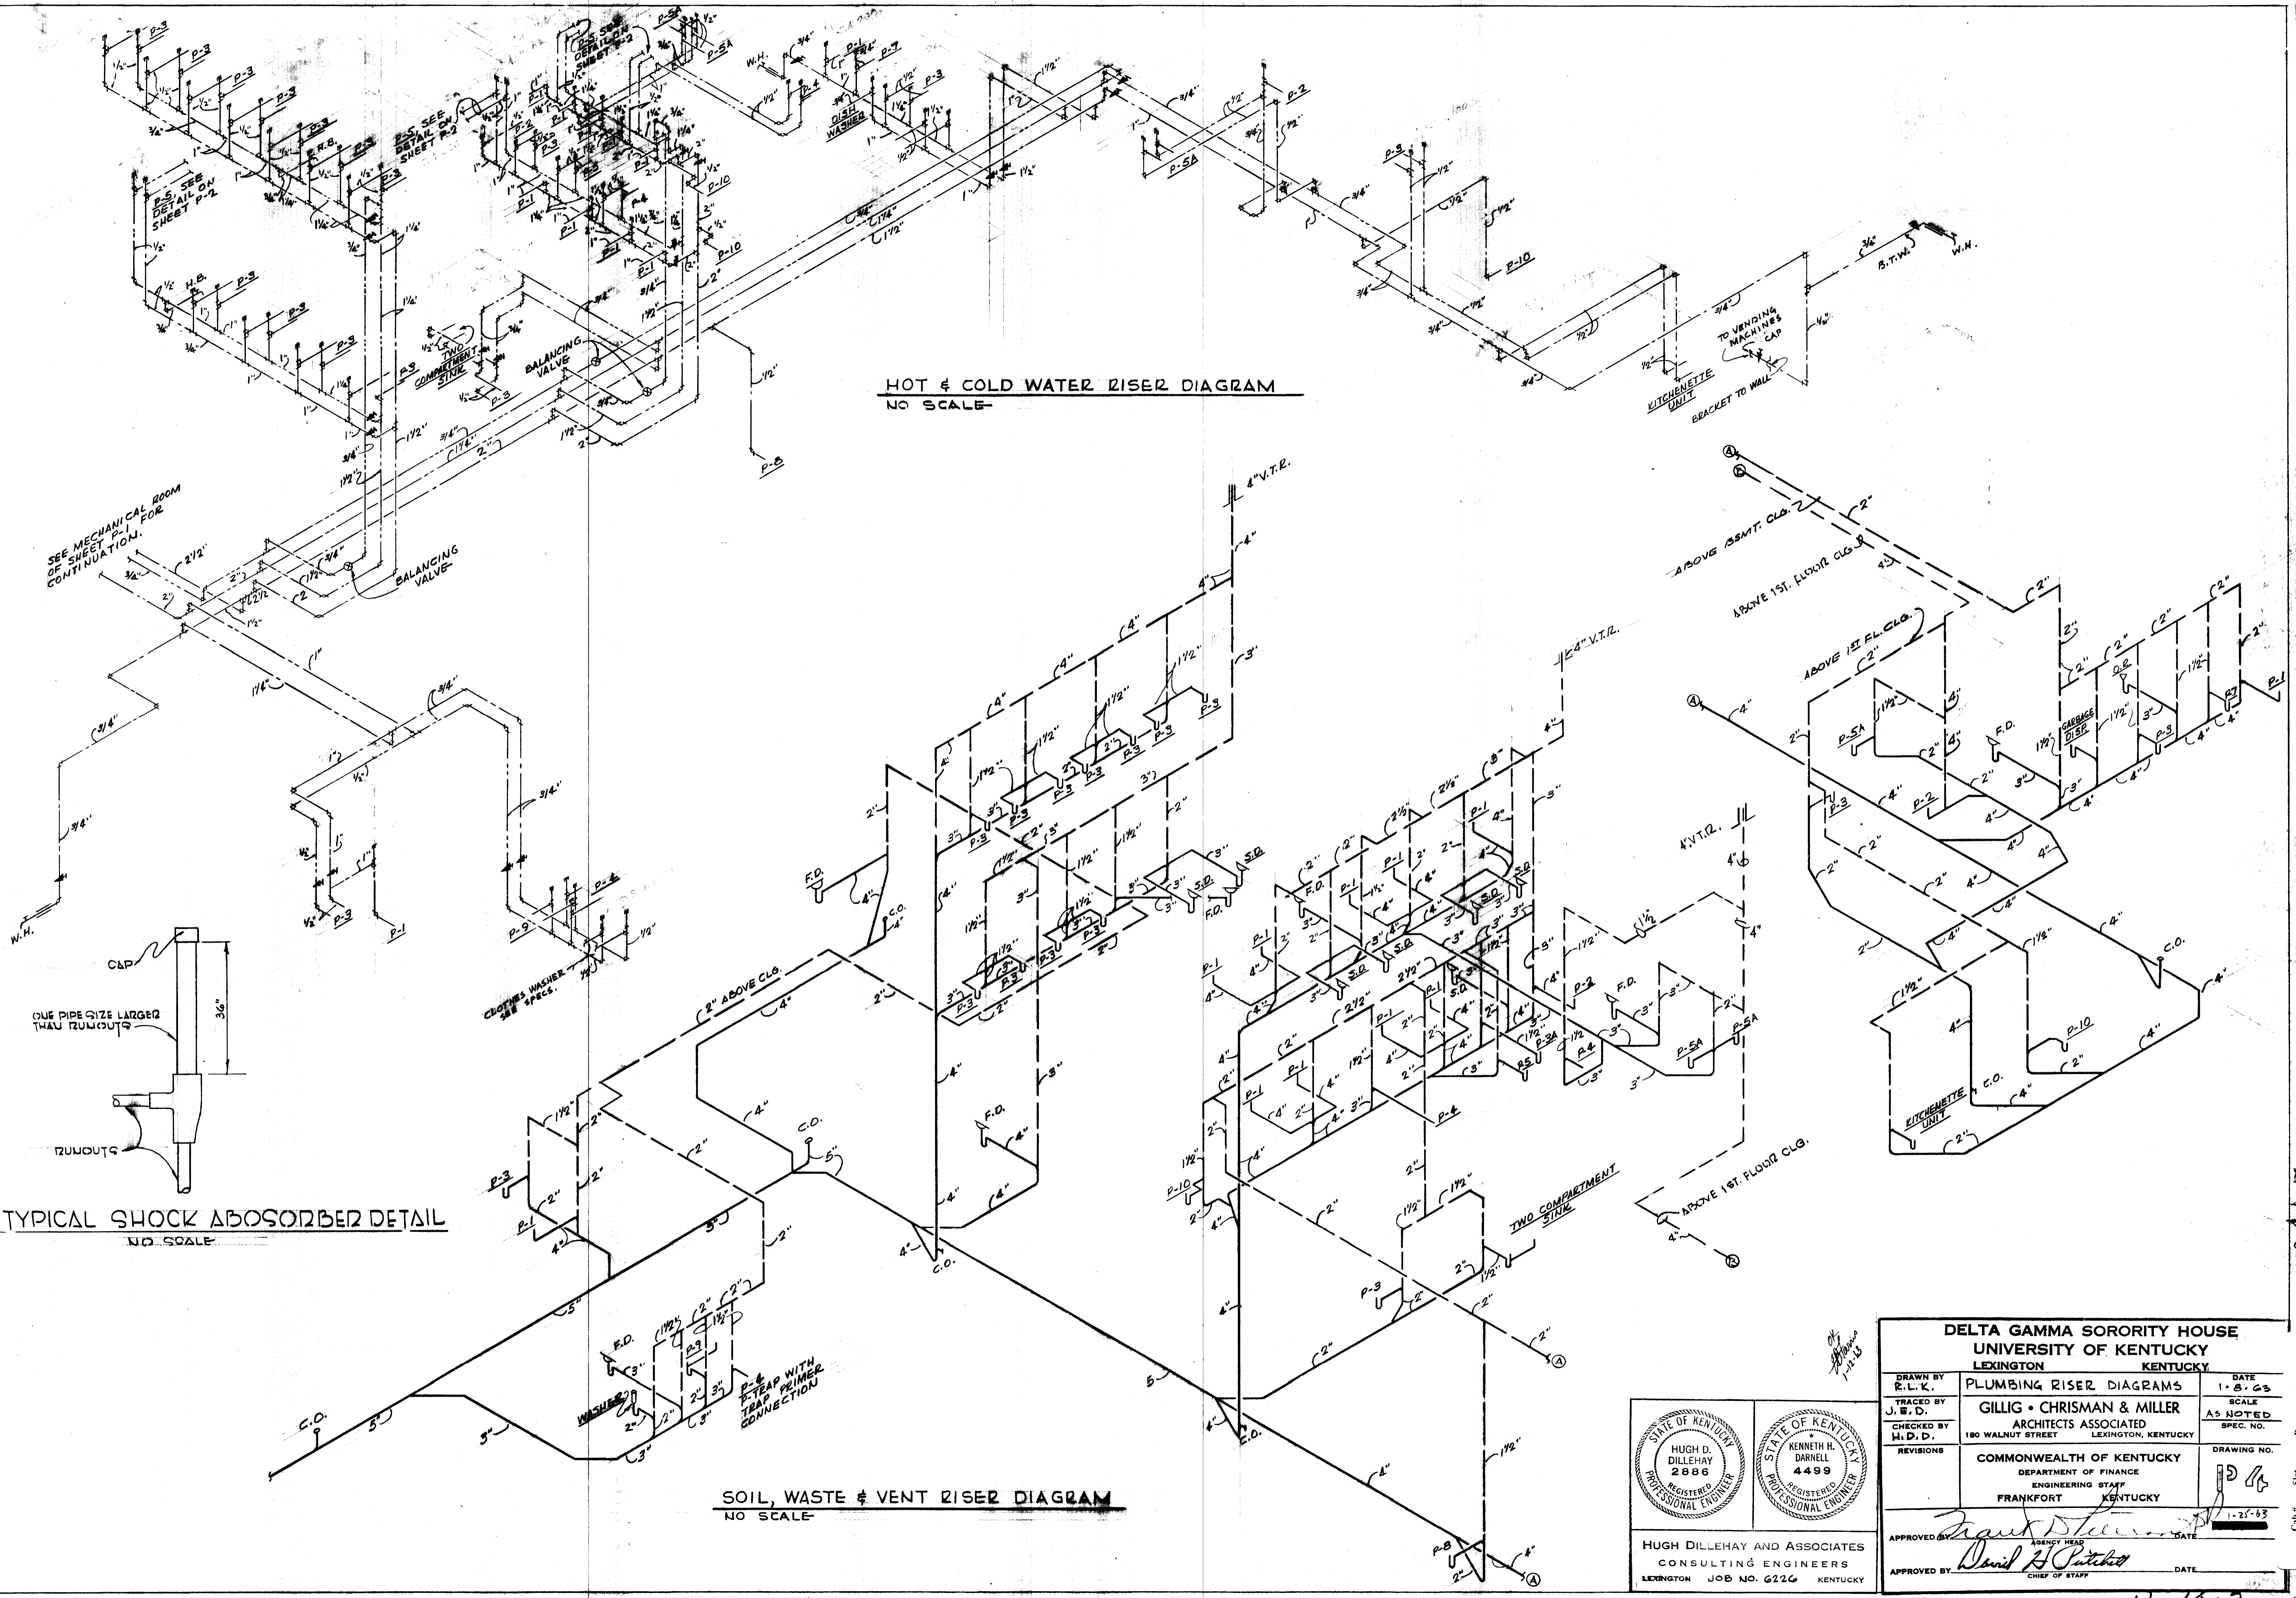

HOT & COLD WATER RISER DIAGRAM
NO SCALE

SOIL, WASTE & VENT RISER DIAGRAM
NO SCALE

TYPICAL SHOCK ABSORBER DETAIL
NO SCALE

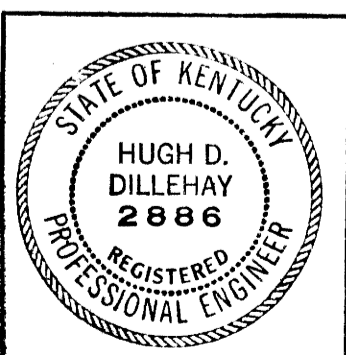


HUGH DILLEHAY AND ASSOCIATES
CONSULTING ENGINEERS
LEXINGTON JOB NO. 6226 KENTUCKY

DELTA GAMMA SORORITY HOUSE UNIVERSITY OF KENTUCKY LEXINGTON KENTUCKY		
DRAWN BY R.L.K.	PLUMBING RISER DIAGRAMS	DATE 1-8-63
TRACED BY J.E.D.	GILLIG • CHRISMAN & MILLER ARCHITECTS ASSOCIATED 180 WALNUT STREET LEXINGTON, KENTUCKY	SCALE AS NOTED SPEC. NO.
CHECKED BY H.D.D.	COMMONWEALTH OF KENTUCKY DEPARTMENT OF FINANCE ENGINEERING STAFF FRANKFORT KENTUCKY	DRAWING NO.
APPROVED BY <i>Frank Starnes</i> AGENT HEAD	APPROVED BY <i>David H. Satchel</i> CHIEF OF STAFF	DATE 1-25-63


U-1902

008607
 DOCUMENT # 008107
 C-2
 121



BOILER PIPING DETAIL - NO SCALE

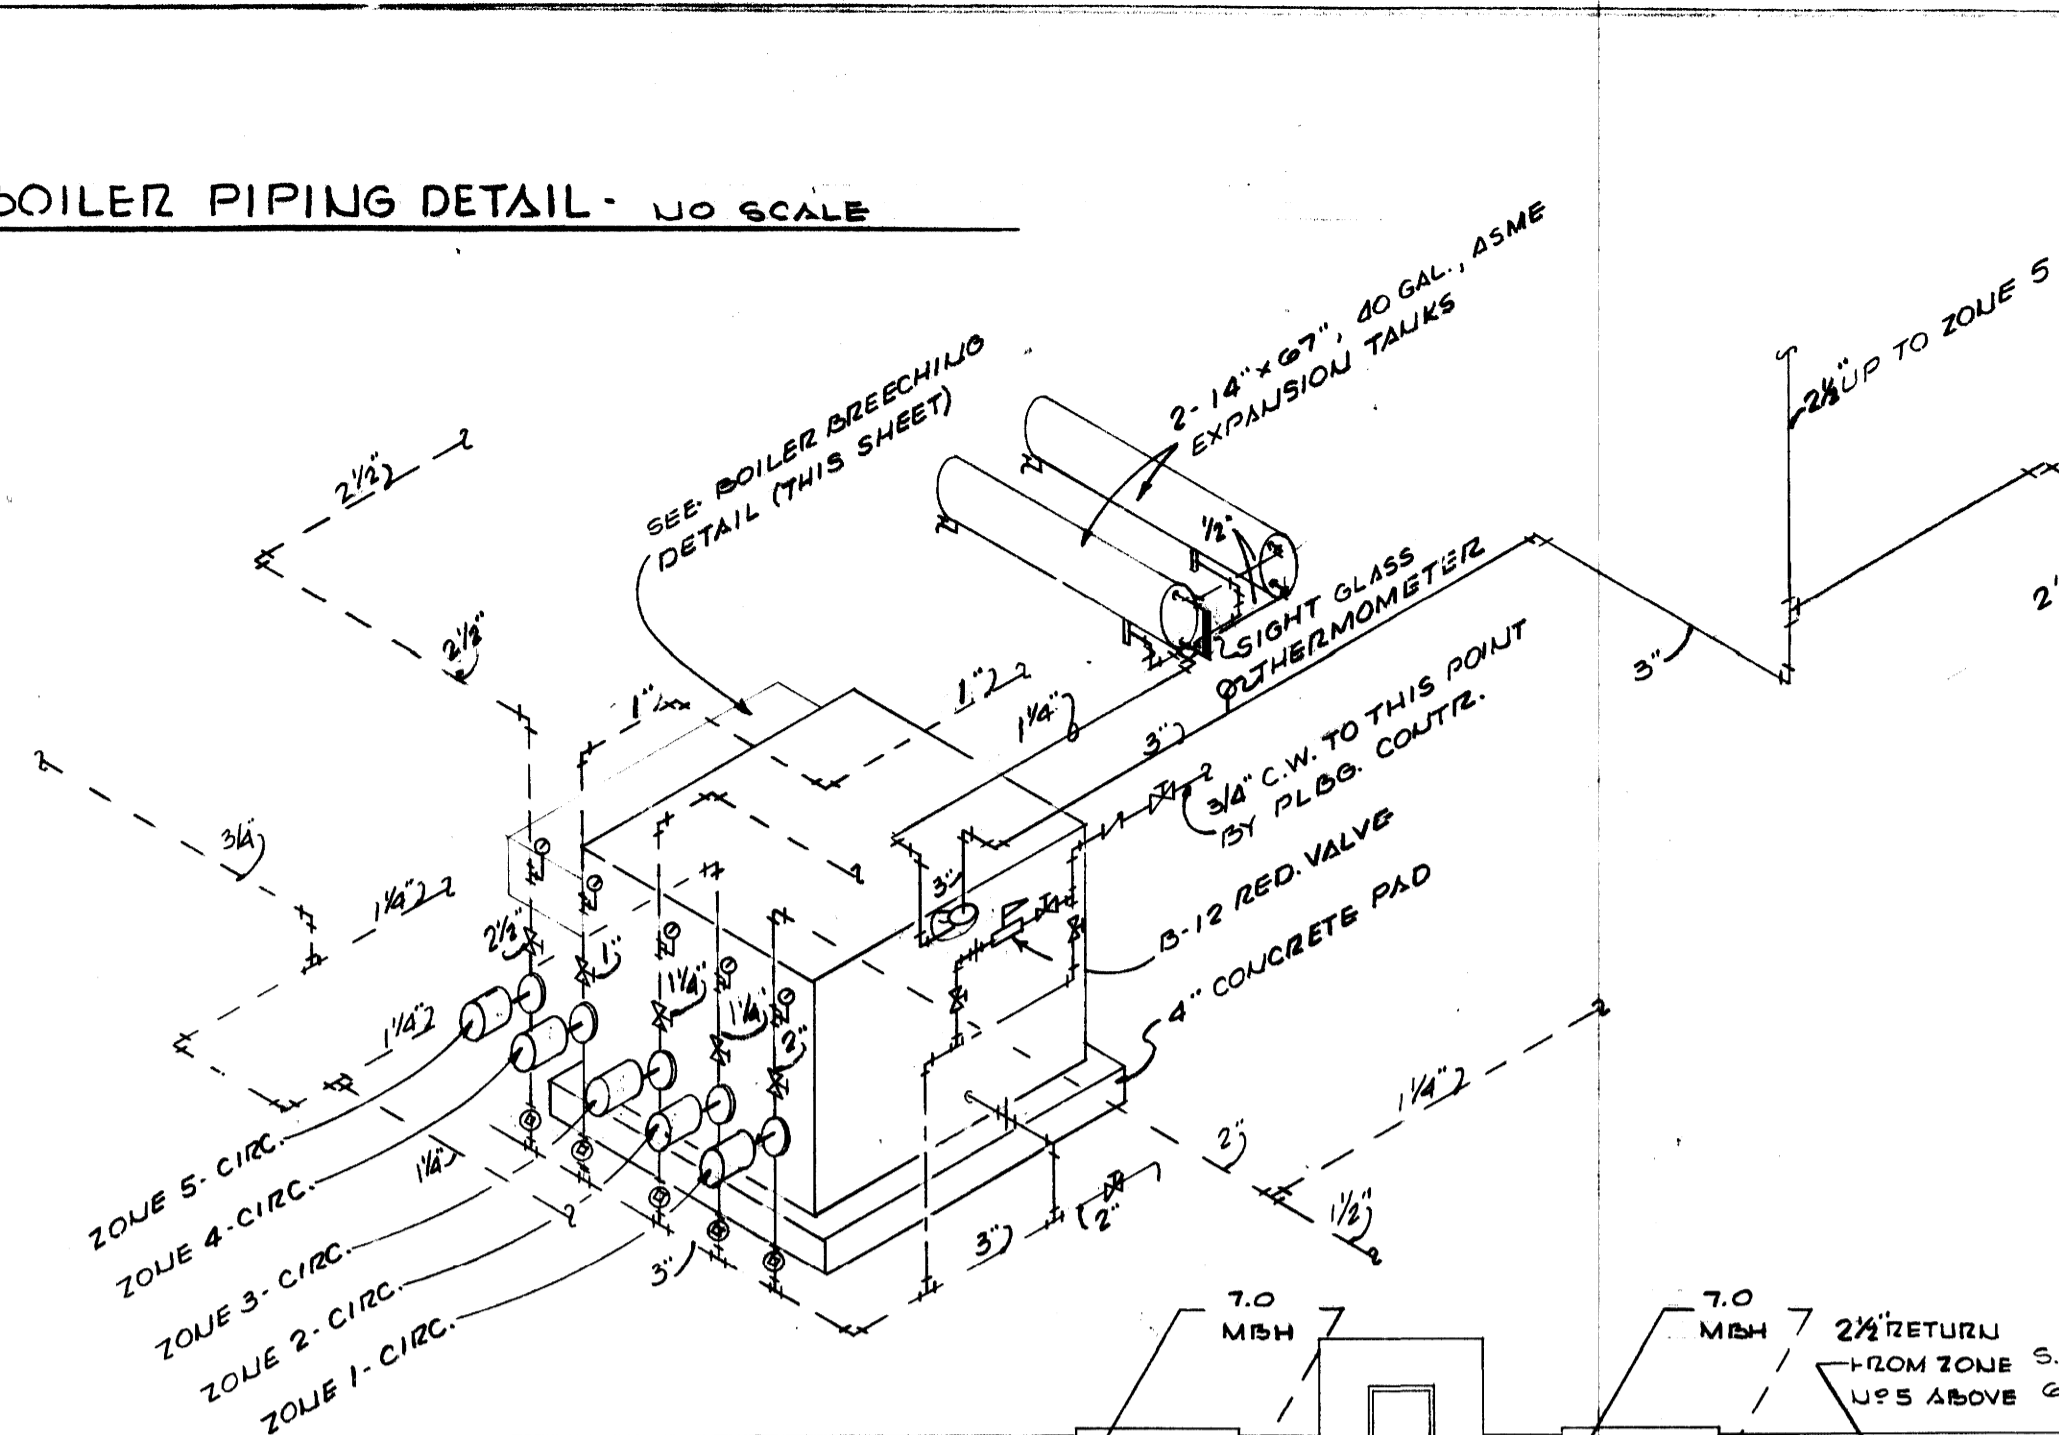

BOILER BREACHING DETAIL - NO SCALE

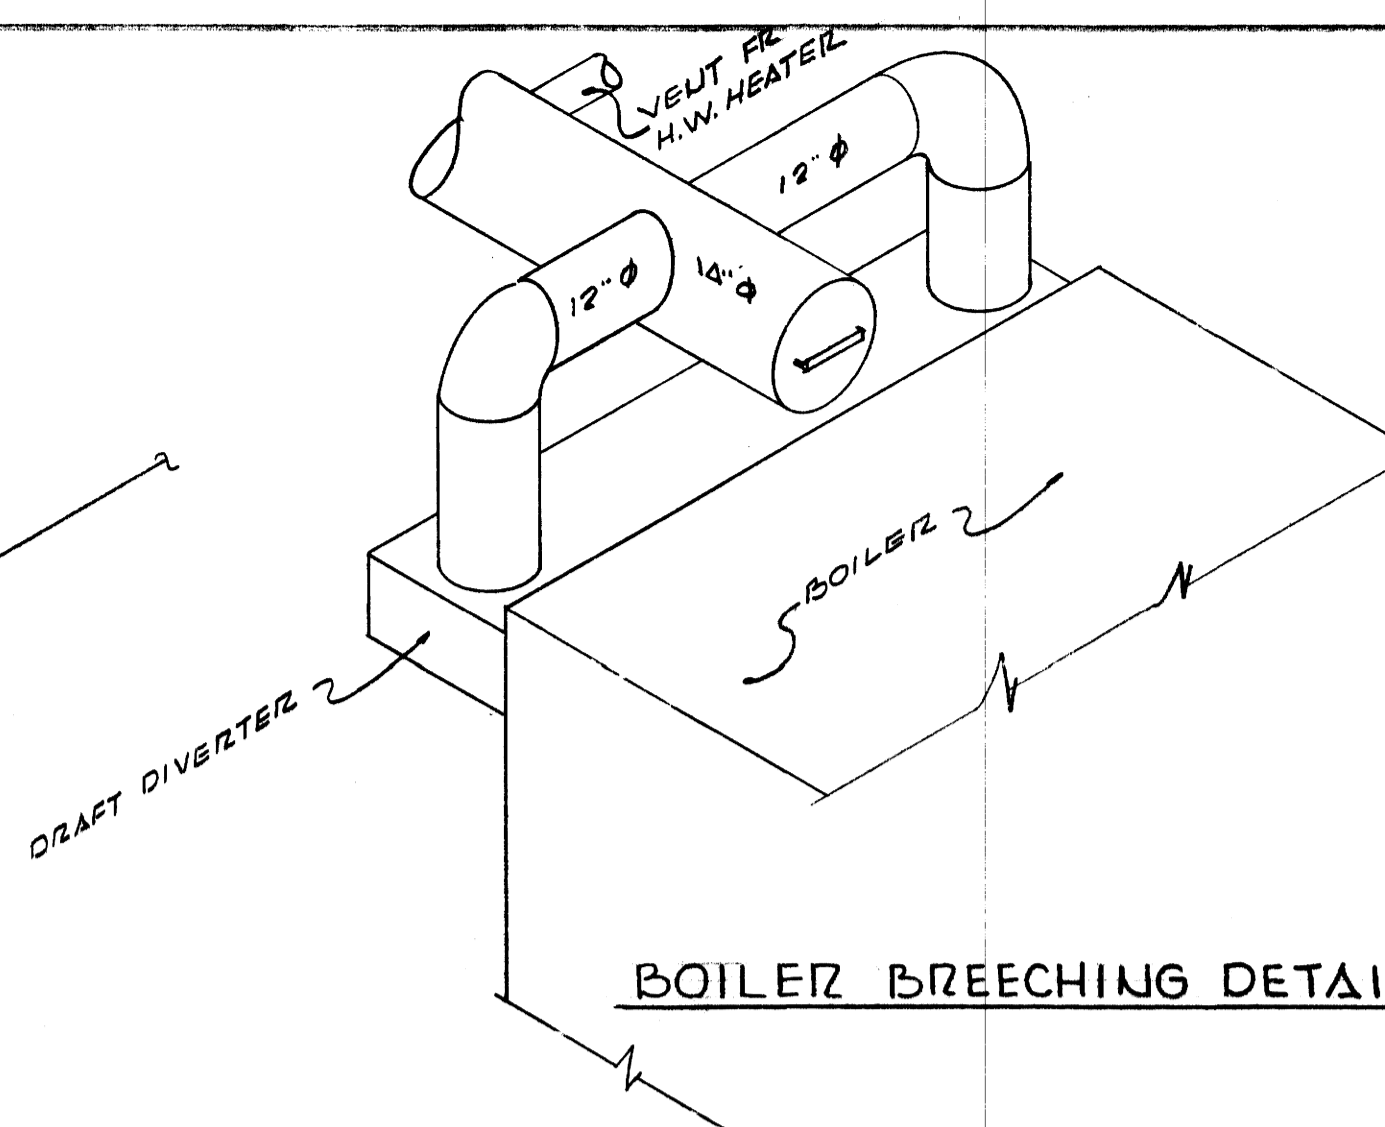

TYPICAL DOWNFEED CONNECTOR PIPING DETAIL - NO SCALE

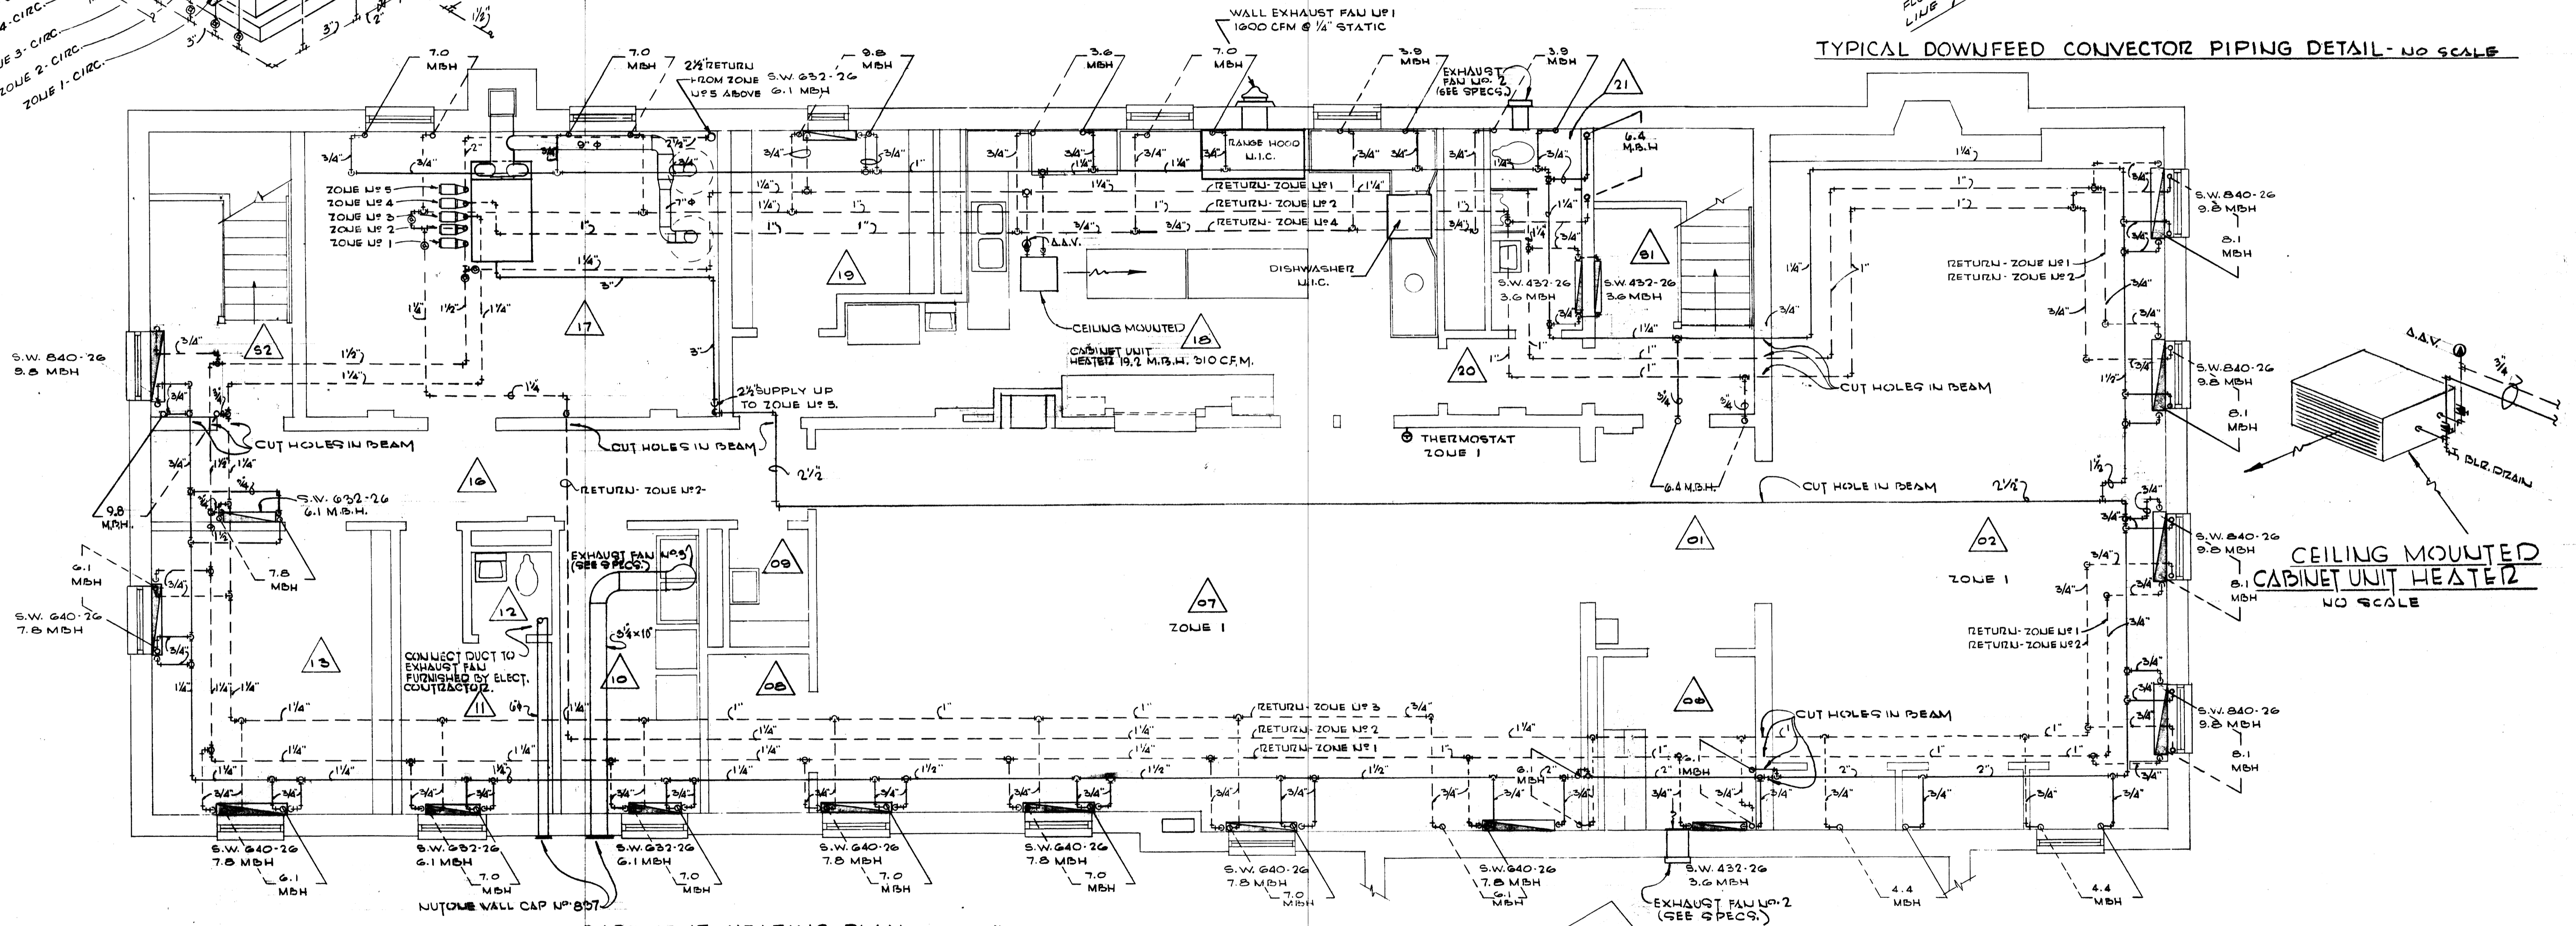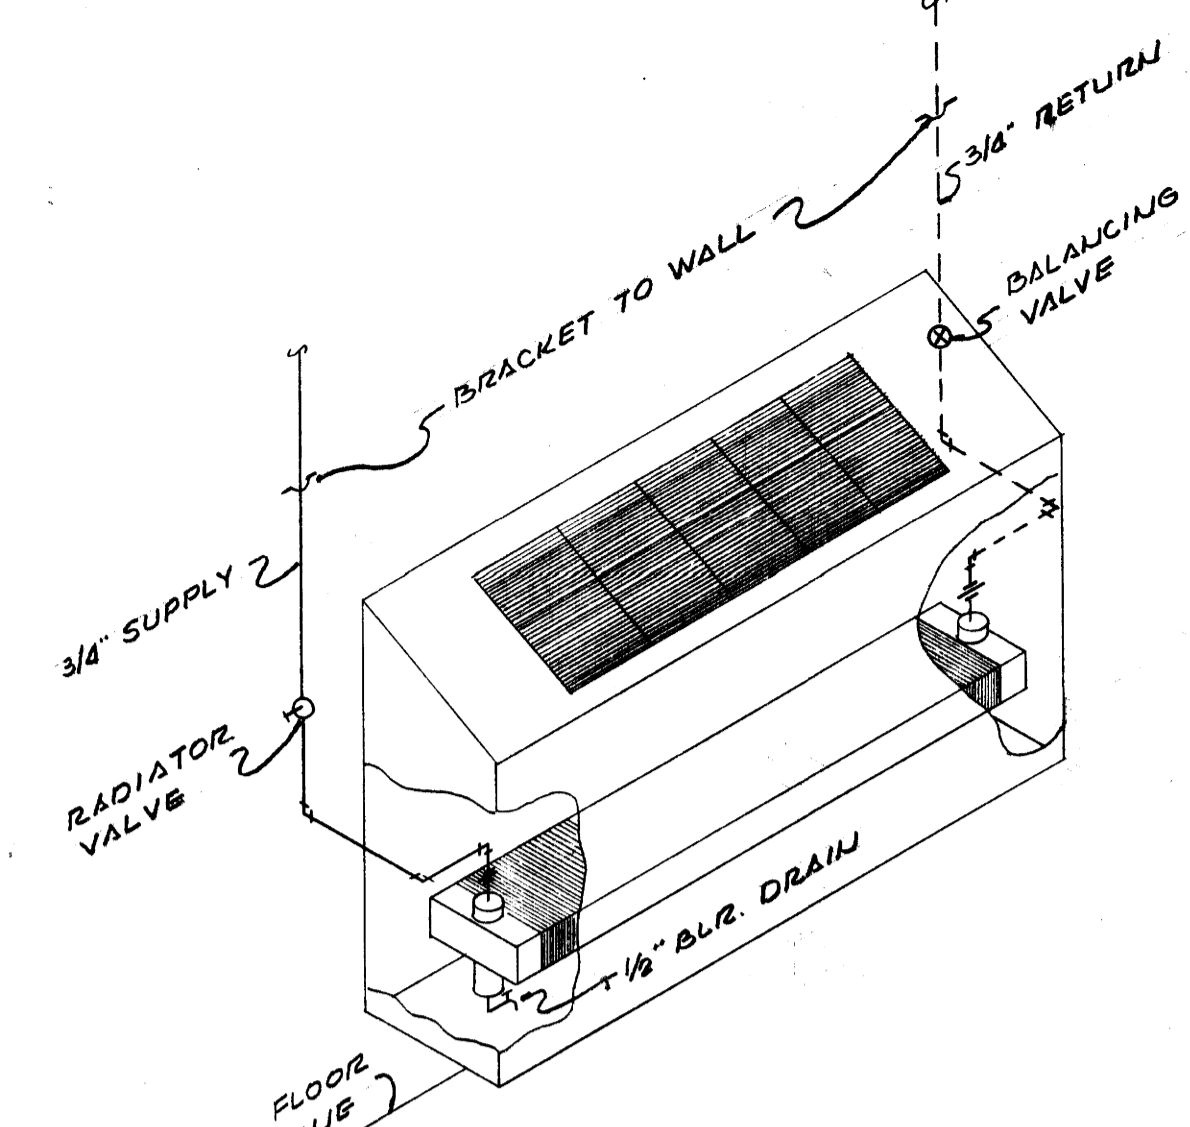


BASEMENT HEATING PLAN - SCALE 1/4" = 1'-0"

ZONE LEGEND



ZONE NO. 1	ENTIRE BASEMENT
ZONE NO. 2	FIRST FLOOR - ROOMS NO. 81, 103, 102 & 101.
ZONE NO. 3	REMAINDER OF FIRST FLOOR LESS ZONES 2 & 4.
ZONE NO. 4	FIRST FLOOR - ROOMS NO. 107, 105, & 104.
ZONE NO. 5	ENTIRE SECOND FLOOR.

PUMP SCHEDULE

PUMP NO.	ZONE SERVED	MODEL	CAPACITY	HEAD	MOTOR CHARACTERISTICS
1	1	2" BOOSTER	20	10'	1/2 HP - 115V, 60 CY., 1 Φ
2	2	1 1/2" H.V.	10	10'	1/2 HP - 115V, 60 CY., 1 Φ
3	3	1 1/2" H.V.	10	10'	1/2 HP - 115V, 60 CY., 1 Φ
4	4	#100	5	7 1/2'	1/2 HP - 115V, 60 CY., 1 Φ
5	5	2 1/2" BOOSTER	20	14 1/2'	1/2 HP - 115V, 60 CY., 1 Φ

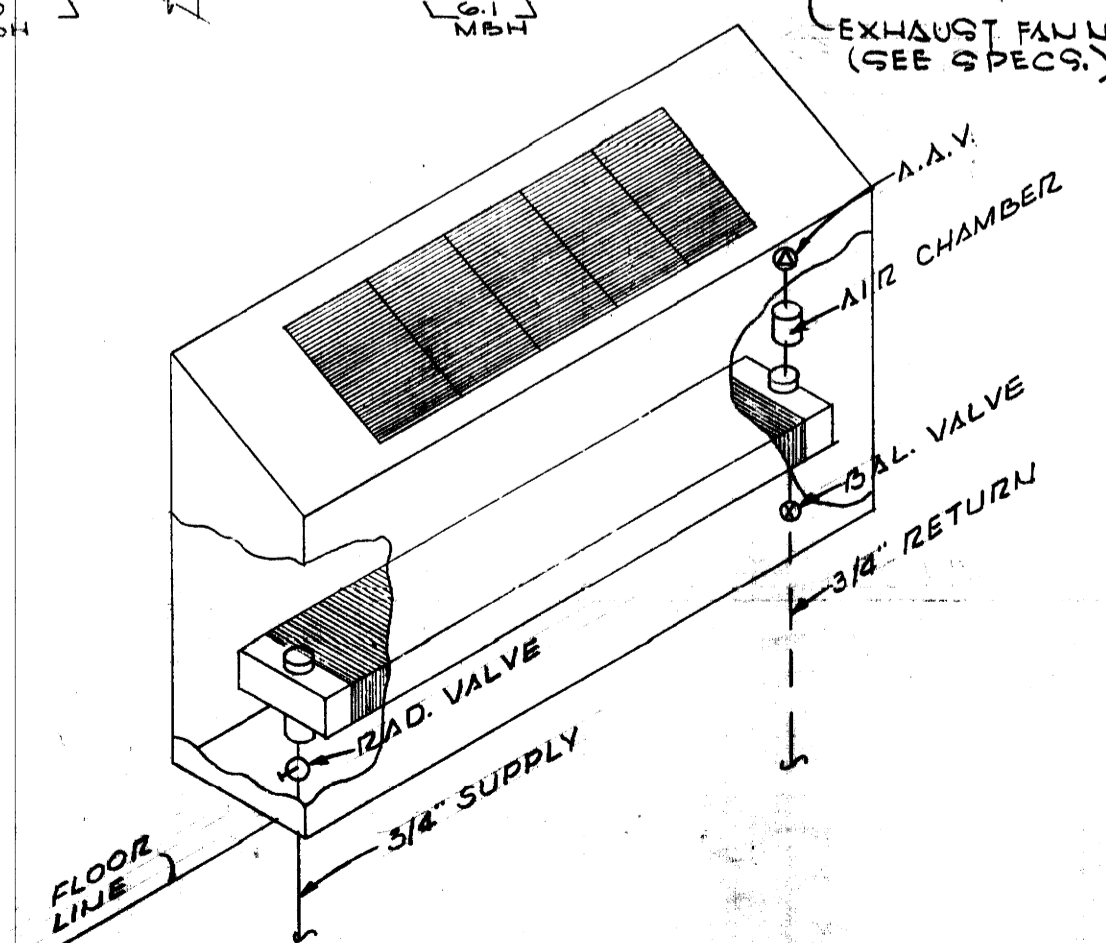

TYPICAL UPFEED CONNECTOR PIPING DETAIL - NO SCALE

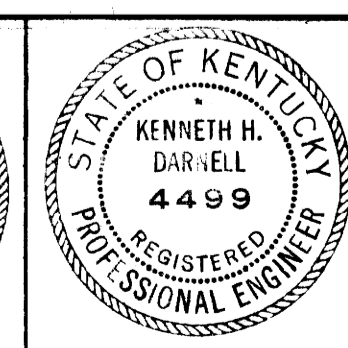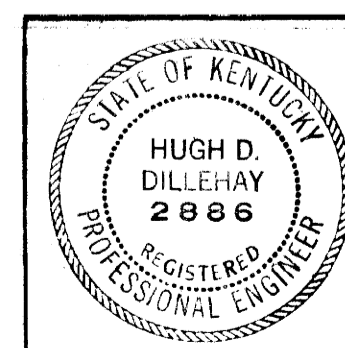

HUGH DILLEHAY AND ASSOCIATES
CONSULTING ENGINEERS
LEXINGTON, KENTUCKY

DELTA GAMMA SORORITY HOUSE
UNIVERSITY OF KENTUCKY
LEXINGTON, KENTUCKY

PROJECT: BASEMENT HEATING

DESIGNED BY: GILG, CHRISMAN & MILLER ARCHITECTS ASSOCIATED
100 WALKER STREET, LEXINGTON, KENTUCKY

CHECKED BY: H. D. D.


APPROVED BY: *Frank J. Peterson* (Agency Head) DATE: 1-25-63
W. J. Mc Cormell (Chief of Staff) DATE: 2-5-63

COMMONWEALTH OF KENTUCKY
DEPARTMENT OF FINANCE
ENGINEERING STAFF
FRANKFORT, KENTUCKY

DRAWING NO. H-11


DATE: 1-25-63

DATE: 2-5-63

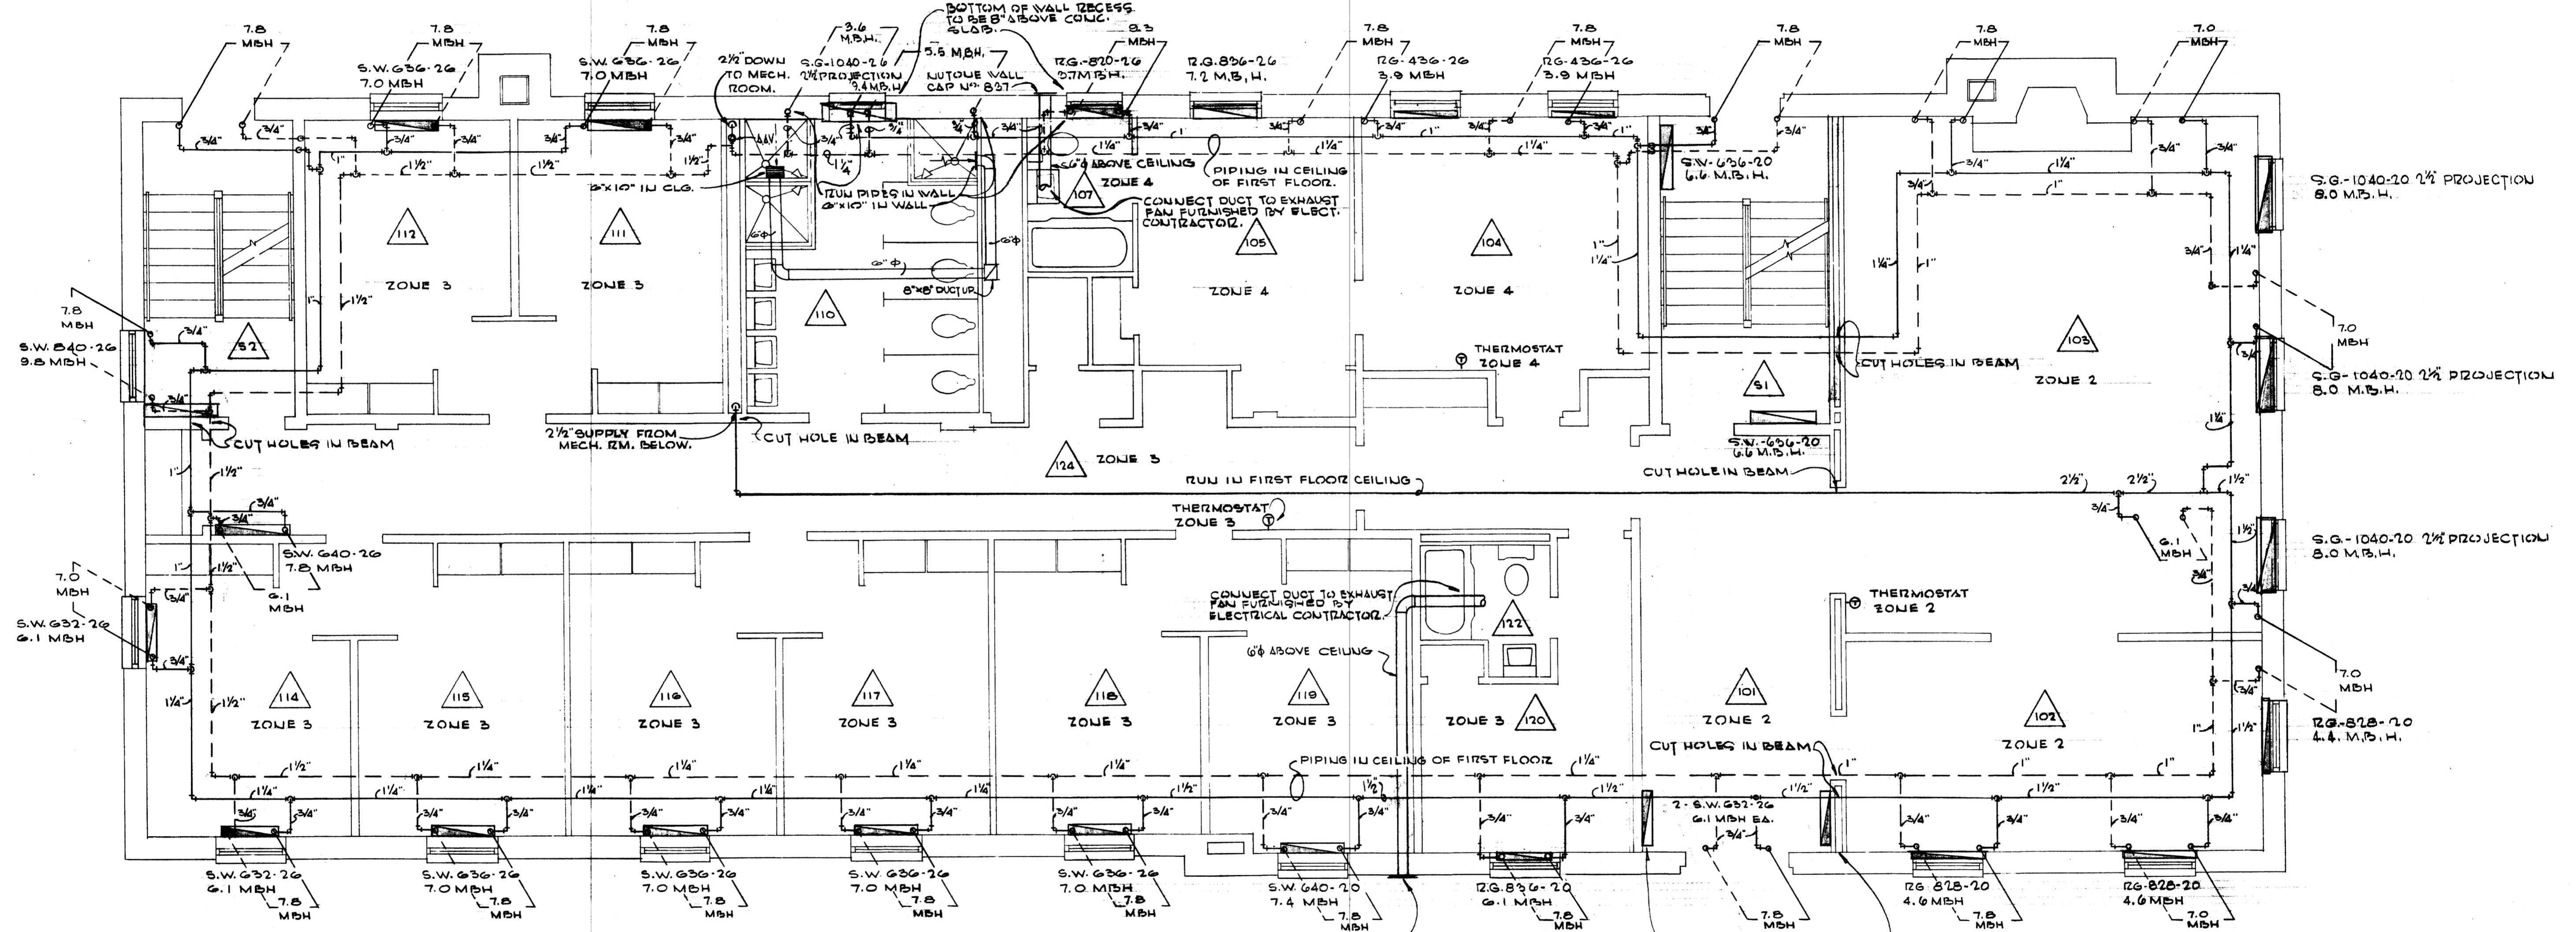

FIRST FLOOR HEATING PLAN - SCALE 1/4" = 1'-0"

HEATING LEGEND	
HOT WATER SUPPLY	—
HOT WATER RETURN	- - -
CONVECTOR	[Symbol]
AUTOMATIC AIR VENT	[Symbol]
GATE VALVE	[Symbol]
UNION	[Symbol]
BALANCING VALVE	[Symbol]
THERMOMETER	[Symbol]
ELBOW (PLAN, UP, DOWN)	[Symbol]
TEE (PLAN, UP, DOWN)	[Symbol]
CHECK VALVE	[Symbol]

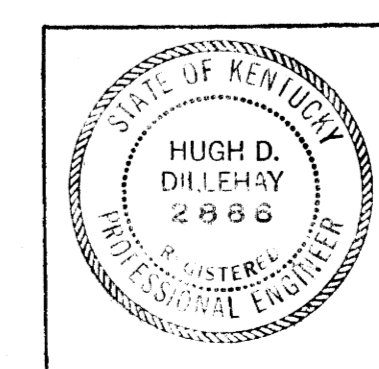


HUGH DILLEHAY AND ASSOCIATES
CONSULTING ENGINEERS
LEXINGTON JOB NO. G226 KENTUCKY


DELTA GAMMA SORORITY HOUSE UNIVERSITY OF KENTUCKY LEXINGTON KENTUCKY		
DRAWN BY CLUG • CHRISMAN & MILLER ARCHITECTS ASSOCIATED 100 WALNUT STREET LEXINGTON, KENTUCKY	DATE 1-25-65	SCALE 1/4" = 1'-0" SPEC. 10
CHECKED BY COMMONWEALTH OF KENTUCKY DEPARTMENT OF FINANCE ENGINEERING STAFF FRANKFORT KENTUCKY	DRAWING	APPROVED BY <i>W. J. Mc Connell</i> CHIEF OF STAFF
APPROVED BY <i>W. J. Mc Connell</i> CHIEF OF STAFF	DATE 2-5-63	U-1902

008109

008109


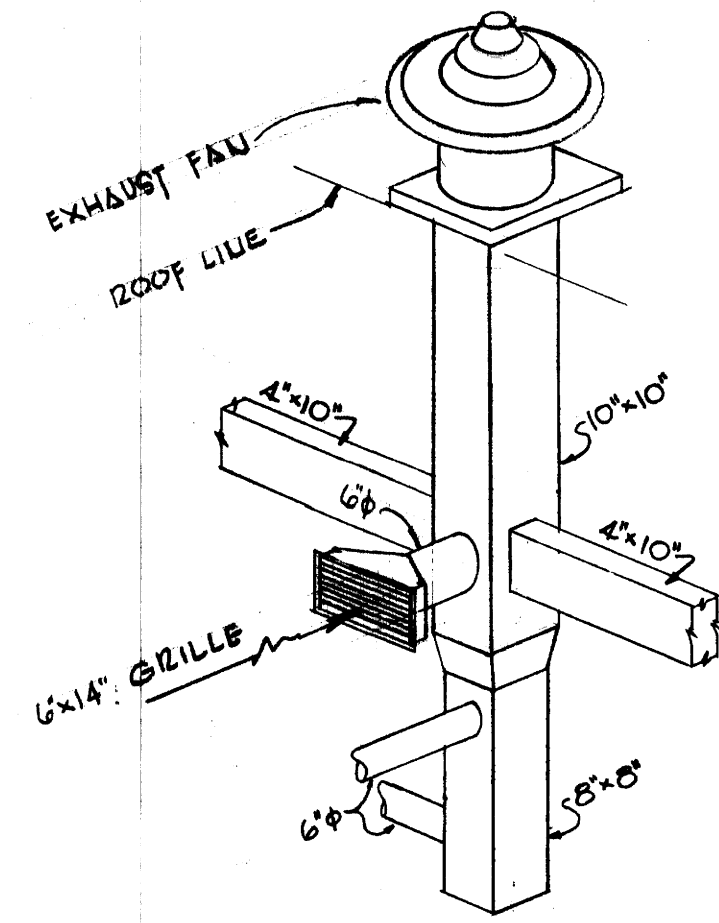


EXHAUST FAN DETAIL
NO SCALE

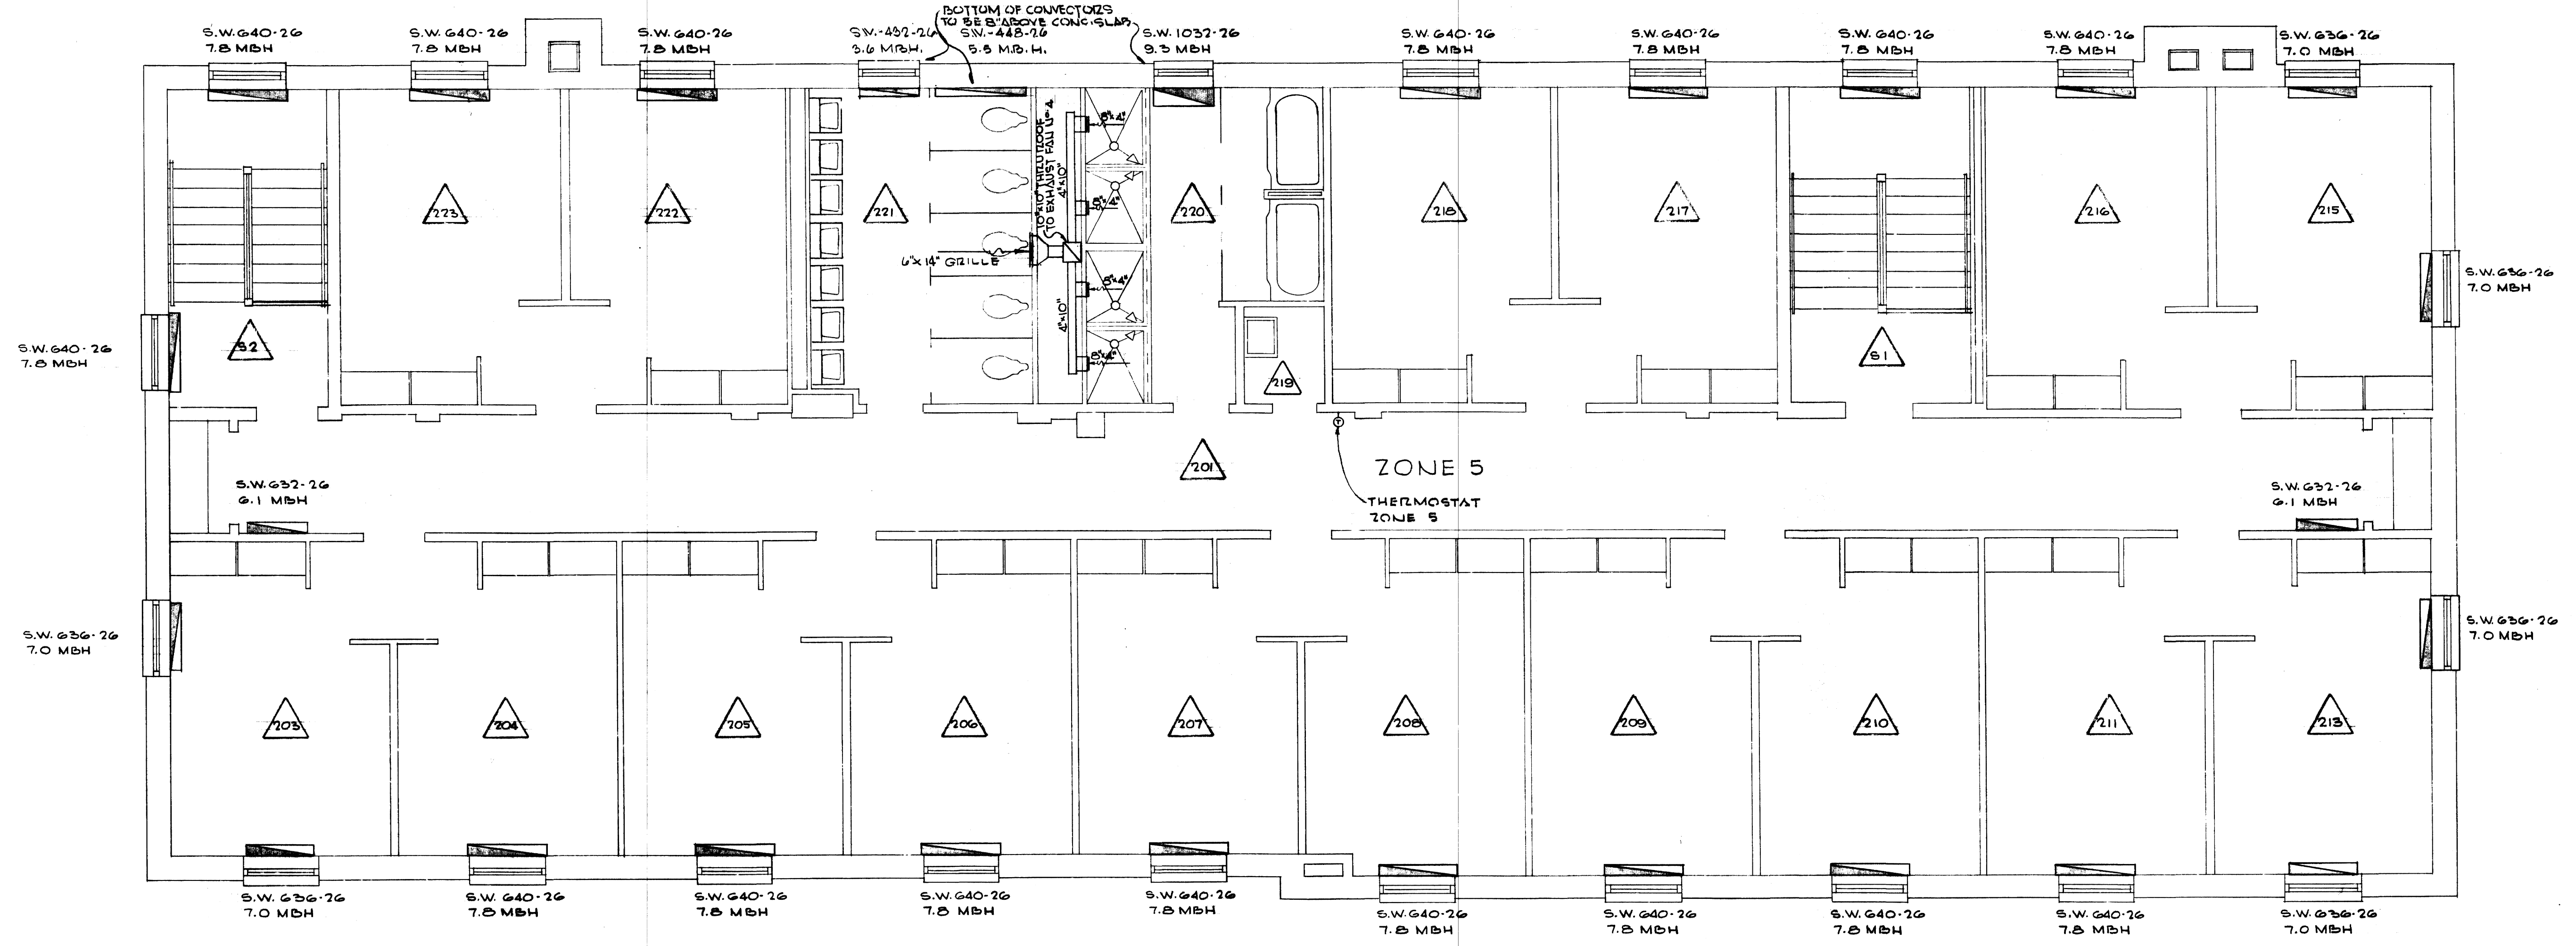


SECOND FLOOR HEATING PLAN. SCALE: 1/4" = 1'-0"

008110

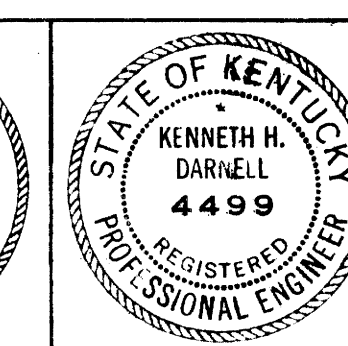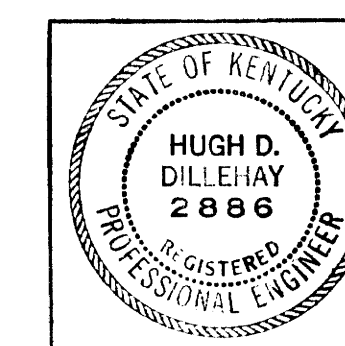


DELTA GAMMA SORORITY HOUSE		
UNIVERSITY OF KENTUCKY		
DESIGNED BY	SECOND FLOOR HEATING	DATE 1-8-65
TRACED BY	GILIG • CHRISMAN & MILLER	SCALE 1/4" = 1'-0"
CHECKED BY	ARCHITECTS ASSOCIATED	SPEC. NO.
REVISIONS	100 GALESTY STREET	DRAWING NO. 1-13
COMMONWEALTH OF KENTUCKY		
DEPARTMENT OF FINANCE		
ENGINEERING STAFF		
FRANK H. T. KENTUCKY		
APPROVED BY	<i>W. T. McConnell</i>	DATE 2-5-63
HUGH DILLEHAY AND ASSOCIATES		
CONSULTING ENGINEERS		
LEXINGTON JOB NO. 6226 KENTUCKY		


U-1915

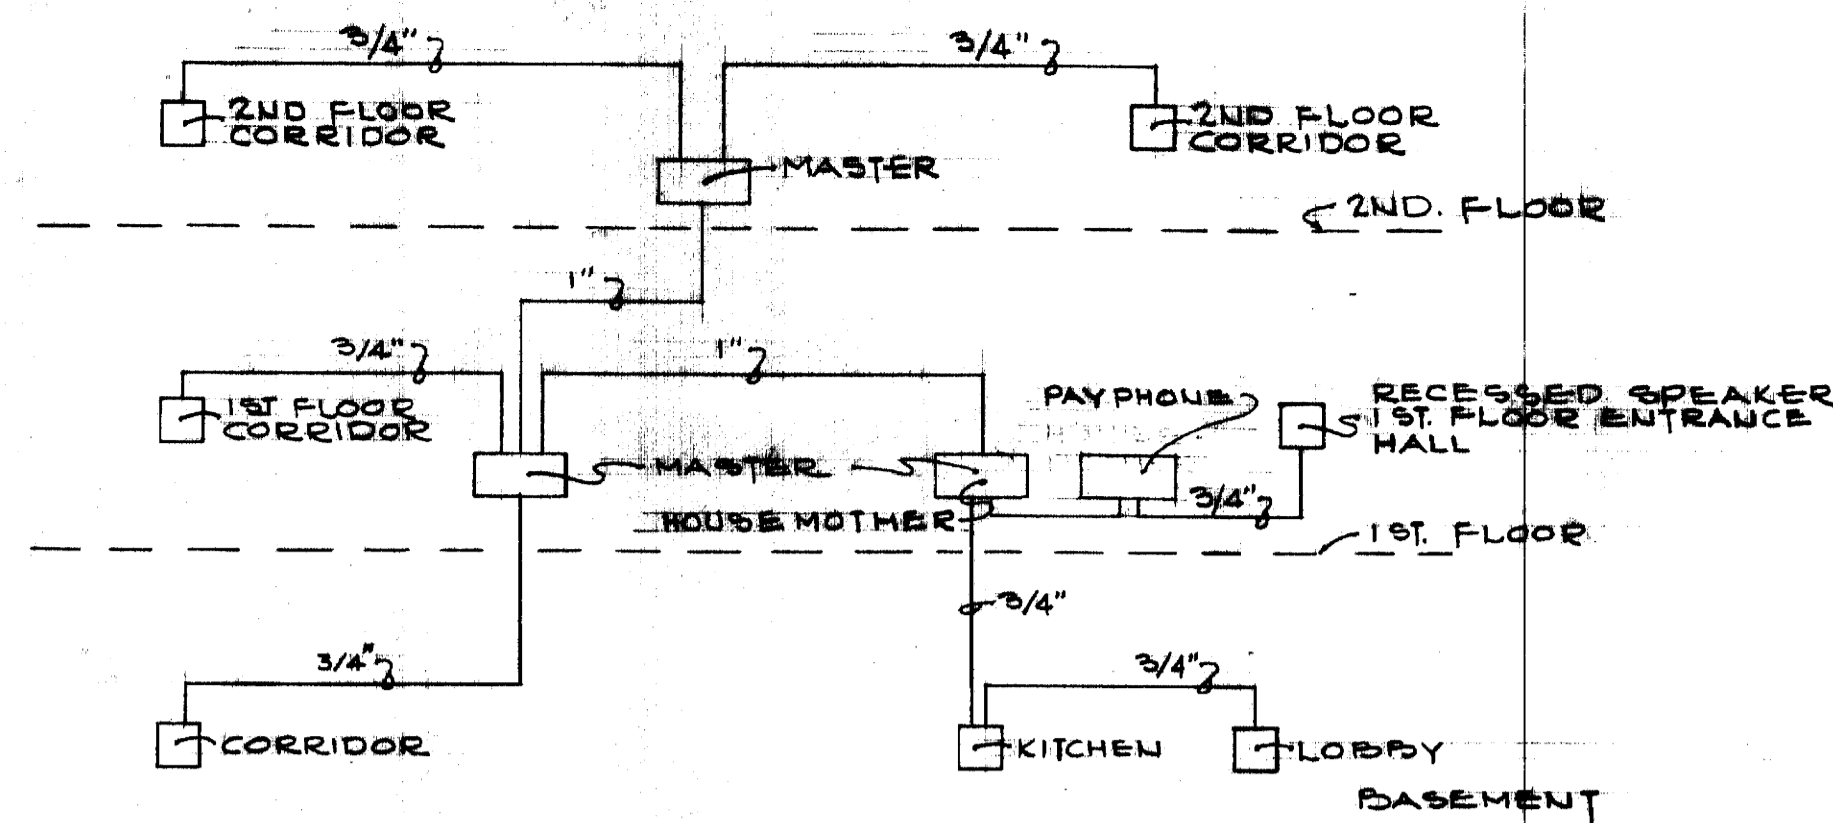

INTERCOM RISER DIAGRAM
N.T.S.

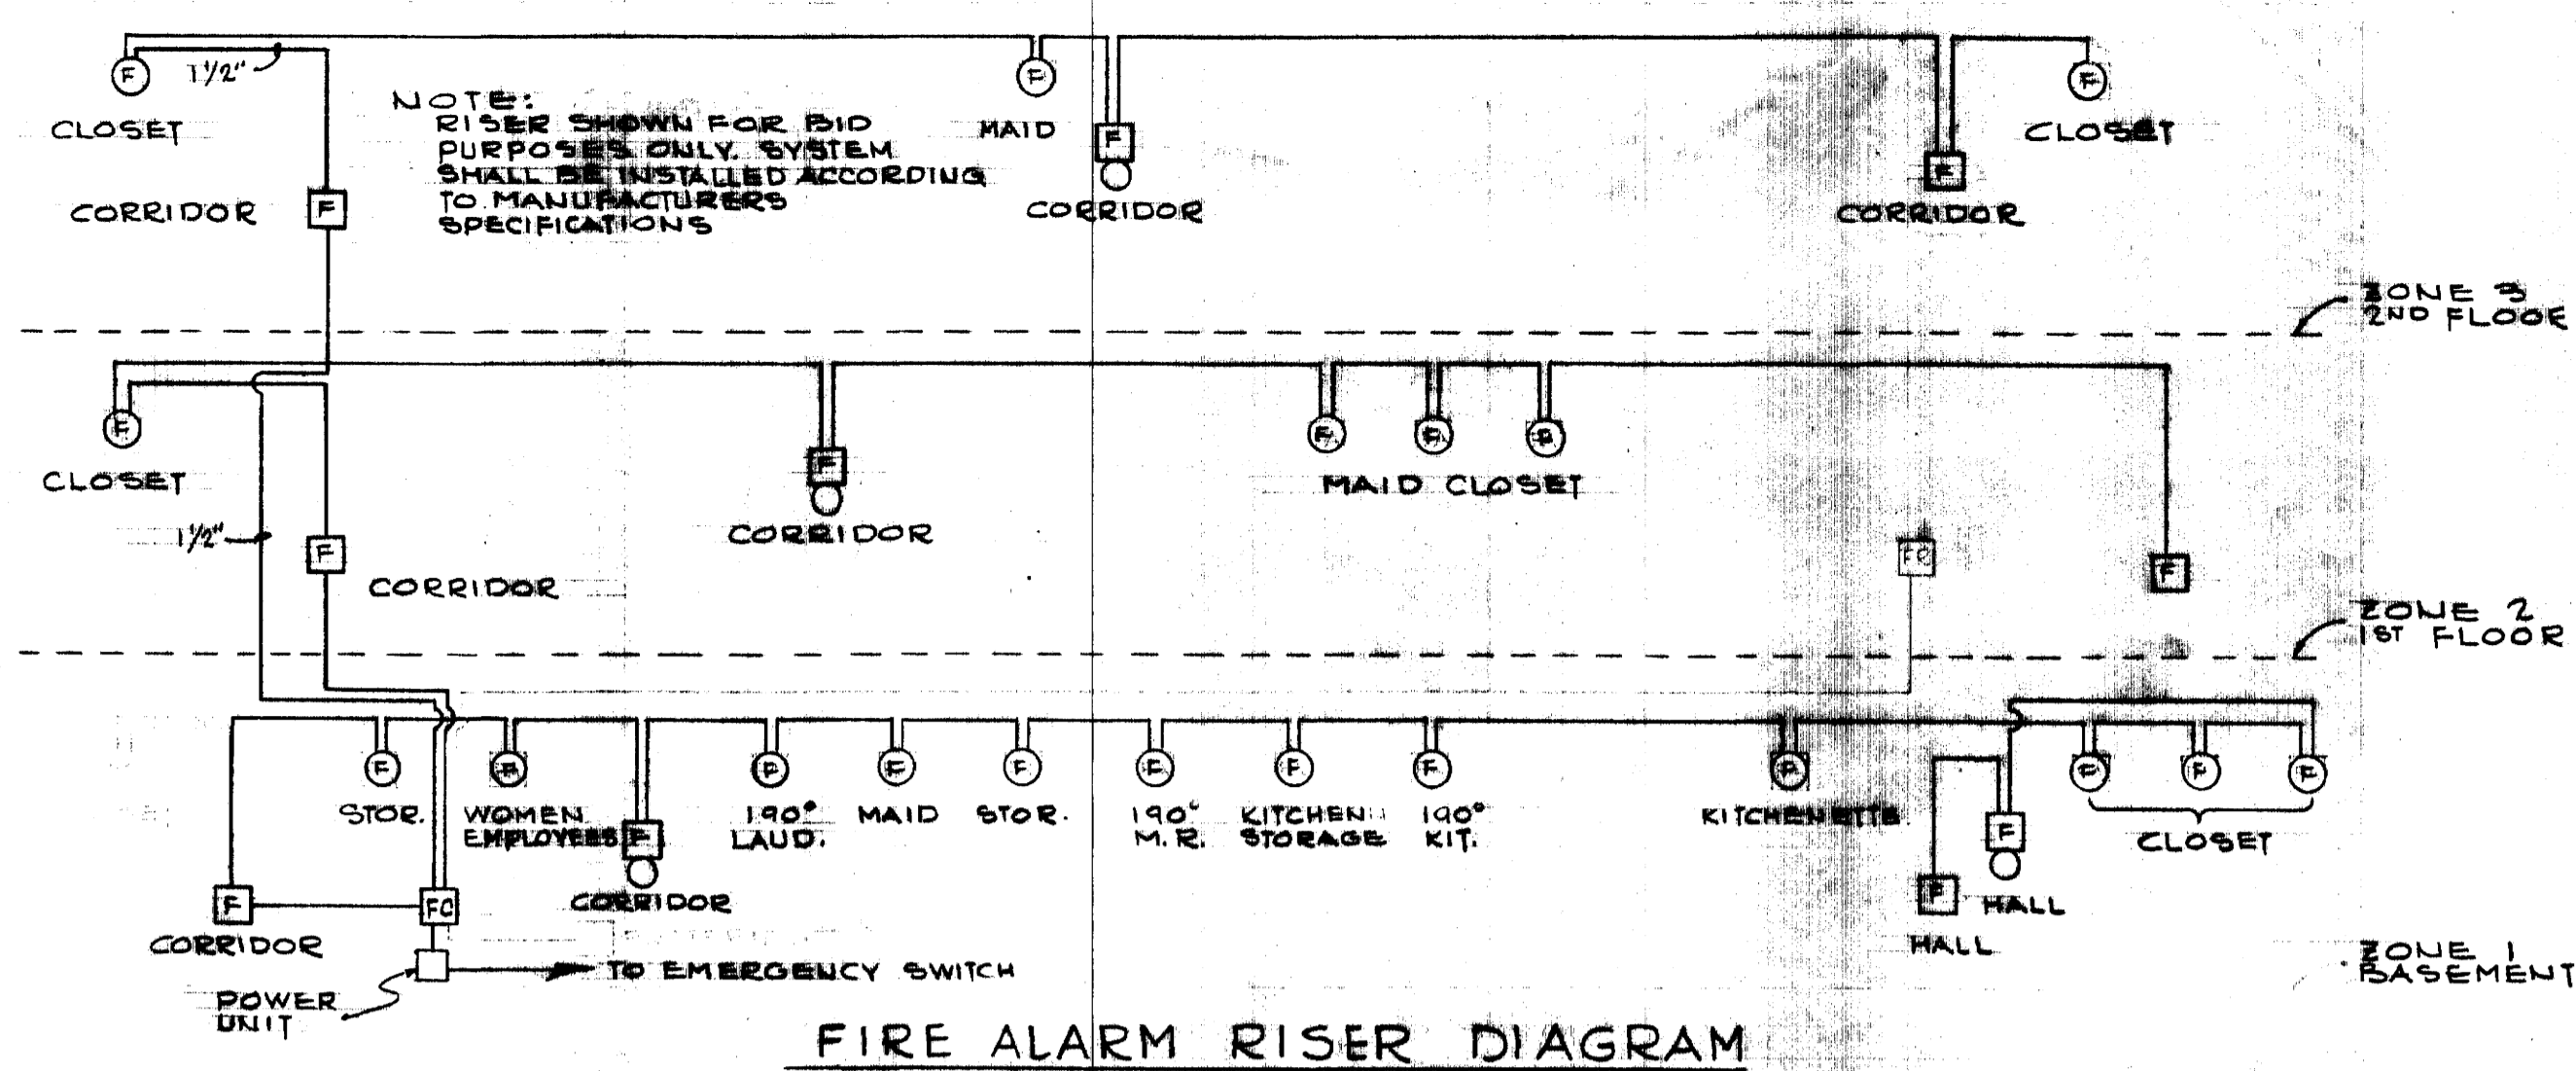


FIRE ALARM RISER DIAGRAM
N.T.S.

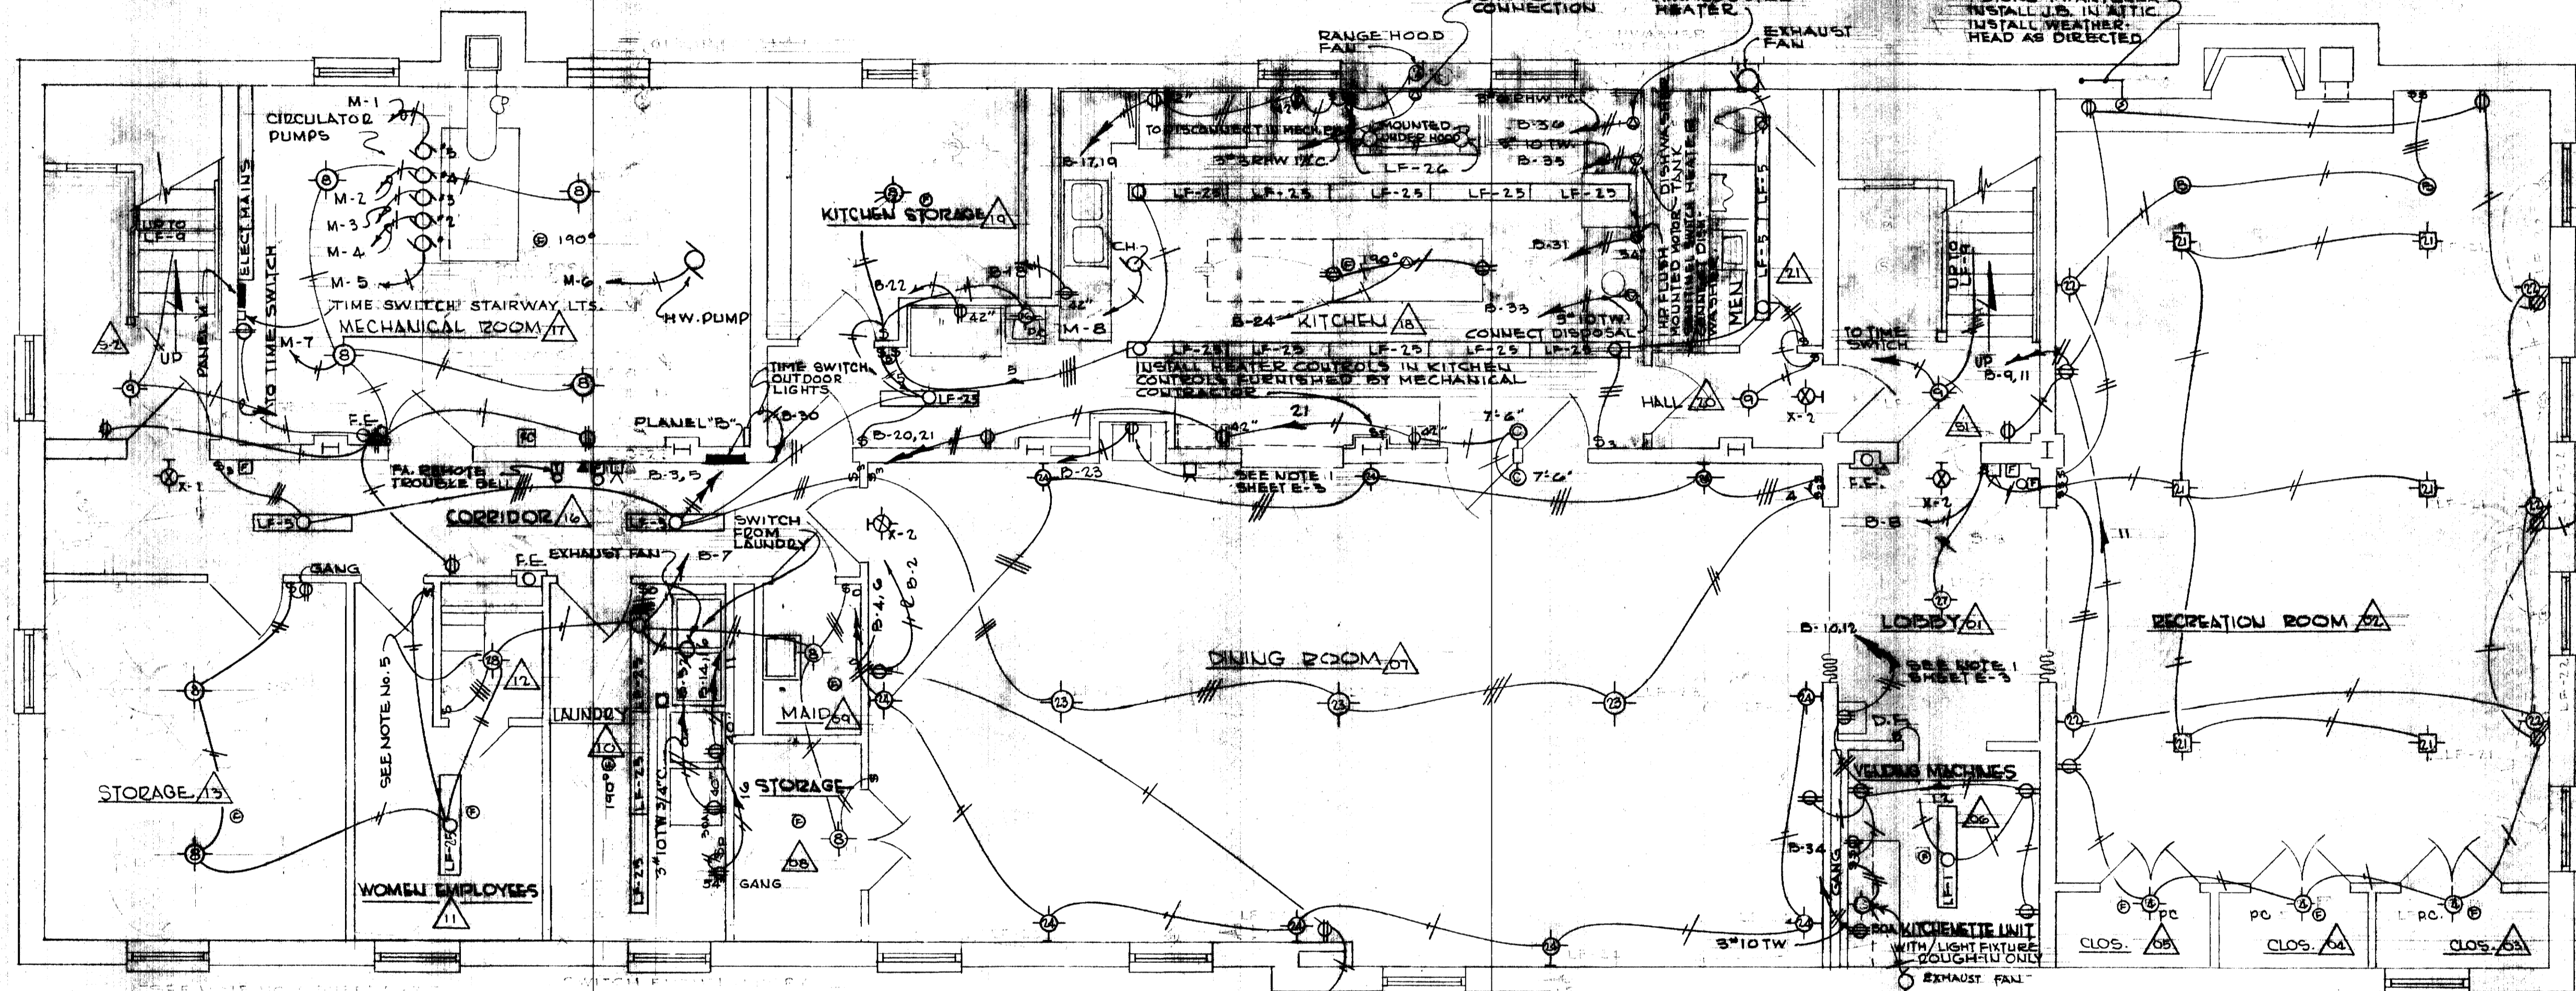

BASEMENT ELECTRICAL FLOOR PLAN
SCALE: 1/4" = 1'-0"

ELECTRICAL	SYMBOLS
FLUORESCENT LIGHT FIXTURES	Δ INTERCOM MASTER UNIT
CEILING LIGHT FIXTURE	□ ELECTRICAL PANEL
WALL BRACKET LIGHT	— DISCONNECT
RECESSED LIGHT FIXTURE	□ FIRE ALARM STATION
EXIT LIGHT	⊙ AUTOMATIC FIRE ALARM DEVICE
DUPLEX CONVENIENCE OUTLET	⊙ FIRE ALARM CONTROL PANEL
WEATHERPROOF OUTLET	⊙ FIRE ALARM BELL
240 VOLT OUTLET	⊙ PUSH BUTTON
SPECIAL PURPOSE OUTLET	□ SPEAKER
OUTLET	□ RECESSED SPEAKER
OUTLET WITH PULL SWITCH	⊙ MOTOR CONNECTION
BLANK OUTLET	⊙ FAN COIL UNIT OUTLET
CLOCK OUTLET	⊙ BELL TRANSFORMER
T.V. OUTLET	□ DOOR CHIMES
SWITCHES: SINGLE, 3 WAY, ETC.	— CONDUIT CONCEALED IN WALL & CEILING
UNIVERSITY TELEPHONE	— CONDUIT IN OR UNDER FLOOR SLAB
REMOTE FIRE ALARM ANNUNCIATOR	— HOME RUN TO PANEL
THERMOSTAT	Δ OUTSIDE TELEPHONE (DAY)

NOTE: S_o — DOUBLE POLE SINGLE THROW SWITCH.

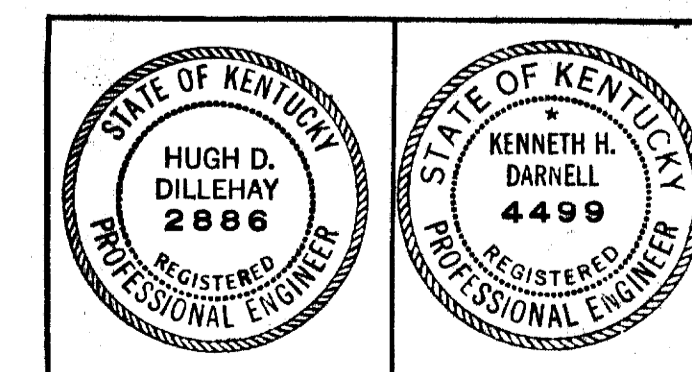

DELTA GAMMA SORORITY HOUSE
UNIVERSITY OF KENTUCKY
LEXINGTON, KENTUCKY

BASEMENT ELECTRICAL

TRACED BY: [Signature]
CHECKED BY: [Signature]
REVISIONS:

GILLIG • CHRISMAN & MILLER
ARCHITECTS ASSOCIATED
100 WALNUT STREET, LEXINGTON, KENTUCKY


COMMONWEALTH OF KENTUCKY
DEPARTMENT OF FINANCE
ENGINEERING STAFF
FRANKFORT, KENTUCKY

APPROVED BY: [Signature] DATE: 1-25-63
APPROVED BY: [Signature] DATE: 2-26-63

HUGH DILLEHAY AND ASSOCIATES
CONSULTING ENGINEERS
LEXINGTON JOB NO. 6716 KENTUCKY


DATE: 1-25-63
SCALE: AS NOTED
SPEC. NO.:
DRAWING NO.:
SHEET: C-2

U-1906

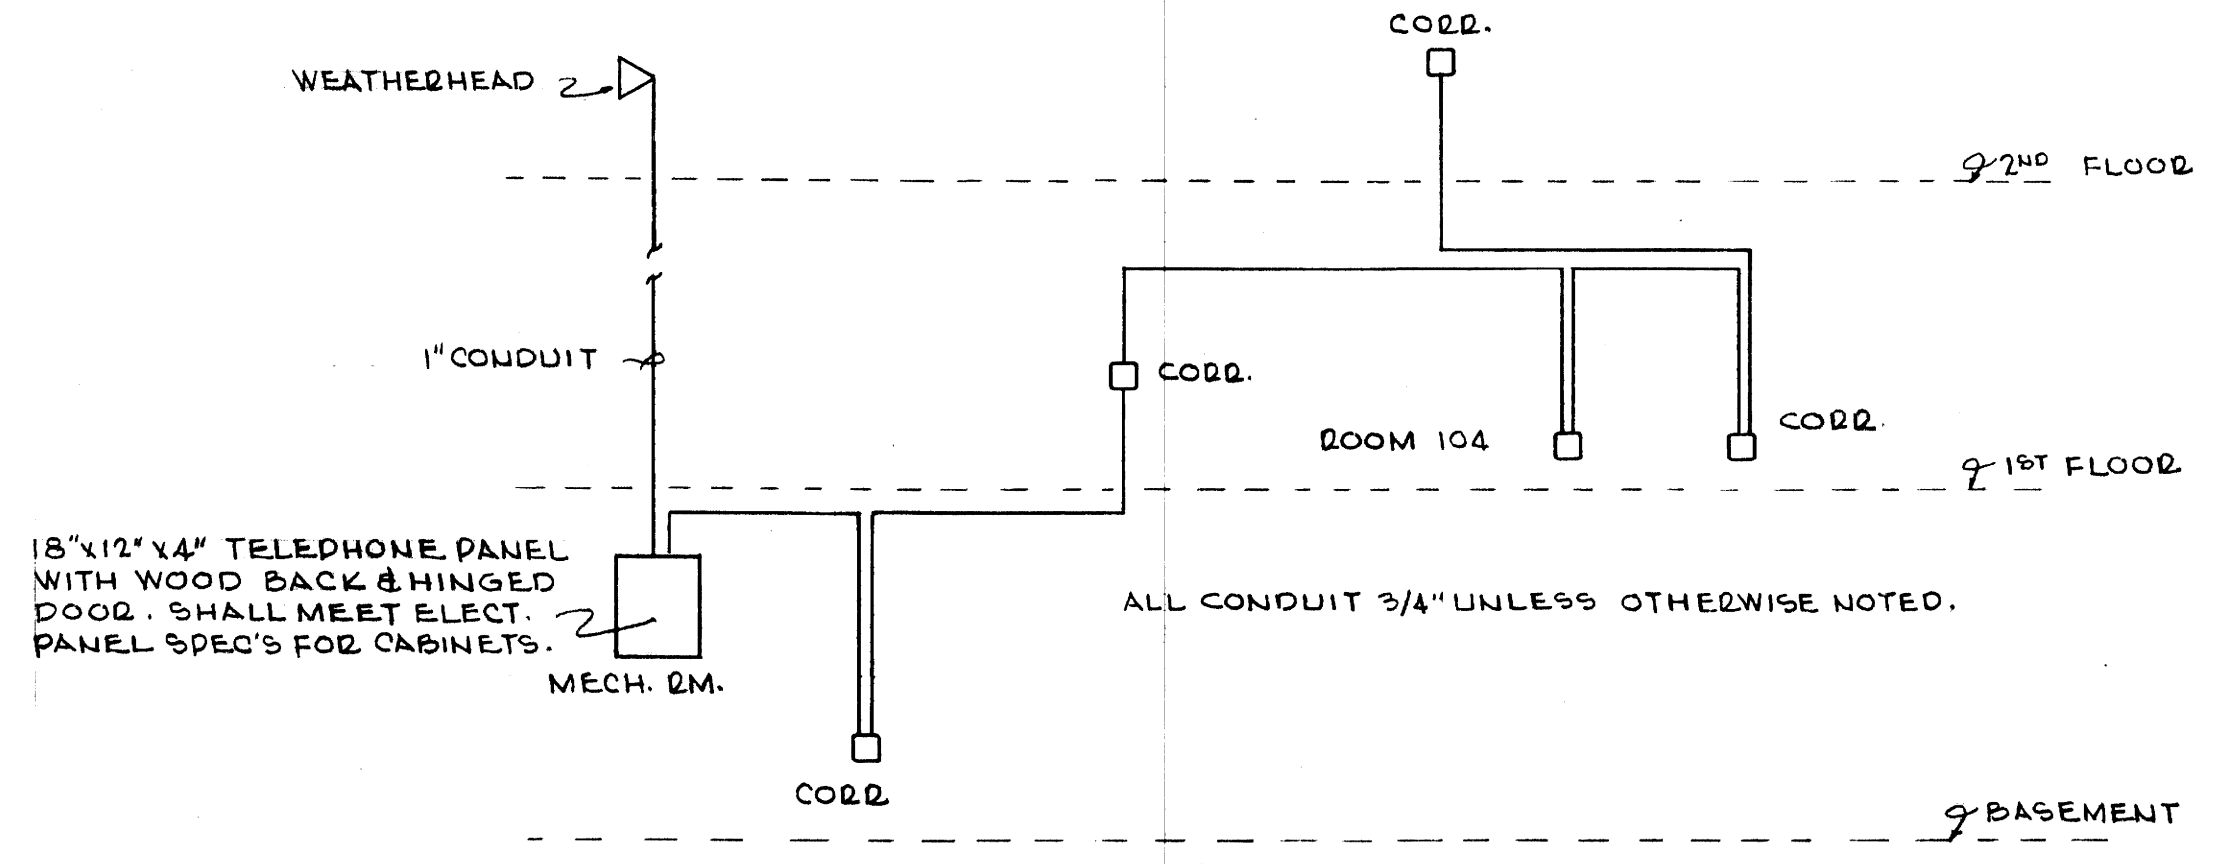


TELEPHONE RISER DIAGRAM
N.T.S.

SWITCH FURNISHED WITH LF-29, LF-30. TO BE SWITCHED WITH LIGHT PORTION OF LF-29.

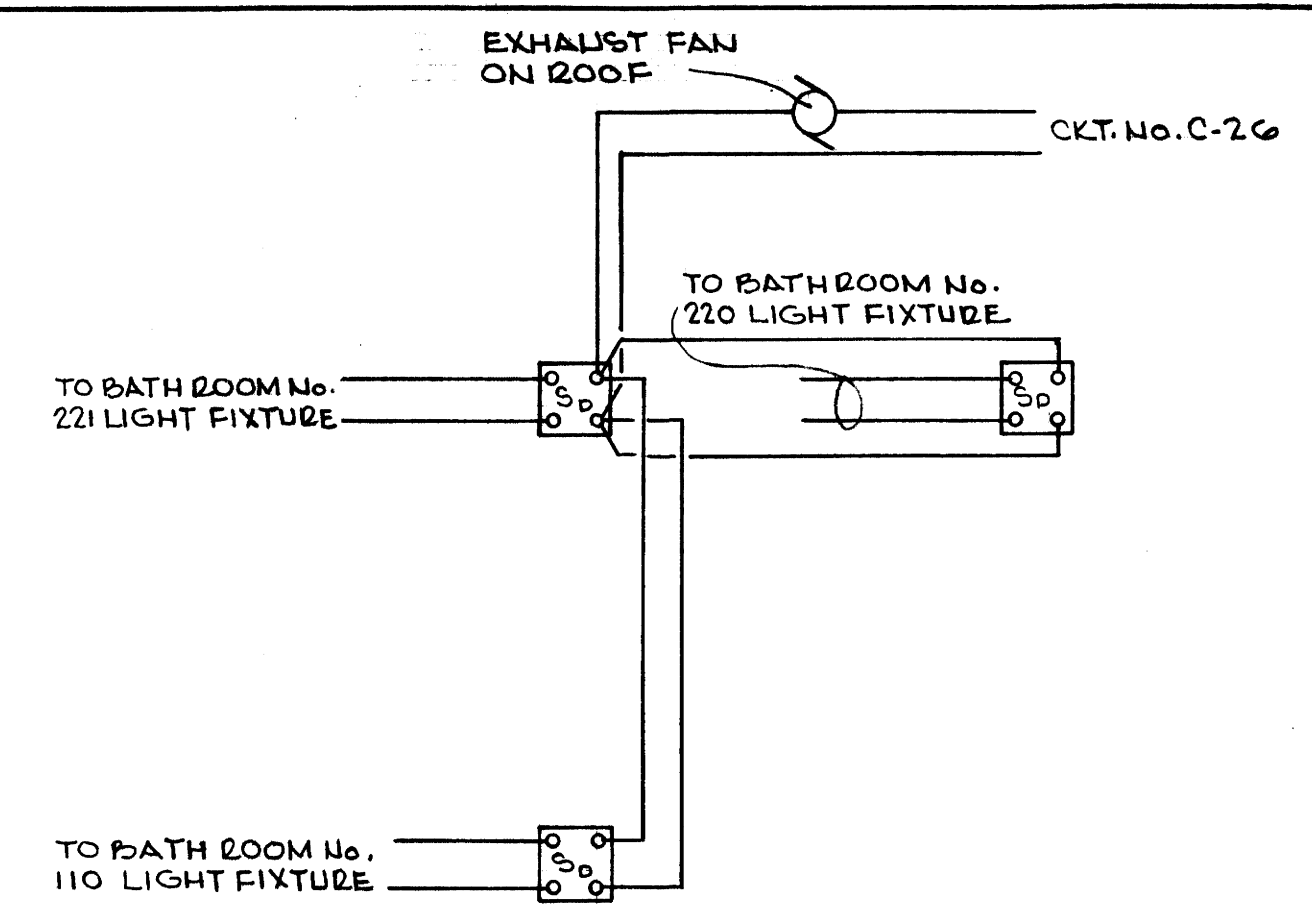


CONTROL CIRCUIT FOR EXHAUST FAN ON ROOF
N.T.S.

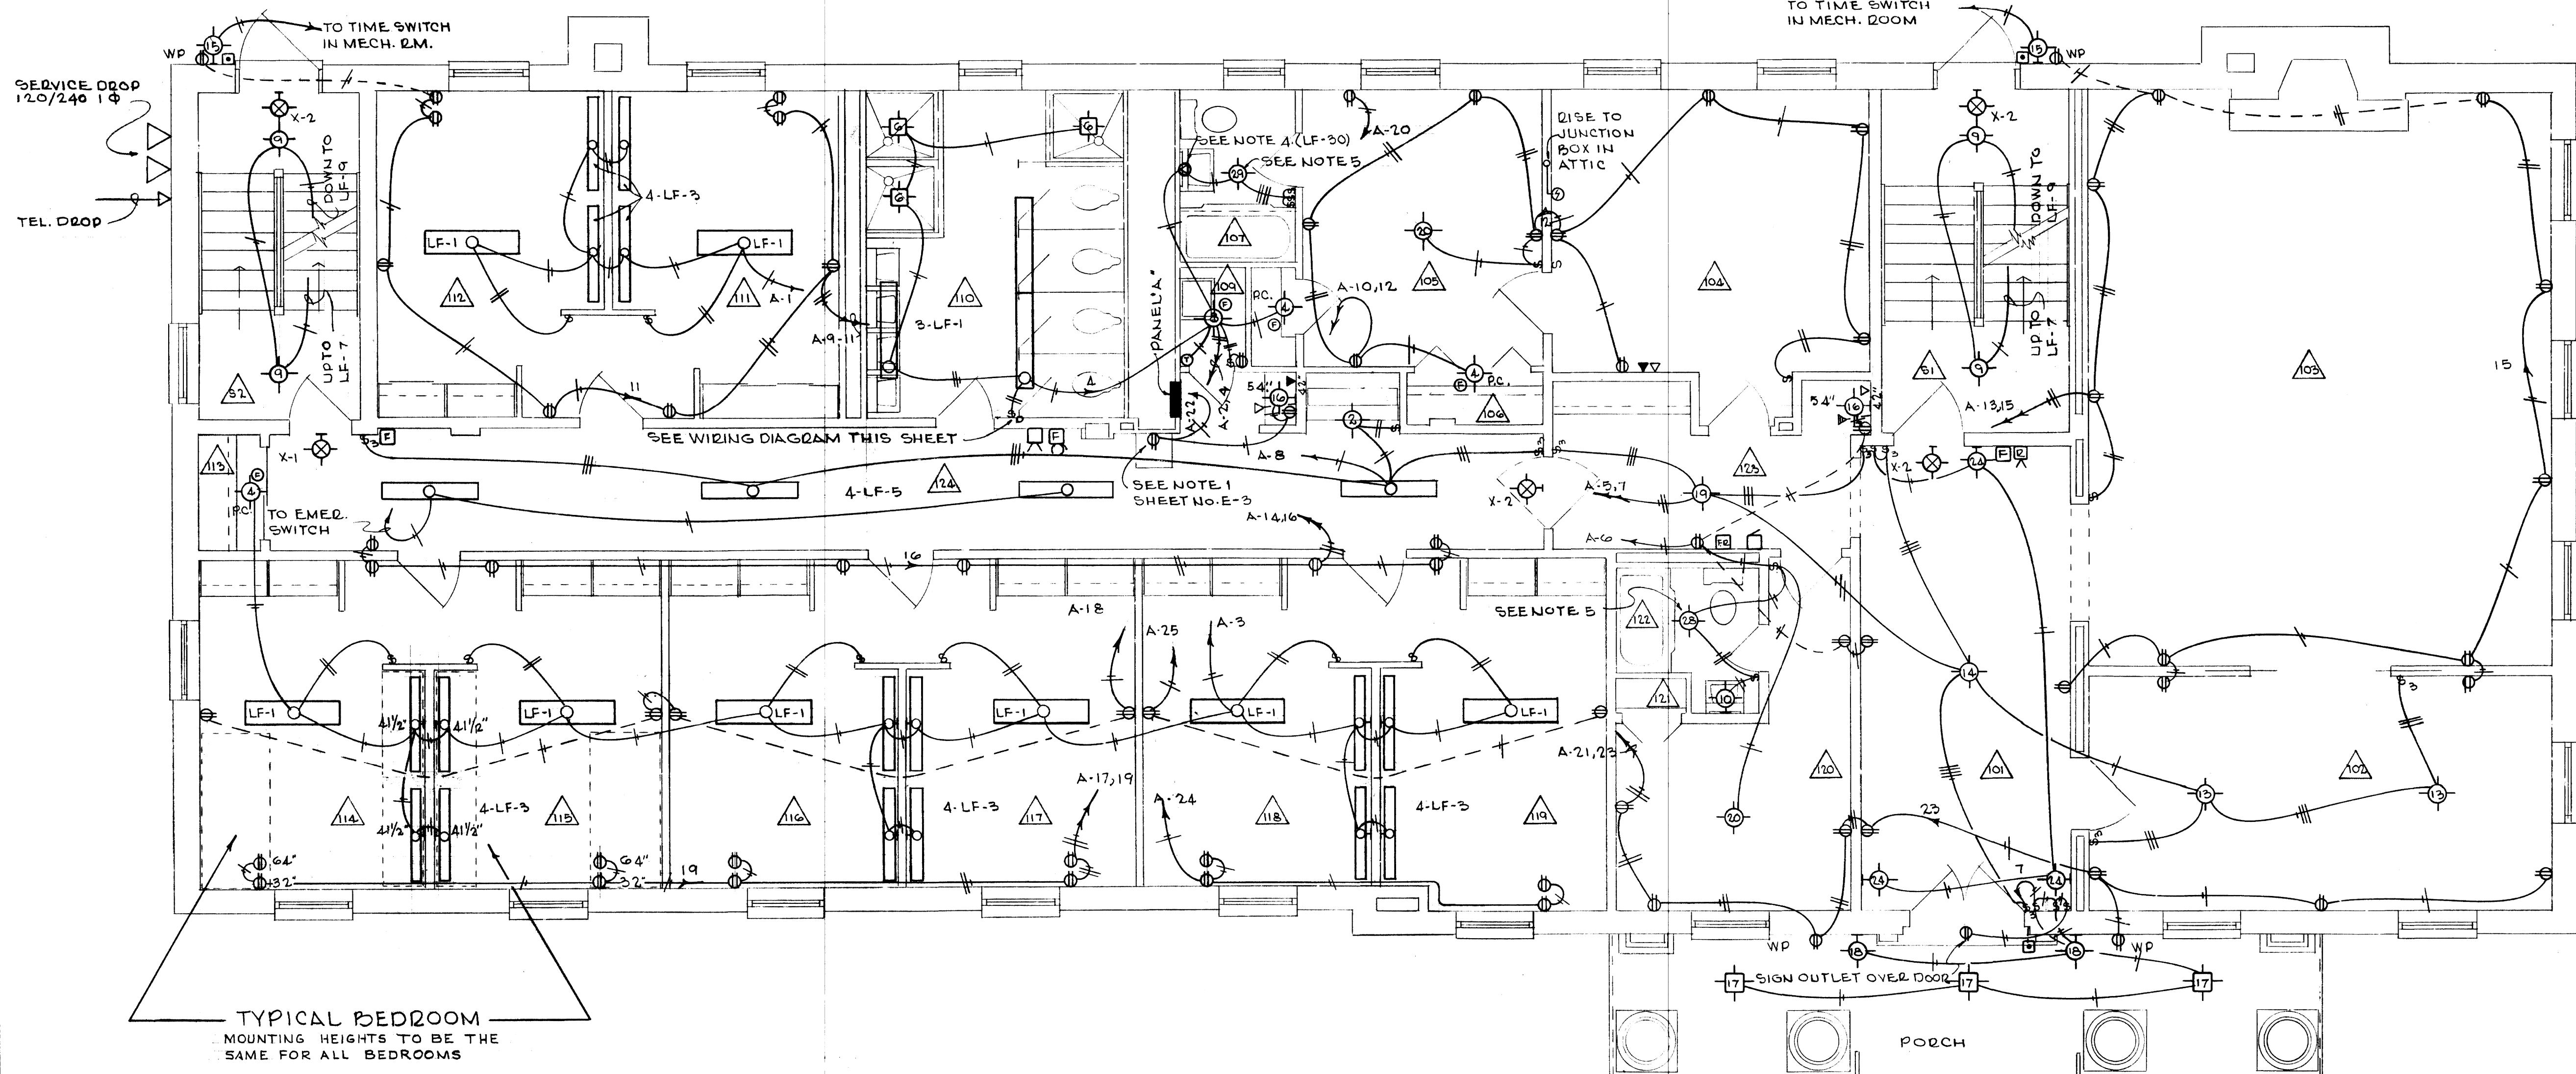

FIRST FLOOR ELECTRICAL PLAN
SCALE: 1/4"=1'-0"

TYPICAL BEDROOM
MOUNTING HEIGHTS TO BE THE SAME FOR ALL BEDROOMS

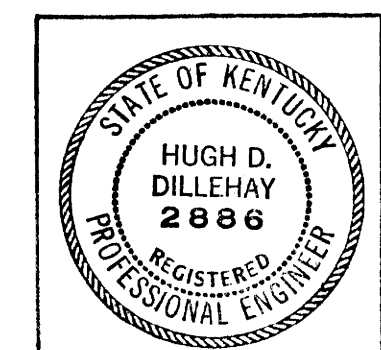

HUGH DILLEHAY AND ASSOCIATES
CONSULTING ENGINEERS
LEXINGTON JOB # 6226 KENTUCKY

DELTA GAMMA SORORITY HOUSE UNIVERSITY OF KENTUCKY LEXINGTON, KENTUCKY		
DESIGNED BY K.H.D.	DRAWN BY B.G.D.	DATE 1-25-63
CHECKED BY K.H.D.		SCALE 1/4"=1'-0"
SPEC. NO.		
DRAWING NO.		
APPROVED BY <i>W.V. McConnell</i>		
DATE 2-5-63		

008112


U-1907

NOTES:


1. WATER COOLED VERIFY ROUGH-IN WITH MECHANICAL CONTRACTOR.
2. VERIFY EXACT LOCATION OF EXHAUST FANS WITH MECH. CONTR. CONTROL LEG & CONTROLS FURNISHED UNDER OTHER SECTIONS OF THIS CONTRACT.
3. ALL OUTLETS 16" FROM FLOOR TO BOTTOM OF OUTLET BOXES, SWITCHES 18" UNLESS OTHERWISE NOTED ON DRAWINGS.
4. ELECTRICAL CONTR. TO FURNISH & INSTALL MEDICINE CABINET.
5. MECHANICAL CONTR. WILL FURNISH & INSTALL DUCT WORK FOR LF-28 & LF-29.
6. LF-3 BOX CENTERS TO BE LOCATED 41 1/2" ABOVE FINISHED FLOOR.

BREAKER SCHEDULE

PANEL	CKT NO.	BREAKER SIZE	NO. OF POLES
A	1-32	20A	1P
B	1-30	20A	1P
	31	20A	2P
	32-35	30A	2P
	36	50A	2P
C	1-32	20A	1P
M	1-10	20A	1P

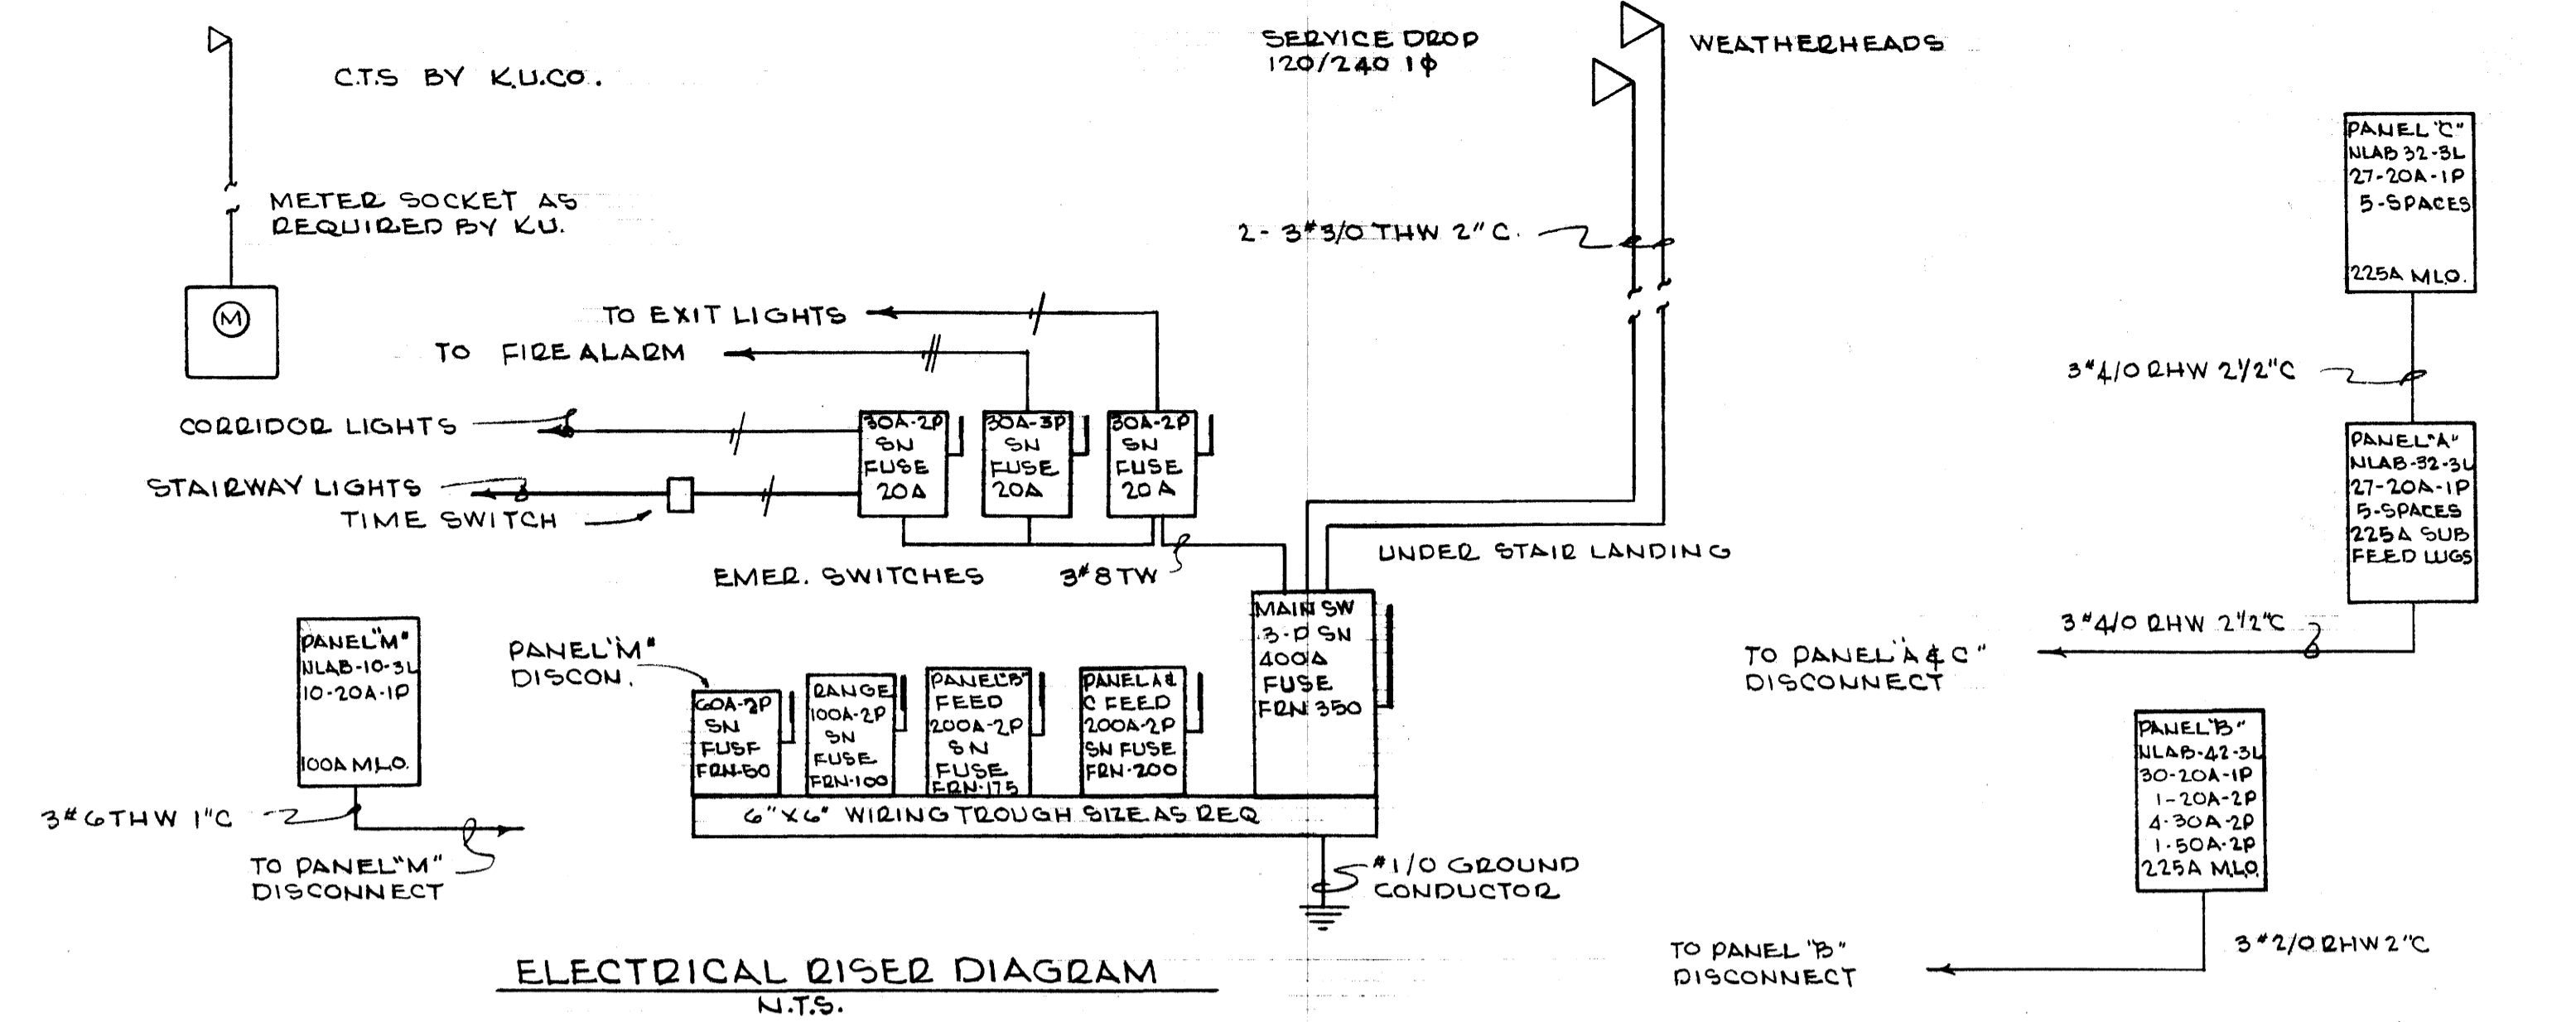



ELECTRICAL RISED DIAGRAM
N.T.S.

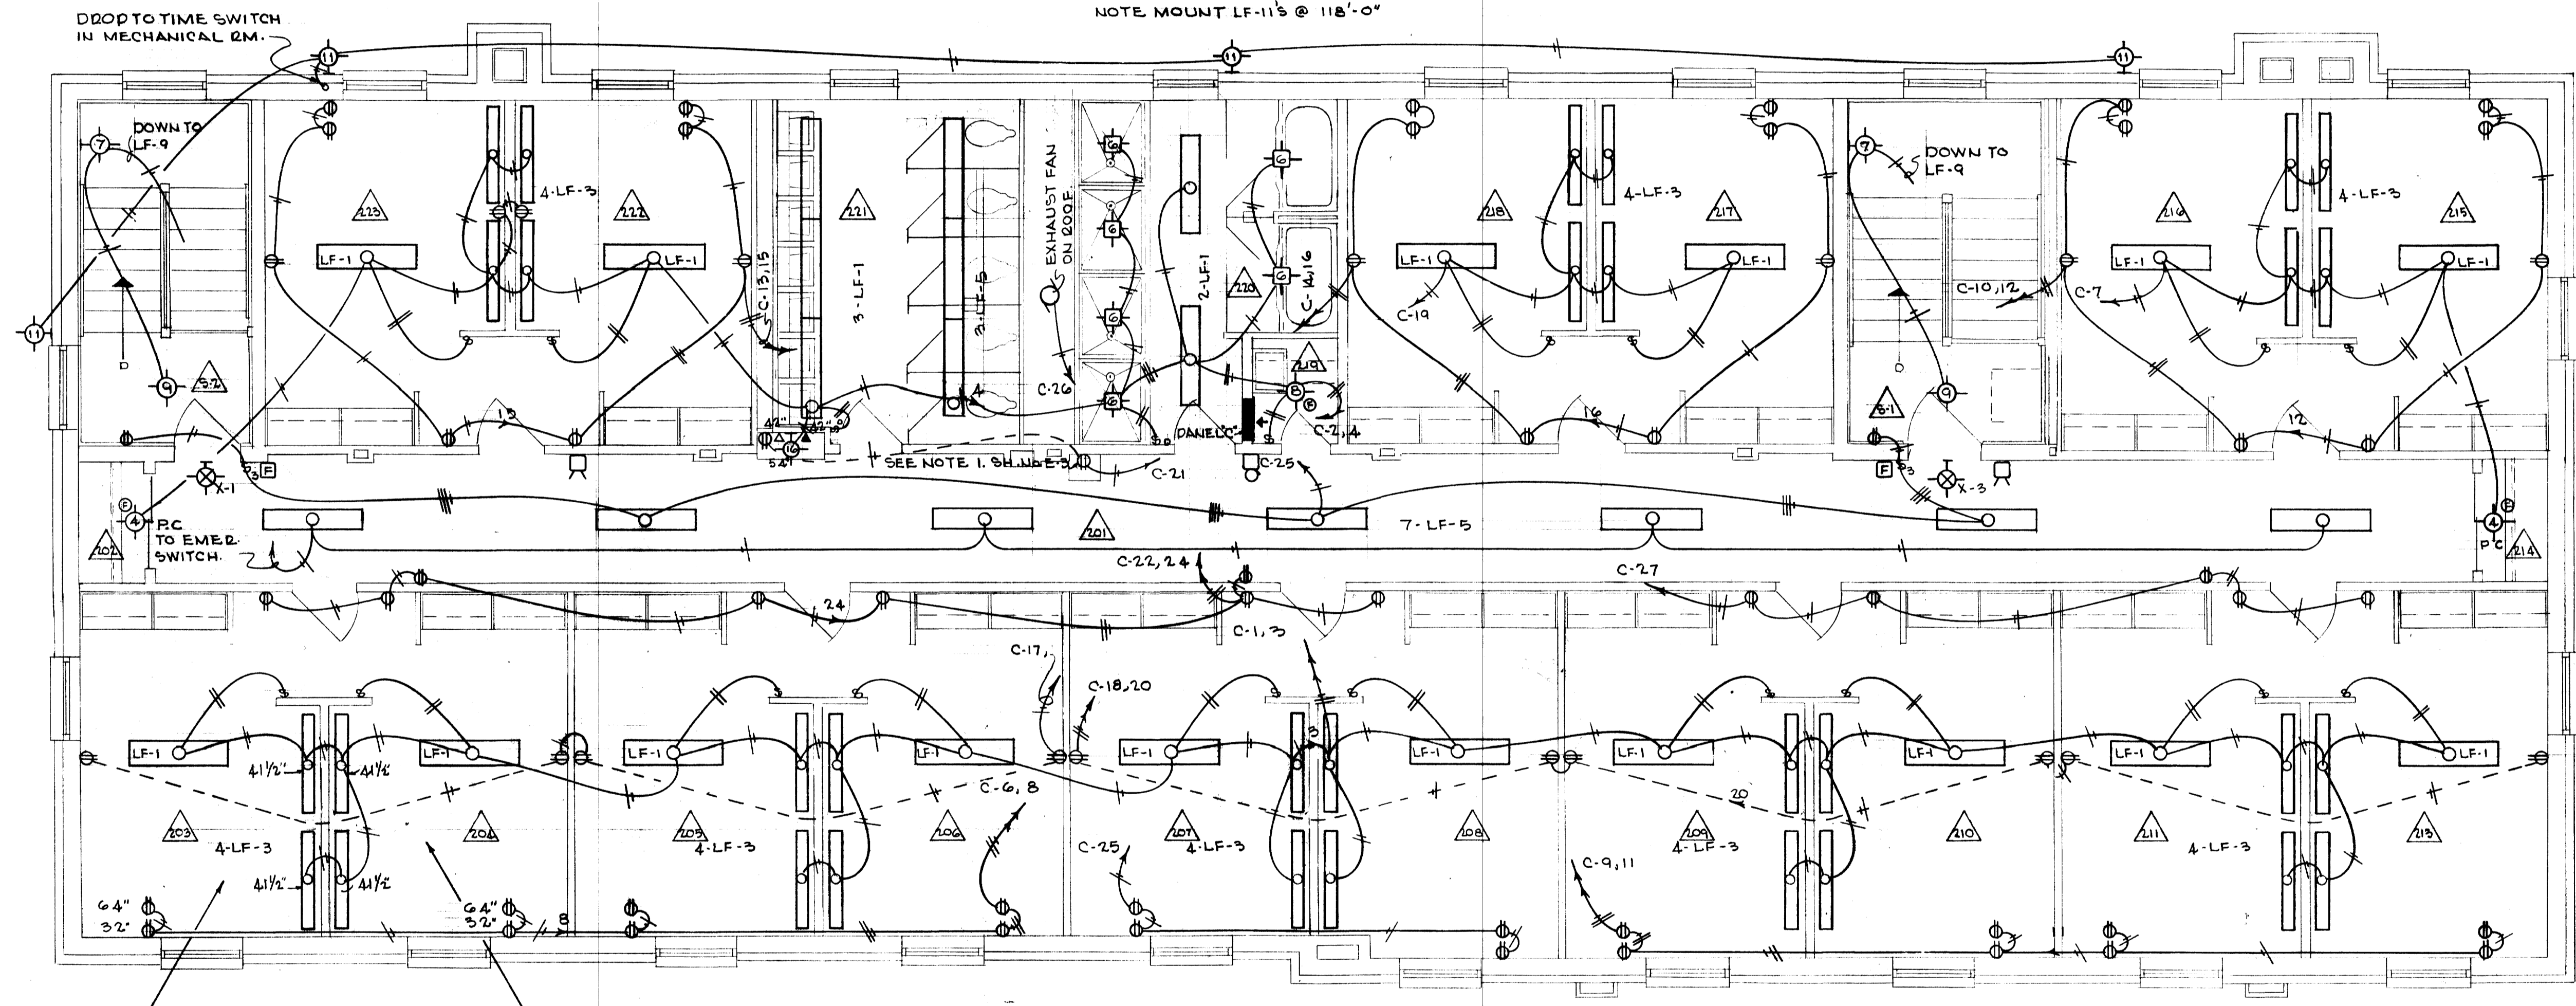

SECOND FLOOR ELECTRICAL PLAN
SCALE: 1/8"=1'-0"

LIGHT FIXTURE SCHEDULE

LF-1 SUNBEAM No. QPCX7402 WITH 2-F40T12/WW	LF-14 MOE No. 1560 WITH 5-25 WATT F/W	LF-27 MOE No. M-1915-1/M-2103 WITH 1-100 WATT
LF-2 LITECRAFT No. FG-98W WITH 1-75 WATT	LF-15 MOE No. 883-7 WITH 1-75 WATT	LF-28 NUTONE No. 8660 FAN & LIGHT UNIT WITH 1-100 WATT
LF-3 ALKCO No. 3225-C-5W WITH 2-20W/T6	LF-16 MOE No. 312 WITH 1-F20/WW	LF-29 NUTONE No. 9110 FAN, HEATER & LIGHT UNIT WITH 1-100 WATT
LF-4 ALABAX No. AL-2007-ND WITH 1-100 WATT	LF-17 MOE No. M-4039 WITH 4-40 WATT	LF-30 CHARLES PARKER No. 7010HFL CABINET UNIT
LF-5 SUNBEAM No. QPCX7401 WITH 1-F40T12/WW	LF-18 MOE No. M-812-7 WITH 1-60 WATT	
LF-6 LITECRAFT No. D-840 WITH 1-75 WATT	LF-19 MOE No. M-1915-1/M-2101 WITH 1-75 WATT	X-1 MILLED No. SE1600 WITH 4-7C7
LF-7 PRESCOLITE No. WB-10(GRAY) WITH 1-100 WATT	LF-20 MOE No. M-4039 WITH 4-40 WATT	X-2 MILLED No. SB1600 WITH 4-7C7
LF-8 ALABAX No. AL-2011 WITH 1-100 WATT	LF-21 PRESCOLITE No. 479-584 WITH 1-150 WATT	X-3 MILLED No. SE 2600 WITH 4-7C7
LF-9 PRESCOLITE No. WB-2-2(GRAY) WITH 2-60 WATT	LF-22 PRESCOLITE No. 60-96(BROWN) WITH 1-75 WATT	
LF-10 PRESCOLITE No. WB-19 WITH 2-75 WATT	LF-23 FRAMBURG No. 2665 O.A.L 16" WITH 5-40 WATT	
LF-11 STEBED No. S-500Z WITH 2-150 PAR 38/SP	LF-24 LITECRAFT No. C-307 WITH 2-40 WATT	
LF-12 PRESCOLITE No. AL-5 WITH CAST HOUSING WITH 1-15 WATT	LF-25 SUNBEAM No. 202-4825 WITH 2-F40T12/WW	
LF-13 MOE No. M-1936 WITH 2-60 WATT	LF-26 BENJAMIN No. 71.41 WITH 1-100 WATT	

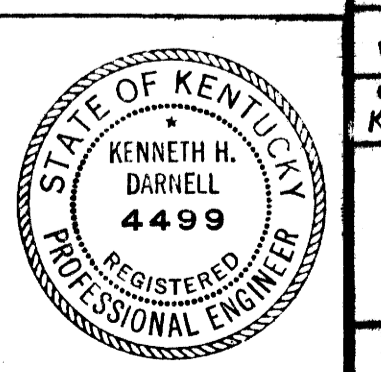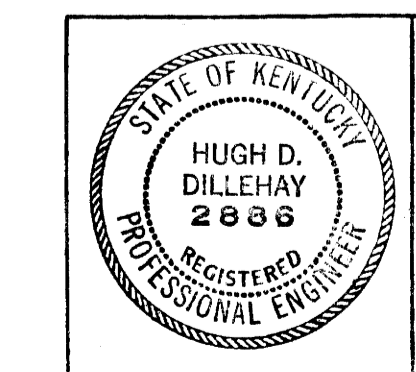

DELTA GAMMA SORORITY HOUSE
UNIVERSITY OF KENTUCKY
LEXINGTON KENTUCKY

DATE 1-25-63
SCALE 1/8"=1'-0"
SPEC. NC

GILLIG • CHRISMAN & MILLER
ARCHITECTS ASSOCIATED
180 WALNUT STREET
LEXINGTON, KENTUCKY

COMMONWEALTH OF KENTUCKY
DEPARTMENT OF FINANCE
ENGINEERING STAFF
FRANKFORT KENTUCKY

APPROVED BY: *Wm. Mc Connell* DATE 3-5-63
CHIEF OF STAFF

008113

U-1908