


04-14-14

BRN

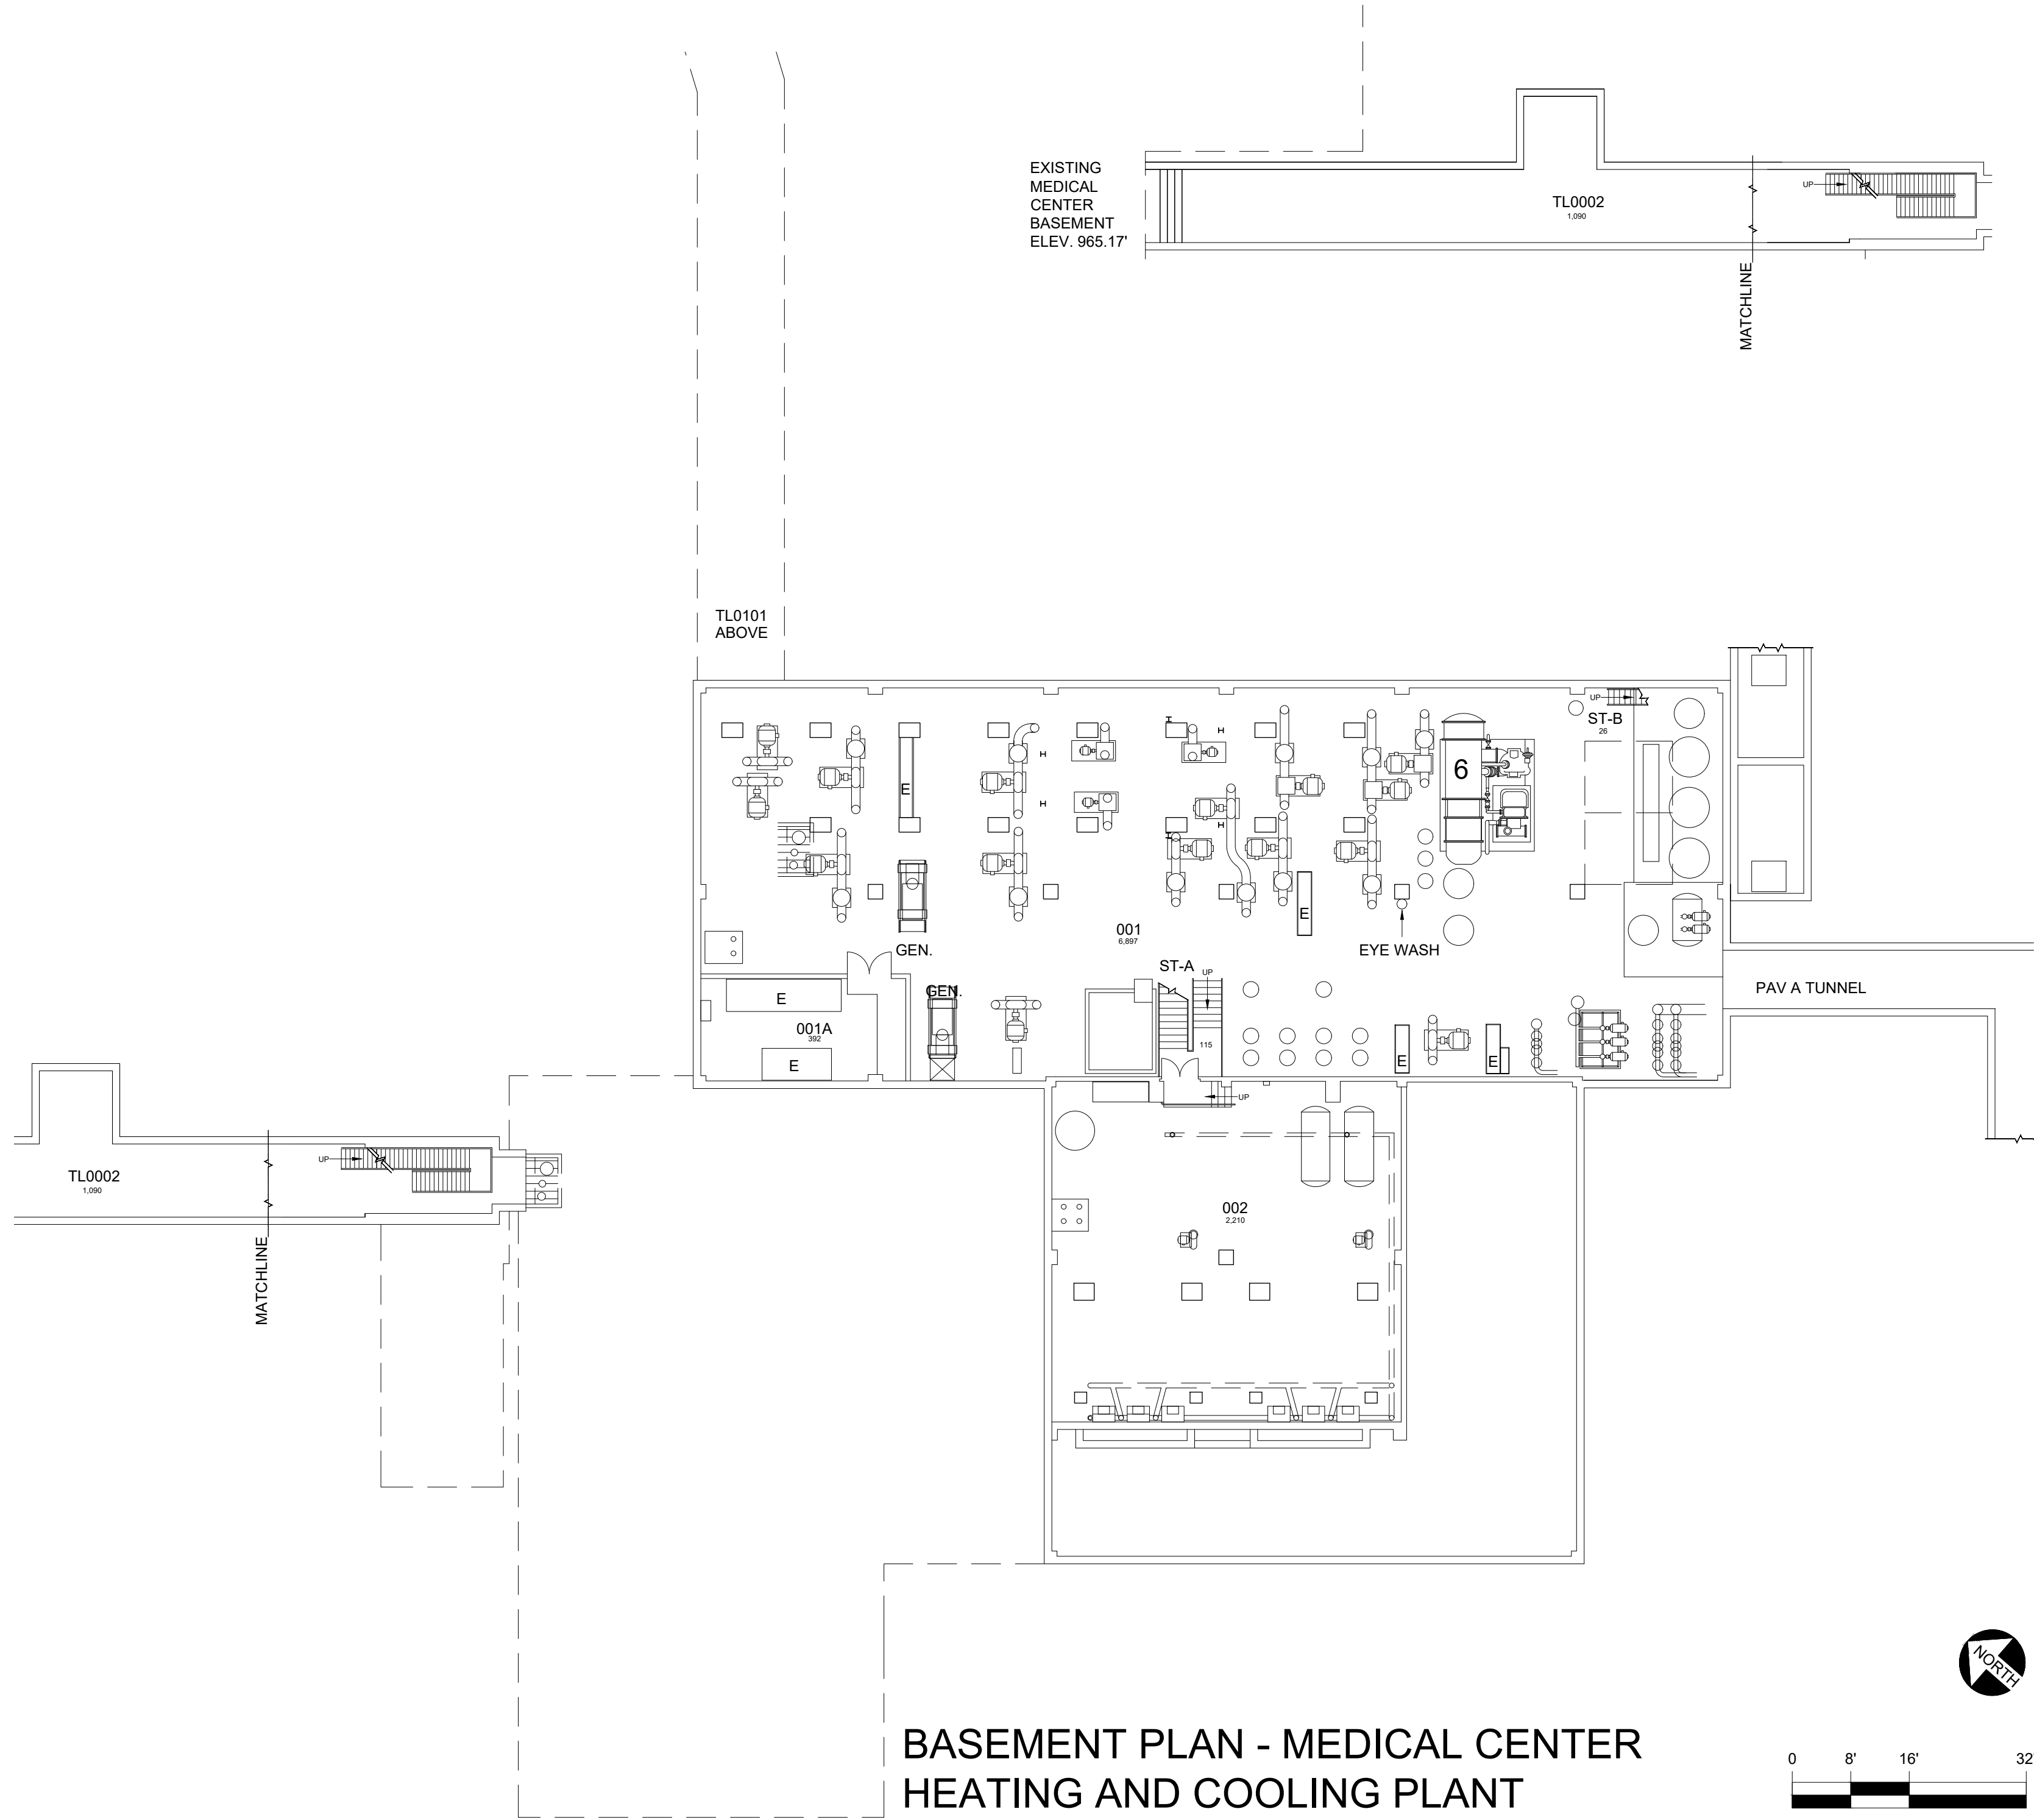

EXISTING
MEDICAL
CENTER
BASEMENT
ELEV. 965.17'

TL0002
1,090

TL0101
ABOVE


MATCHLINE

MATCHLINE

TL0002
1,090

**BASEMENT PLAN - MEDICAL CENTER
HEATING AND COOLING PLANT**

 11,817 Gross Square Ft




DATE:
11-14-05
DRAWN BY:
LHR

BLDG #:
0085

**MED. CTR. HEATING & COOLING PLANT
KEY DRAWING**

UNIVERSITY OF KENTUCKY
ITS Information Services

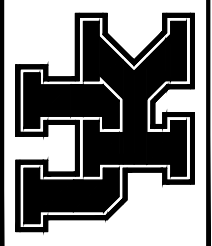

SHEET
1 of 6


TO [0298] WILLIAM R. WILLARD
MEDICAL EDUCATION BLDG

MATCHLINE

110 PUMP ROOM


TL1
2,761

TL1
TL0101
2,761

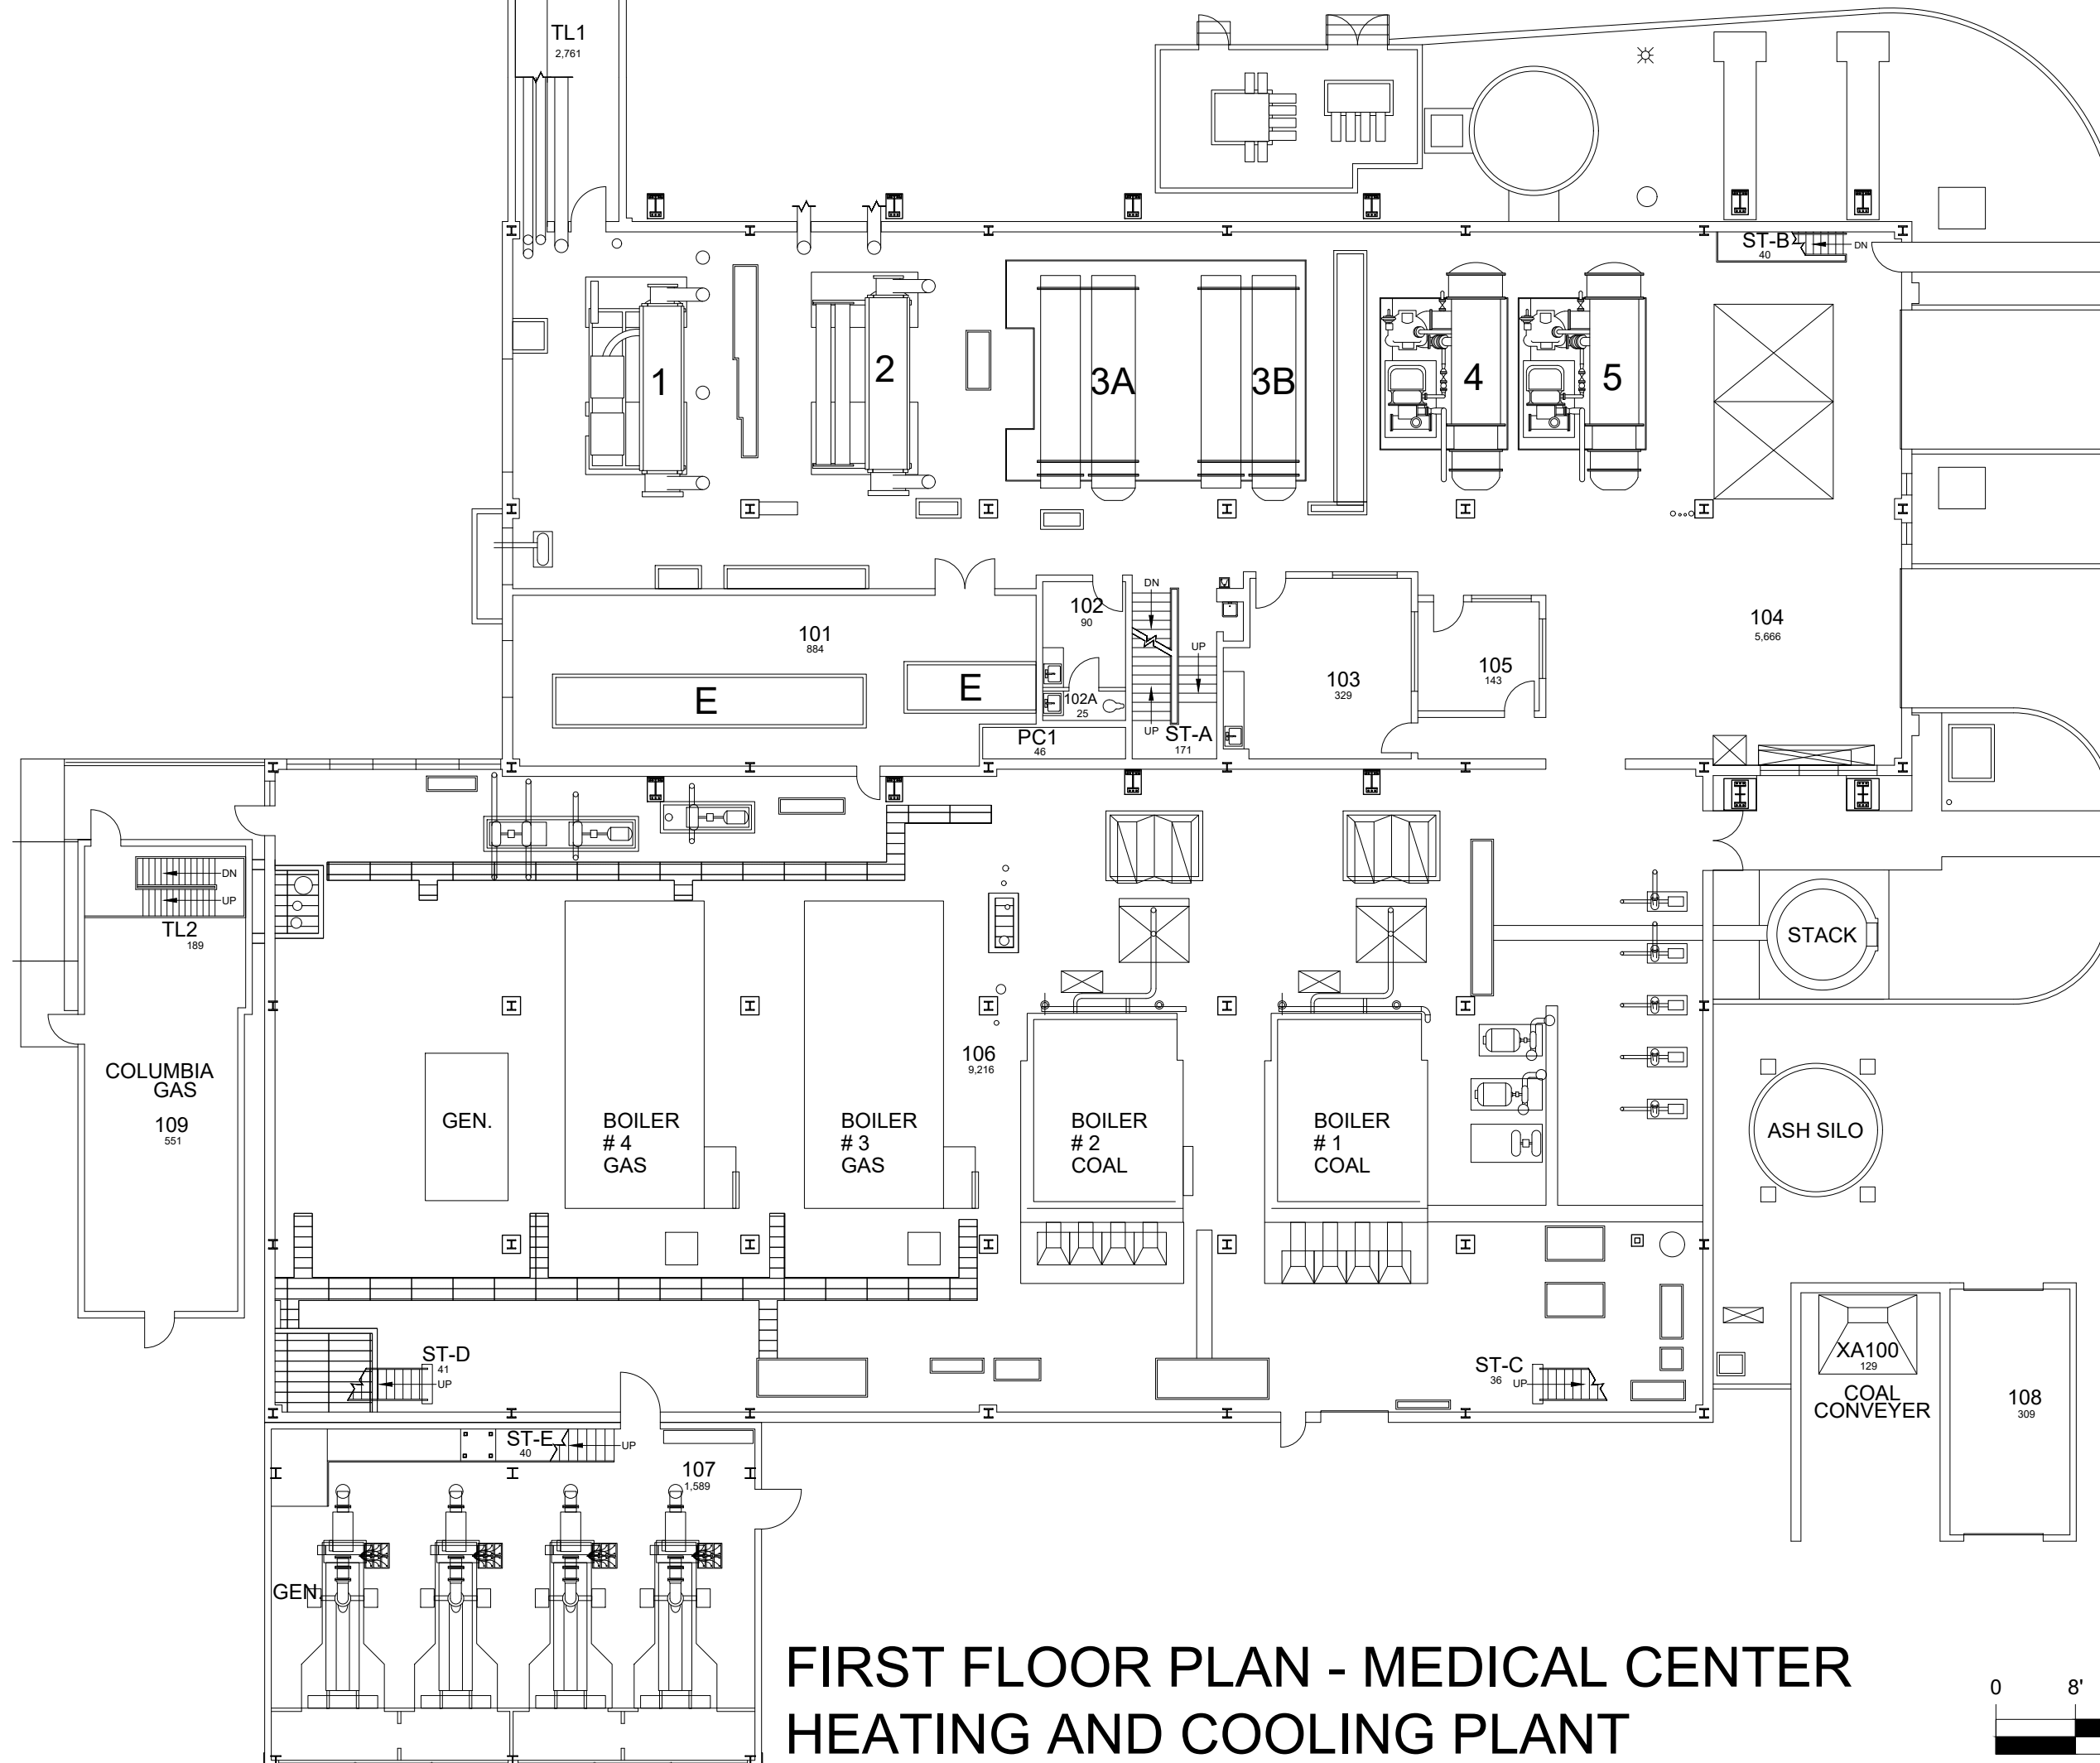

**FIRST FLOOR PLAN - MEDICAL CENTER
HEATING AND COOLING PLANT**

 23,728 Gross Square Ft




DATE:
11-14-05
DRAWN BY:
LHR

BLDG #:
0085

**MED. CTR. HEATING & COOLING PLANT
KEY DRAWING**

UNIVERSITY OF KENTUCKY
ITS Information Services

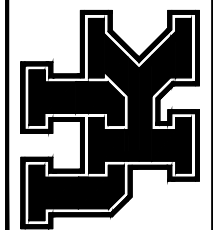

SHEET
2 of 6

6/8/21


JES

DATE:
11-14-05
DRAWN BY:
LHR


BLDG #:
0085

MED. CTR. HEATING & COOLING PLANT
KEY DRAWING

UNIVERSITY OF KENTUCKY
ITS Information Services

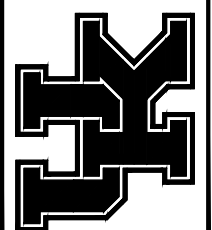

SHEET
3 of 6

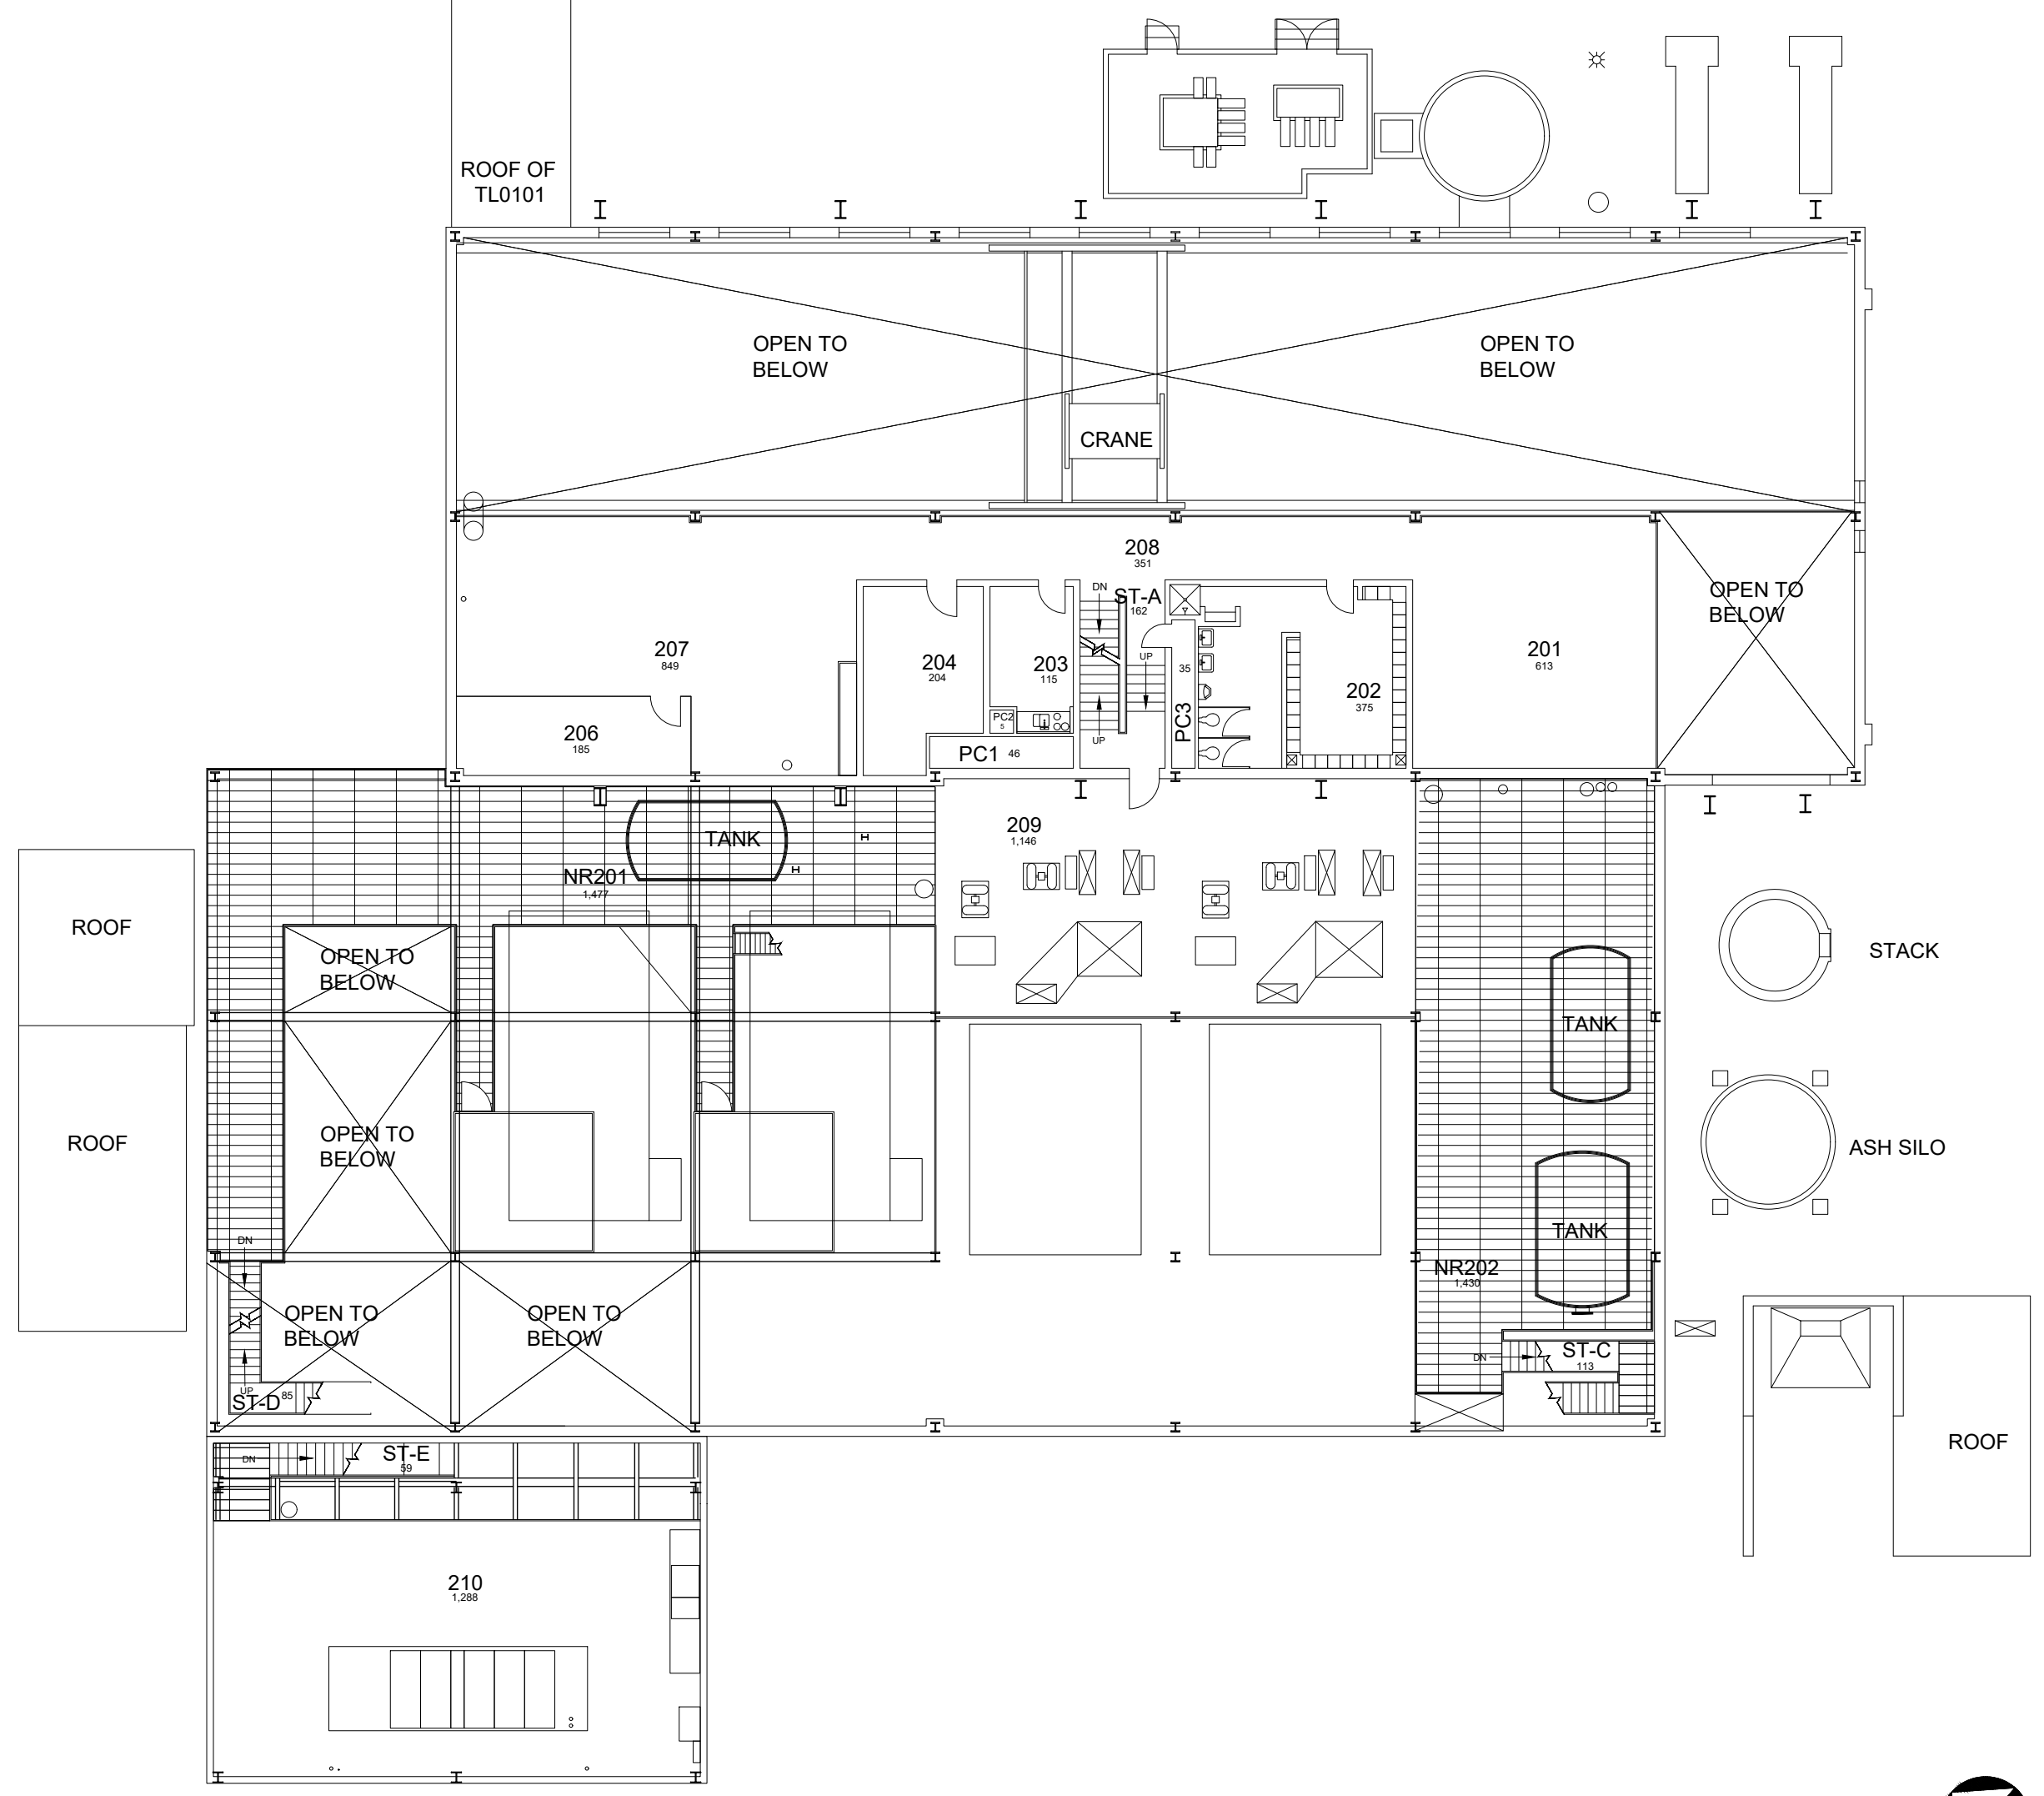

SECOND FLOOR MEZZANINE
MEDICAL CENTER HEATING AND COOLING PLANT
9,396 Gross Square Ft

3-14-16


ALK

DATE:
11-14-05
DRAWN BY:
LHR

BLDG #:
0085


MED. CTR. HEATING & COOLING PLANT
KEY DRAWING

UNIVERSITY OF KENTUCKY
ITS Information Services

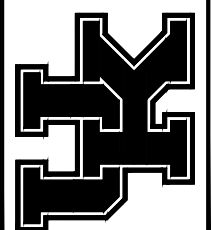

SHEET
4 of 6


- LEGEND
- LIGHT
 - PLUMBING VENT
 - ROOF DRAIN
 - FAN
 - INTAKE/EXHAUST OR

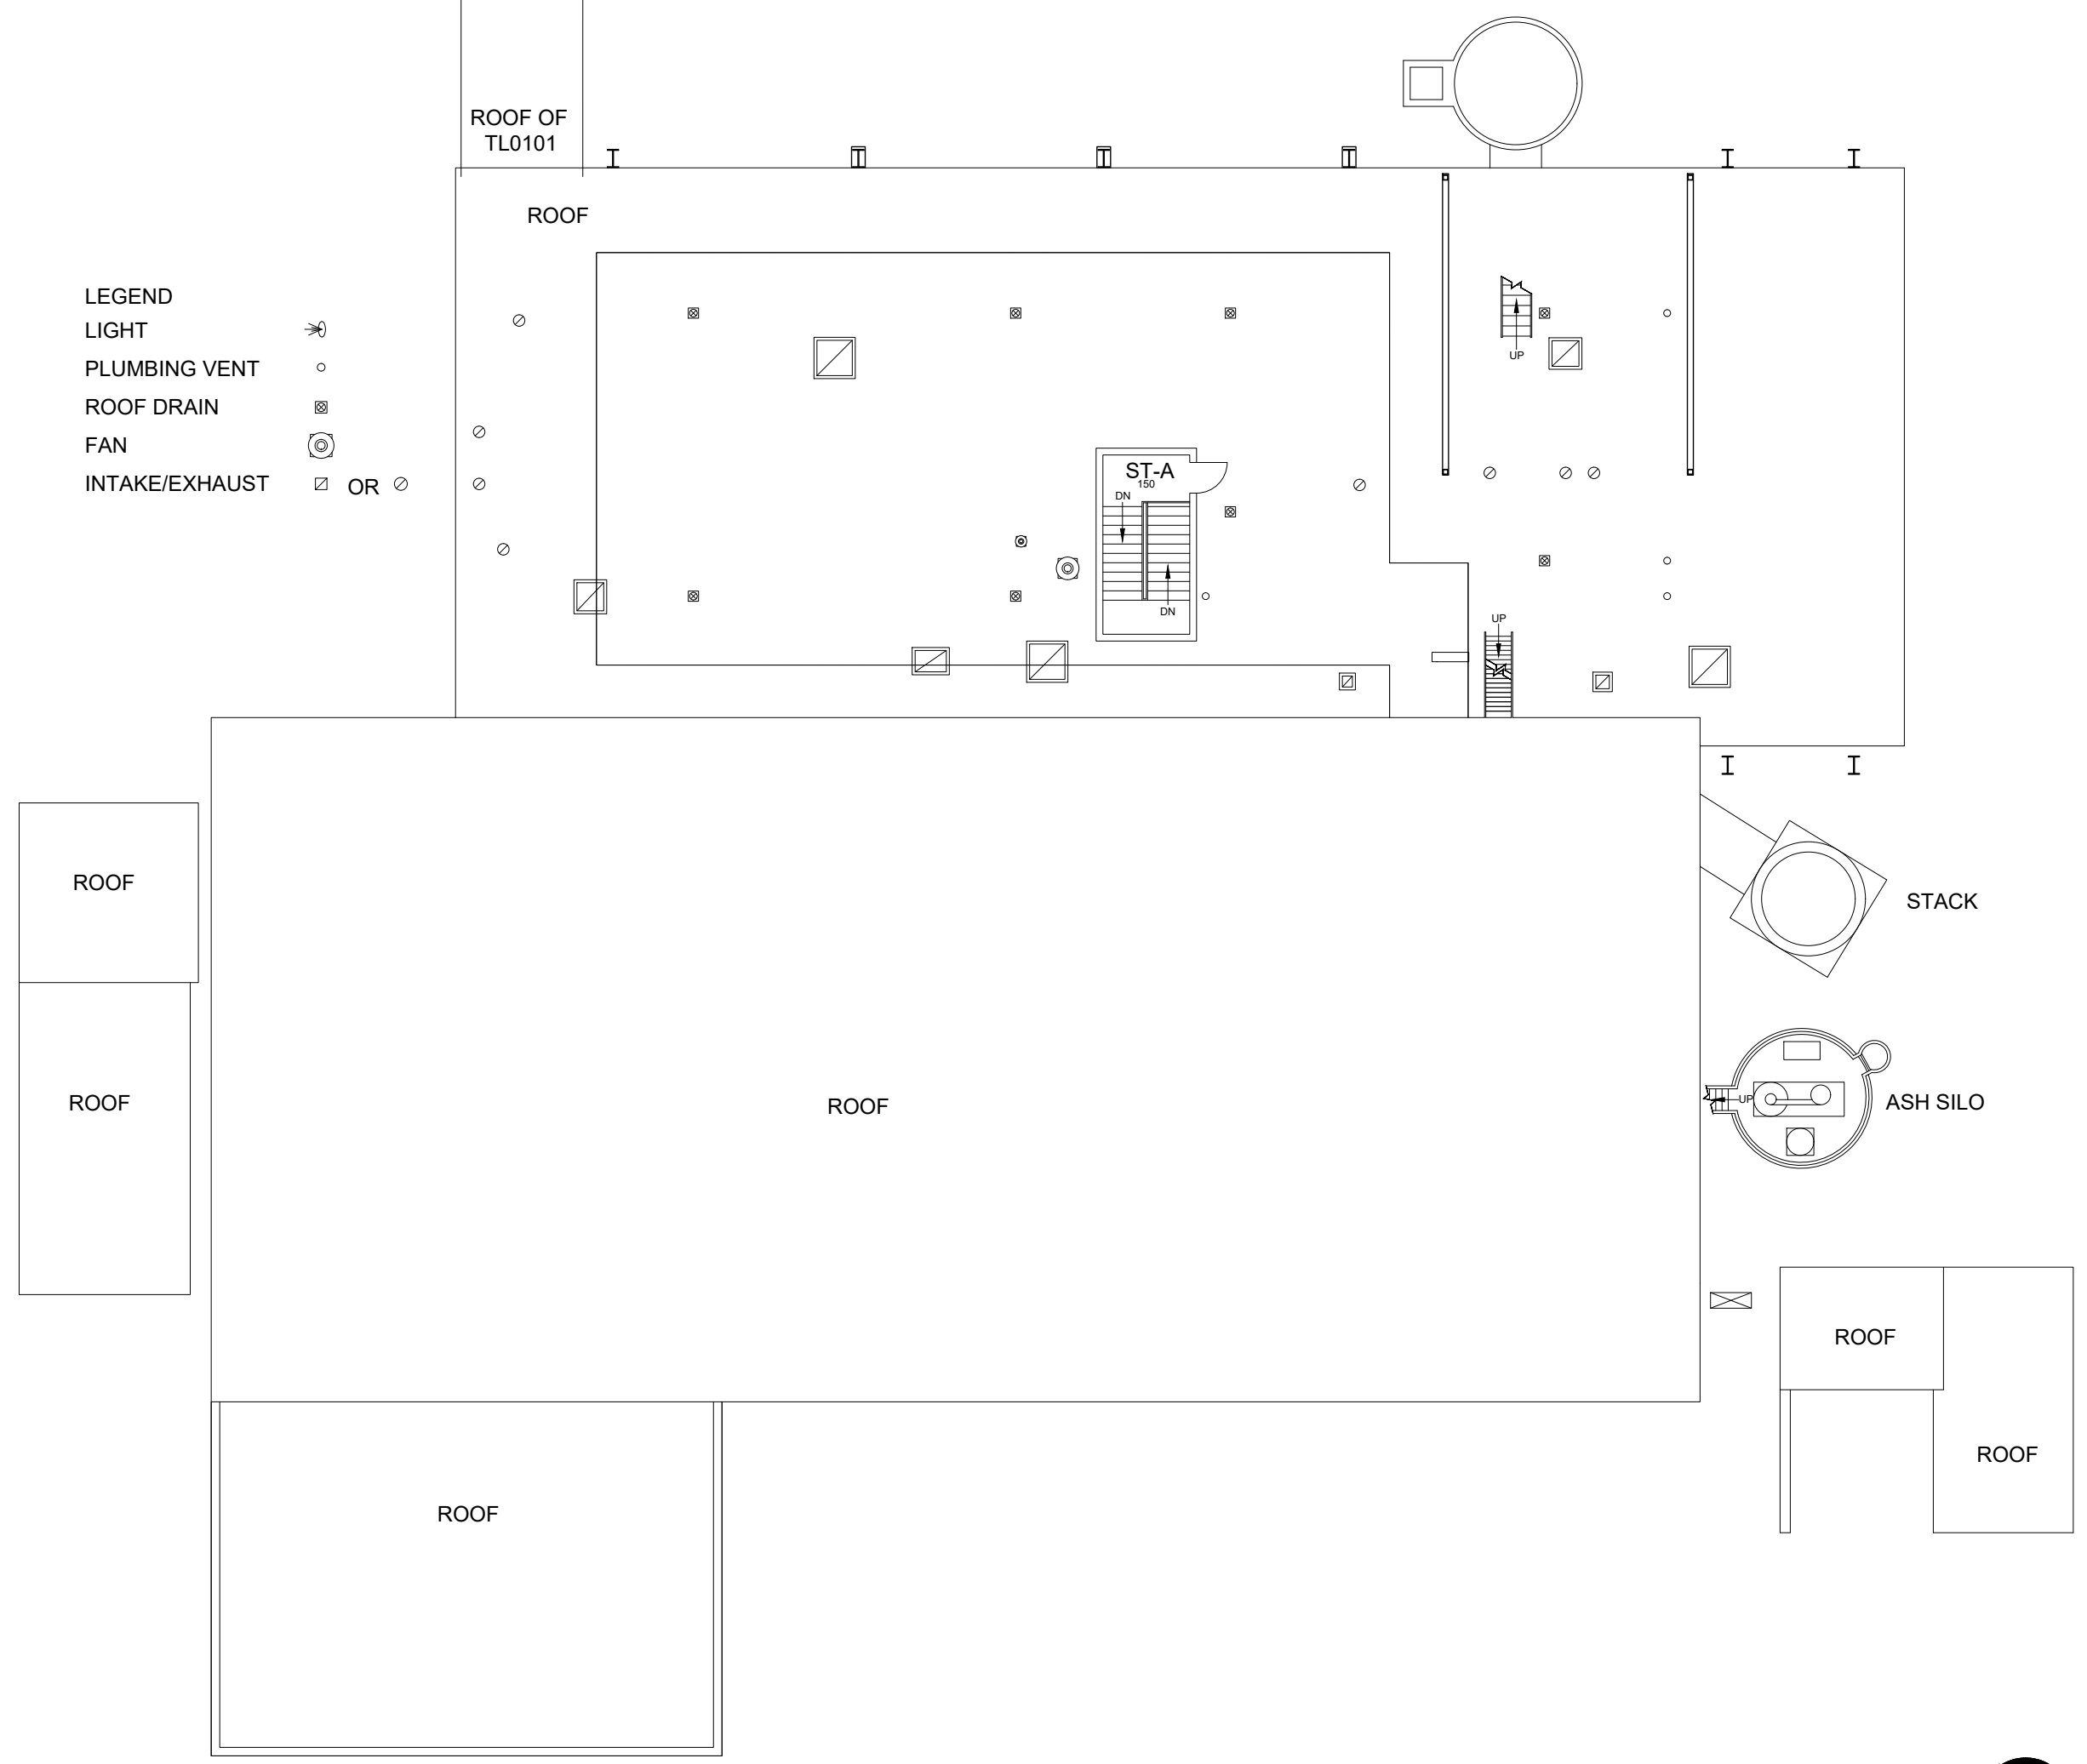

THIRD FLOOR PLAN
MEDICAL CENTER HEATING AND COOLING PLANT
185 Gross Square Ft.


3-14-16

ALK

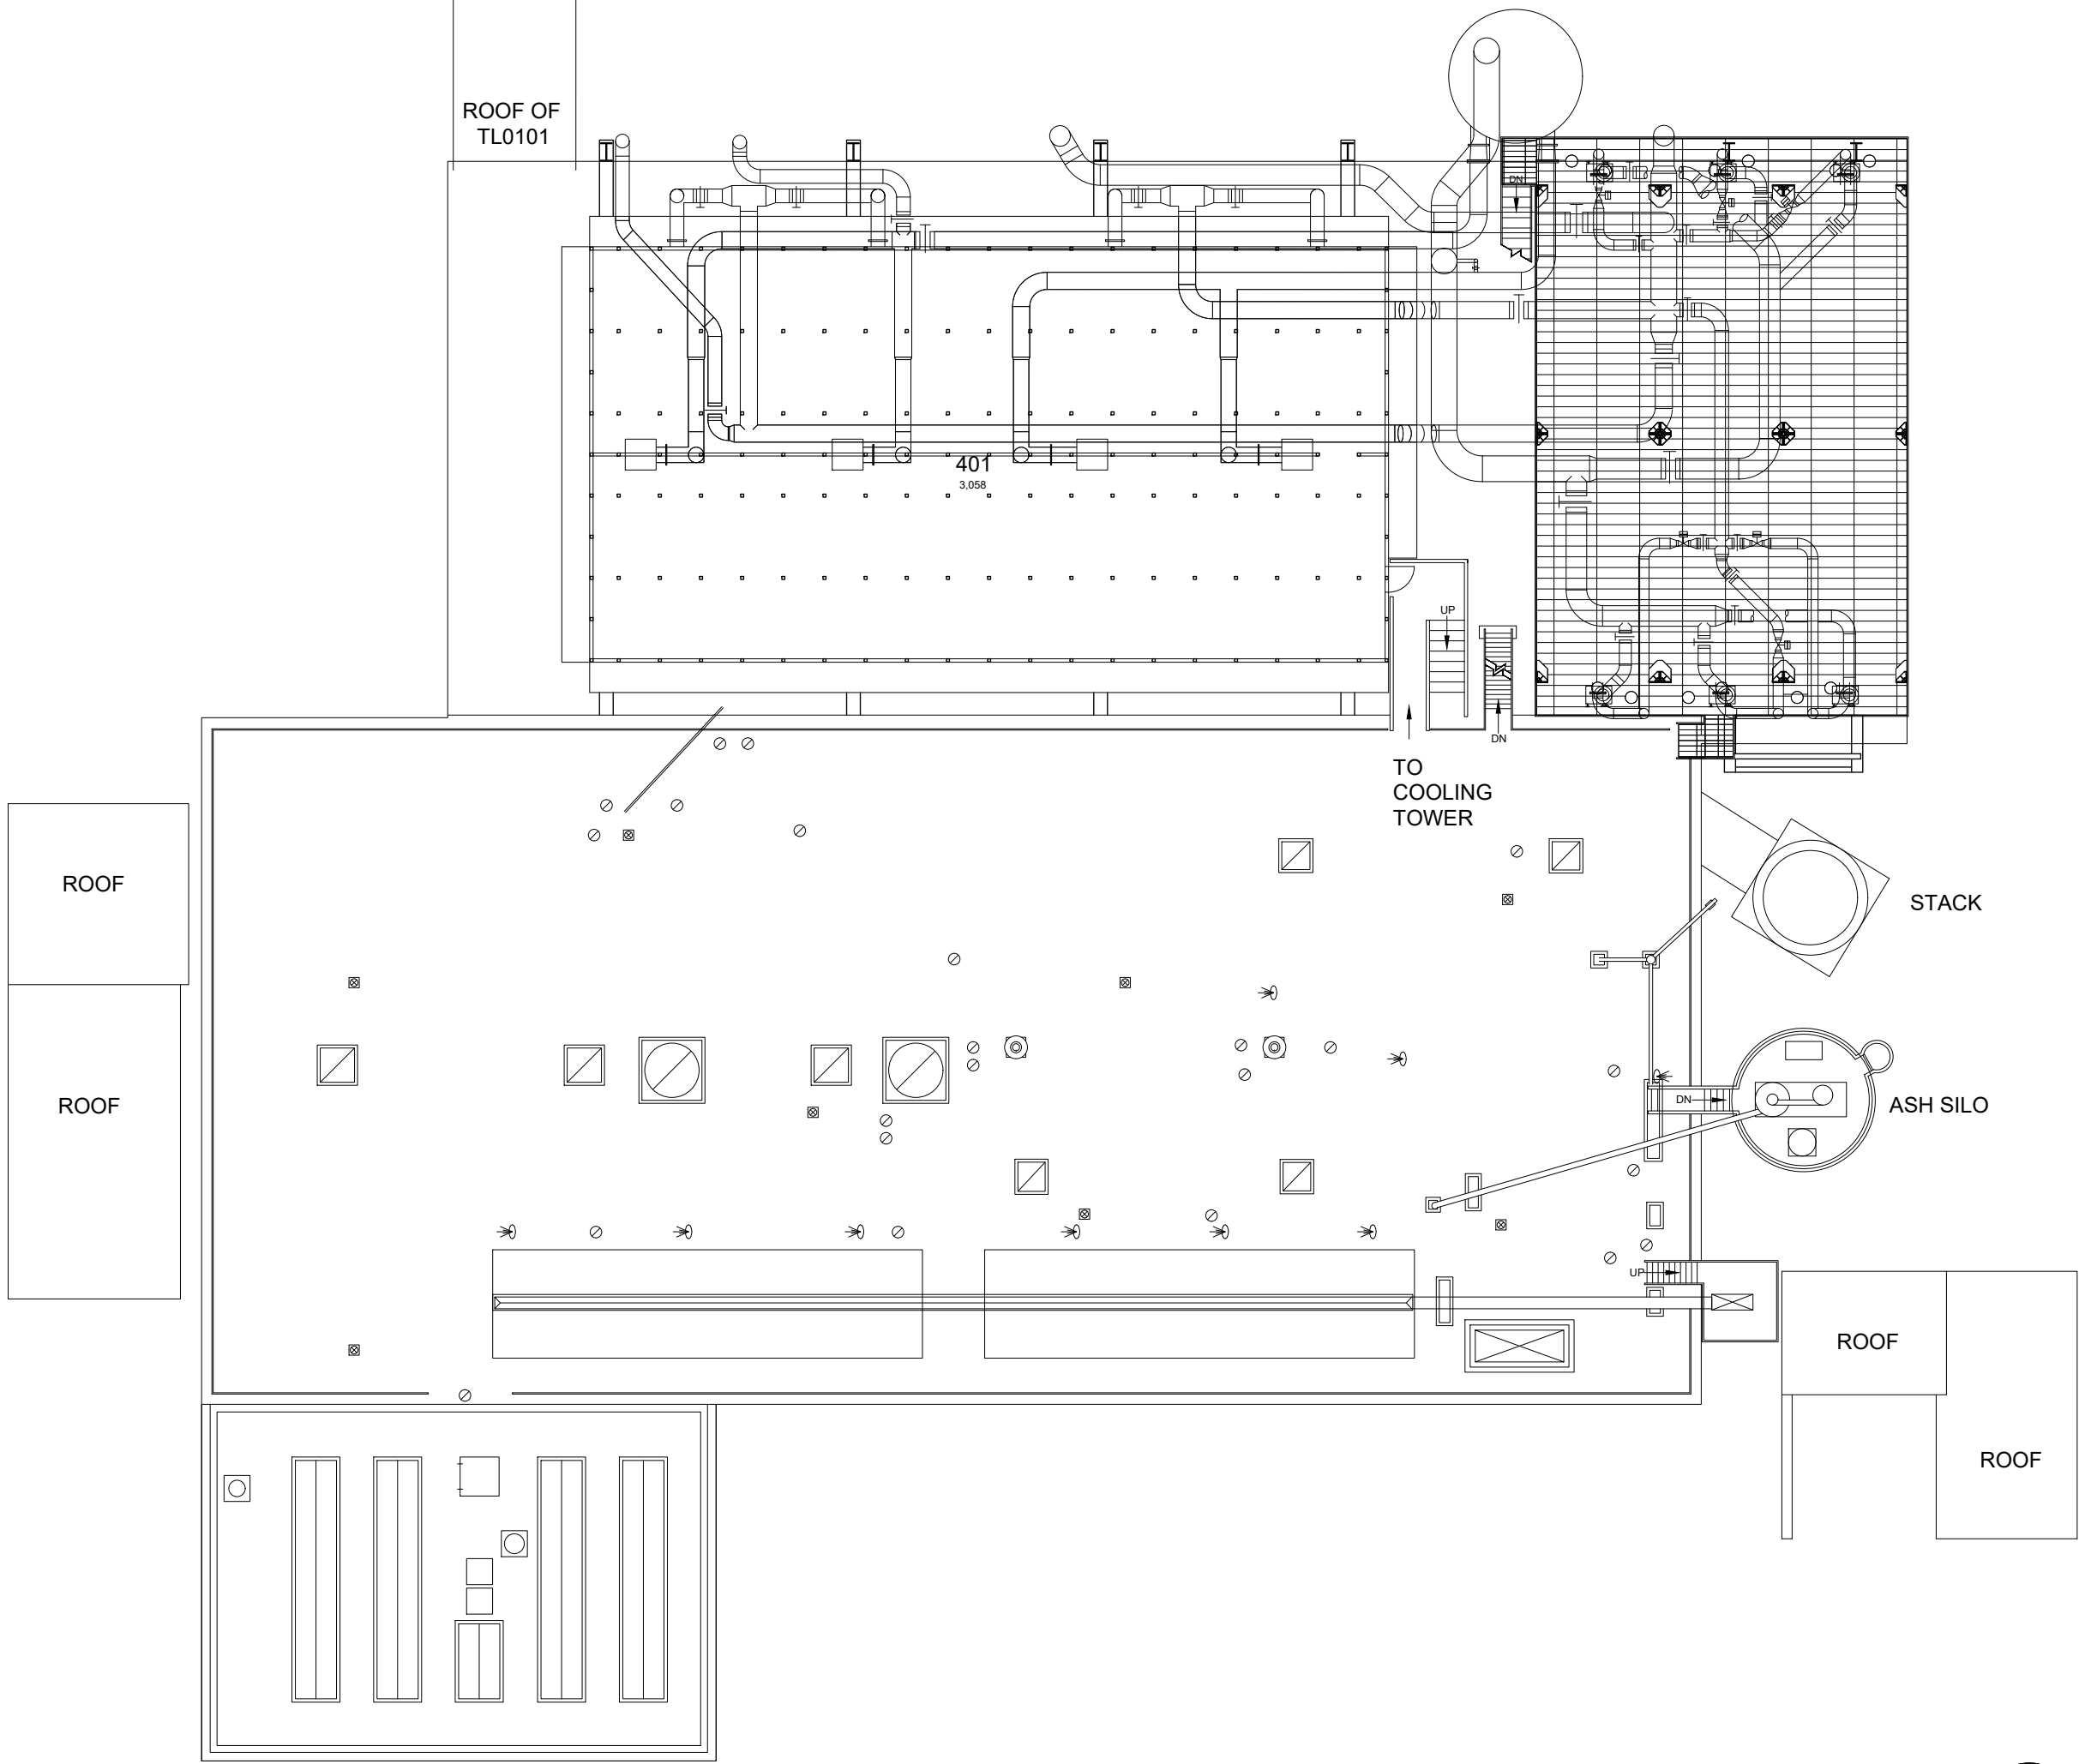

**FOURTH FLOOR PLAN
MEDICAL CENTER HEATING AND COOLING PLANT**

 3,058 Gross Square Ft




DATE:
11-14-05
DRAWN BY:
LHR

BLDG #:
0085

**MED. CTR. HEATING & COOLING PLANT
KEY DRAWING**

UNIVERSITY OF KENTUCKY
ITS Information Services

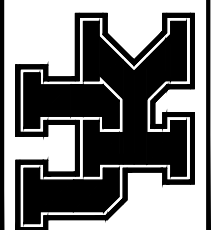

SHEET
5 of 6

3-14-16


ALK

DATE:
11-14-05
DRAWN BY:
LHR

BLDG #:
0085

MED. CTR. HEATING & COOLING PLANT
KEY DRAWING

UNIVERSITY OF KENTUCKY
ITS Information Services

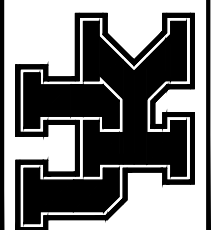

SHEET
6 of 6


ROOF DATA

Section	Roof Area Number	Location	Roof Type	Sq. Ft.
1	RF401	Main Building Upper Roof	BUR	9747
2	RF302	Main Building Lower Roof	BUR	7653
3	RF503	Fan Level North Platform	Metal	3136
4	RF504	Fan Level East Roof Platform	Metal	2109
5	RF405	Generator Roof	Pavers	1733
6	RF206	North Addition West Roof	BUR	512
7	RF207	Coal Chute Lower Roof	Metal	344
8	RF208	North Addition East Roof	BUR	304
9	RF309	Coal Chute Upper Roof	Metal	206

Data Source: CPPD

LEGEND

- LIGHT
- PLUMBING VENT
- ROOF DRAIN
- FAN
- INTAKE/EXHAUST
- ROOF HATCH
- SCUPPER &
- FLOW ARROW
- SECTION NUMBER

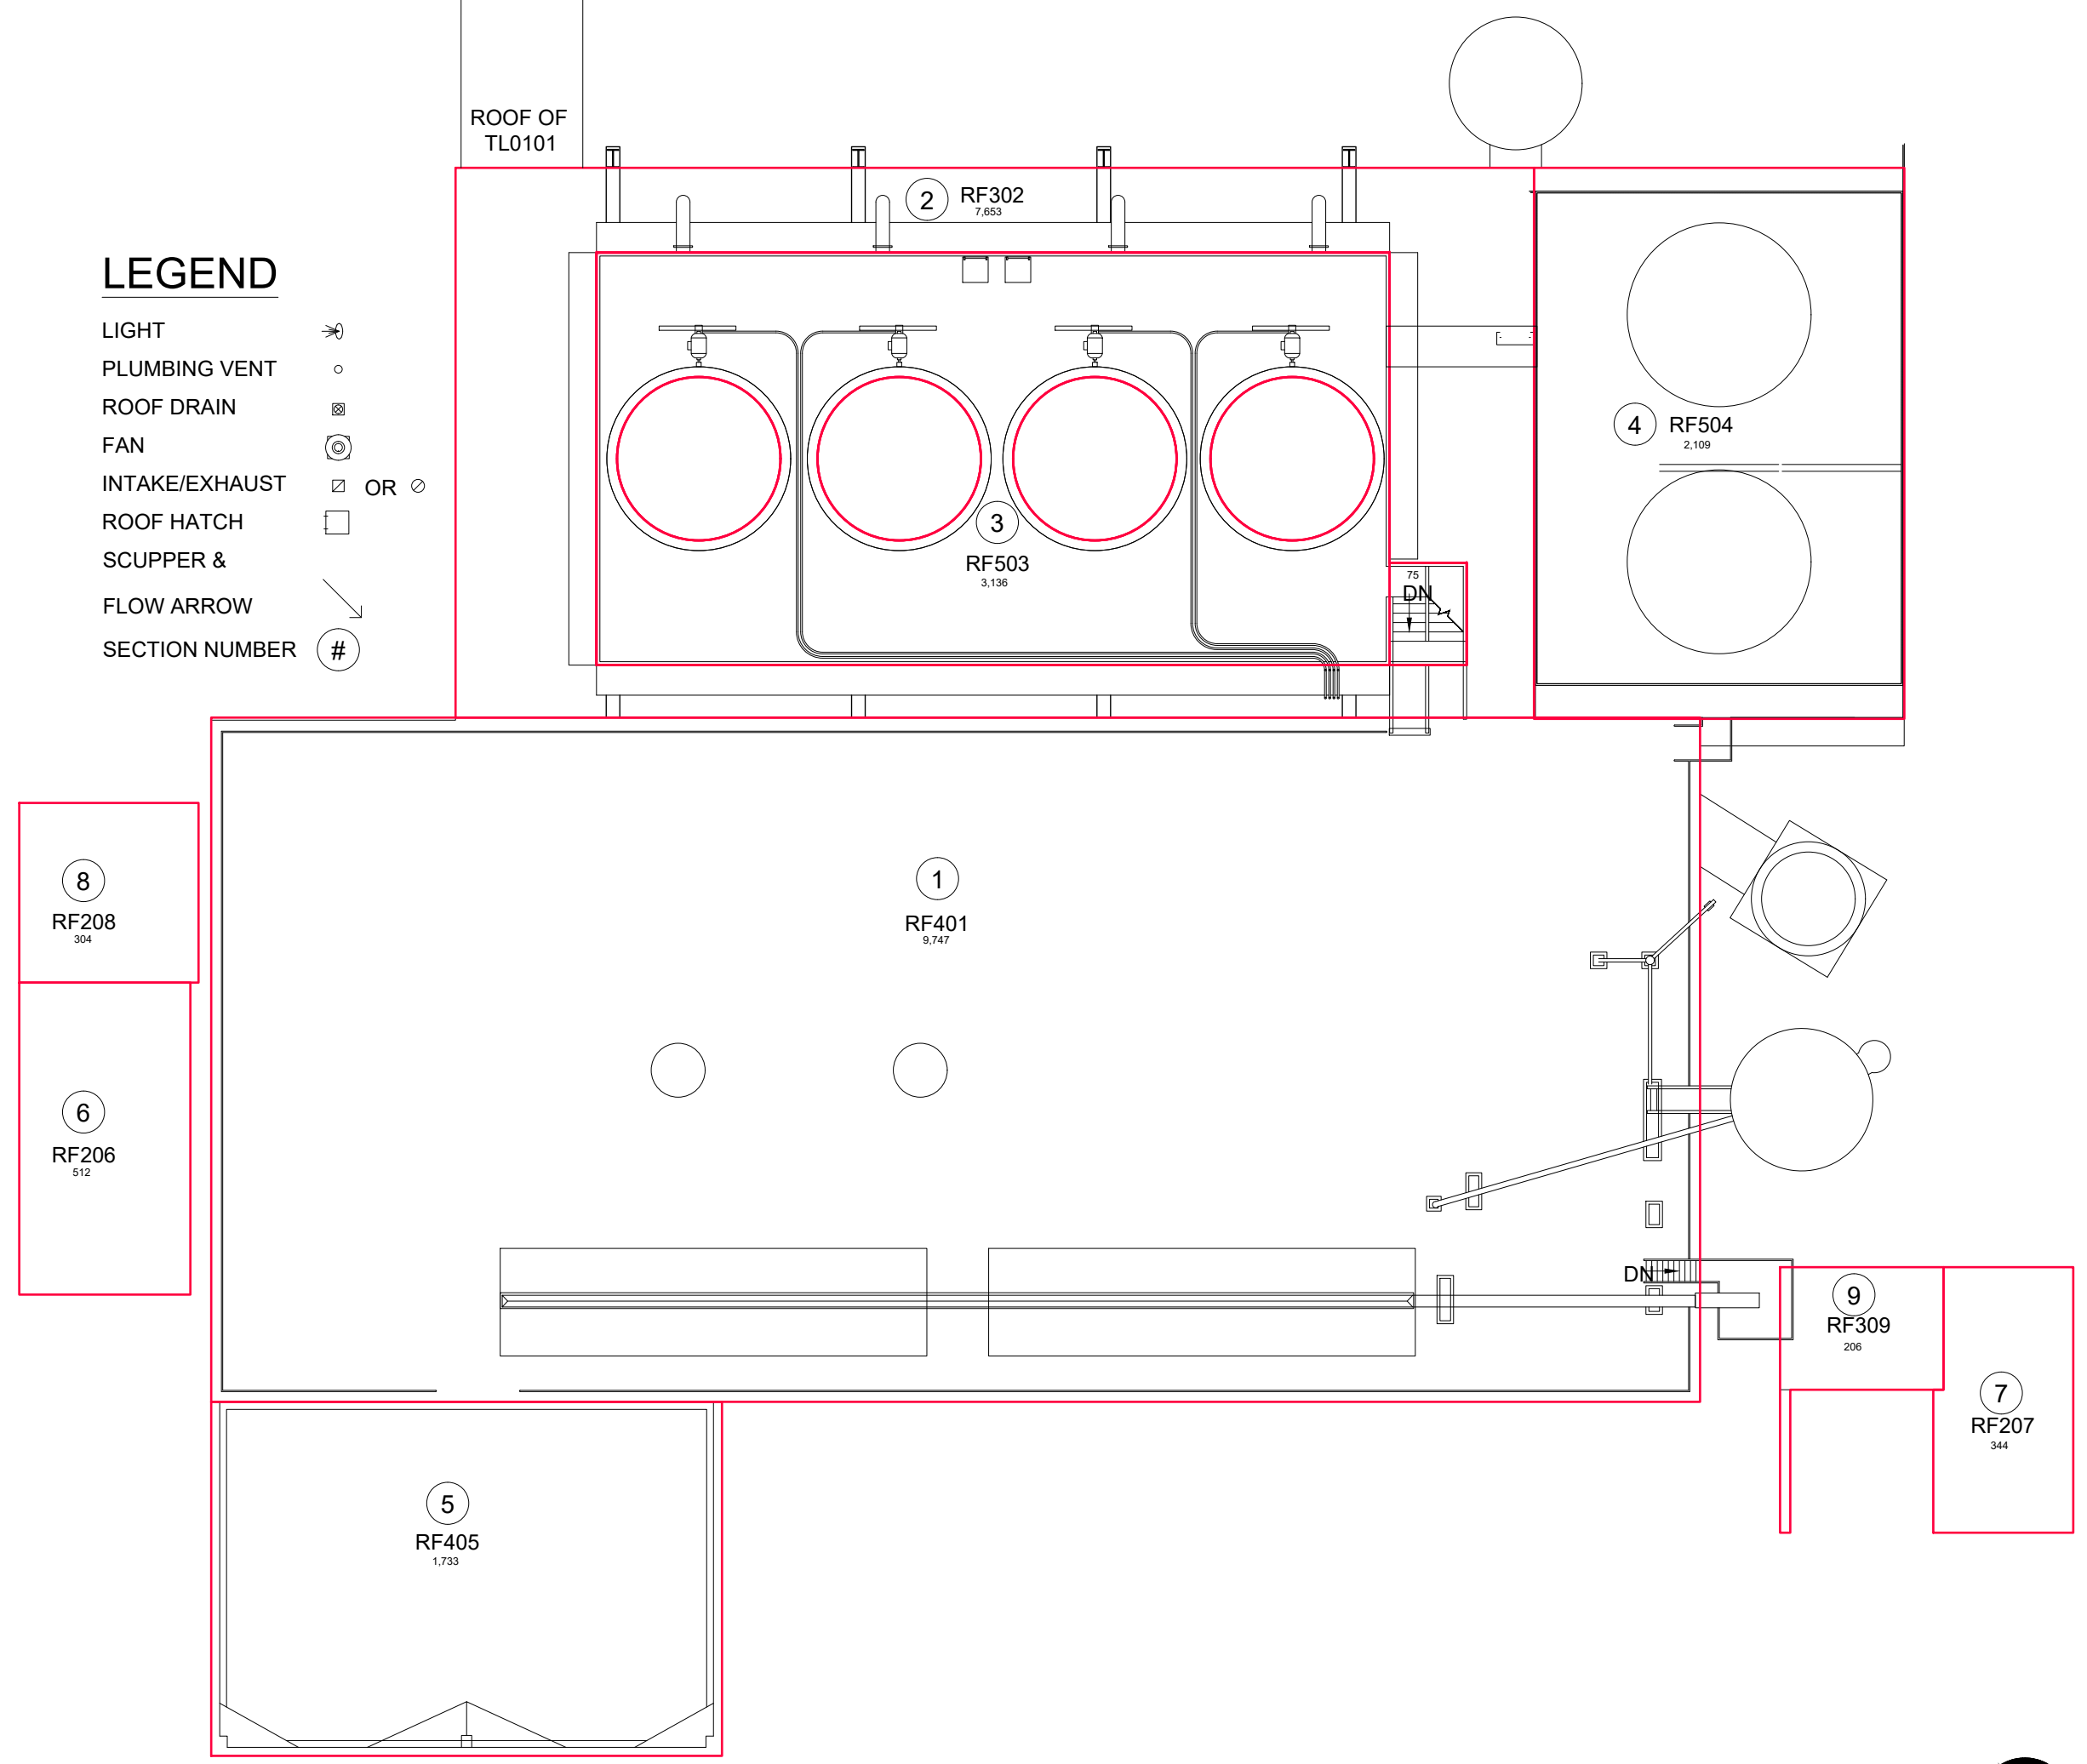

ROOF PLAN
MEDICAL CENTER HEATING AND COOLING PLANT

1/4/17

SHW