
 


06-25-2013  
MED

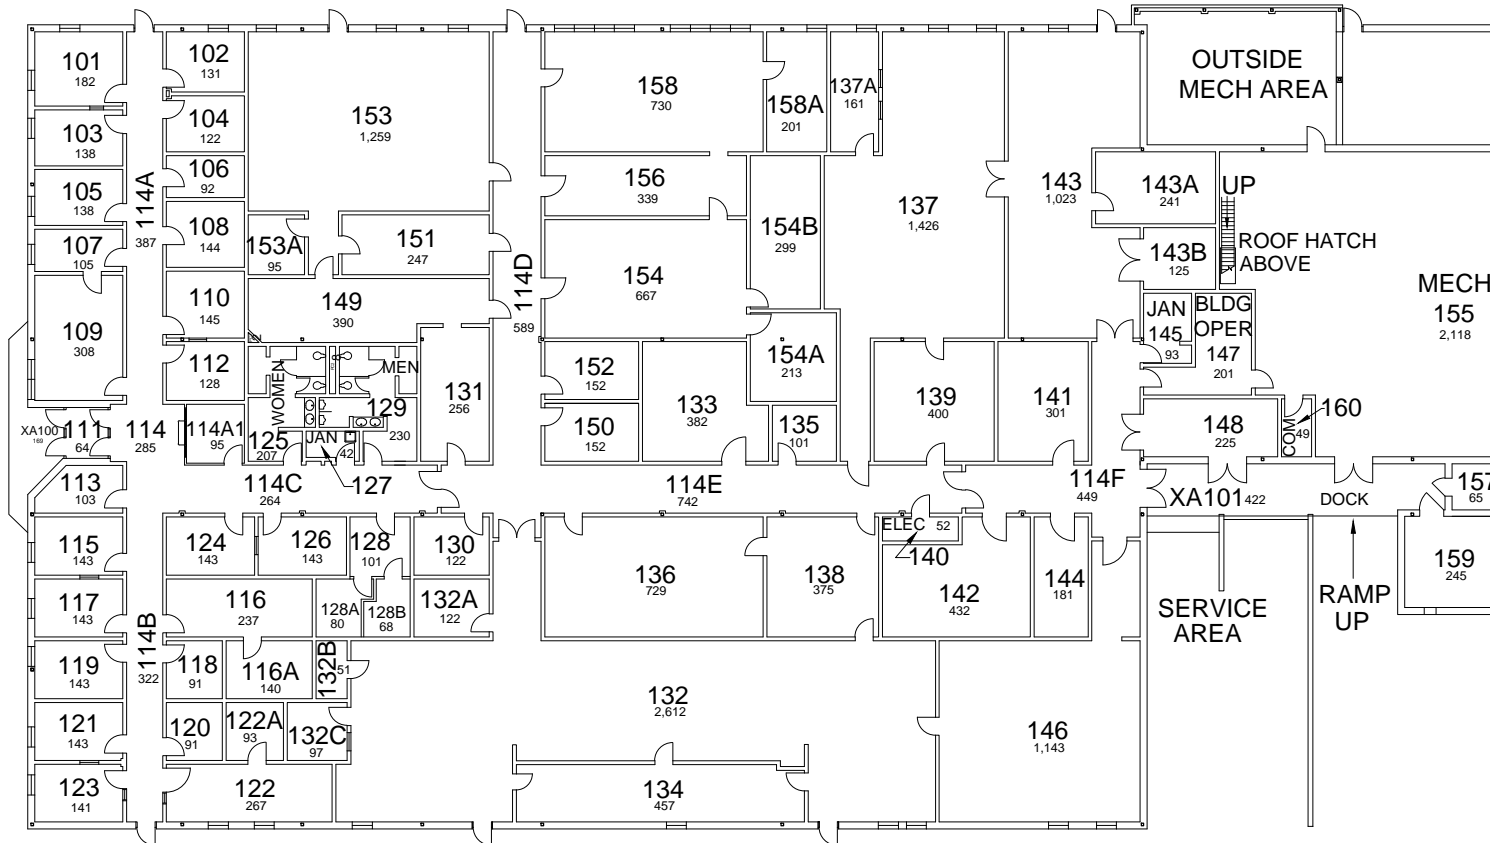

# FIRST FLOOR PLAN BRUCE POUNDSTONE REGULATORY SERVICES BUILDING

29,101 Gross Square Ft.




DATE:  
06-28-02  
DRAWN BY:  
JCM

BLDG #:  
0275  
**BRUCE POUNDSTONE REGULATORY SERVICES BUILDING**  
KEY DRAWING

UNIVERSITY OF KENTUCKY  
Physical Plant Division  
**UK**


SHEET  
1 OF 3

MED 06-25-2013

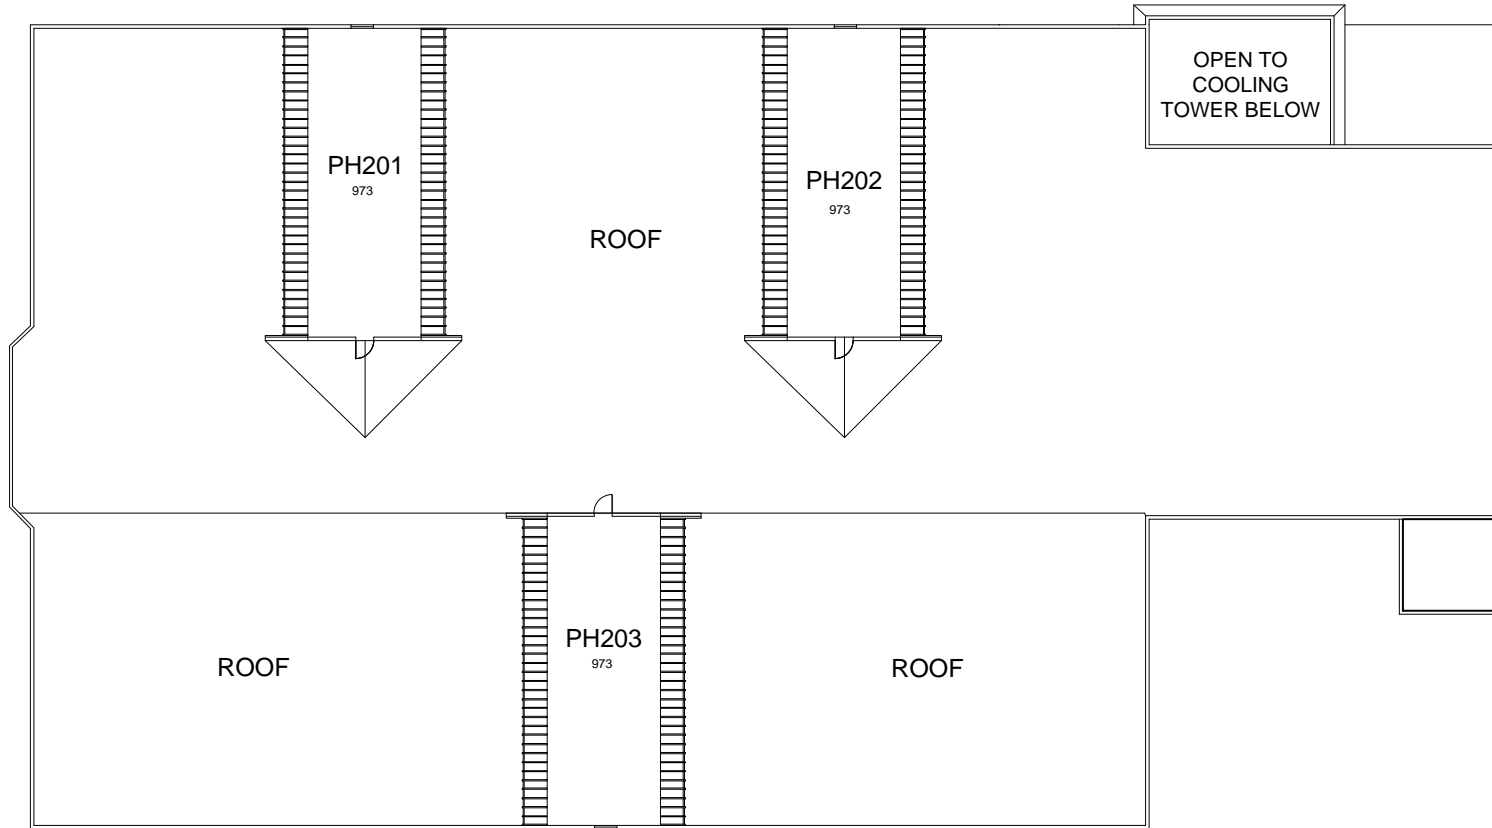

# PENTHOUSE PLAN BRUCE POUNDSTONE REGULATORY SERVICES BUILDING

 2,979 Gross Square Ft.



DATE:  
06-28-02  
DRAWN BY:  
JCM

BRUCE POUNDSTONE REGULATORY SERVICES BUILDING  
KEY DRAWING  
BLDG #:  
0275

UNIVERSITY OF KENTUCKY  
Physical Plant Division  
**UK**

SHEET  
2 OF 3


# LEGEND

- PLUMBING VENT
- ⊗ ROOF DRAIN
- ▧ ROOF HATCH
- WALK PADS
- ▩ SOLAR PANELS
- ↘ FLOW ARROW
- ① SECTION NUMBER


# ROOF DATA

Section	Roof Label	Location	Roof Type	Sq. Ft.
1	RF201	East Roof	Hypalon	16,405
2	RF202	North Roof	Hypalon	4,280
3	RF203	South Roof	Hypalon	4,000
4	RF304	West Penthouse	Standing seam steel	975
5	RF305	South Penthouse	Standing seam steel	975
6	RF306	North Penthouse	Standing seam steel	975
7	RF207	Solvent Storage Roof	Hypalon	285

Data source: CPPD Data

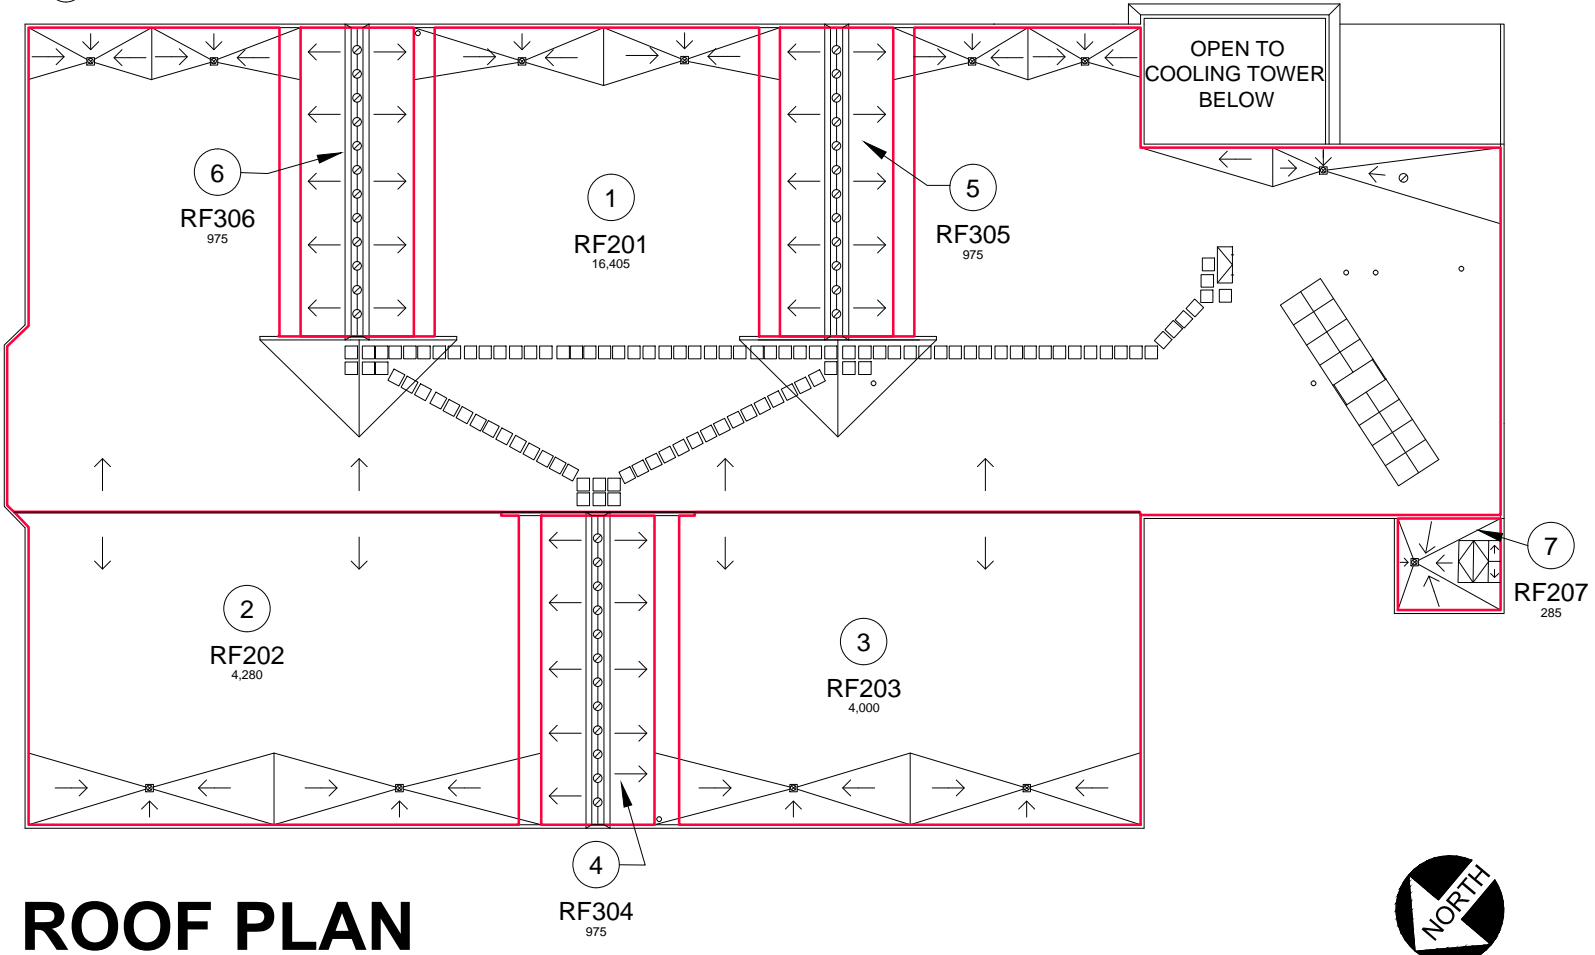

# ROOF PLAN BRUCE POUNDSTONE REGULATORY SERVICES BUILDING

 

DATE: 06-28-02  
DRAWN BY: JCM

BLDG #: 0275

BRUCE POUNDSTONE REGULATORY SERVICES BUILDING  
KEY DRAWING

UNIVERSITY OF KENTUCKY  
Physical Plant Division  
**UK**

SHEET 3 OF 3

12-03-2014

AJD